


FED. ROAD DIST. NO.	STATE	PROJECT NO.	COUNTY	CONTROL SECTION	STATE ROUTE	SHEET NO.	TOTAL SHEETS
7	NEVADA	1-015-1 (22)40	CLARK	03-083		120	130

REFERENCE SHEET NO K-2

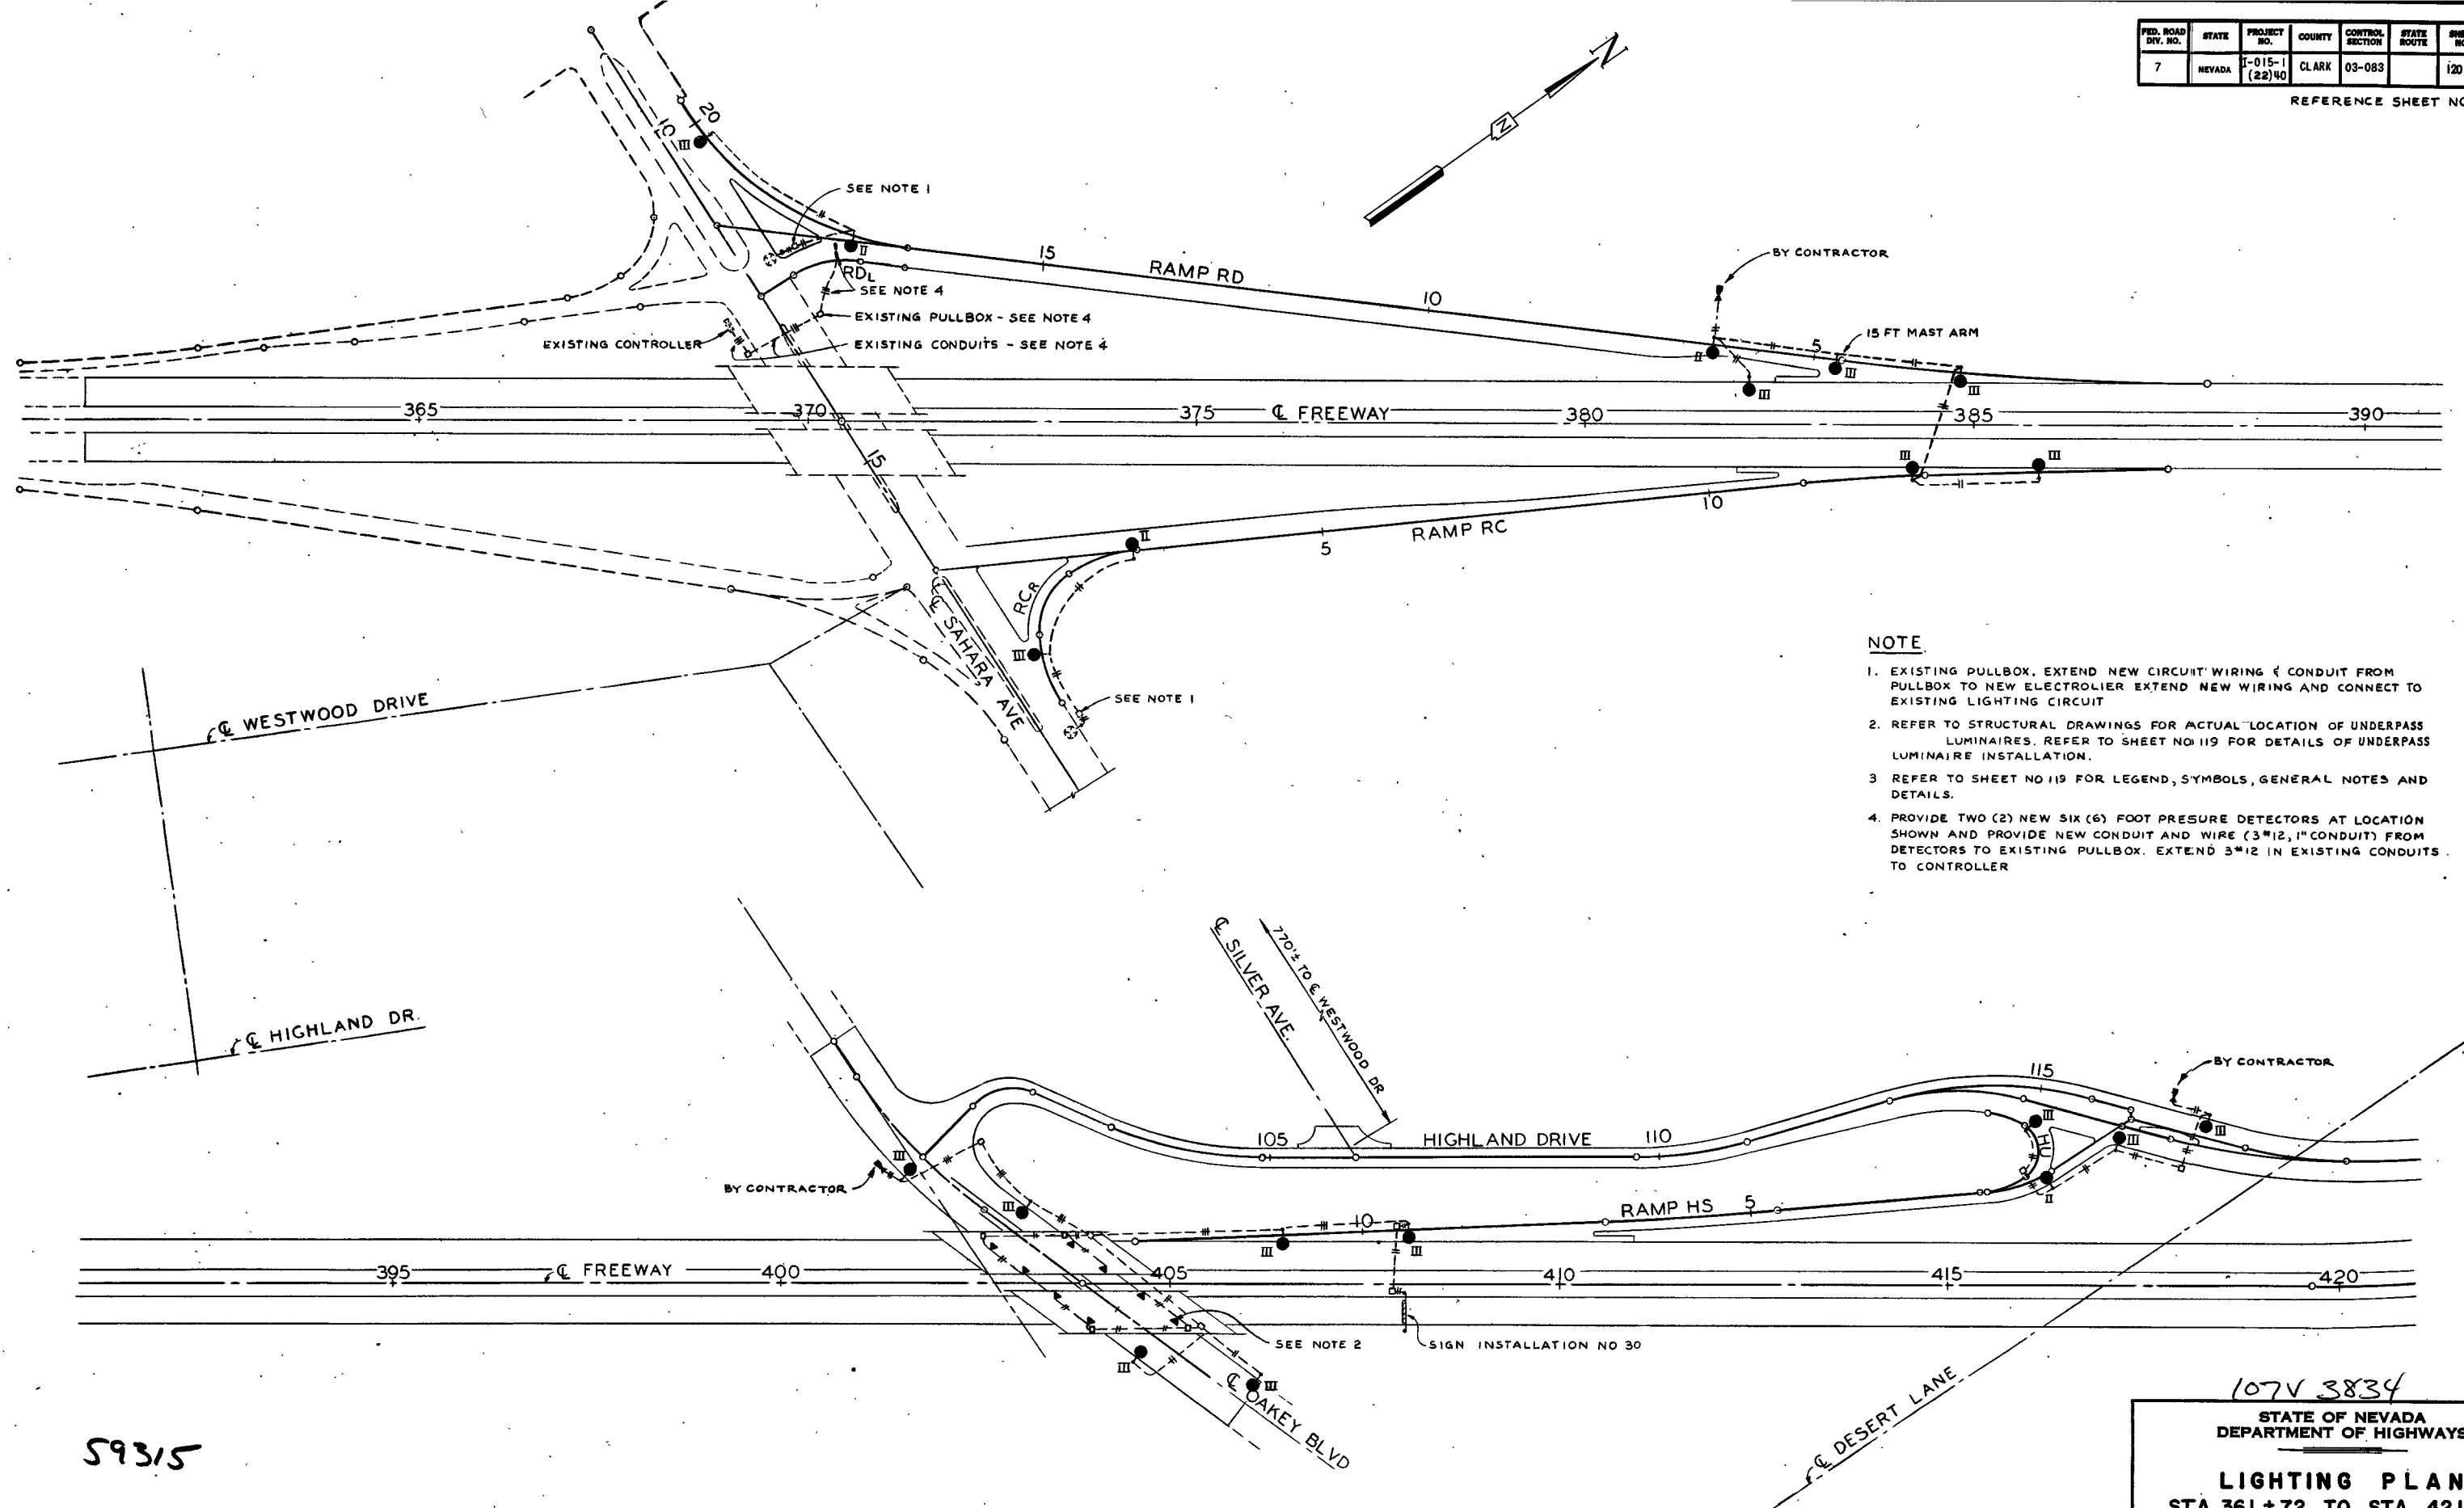

- NOTE
- EXISTING PULLBOX. EXTEND NEW CIRCUIT WIRING & CONDUIT FROM PULLBOX TO NEW ELECTROLIER. EXTEND NEW WIRING AND CONNECT TO EXISTING LIGHTING CIRCUIT.
 - REFER TO STRUCTURAL DRAWINGS FOR ACTUAL LOCATION OF UNDERPASS LUMINAIRES. REFER TO SHEET NO 119 FOR DETAILS OF UNDERPASS LUMINAIRE INSTALLATION.
 - REFER TO SHEET NO 119 FOR LEGEND, SYMBOLS, GENERAL NOTES AND DETAILS.
 - PROVIDE TWO (2) NEW SIX (6) FOOT PRESURE DETECTORS AT LOCATION SHOWN AND PROVIDE NEW CONDUIT AND WIRE (3*12, 1" CONDUIT) FROM DETECTORS TO EXISTING PULLBOX. EXTEND 3*12 IN EXISTING CONDUITS TO CONTROLLER.

59315

107V 3834
STATE OF NEVADA
DEPARTMENT OF HIGHWAYS 81
LIGHTING PLAN
STA. 361+72 TO STA. 421+00
LAS VEGAS FREEWAY
DE LEUW, CATHAR & COMPANY
SCALE: DESIGNED BY: T.N.