


FED. ROAD DIV. NO.	STATE	PROJECT NO.	COUNTY	CONTROL SECTION	STATE ROUTE	SHEET NO.	TOTAL SHEETS
7	NEVADA	015-1 (2840)	CLARK	03-083		121	130

REFERENCE SHEET NO K-3

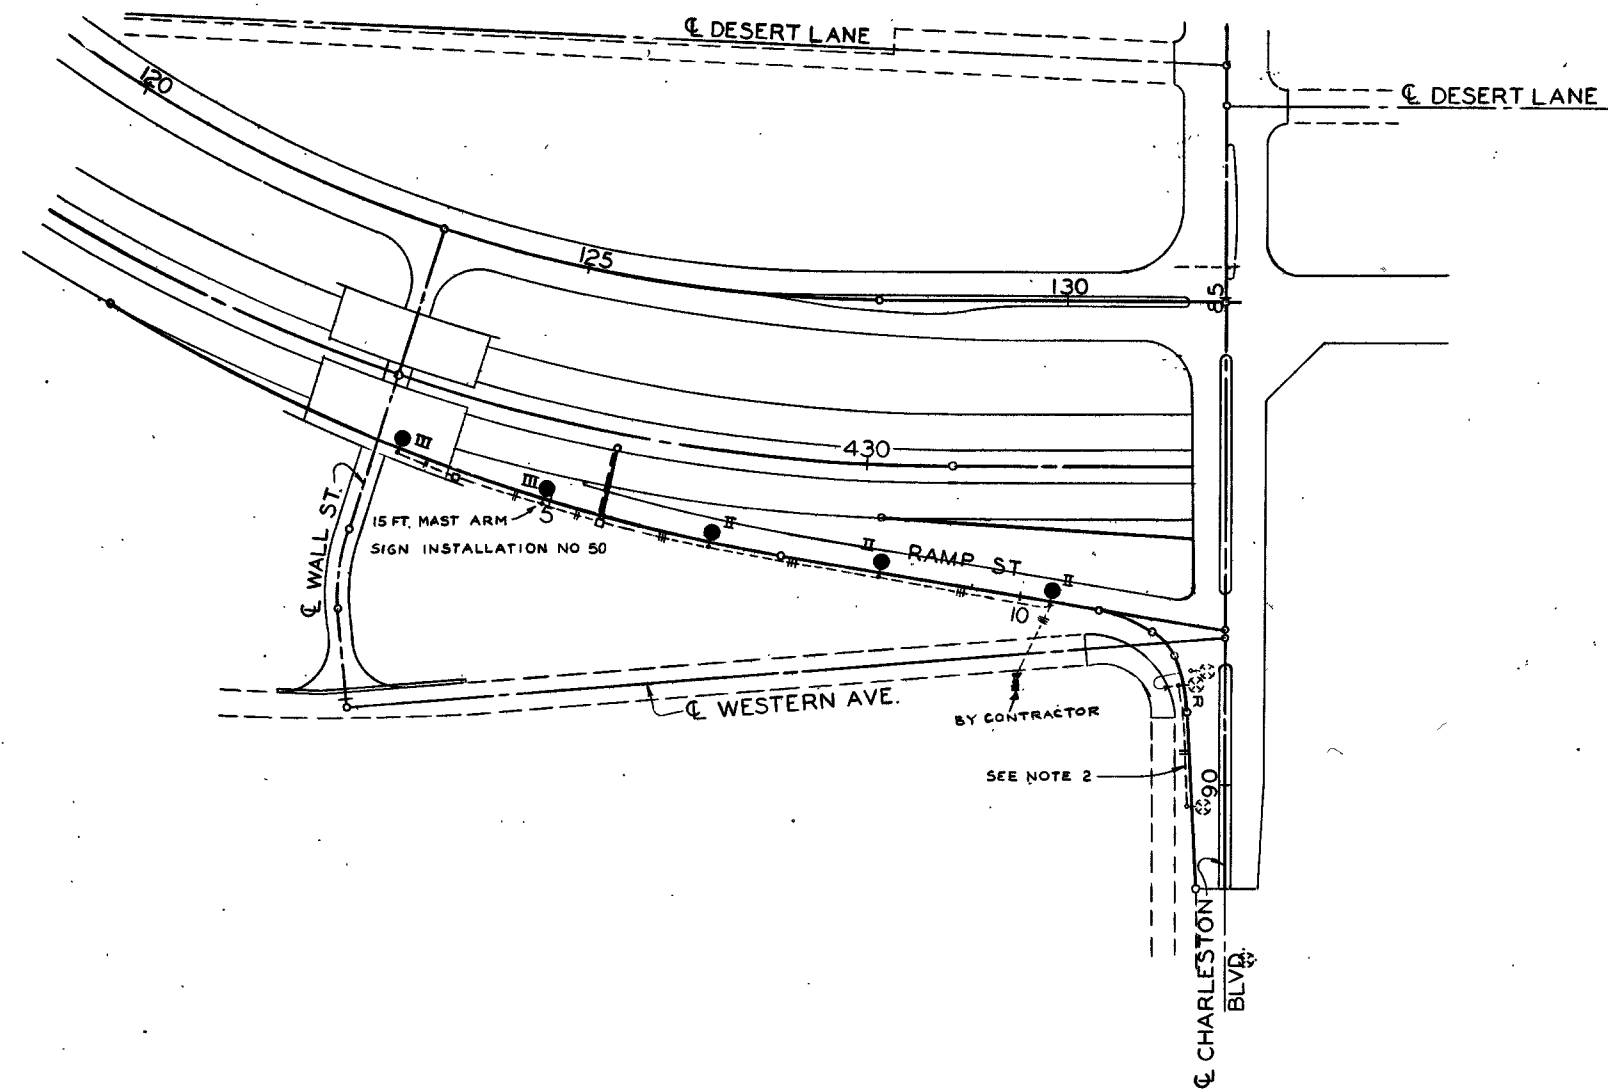

NOTE

1. STANDARD IS FOR TRAFFIC SIGNALS AND LIGHTING (TYPE III OR TYPE IV STANDARD) REFER TO SHEET NO. 122 FOR TRAFFIC SIGNALS.
2. EXTEND EXISTING STREET LIGHTING CIRCUITING TO RELOCATED ELECTROLIER.
3. REFER TO SHEET NO. 119 FOR LEGEND, SYMBOLS, GENERAL NOTES AND DETAILS.

59316

107V3834

STATE OF NEVADA
DEPARTMENT OF HIGHWAYS 82

LIGHTING PLAN
STA. 421+00 TO STA. 433+75±
LAS VEGAS FREEWAY

DE LEUW, CATHY & COMPANY ENGINEERS	SCALE DESIGNED BY T.N. DRAWN BY J.K.
---------------------------------------	--