


FED. ROAD DIV. NO.	STATE	PROJECT NO.	COUNTY	CONTROL SECTION	STATE ROUTE	SHEET NO.	TOTAL SHEETS
7	NEVADA	1-015-1 (22)40	CLARK	03-083		123	130


REFERENCE SHEET K-5

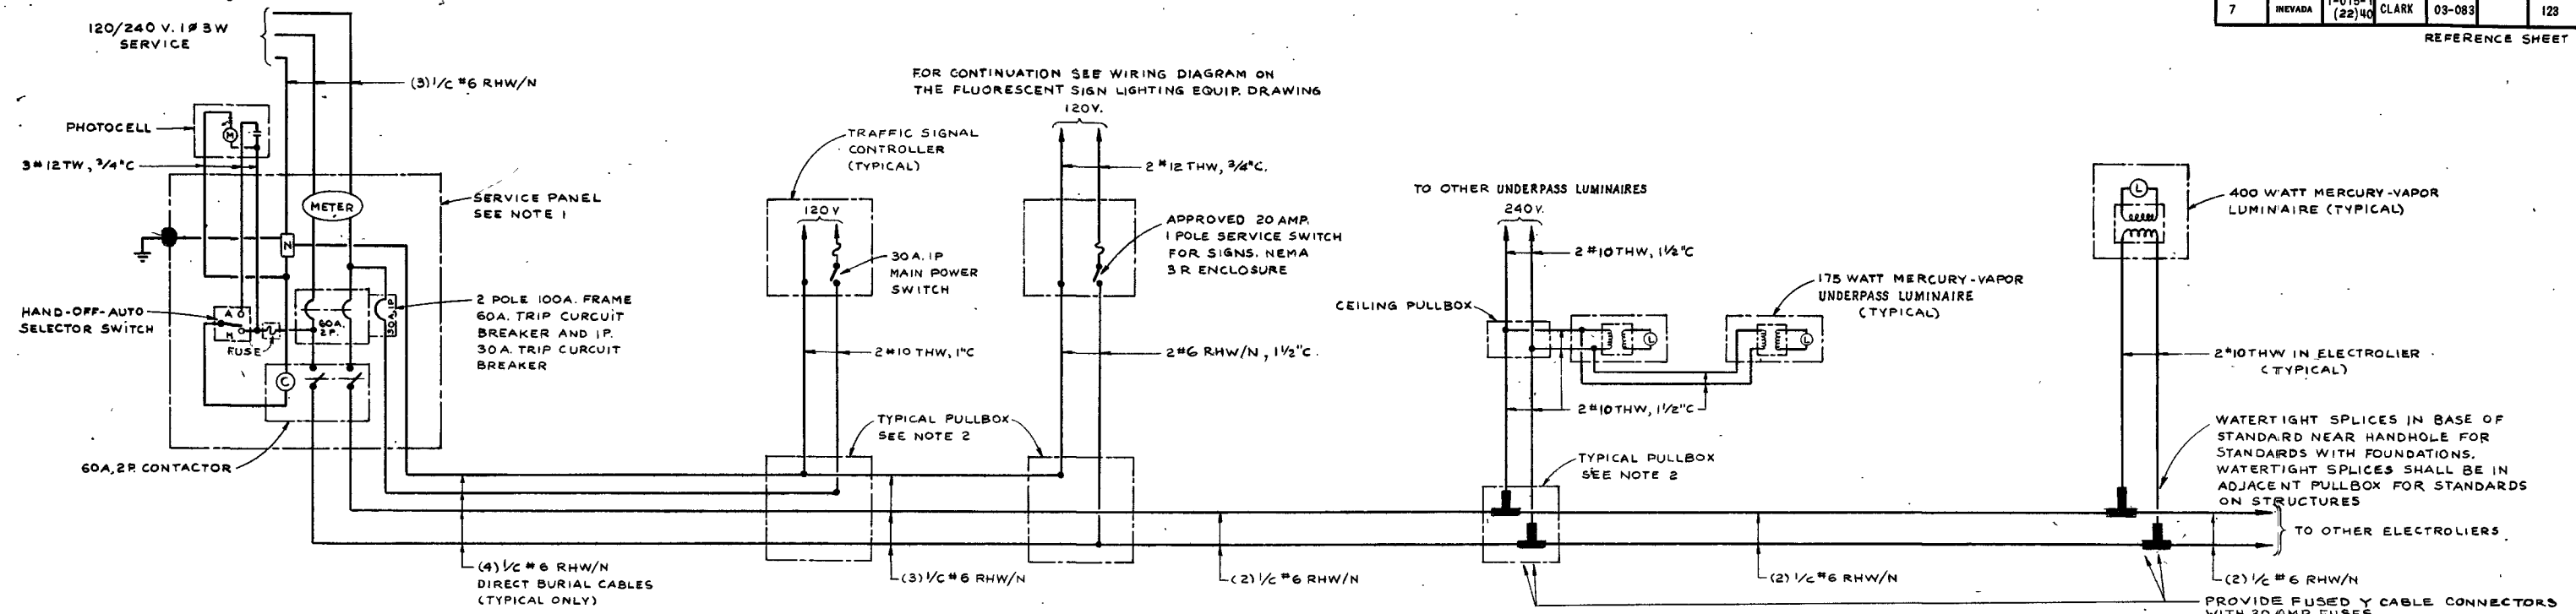

TYPICAL ELECTRICAL SERVICE AND SYSTEM WIRING DIAGRAM FOR LIGHTING AND TRAFFIC SIGNALS
NO SCALE


NOTE

1. REFER TO SPECIAL PROVISIONS FOR SERVICE PANEL.
2. ALL SPLICES IN PULLBOXES SHALL BE WATERTIGHT
3. REFER TO LAYOUT PLANS FOR LOCATIONS WHERE CONDUIT IS REQUIRED FOR DIRECT BURIAL CABLES.

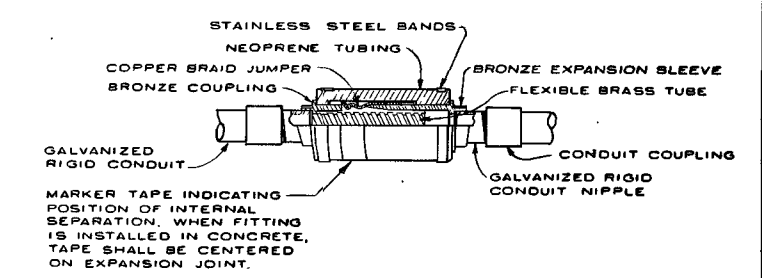

NOTE:
THIS FITTING SHALL PROVIDE FOR MOVEMENT OF 3/4\"/>

CONDUIT EXPANSION & DEFLECTION FITTING
NO SCALE

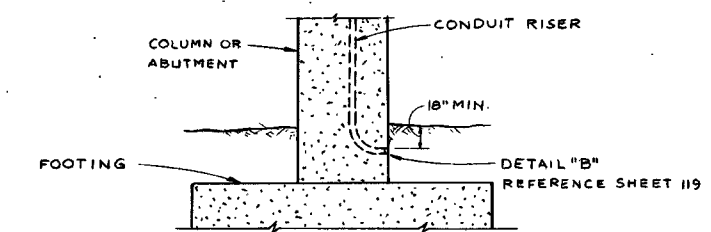

CONDUIT RISER AT COLUMN OR ABUTMENT
NO SCALE

59318

107V3834

STATE OF NEVADA
DEPARTMENT OF HIGHWAYS 84

ELECTRICAL DETAILS

LAS VEGAS FREEWAY

DE LEUW, CATHAR & COMPANY
ENGINEERS

SCALE AS SHOWN
DESIGNED BY T.N.
DRAWN BY I.K.