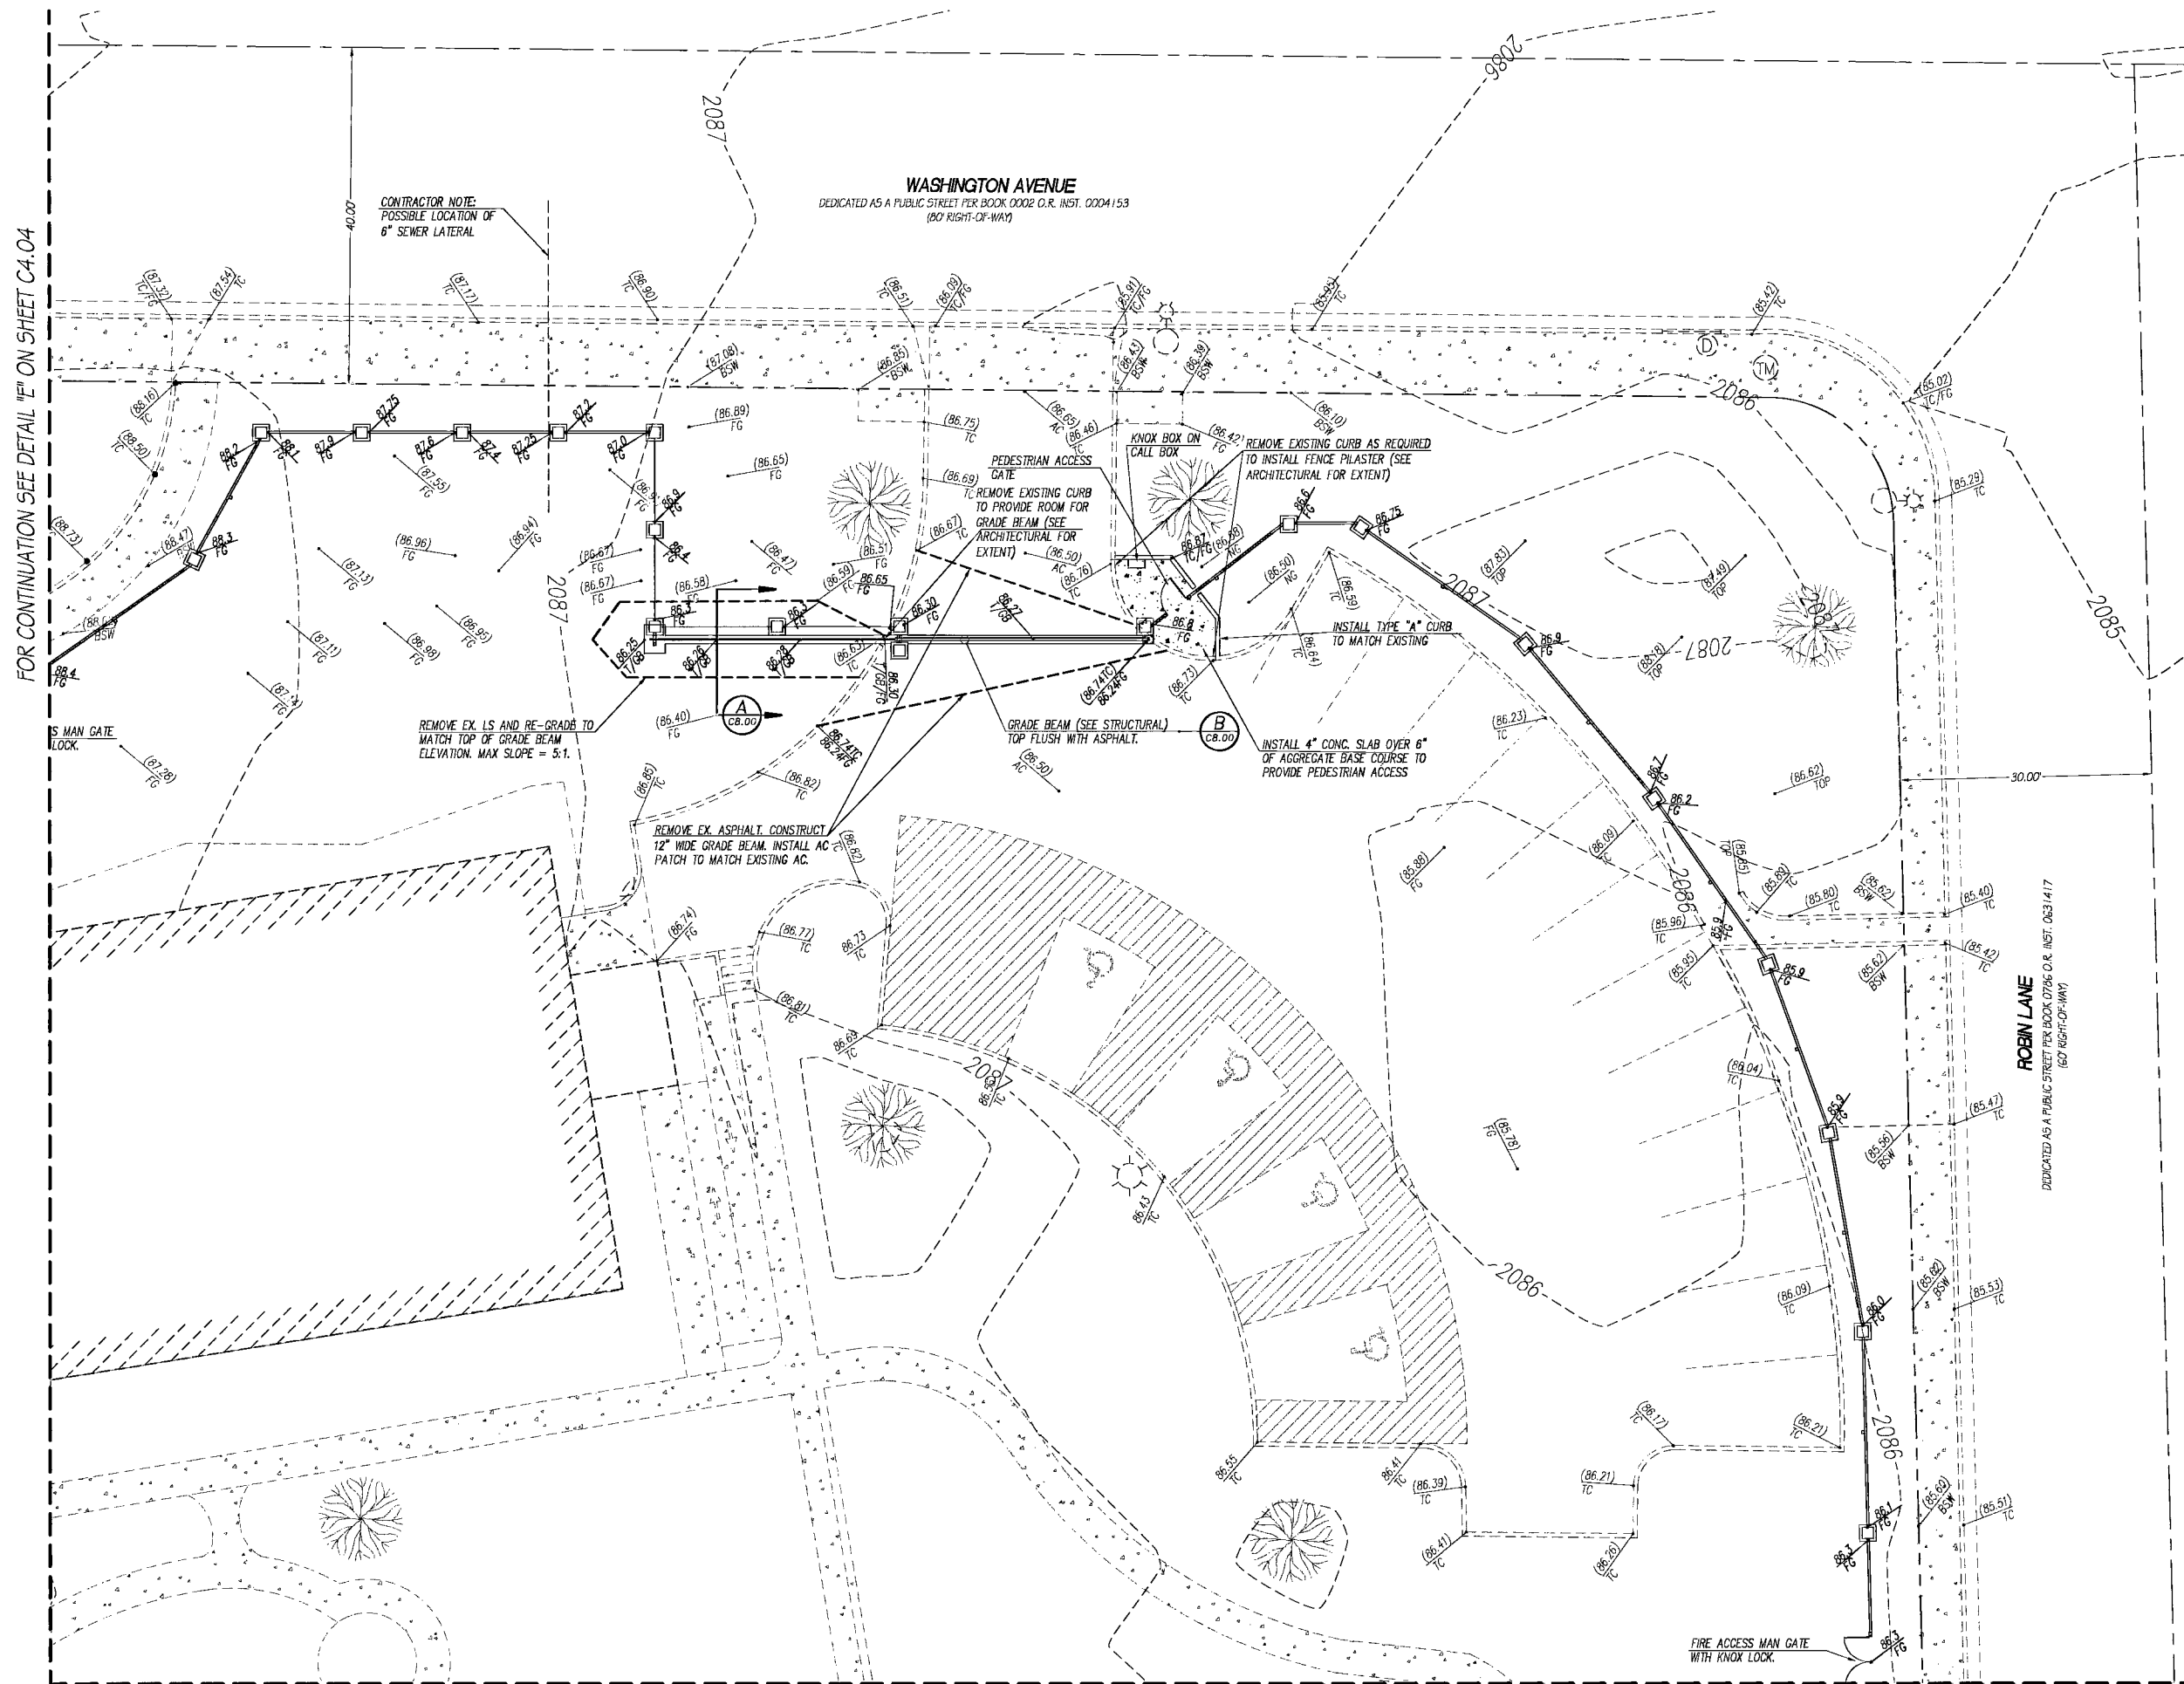


LEGEND
SEE SHEET 4.00 FOR LEGEND

NOTE TO CONTRACTOR

CONTRACTOR SHALL REVIEW THE EXTERIOR SPRINKLING PLAN SHEETS (L-6 THROUGH L-9 INCLUSIVE) WHICH WERE PREPARED FOR THE HARRY LEVY GARDENS PROJECT IN 1986. THE PLANS WERE PREPARED BY WALTER F. ZICK AND HARRIS P. SHARP, ARCHITECTS-ENGINEERS, INC. IT IS THE CONTRACTOR'S RESPONSIBILITY TO LOCATE AND ISOLATE OR REMOVE THE IRRIGATION SYSTEM IN THE AREAS OF NEW CONSTRUCTION AS NECESSARY. REPLACEMENT OF THE IRRIGATION SYSTEM AND LANDSCAPING AFTER THE FENCE IS CONSTRUCTED IS PART OF THIS CONTRACT.

NOTE TO CONTRACTOR

IT IS THE INTENT THAT THE MAXIMUM DIFFERENTIAL BETWEEN THE BOTTOM OF THE FENCE PICKETS AND THE FINAL FINISH GRADE SHALL BE 4 (FOUR) INCHES. MINOR GRADING IN THE VICINITY OF THE FENCE MAY BE REQUIRED IN ORDER TO ACHIEVE THIS INTENT.

DETAILED GRADING PLAN (NORTHEAST DRIVEWAY ON WASHINGTON AVENUE)


SCALE: 1" = 10'

FOR CONTINUATION SEE DETAIL "C" ON SHEET C4.02

HORIZON ENGINEERING ASSUMES NO RESPONSIBILITY FOR EXISTING UTILITY LOCATIONS AND ELEVATIONS. THE UTILITIES SHOWN ON THIS DRAWING HAVE BEEN PLOTTED FROM THE BEST AVAILABLE INFORMATION. IT IS, HOWEVER, THE CONTRACTOR'S RESPONSIBILITY TO FIELD VERIFY THE LOCATION AND ELEVATION OF ALL UTILITIES PRIOR TO THE COMMENCEMENT OF ANY CONSTRUCTION. CONTRACTOR TO FIELD VERIFY ALL EXISTING SITE CONDITIONS PRIOR TO CONSTRUCTION. IF A CONFLICT EXISTS BETWEEN WHAT IS SHOWN ON THESE DRAWINGS AND WHAT EXISTS IN THE FIELD, THE CONTRACTOR IS TO NOTIFY THE ARCHITECT OR ENGINEER IMMEDIATELY.

GENERAL NOTE:

IT IS THE CONTRACTOR'S RESPONSIBILITY TO FILE A NOTICE OF INTENT/REQUEST TO BE INCLUDED IN THE STORM WATER GENERAL PERMIT, AND SUBMIT THE ASSOCIATED STORMWATER POLLUTION PREVENTION PLAN (SWPPP) AS REQUIRED BY FEDERAL LAW, AND MONITORED BY THE NEVADA DIVISION OF ENVIRONMENTAL PROTECTION.

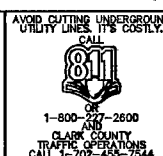

NOTE:

FOR ALL REQUIRED ELECTRICAL TRENCHING FOR GATE CONTROLS, REFER TO THE ELECTRICAL SITE PLAN.


HARRY LEVY GARDENS
2525 W. WASHINGTON AVE

DETAILED GRADING SHEET 3

CITY OF LAS VEGAS

HORIZON ENGINEERING

9901 COVINGTON CROSS DRIVE,
SUITE 120
LAS VEGAS, NEVADA 89144
PHONE (702) 228-5066
FAX (702) 228-0677
WWW.HORIZONSURVEYS.COM

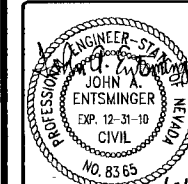

JOB NO: E482.001
DATE: 10/19/09

C4.03

SHEET 8 OF 10

107V3950-F