



CIVIL ENGINEERING DIVISION
CLARK COUNTY DEVELOPMENT SERVICES
ACCEPTED

AND WITH UNDERGROUND
TRAFFIC SIGNAL SYSTEMS
AND STREET LIGHT SYSTEMS
ON SLOTT

CALL BEFORE
YOU DO
UNDERGROUND



 Ca. before you
UnderGround
1-702-455-751
CLARK COUNTY TRAFFIC OPERATORS
1-702-229-661
LAS VEGAS AREA COMPUTERIZED TRAFFIC SYSTEMS

TRAFFIC

REVISED
ISSUED FOR
CONSTRUCTION
05/10/04

**Call
before you
Dig**

Call
before you
OVERHEAD

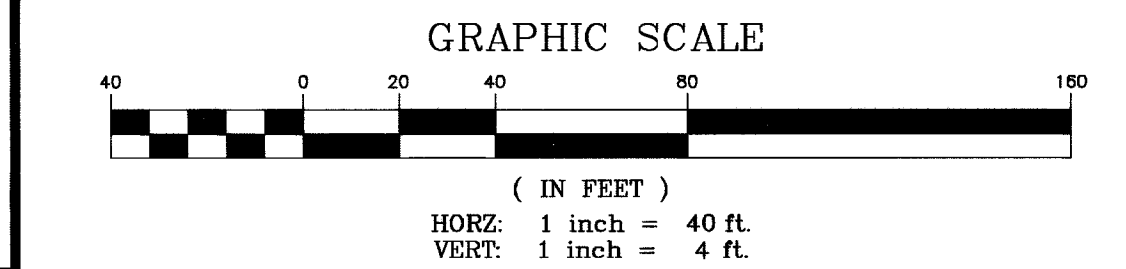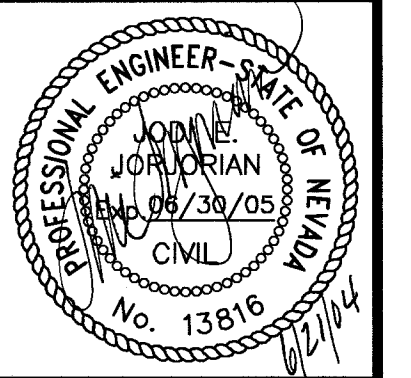


CITY OF LAS VEGAS BENCHMARK: 8LV90 19C4

RIVET AND PLATE IN CONCRETE PAD (ELEC) +/- 200 FEET
NORTHWEST OF DEER SPRINGS AND GRAND CANYON.

ELEVATION = 832.783m (NAVD'88)



THE BASIS OF BEARINGS FOR THIS PROJECT IS GRID NORTH AS DEFINED BY THE NEVADA COORDINATE SYSTEM OF 1983 (NCS83), EAST ZONE, (2701).

ALL EXISTING UTILITY LOCATIONS AND PROPERTY LINE BOUNDARIES SHOWN HEREON ARE APPROXIMATE ONLY. IT SHALL BE THE CONTRACTOR'S RESPONSIBILITY TO DETERMINE THE EXACT VERTICAL AND HORIZONTAL LOCATION OF ALL ITEMS PRIOR TO CONSTRUCTION AND RELOCATE ANY UTILITIES AS NECESSARY. NO REPRESENTATION IS MADE THAT ALL UTILITIES ARE SHOWN HEREON. THE ENGINEER ASSUMES NO LIABILITY FOR UTILITIES NOT SHOWN OR PROPERTY LINES NOT SHOWN IN THEIR PROPER LOCATIONS.

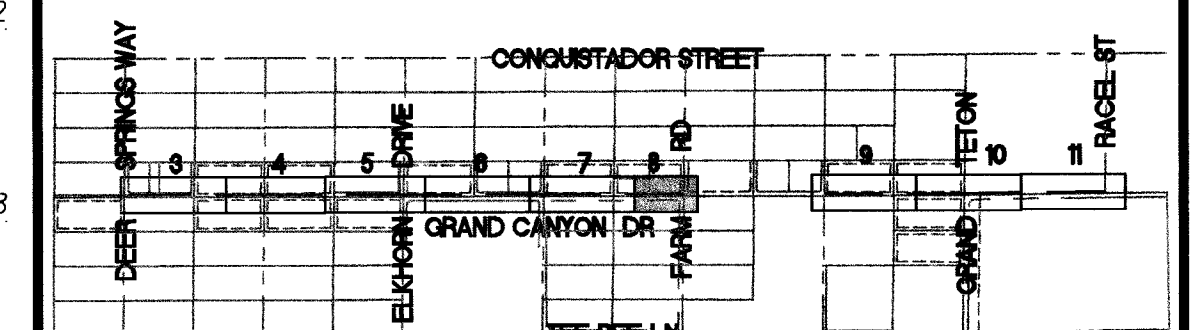

Engineer/Technician	JODI JORJORIAN	Phone	(702) 263-7275
Project Manager	CRAIG SISCO	Phone	(702) 365-2174
Project Contact	NATHAN WHITE	Phone	(702) 365-2349
Sheet No. 8 of 16	Scale 1" = 40'	Date	05/10/04
Dwn. By JMA	Chkd. By JEJ	Appvd. By	JEJ

Title	SI-CC GRAND CANYON DRIVE 16" STL 720# EXTENSION PLAN AND PROFILE STA 57+00 TO STA 61+51.13
-------	---

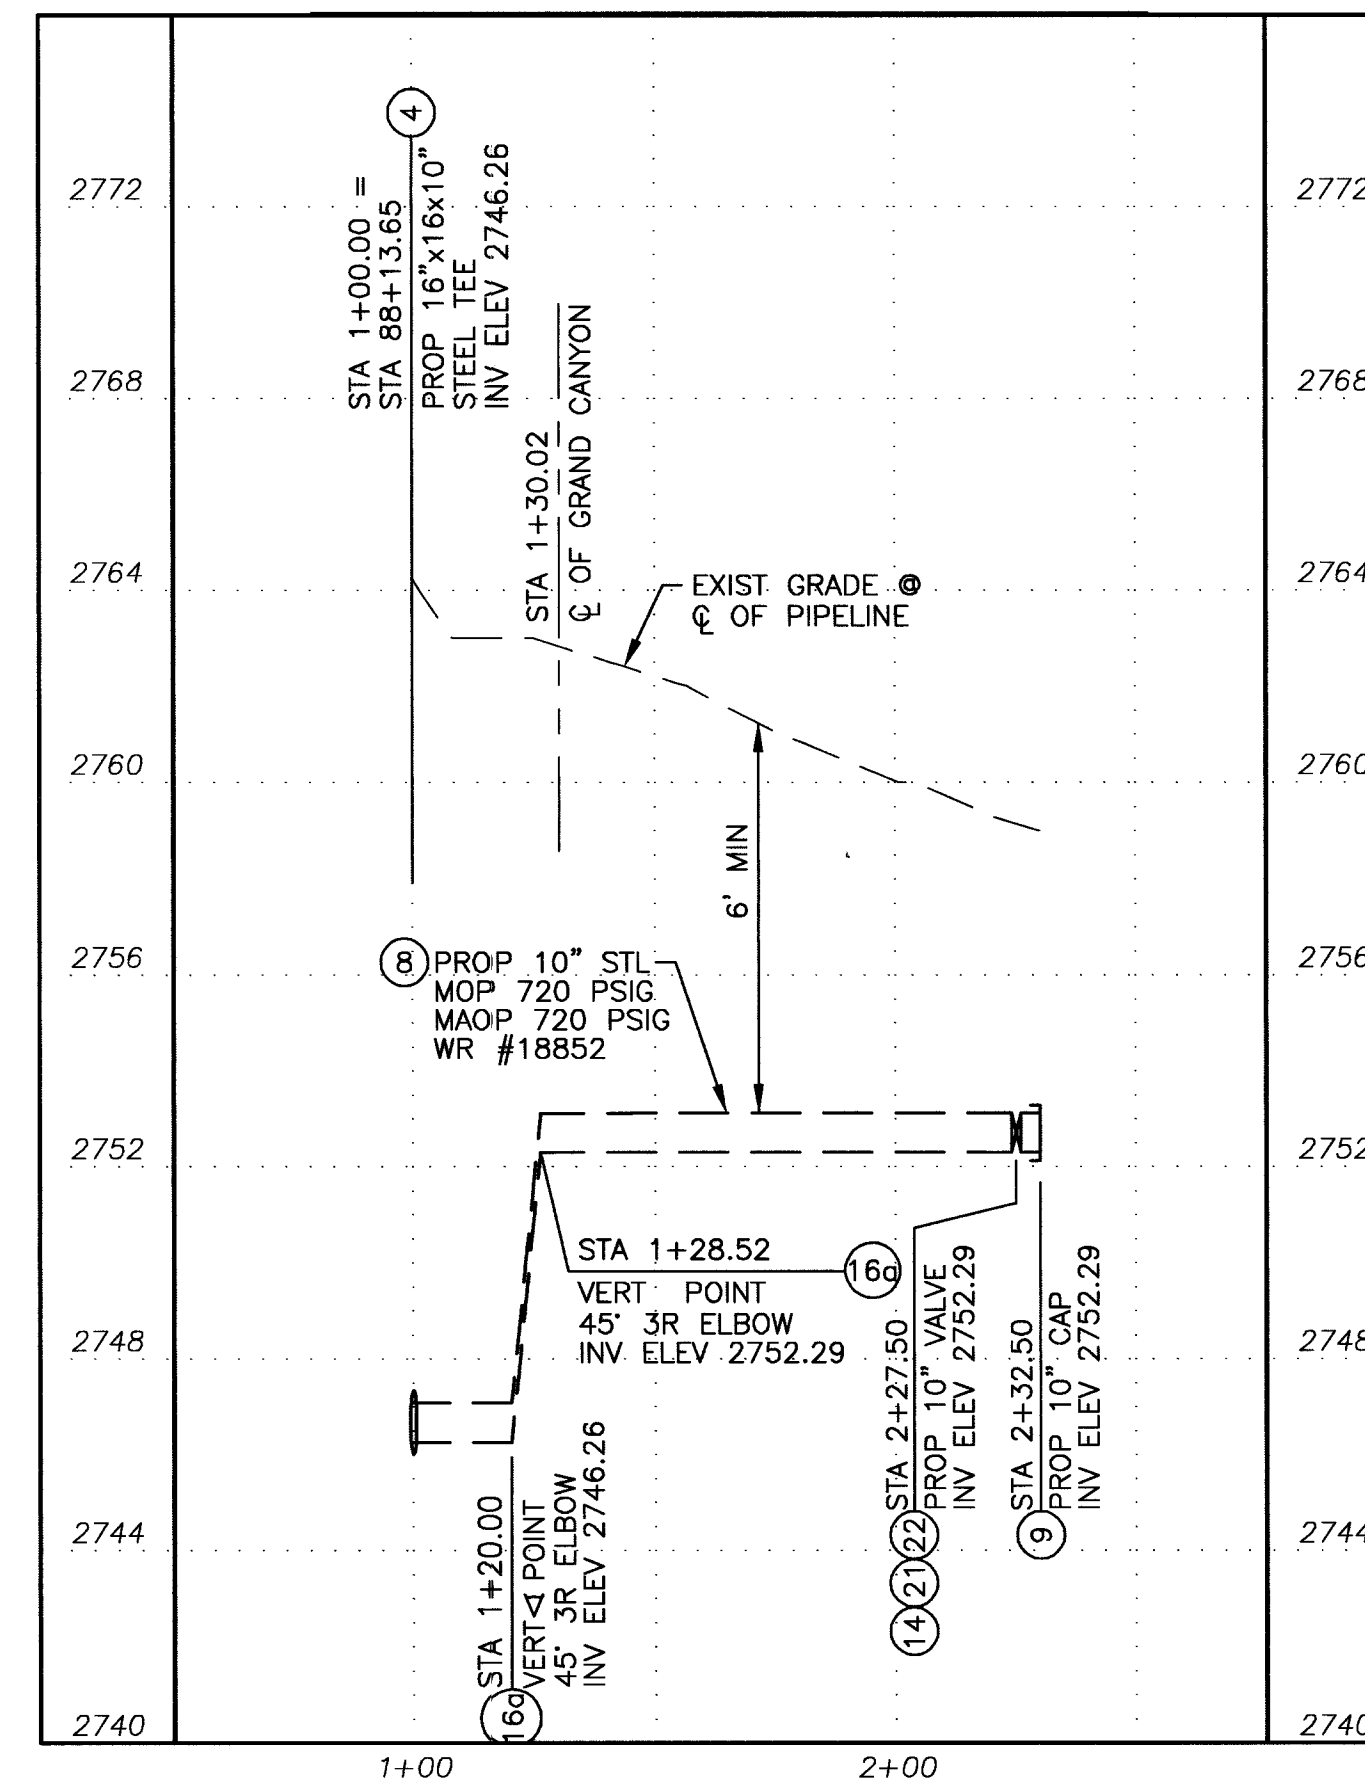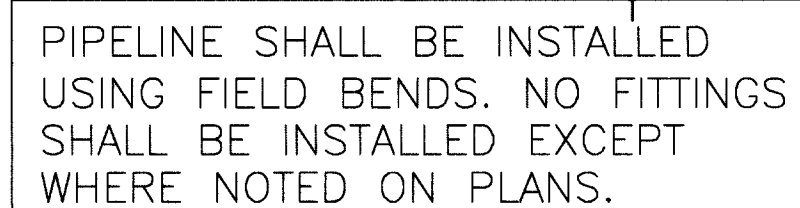

WR #18852		WR #18854		WR #18856	
UNIT NO.	UNIT TYPE	INSTL.	RET.	INSTL.	RET.
		PROPOSED		COMPLETED	
PROPERTY UNITS					

PIPE DIA. _____	TEST MEDIUM	TEST METHOD
PIPE LENGTH _____	☐ AIR	☐ GAUGE
PIPE TYPE _____	☐ NITROGEN	☐ CHART
MIN. DURATION _____	☐ WATER	
	☐ SOAP	
	START	END

TEST PRES. (PSIG) _____

TIME _____

DATE _____

PERFORMED BY _____

NO.	DESCRIPTION	BY	DATE	APPR	

REVISIONS	
AS-BUILT RECD. IN ENGINEERING	DATE _____
ATLAS POSTED BY _____	DATE _____
INDEX POSTED BY _____	DATE _____

INSPECTOR _____	SUPPLY ISOLATION AREA
FOREMAN _____	SUP-51

PERMIT INFORMATION
TAX DISTRICT: 02-125, 02-200
CLARK COUNTY, CITY OF LAS VEGAS

PBS

	SUPPLY ISOLATION AREA SUP-51
--	---------------------------------------

W.R. No.	18854
	18852

X579 Y558, X579 Y560
X579 Y562, X579 Y564

X579 Y566

Location
LAS VEGAS

Engineer/Technician	JODI JORJORIAN	Phone	(702) 263-7275
Project Manager	CRAIG SISCO	Phone	(702) 365-2174
Project Contact	NATHAN WHITE	Phone	(702) 365-2349
Sheet No. 8 of 16	Scale 1" = 40'	Date	05/10/04
Dwn. By JMA	Chkd. By JEJ	Appvd. By	JEJ

Title	SI-CC GRAND CANYON DRIVE 16" STL 720# EXTENSION PLAN AND PROFILE STA 57+00 TO STA 61+51.13
-------	---