



CIVIL ENGINEERING DIVISION
CLARK COUNTY DEVELOPMENT SERVICES
ACCEPTED



Call before you Under Ground

1-702-455-7511
CLARK COUNTY TRAFFIC OPERATIONS
AND
1-702-229-6611
LAS VEGAS AREA COMPUTERIZED TRAFFIC SYSTEM

**ISSUED FOR
CONSTRUCTION**
05/10/04

Avoid overhead power line contact. It's costly.

Call
before you
OVERHEAD

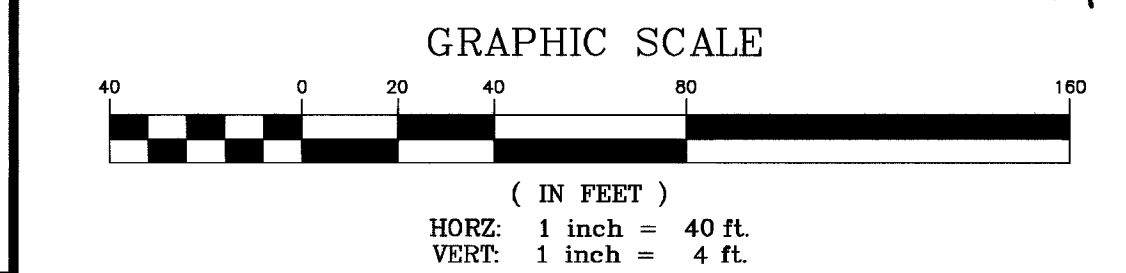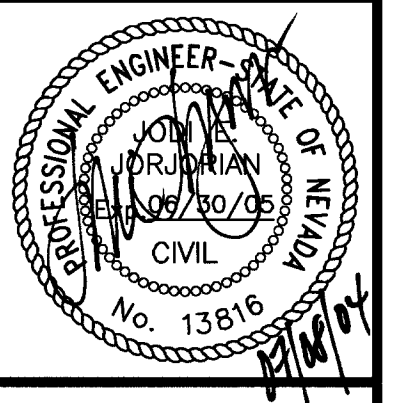


CITY OF LAS VEGAS BENCHMARK: 8LV90 19C4

RIVET AND PLATE IN CONCRETE PAD (ELEC) +/- 200 FEET
NORTHWEST OF DEER SPRINGS AND GRAND CANYON.

ELEVATION = 832.783m (NAVD'88)
= 2732.22ft (NAVD'88)

THE BASIS OF BEARINGS FOR THIS PROJECT IS GRID NORTH AS DEFINED BY THE NEVADA COORDINATE SYSTEM OF 1983 (NCS83), EAST ZONE, (2701).


ALL EXISTING UTILITY LOCATIONS AND PROPERTY LINE BOUNDARIES SHOWN HEREON ARE APPROXIMATE ONLY. IT SHALL BE THE CONTRACTOR'S RESPONSIBILITY TO DETERMINE THE EXACT VERTICAL AND HORIZONTAL LOCATION OF ALL ITEMS PRIOR TO CONSTRUCTION AND RELOCATE ANY UTILITIES AS NECESSARY. NO REPRESENTATION IS MADE THAT ALL UTILITIES ARE SHOWN HEREON. THE ENGINEER ASSUMES NO LIABILITY FOR UTILITIES NOT SHOWN OR PROPERTY LINES NOT SHOWN IN THEIR PROPER LOCATIONS.

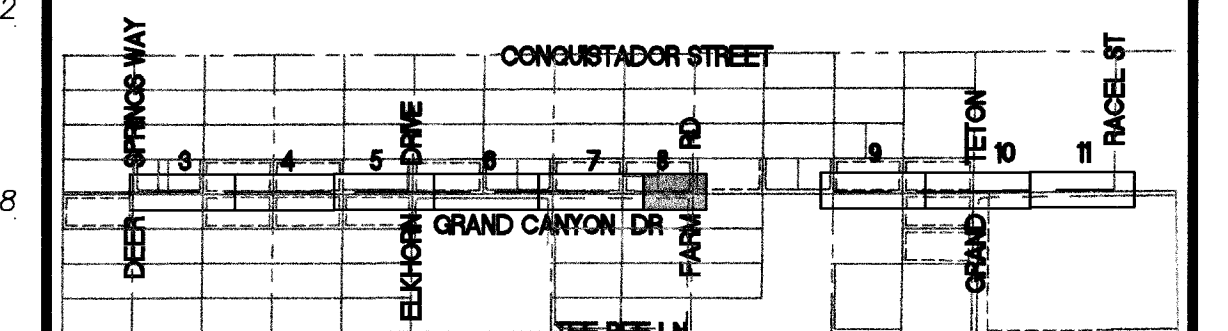




KEY MAP

Engineer/Technician JODI JORJORIAN	Phone (702) 263-7275
Project Manager CRAIG SISCO	Phone (702) 365-2174
Project Contact NATHAN WHITE	Phone (702) 365-2349
Sheet No. 8 of 16	Scale 1" = 40'
Dwn. By JMA	Chkd. By JEJ
	Appvd. By JEJ
	Date 05/10/04

SI-CC GRAND CANYON DRIVE
16" STL 720# EXTENSION
PLAN AND PROFILE
STA 57+00 TO STA 61+51.13

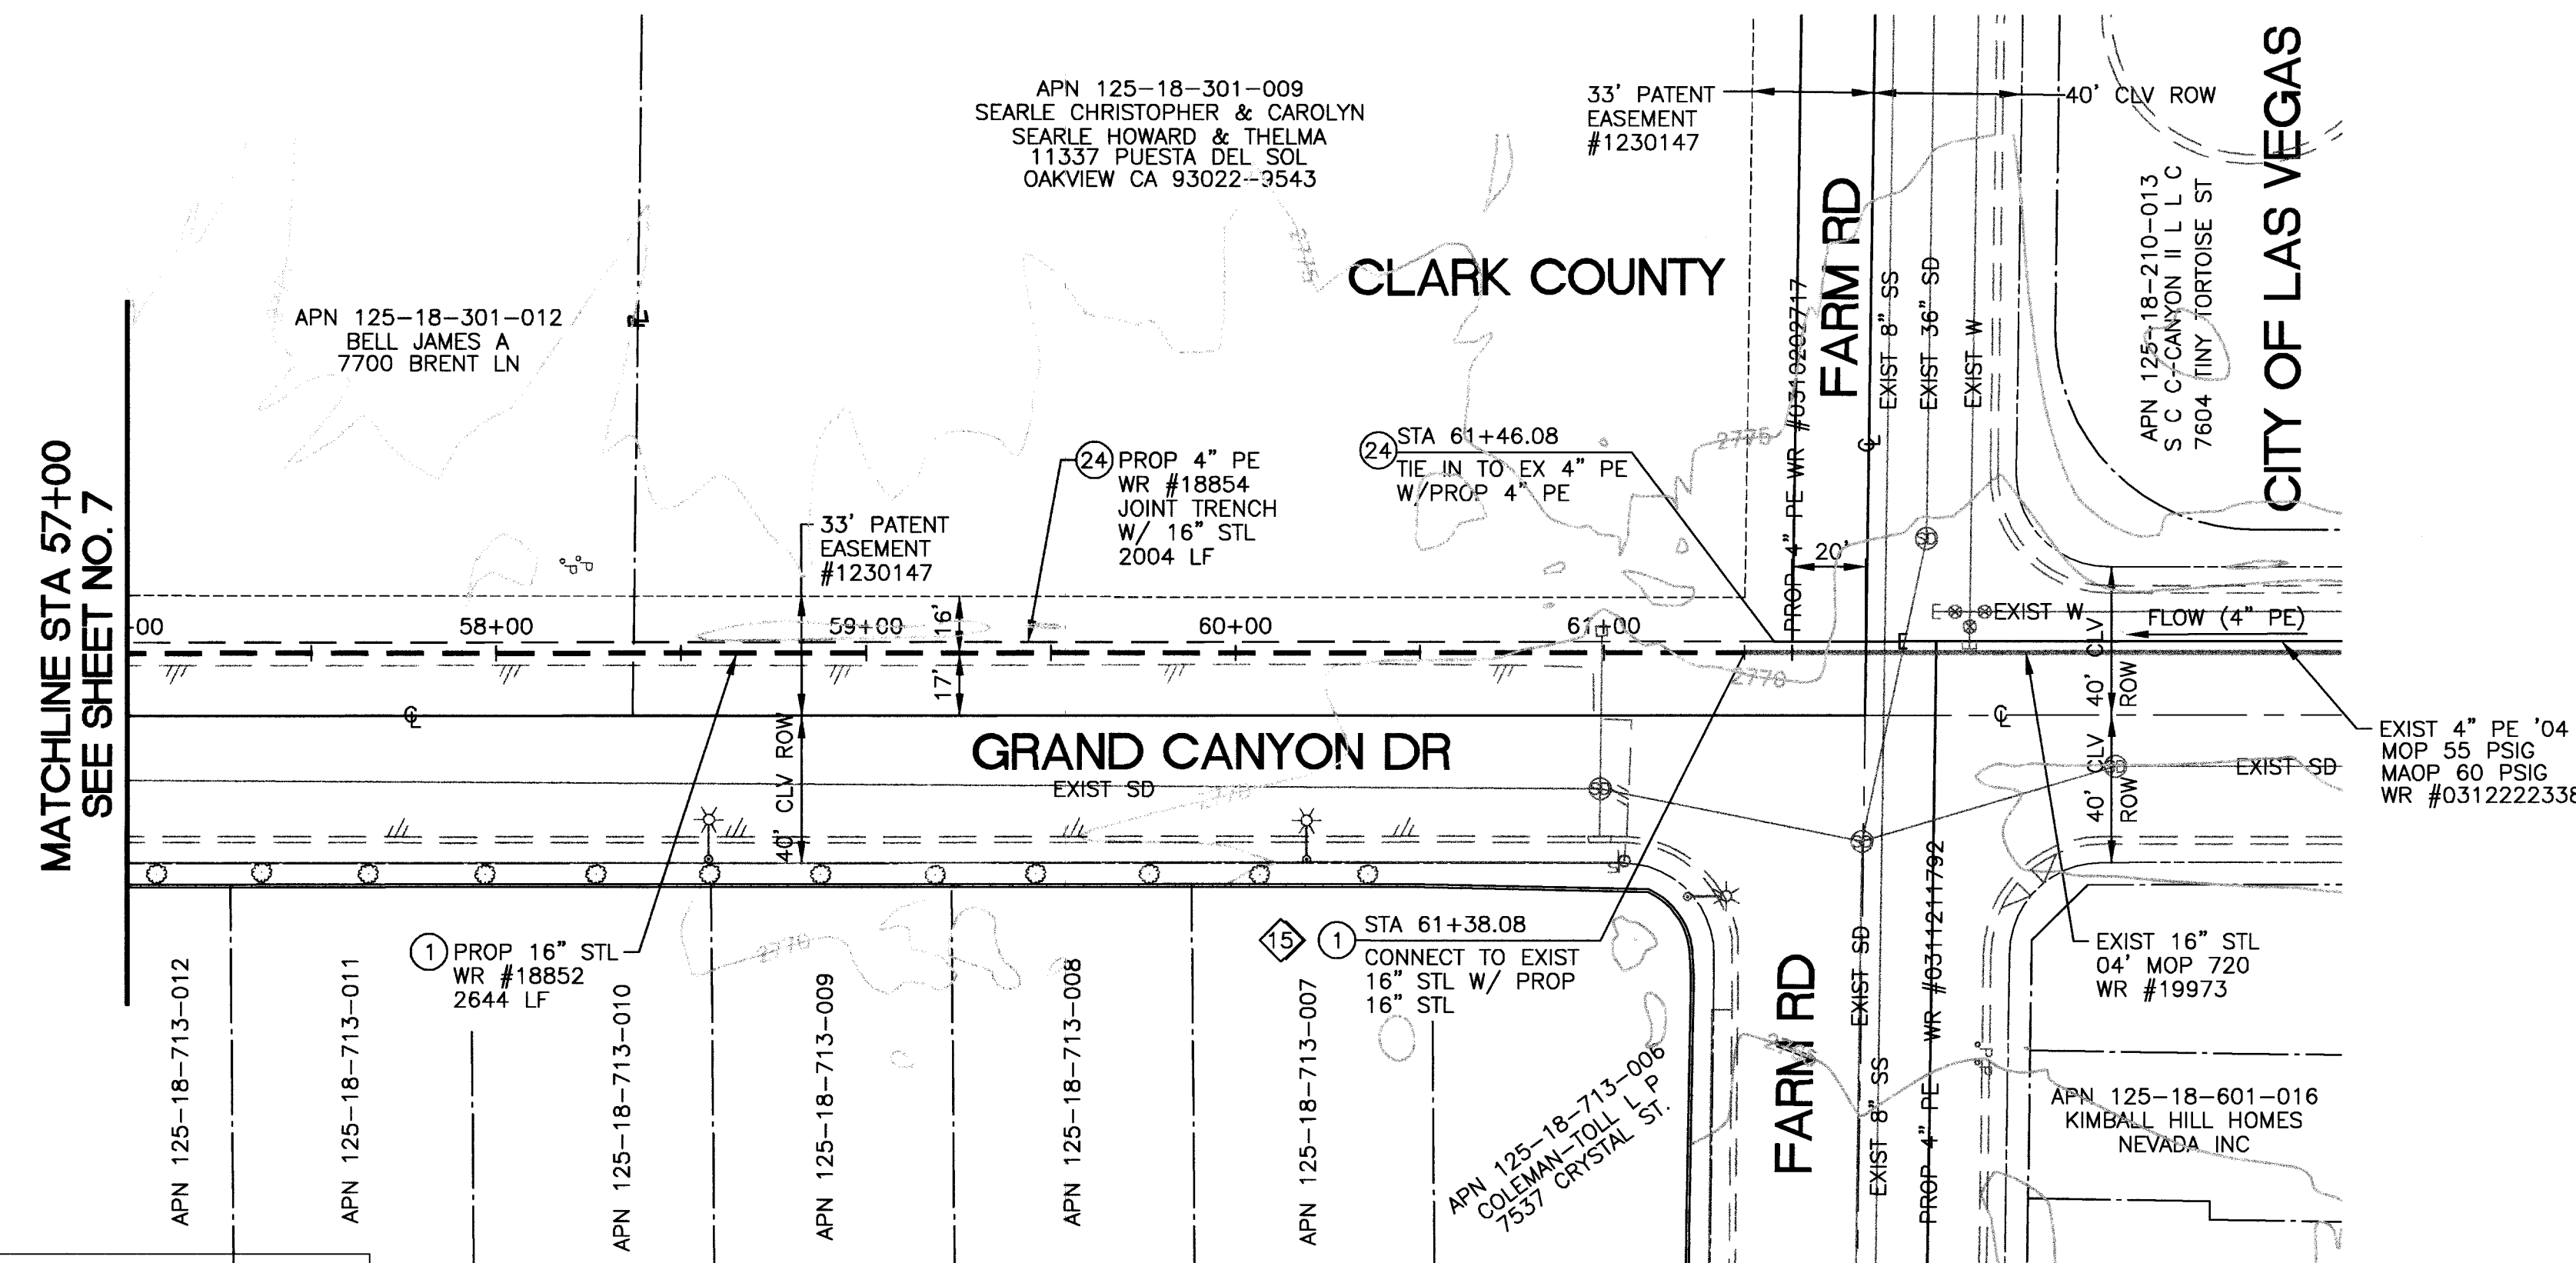

PIPELINE SHALL BE INSTALLED
USING FIELD BENDS. NO FITTINGS
SHALL BE INSTALLED EXCEPT
WHERE NOTED ON PLANS.

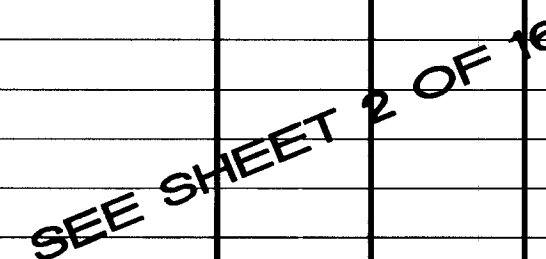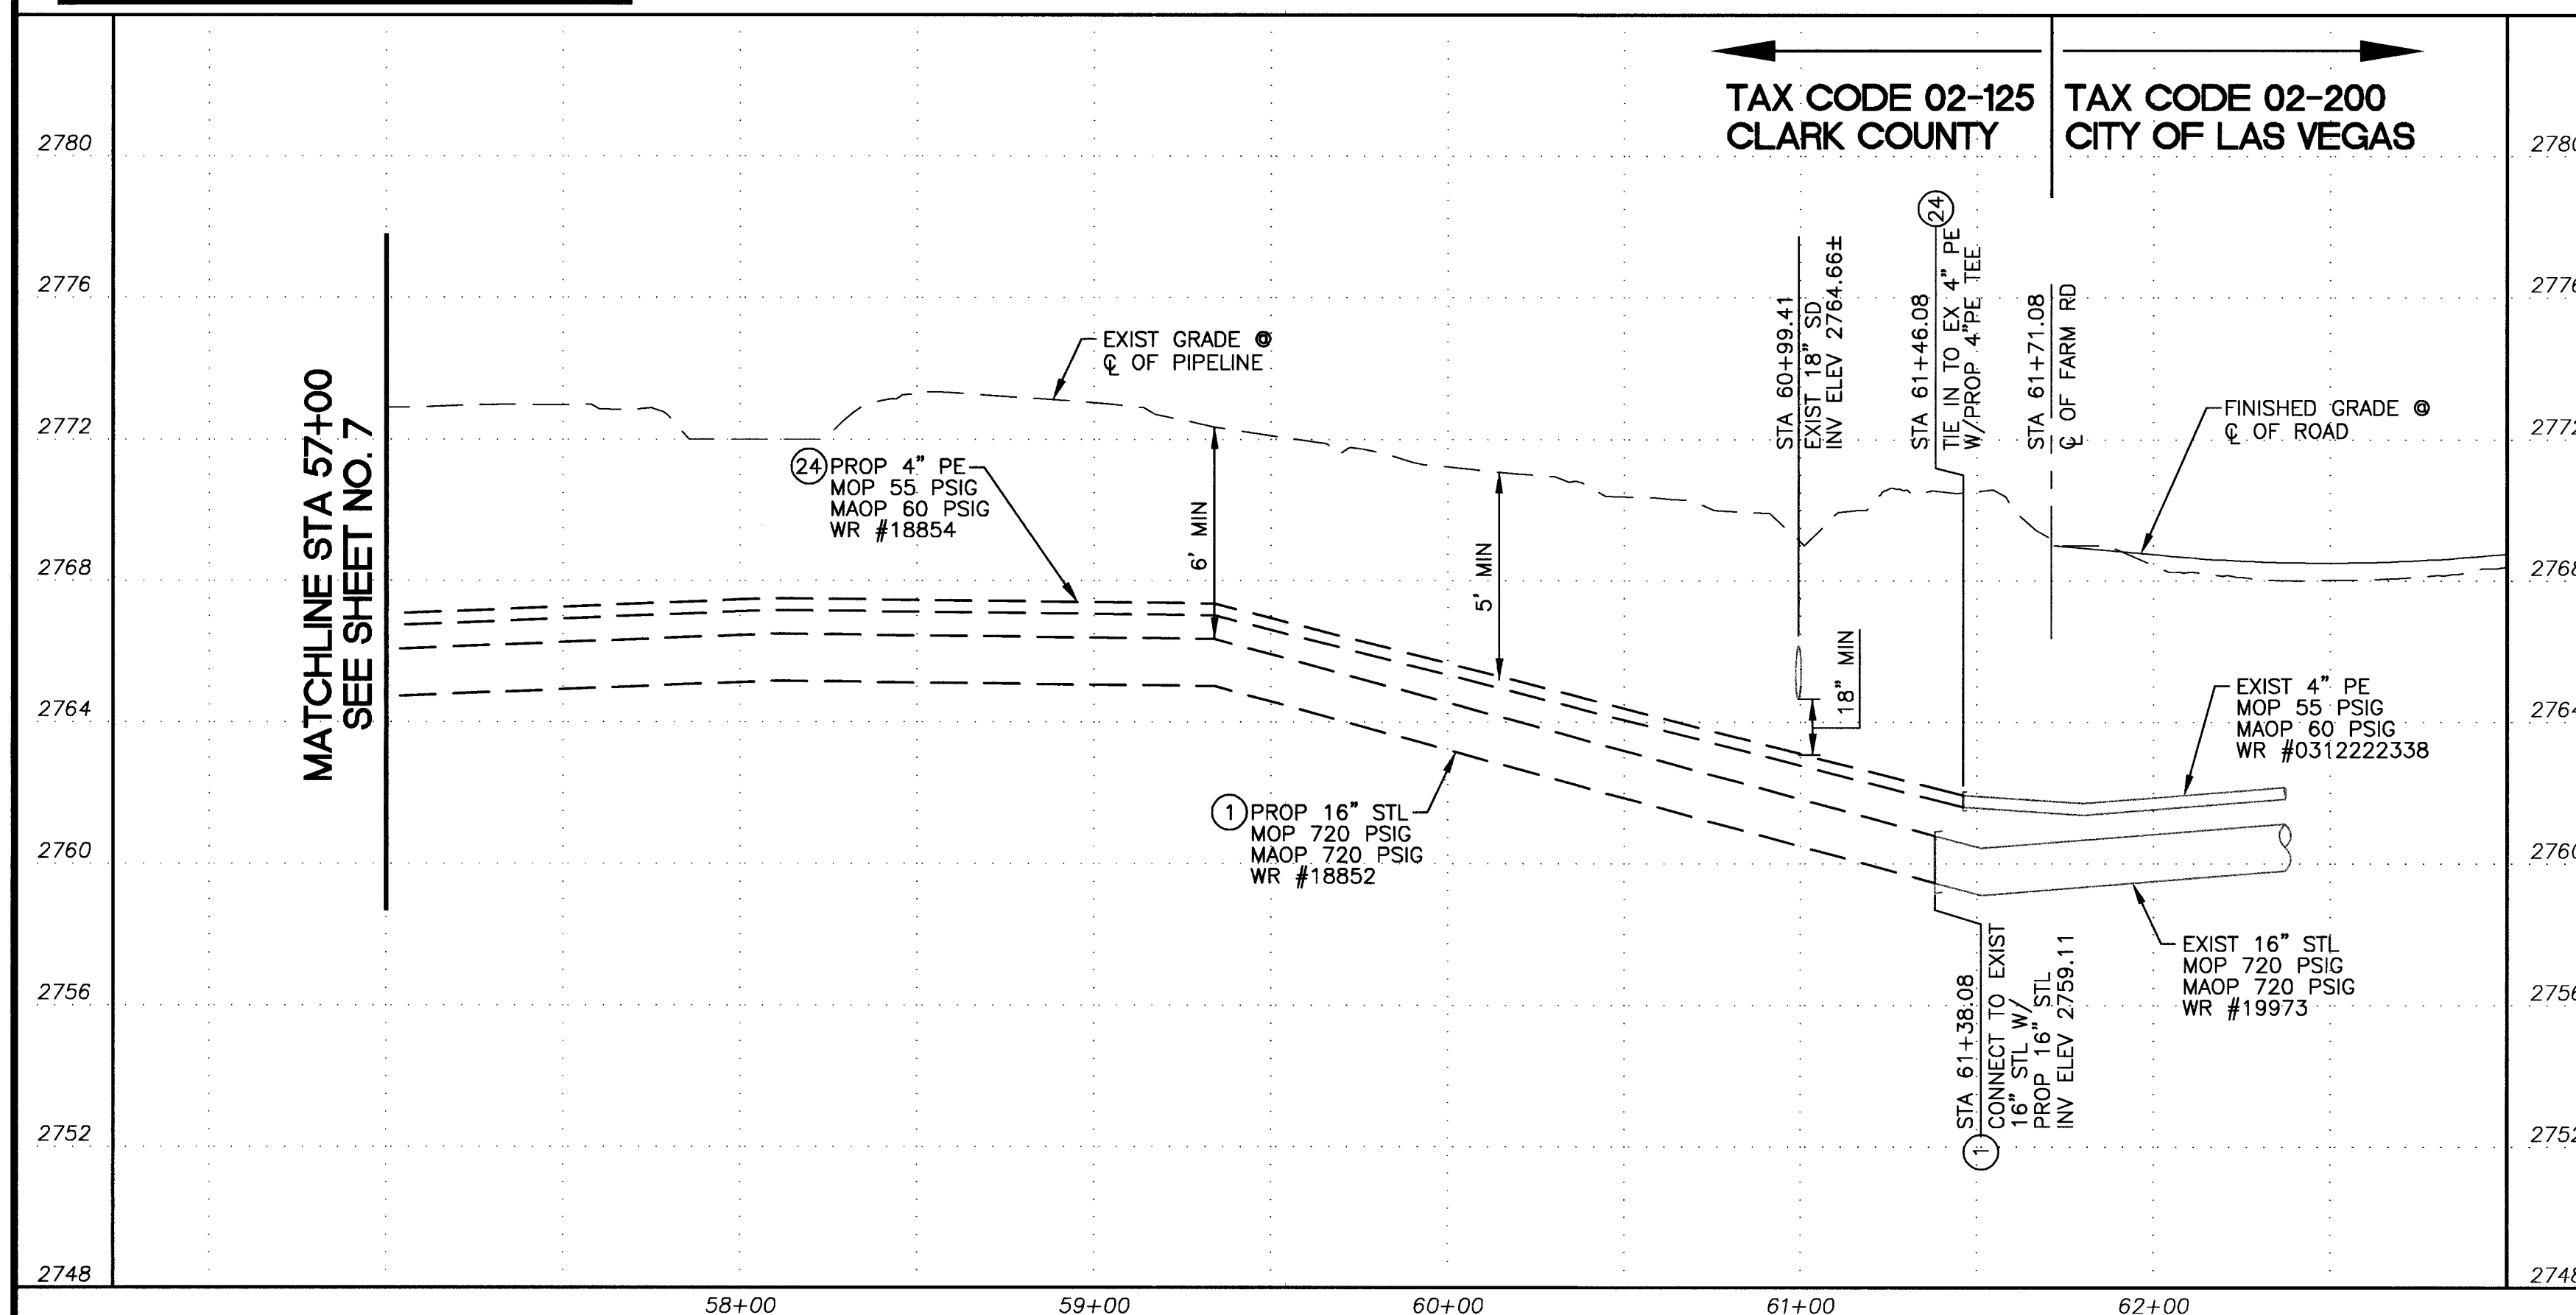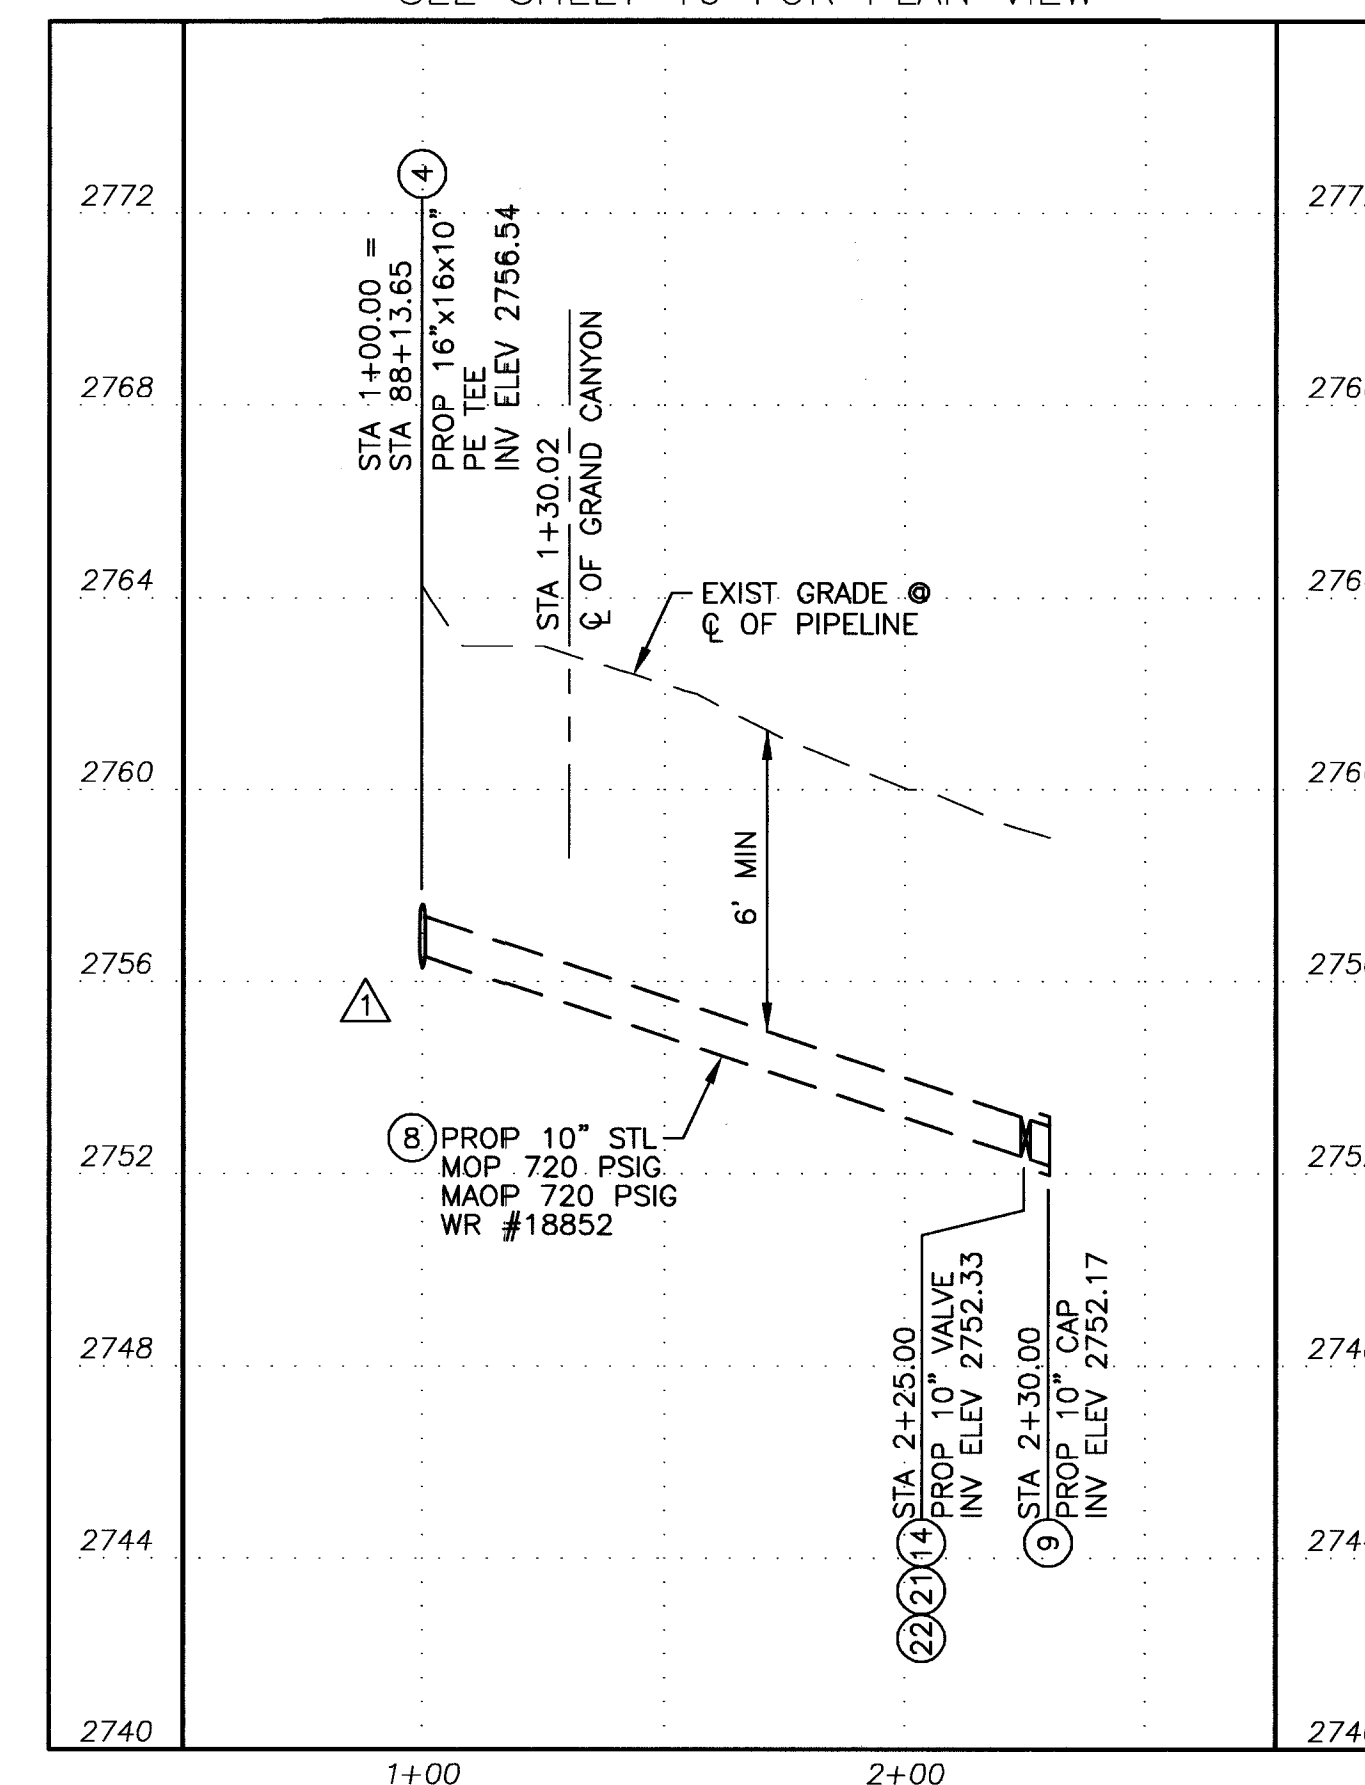

71134

AS-BUILT DRAWING-PRESSURE TEST DATA

PIPE DIA. _____	TEST MEDIUM	TEST METHOD
PIPE LENGTH _____	☐ AIR	☐ GAUGE
PIPE TYPE _____	☐ NITROGEN	☐ CHART
MIN. DURATION _____	☐ WATER	
	☐ SOAP	
	START	END

	START	END
TEST PRES. (PSIG)	_____	_____
TIME	_____	_____
DATE	_____	_____
PERFORMED BY	_____	

①	REVISED 10" DEPTH TO 6' & REVISE
	DROP SECTION LOCATION NORTH OF
	GRAND TETON

7/07/0

REVISIONS	
AS-BUILT RECD. IN ENGINEERING	DATE _____
ATLAS POSTED BY _____	DATE _____
INDEX POSTED BY _____	DATE _____

INSPECTOR _____

FOREMAN _____	AREA SUP-51 31
PERMIT INFORMATION TAX DISTRICT: 02-125, 02-200 CLARK COUNTY, CITY OF LAS VEGAS	

FILE NAME 1515G-8

SUPPLY
ISOLATION
AREA
SUP-51

31

W.R. No.	18854
	18852

X579 Y558, X579 Y560

X579 Y562, X579 Y564

X579 Y566

Location
LAS VEGAS, NV

Engineer/Technician	JODI JORJORIAN	Phone	(702) 263-7275
Project Manager	CRAIG SISCO	Phone	(702) 365-2174
Project Contact	NATHAN WHITE	Phone	(702) 365-2349
Sheet No.	8 of 16	Scale	1" = 40'
Dwn. By	JMA	Chkd. By	JEJ
		Appvd. By	JEJ
		Date	05/10/04

Title	SI-CC GRAND CANYON DRIVE 16" STL 720# EXTENSION PLAN AND PROFILE STA 57+00 TO STA 61+51.13
-------	---