


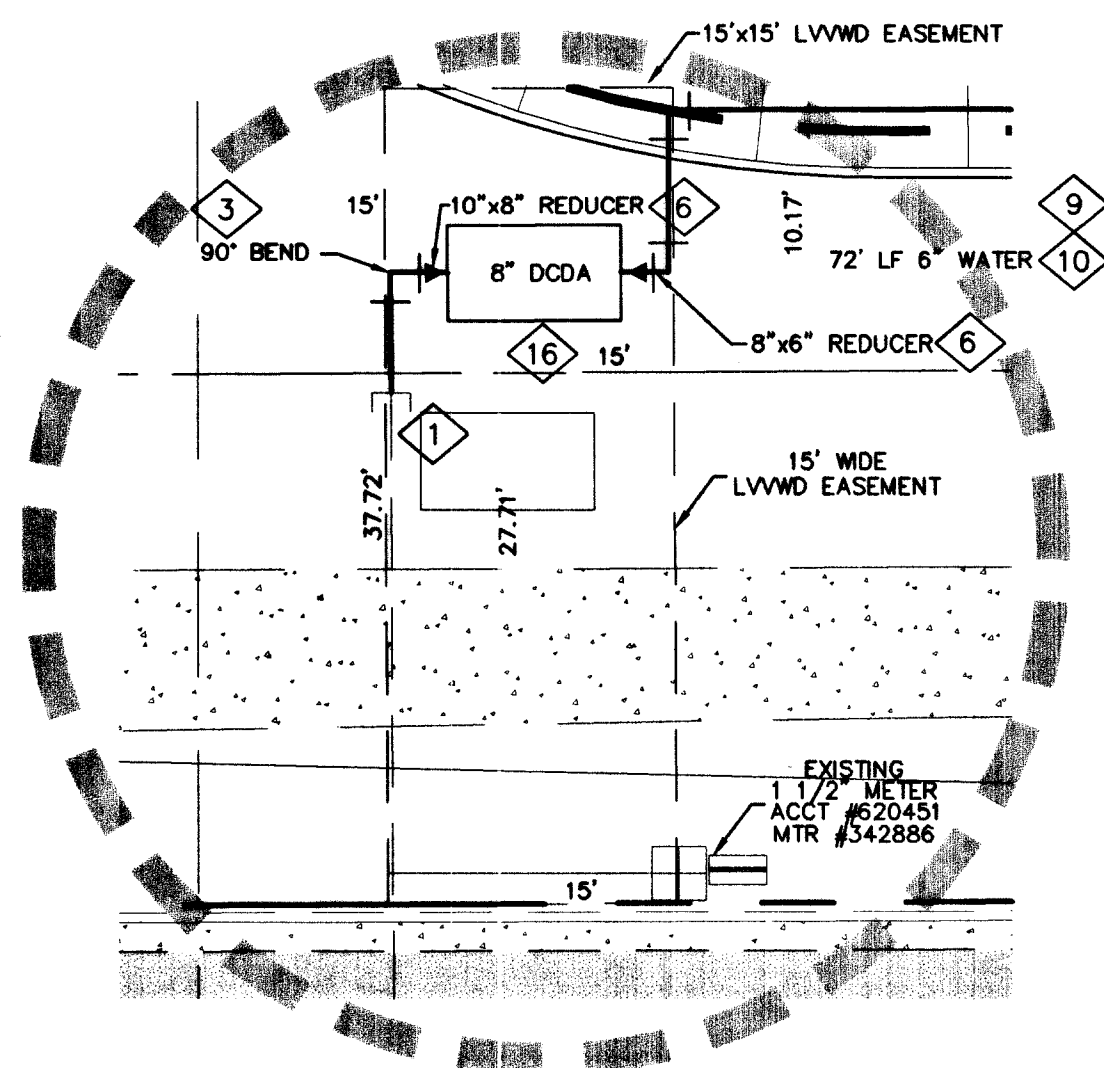
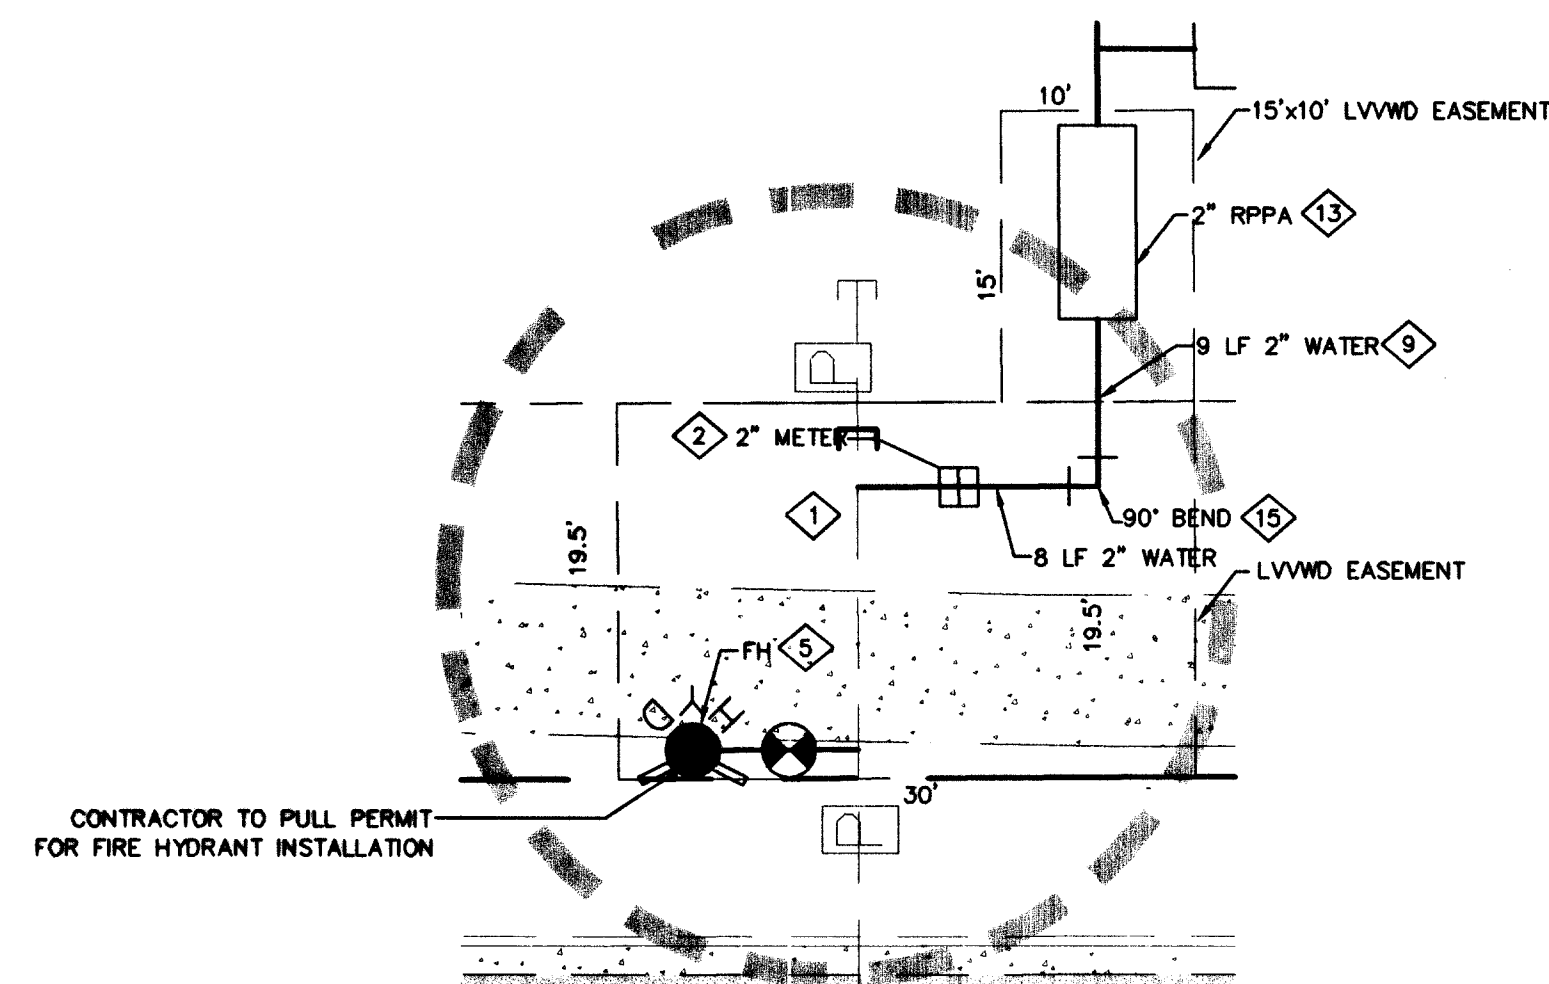
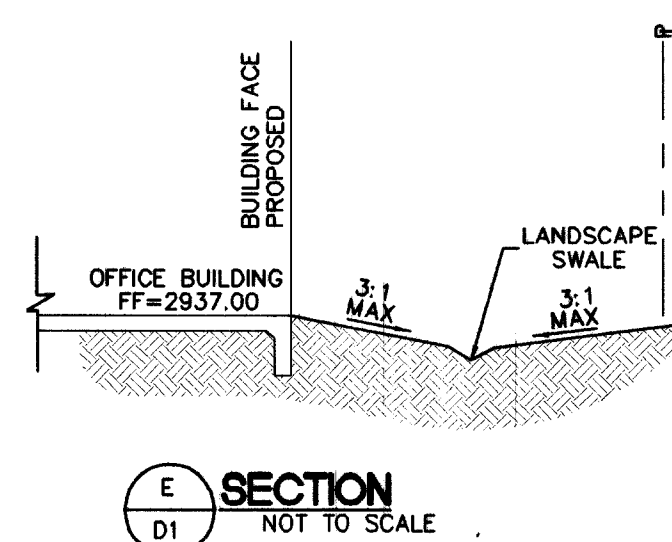
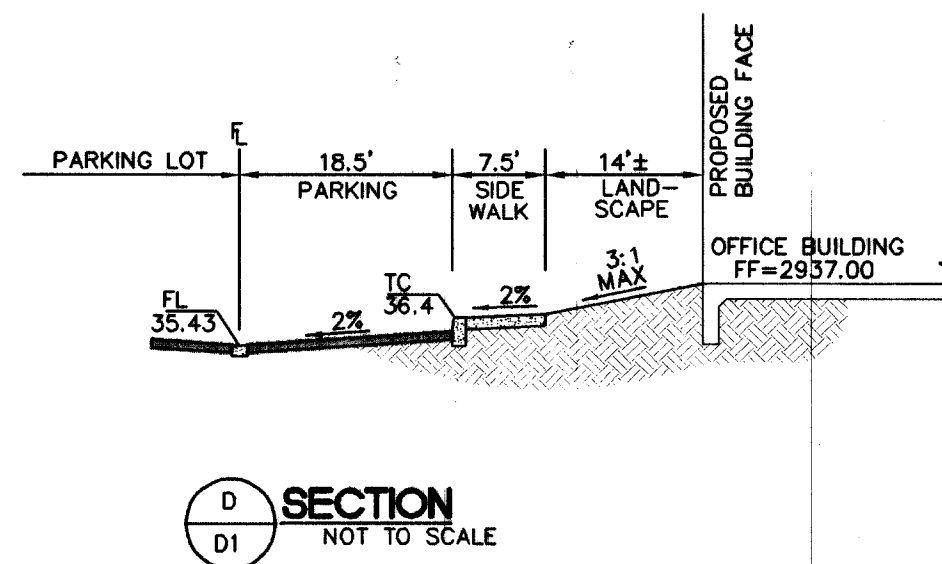


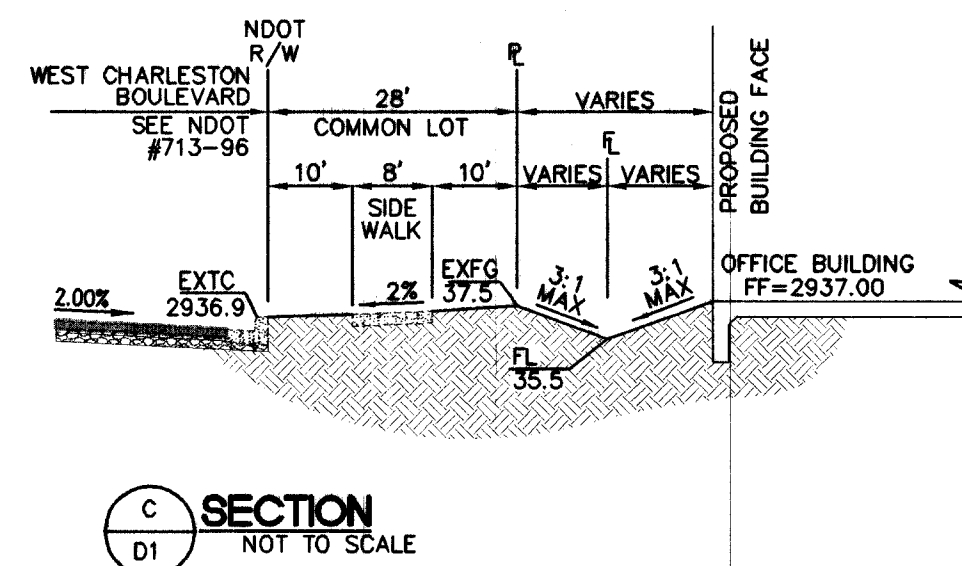

UTILITY EASMENT DETAIL "A"

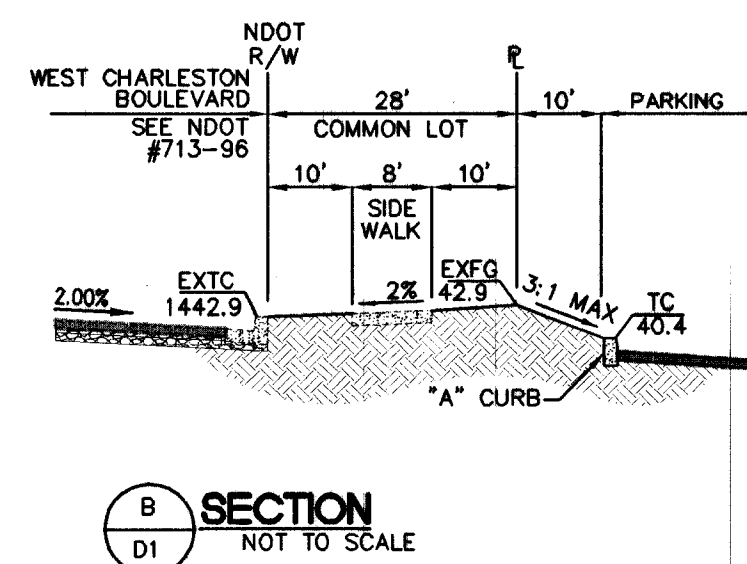

UTILITY EASMENT DETAIL "B"

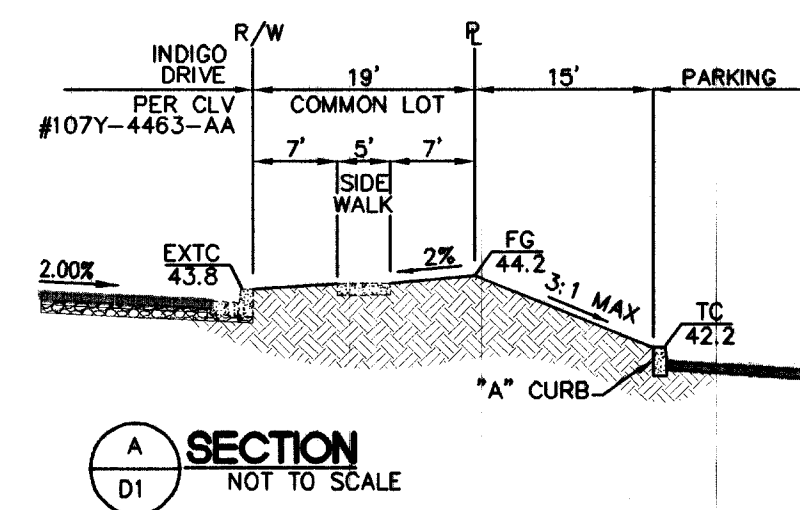


WATER CONSTRUCTION NOTES

1. CONNECT TO EXIST. 10" WATER STUB. CUT & TIE IN PER UDACS PLATE 4A NOTE 1.
2. INSTALL COMPLETE 2" DOM. WATER LINE W/ CORPORATION STOP & 2" METER PER UDACS PLATE #1D.
3. 6" - 90° ELBOW W/ THRUST BLOCK PER UDACS PLATE 5.
4. 6"x6"x6" TEE W/ THRUST BLOCK PER UDACS PLATE 5.
5. INSTALL FIRE HYDRANT ASSEMBLY COMPLETE PER UDACS PLATE #7.
6. INSTALL REDUCER, SIZE PER PLAN WITH THRUST BLOCKS PER PLATE #3.
7. STUB AND CAP 6" WATER WITH THRUST BLOCKS PER PLATE #5.
8. SEE MECHANICAL PLANS FOR BUILDING CONNECTIONS.
9. INSTALL PVC WATER MAIN, SIZE PER PLAN, WATER TRENCH PER UDACS PLATE #6C.
10. INSTALL 6" PVC FIRE LINE.
11. INSTALL COMPLETE 1.5" IRRIGATION POLY. LINE W/ CORPORATION STOP.
12. 1.5" RPPA PER UDACS PLATE #11A. SEE LANDSCAPE PLANS FOR CONTINUATION.
13. INSTALL FIRE DEPARTMENT CONNECTION, RATED FOR 200 PSI, SEE MECHANICAL PLANS.
14. INSTALL 2" RPPA PER UDACS PLATE # 11A.
15. INSTALL POST INDICATOR VALVE PER FIRE DEPARTMENT REQUIREMENTS.
16. 2" - 90° BRASS ELBOW.
17. INSTALL 8" DCA PER UDACS PLATE 11C (FEBCO MODEL 870 - LOW PRESSURE LOSS DCA).
18. CONTRACTOR TO PULL PERMIT FOR FIRE HYDRANT INSTALLATION.

APPROVED FOR CONSTRUCTION

DATE: 1/4/2004
 DRAWN: I DL2
 DESIGNED: I/A
 CHECKED: I/JDK
 PROJECT #: BRS 3043969.00
 SHEET TITLE: DETAIL SHEET
 SHEET NUMBER: D1
 7 OF 7 SHEET

DETAIL SHEET
 HUGHES PLAZA WEST
 CBS L.L.C.
 LAS VEGAS, NEVADA

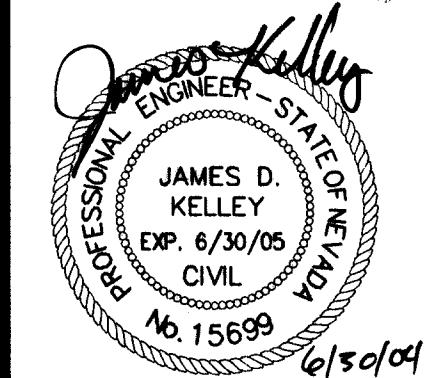

DATE: 1/4/2004
 DRAWN: I DL2
 DESIGNED: I/A
 CHECKED: I/JDK
 PROJECT #: BRS 3043969.00
 SHEET TITLE: DETAIL SHEET
 SHEET NUMBER: D1
 7 OF 7 SHEET

W R G
 DESIGN
 301 W. HOBSON RIDGE PARKWAY #100, HENDERSON, NV 89052
 Tel. 702.990.9300 Fax. 702.990.9305
 PLANNERS • ENGINEERS • LANDSCAPE ARCHITECTS • SURVEYORS

70848 72845
 K2