

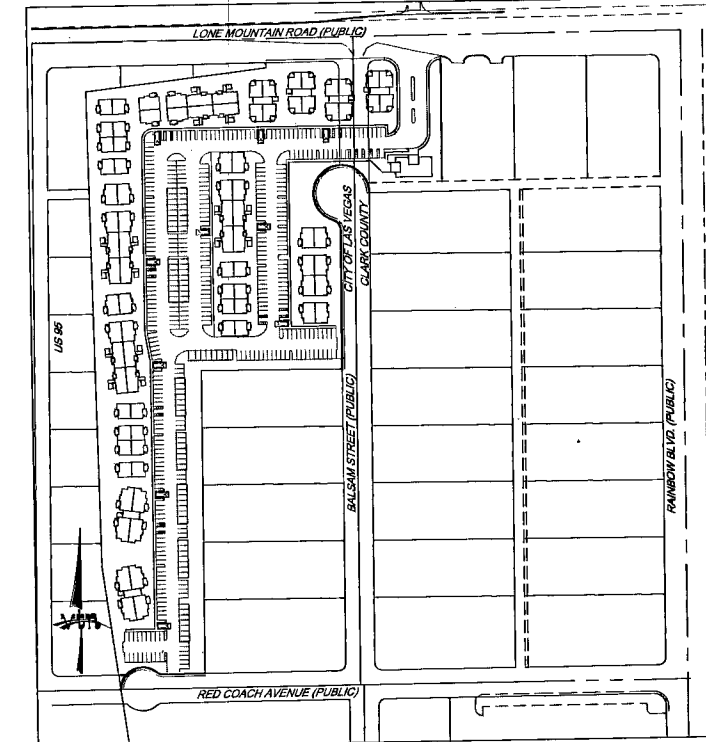


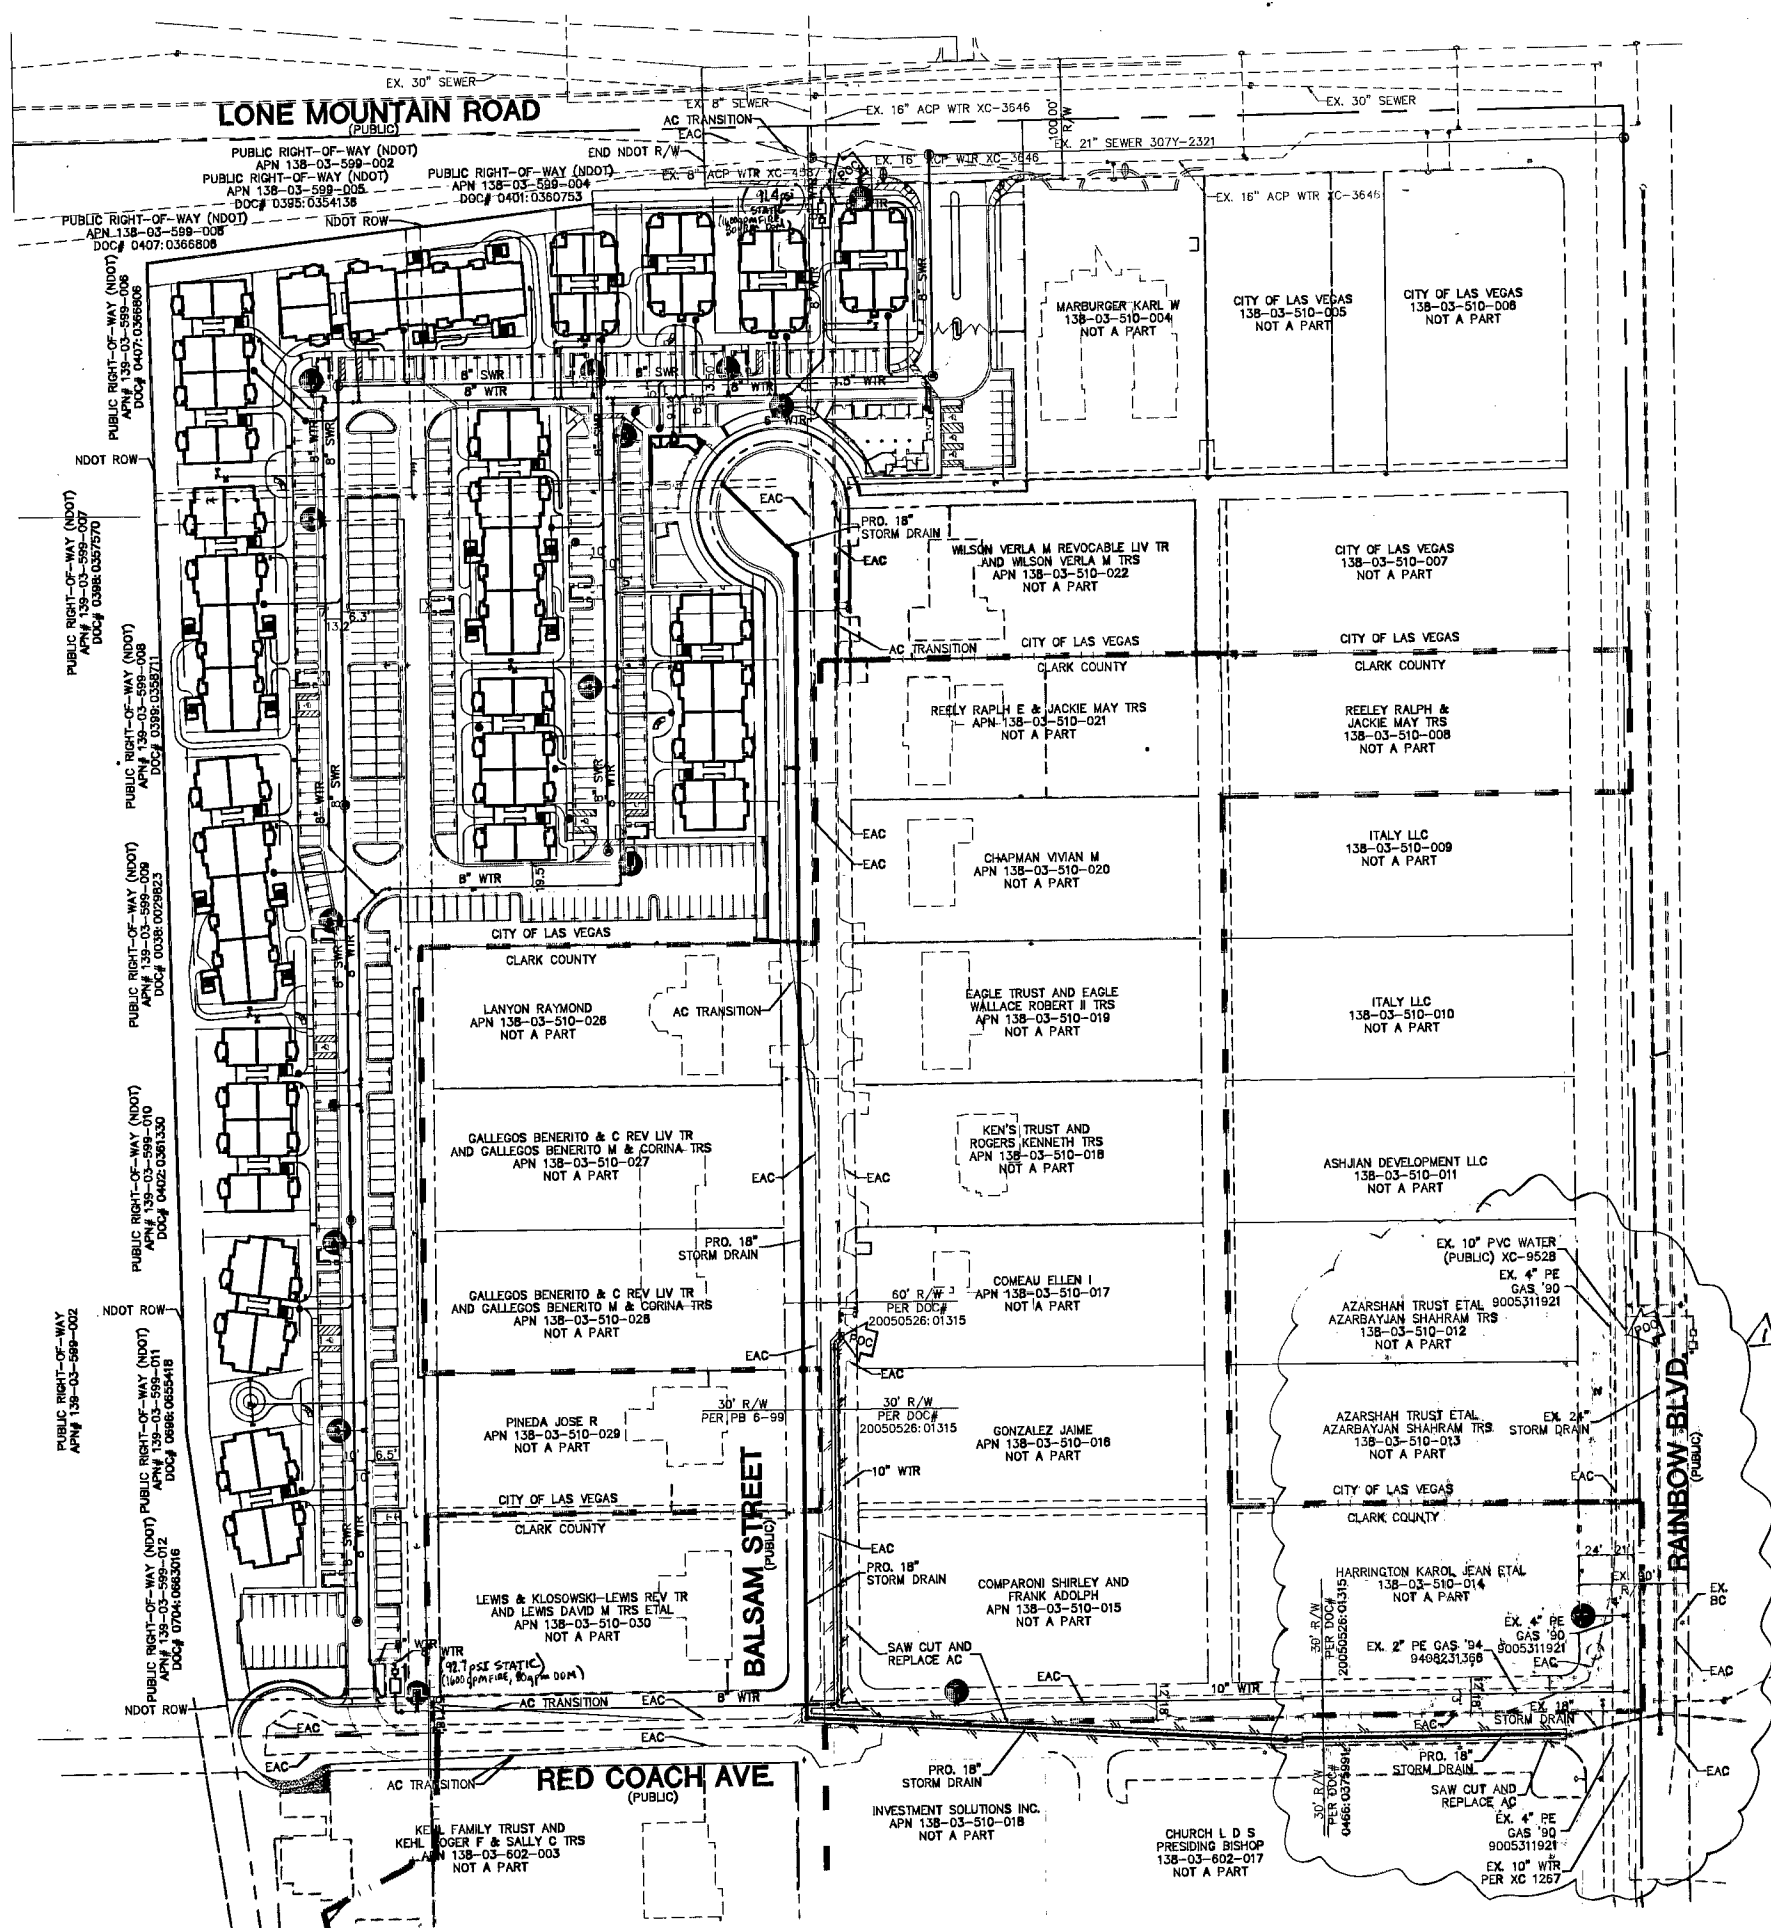

Call before you Dig
1-702-455-7511
CLARK COUNTY TRAFFIC OPERATIONS
1-702-432-5300
FREEWAY AND ARTERIAL SYSTEM OF TRANSPORTATION

Call before you Dig
811 OR 1-800-227-2600

Call before you Overhead
1-702-227-2929

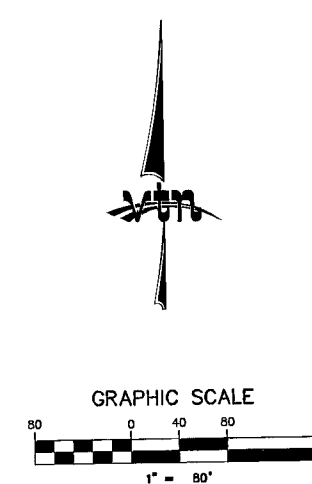

APPROVALS:
 [Signature] 4-09-09
 LAS VEGAS VALLEY WATER DISTRICT
 PROJECT # 111538
 DATE
 FIRE DEPARTMENT APPROVAL
 BY: [Signature] DATE: 12-2-09
 APPROVAL OF THESE PLANS SHALL NOT BE CONSTRUED TO BE A PERMIT FOR, OR AN APPROVAL OF, ANY VIOLATION OF ANY OF THE PROVISIONS OF THE STATE OR COUNTY LAWS.
 107V5176

STERLING S. DEVELOPMENT		CITY OF LAS VEGAS	
6365 CAMERON STREET LAS VEGAS, NV 89118 (702) 871-0555 FAX: (702) 871-0550		2727 SOUTH RAINBOW BOULEVARD LAS VEGAS, NEVADA 89146-5148 PH. (702) 873-7550 FAX (702) 362-2597 WEB WWW.VNV.COM CONSULTING ENGINEERS • PLANNERS • LAND SURVEYORS	
OVERALL UTILITY PLAN		INSPIRADO APARTMENTS	
DRAWN BY: LMH	9/08	DESIGNED BY: LMH	9/08
CHECKED BY: CRG	9/08	PROJECT NO: 7017	SCALE: 1"=80' N.T.S.
		UTU 11 of 41 SHEETS DRAWING NO. HTE# 09-228	

116693
116694
116697