
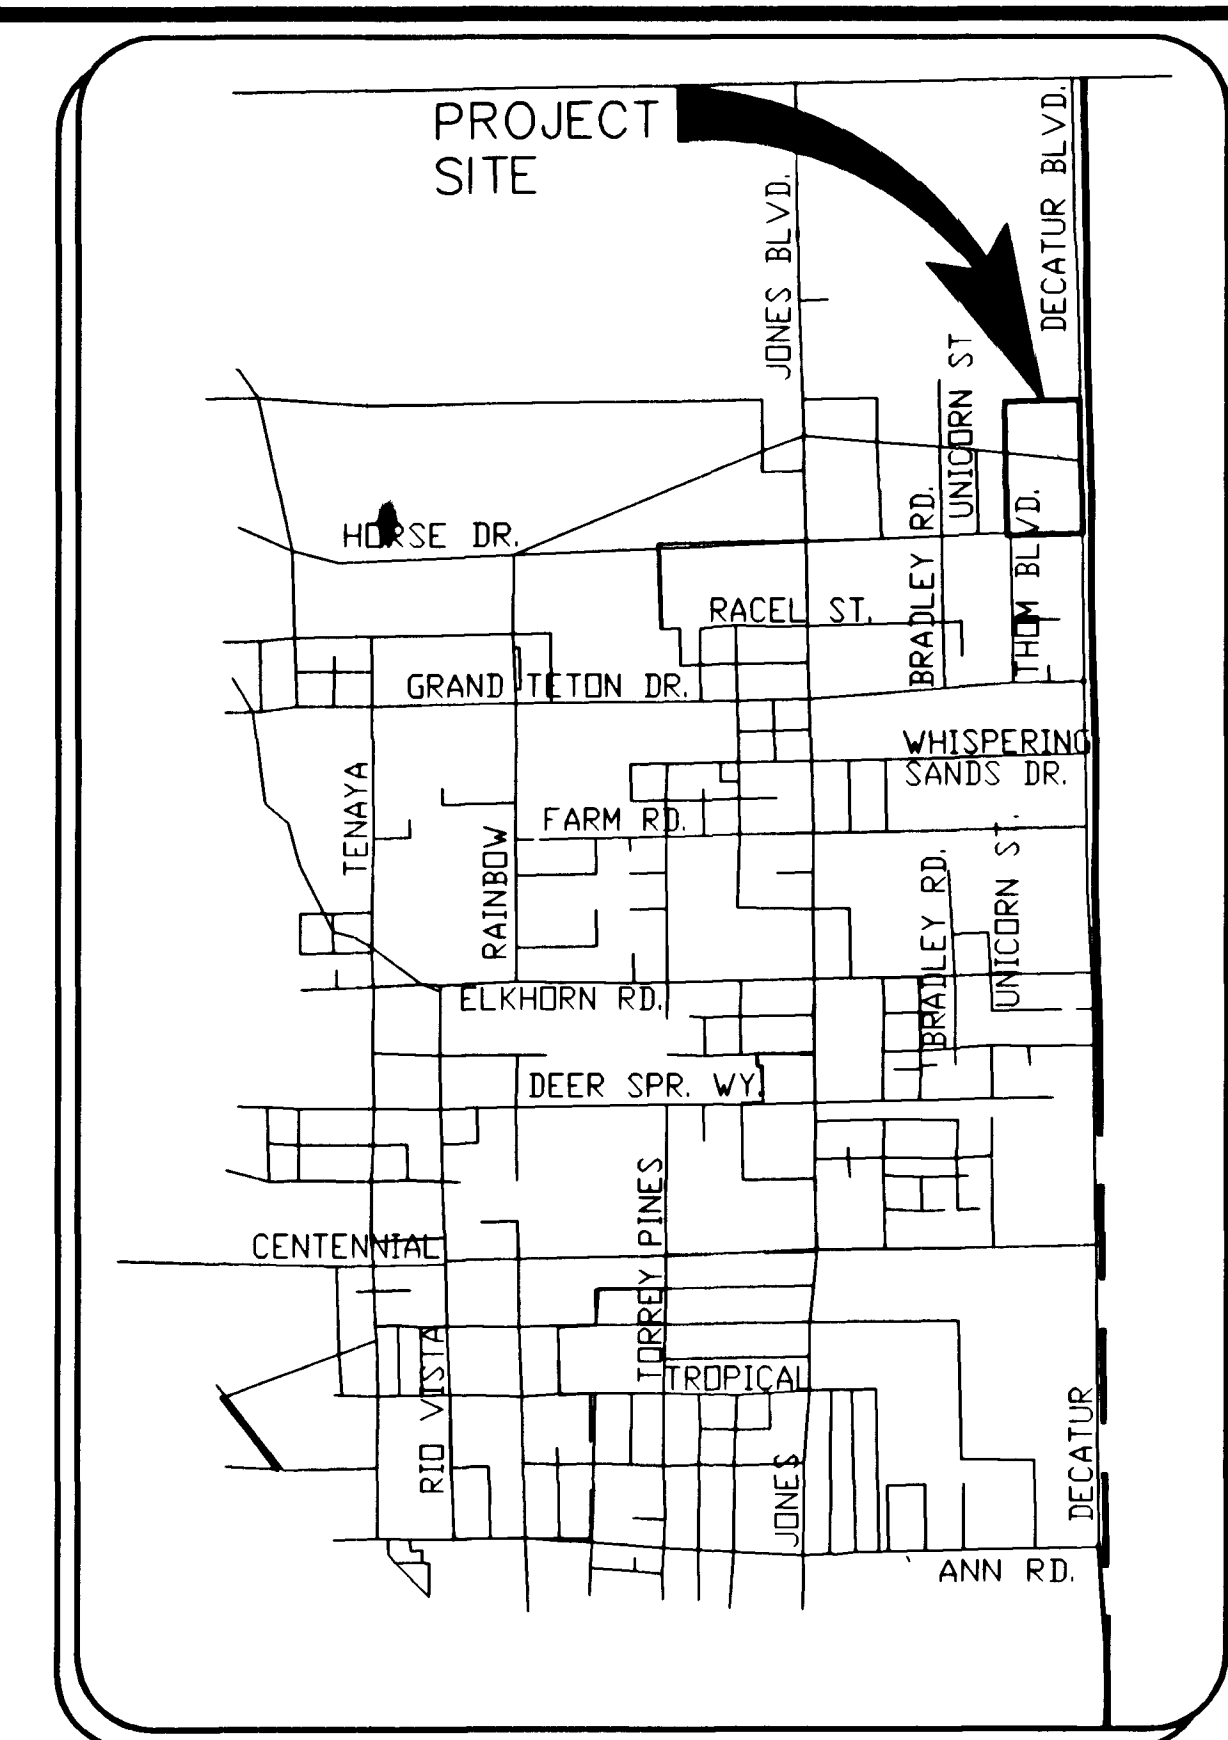


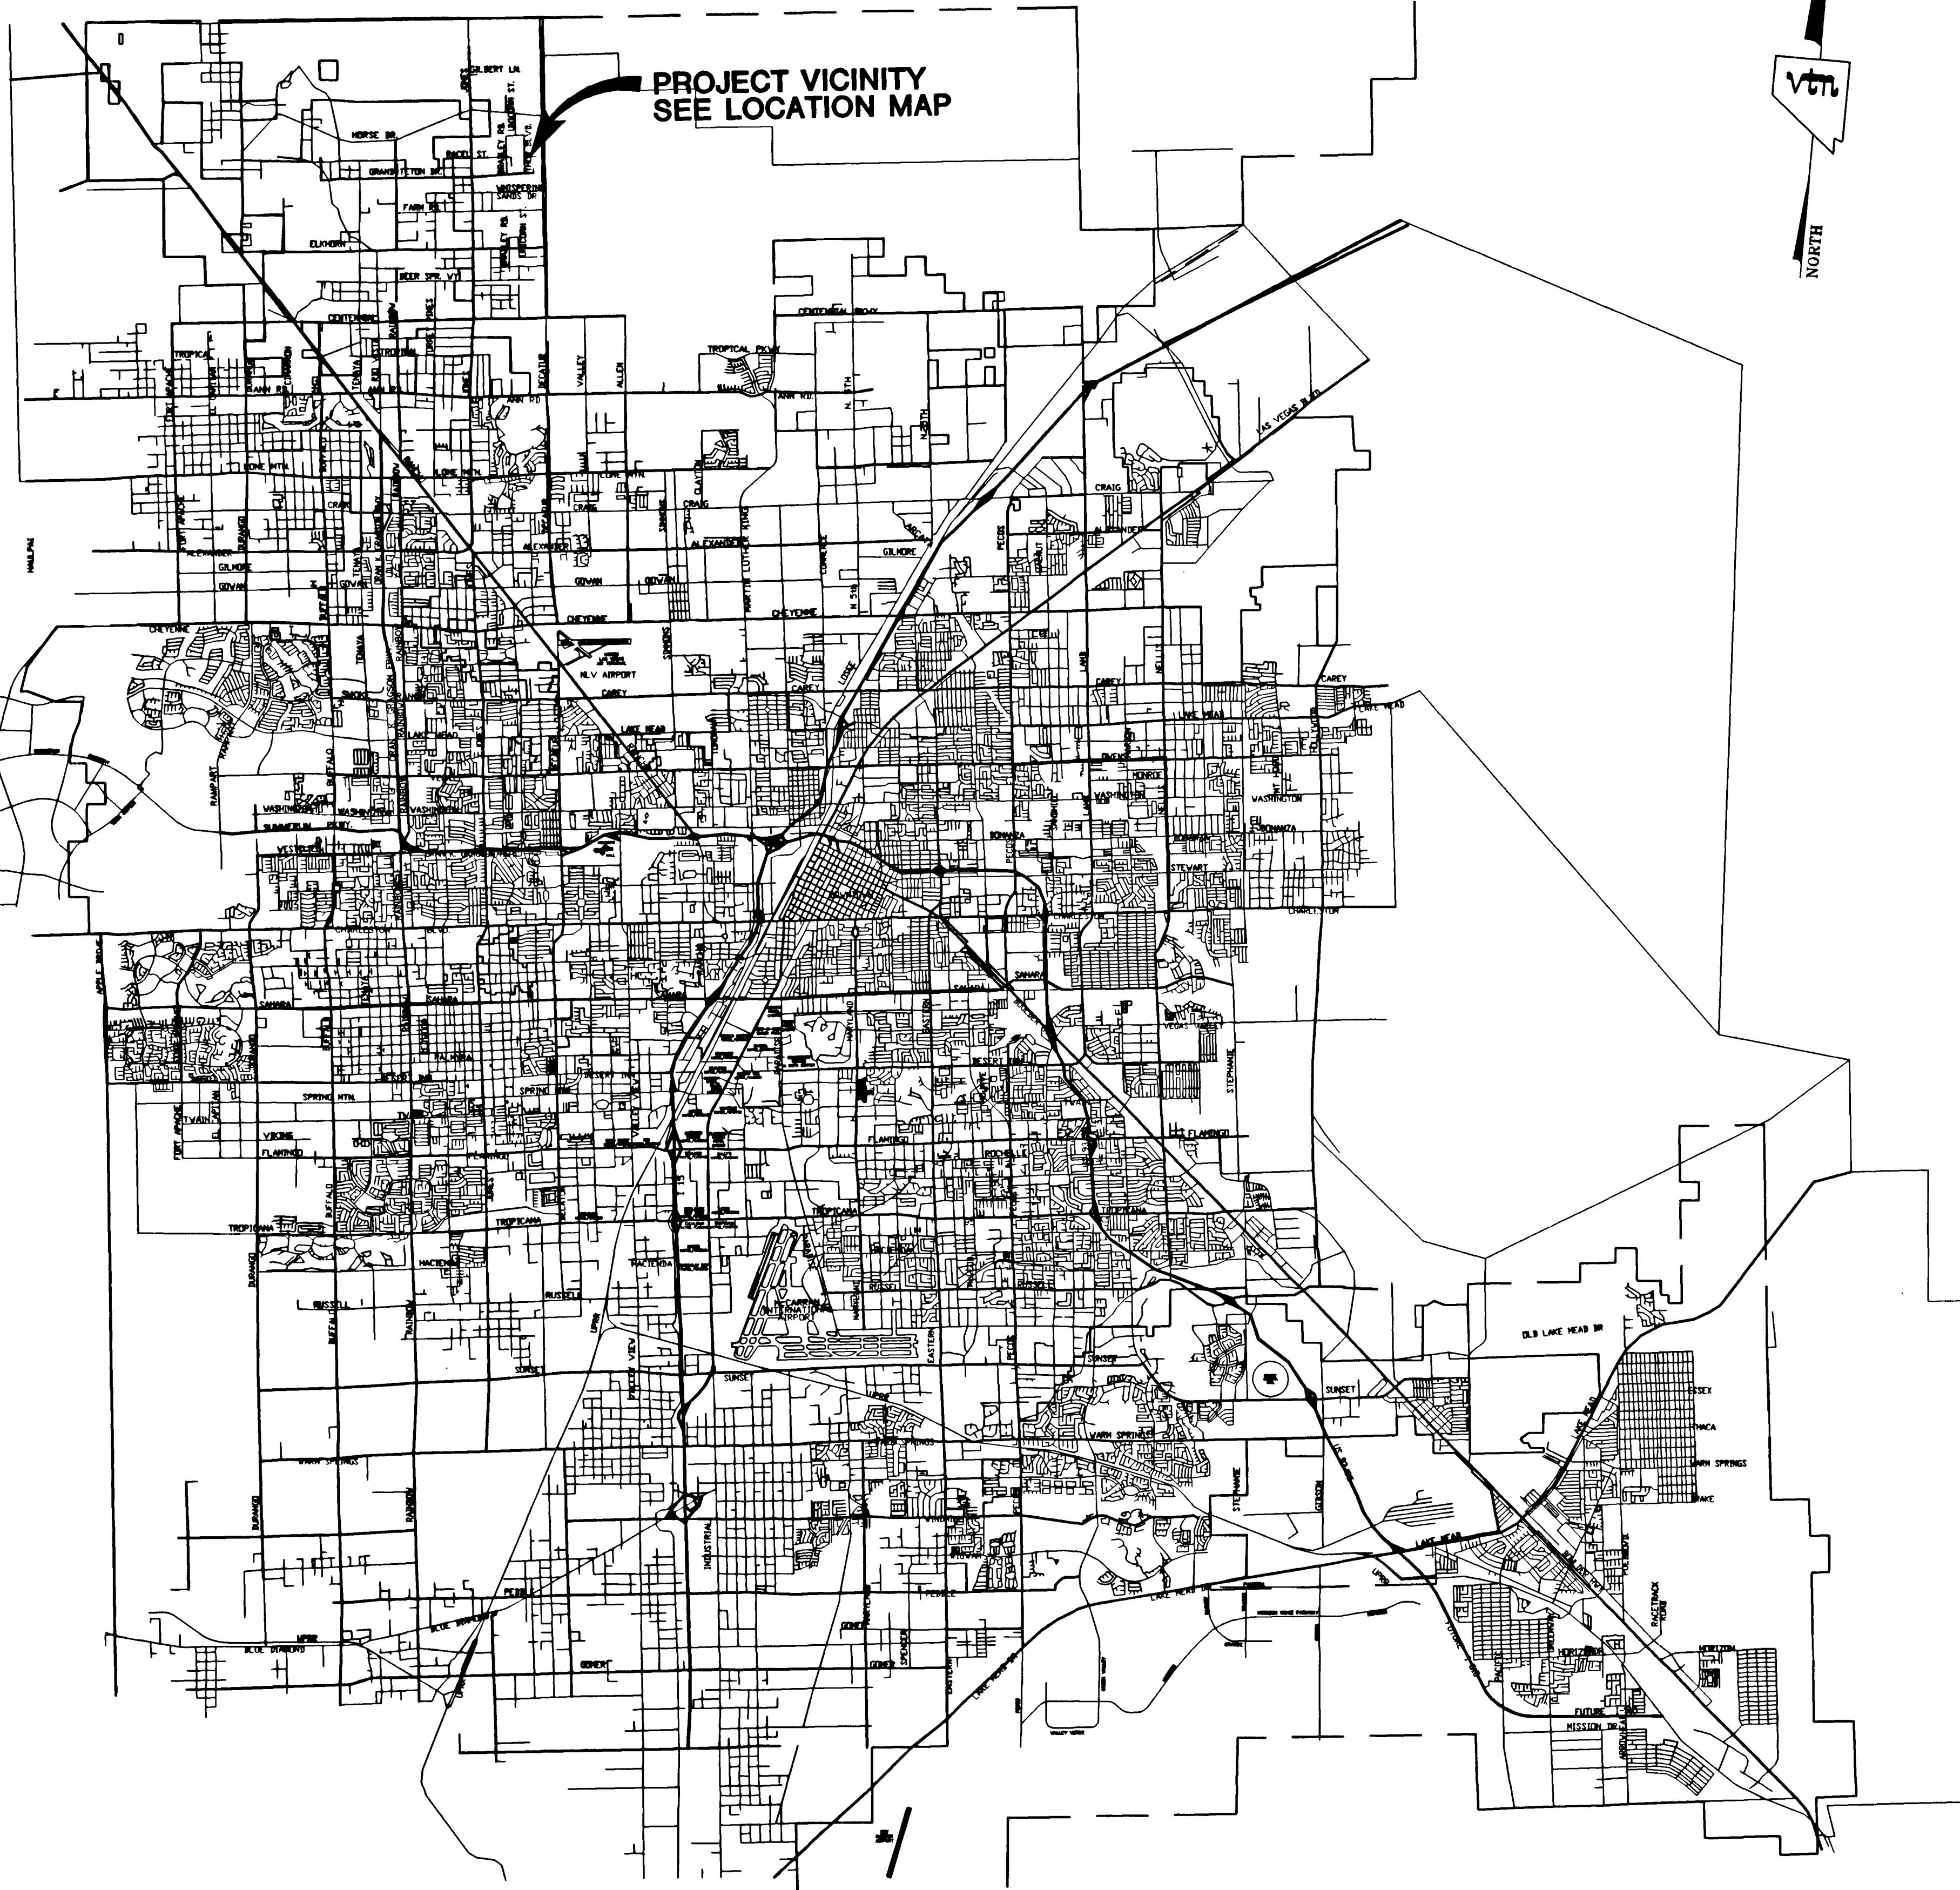

LOCATION MAP
NOT TO SCALE

SHEET INDEX

SHEET #	SHEET	DESCRIPTION
1	C1	COVER SHEET
2	C2	VICINITY MAP
3	C3	GENERAL NOTES SHEET
4	C4	QUANTITY AND SCHEDULE SHEET
5	C5	MASTER UTILITY PLAN
6	C6	MASTER UTILITY PLAN
7	G1	GRADING PLAN
8	G2	GRADING PLAN
9	G3	DETAIL SHEET
10	S1	STREET PLAN & PROFILE - JONES BOULEVARD STA:76+42.01 TO 84+50.00
11	S2	STREET PLAN & PROFILE - JONES BOULEVARD STA:84+50.00 TO 92+50.00
12	S3	STREET PLAN & PROFILE - VOSS TRAIL STREET
13	S4	STREET PLAN & PROFILE - HUFF MOUNTAIN AVENUE
14	S5	STREET PLAN & PROFILE - TURSIL LODGE COURT
15	S6	STREET PLAN & PROFILE - TAYLOR VALLEY AVENUE
16	TR1	TRAFFIC STRIPING AND - JONES BOULEVARD STREET LIGHTING PLAN
17	SS1	SEWER PLAN AND PROFILE - VOSS TRAIL STREET
18	SS2	SEWER PLAN AND PROFILE - HUFF MOUNTAIN AVENUE
19	SS3	SEWER PLAN AND PROFILE - TURSIL LODGE COURT
20	SD1	STORM DRAIN PLAN AND PROFILE- JONES BOULEVARD STA:23+72.95 TO 30+50.00
21	SD2	STORM DRAIN PLAN AND PROFILE- JONES BOULEVARD STA:30+50.00 TO 36+58.40
22	SD3	STORM DRAIN DROP INLET- JONES BOULEVARD PLAN AND PROFILES
23	SD4	STORM DRAIN PLAN AND PROFILE- JONES BOULEVARD STA:23+00.00 TO 16+50.00
24	SD5	STORM DRAIN PLAN AND PROFILE- JONES BOULEVARD STA:16+50.00 TO 10+00.00

APPROVED FOR CONSTRUCTION

Las Vegas Valley Water District

Date

KB HOME
750 PILOT ROAD, SUITE F
LAS VEGAS, NV 89119
(702) 814-2500

VICINITY MAP
IRON MOUNTAIN RANCH
VILLAGE 8
UNIT 2

DRAWN BY: JUNE 2002
DESIGNED BY: JUNE 2002
CHECKED BY: JUNE 2002
PROJECT NO: 8027-2
SCALE: N/A
HORIZ. VERT. N/A

PROFESSIONAL ENGINEER
KENNETH J. NICHOLSON
CIVIL
NO. 10539
EXPIRES 12-31-03

SHEET
C2
2 OF 24 SHEETS
DRAWING NO.
107-4604-B-2