



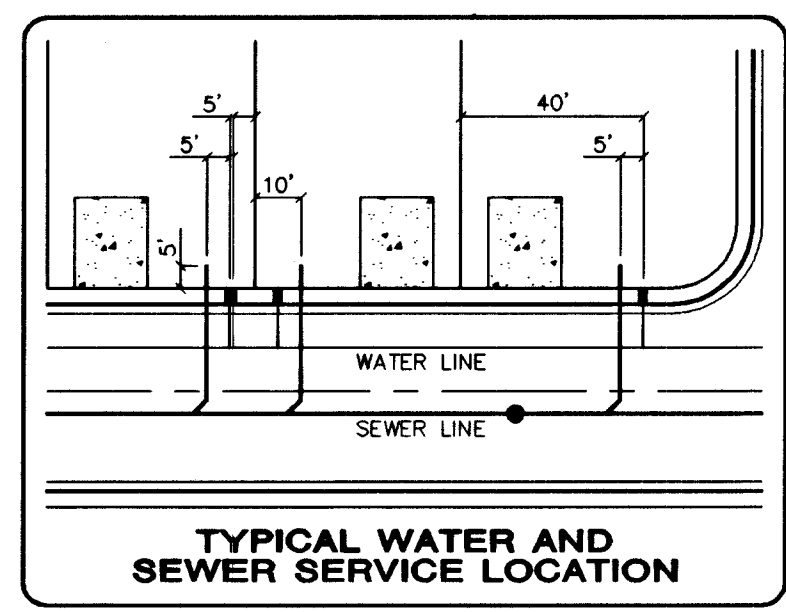

NEVADA POWER COMPANY	DATE
NEVADA POWER COMPANY APPROVAL IS ONLY FOR THE PLACEMENT AND CLEARANCE OF STREET LIGHT AND SIGNAL LIGHT INSTALLATION, AND CLEARANCE OF STREET LIGHT AND SIGNAL LIGHT INSTALLATION.	

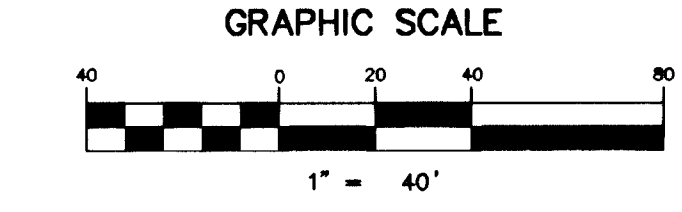

NOTE
SEE SHEET C5 FOR LEGEND AND QUANTITIES

	DRAWN BY: R.M.S.		MAY '02	KB HOME 7200 PILOT ROAD, SUITE F LAS VEGAS, NV 89119 (702) 614-2500  2727 SOUTH RAINBOW BOULEVARD LAS VEGAS, NEVADA 89146-5148 PH. (702) 873-7550 FAX (702) 362-2597 nevada CONSULTING ENGINEERS • PLANNERS • LAND SURVEYORS	
	DESIGNED BY: R.M.S.		MAY '02		
	CHECKED BY: KEN		MAY '02		
	PROJECT NO: 5972-1		SCALE: 1"=40' HORZ. 1"=10' VERT.		
	MASTER UTILITY PLAN AND STREET LIGHT PLAN				
	IRON MOUNTAIN RANCH VILLAGE 9 UNIT 1				
	CITY OF LAS VEGAS				
7					
6					
5					
4	1/26/04	KEN	RELEASE	SERVICE POINT	10/1/04
3	12/22/03	ECR	REMOVED	PROMO/ST SERVICE PT.	12/21/04
2	7/10/03	VDH	REVISED	STREET NAME	4/25/03-7/10/03
1	6/14/03	BDH	REVISED	STREET NAME	4/25/03
REV	DATE	BY			6/12/03