

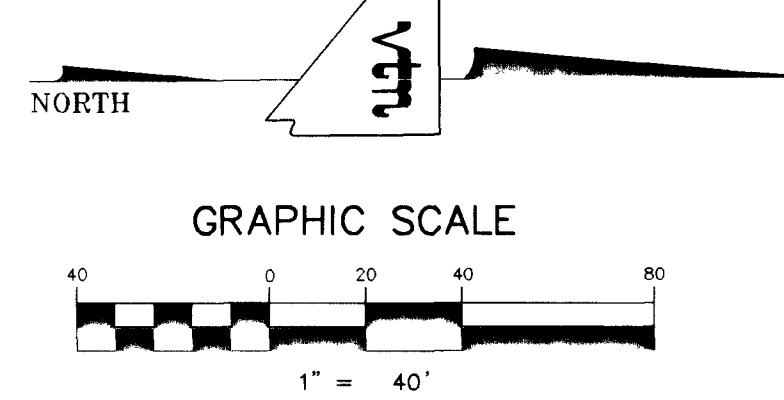
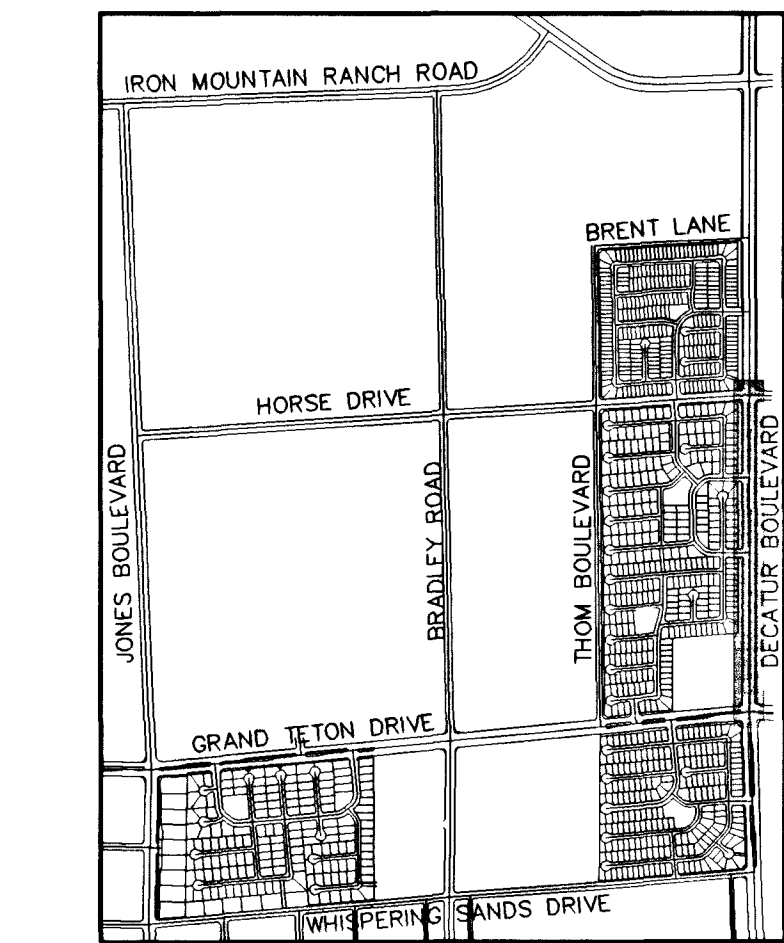


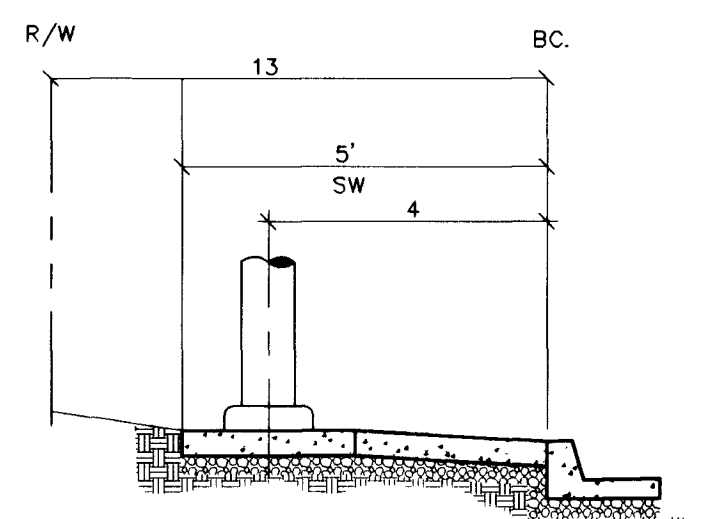

	SHEET TS2 18 of 33 SHEETS		DRAWING NO. 207X-4604-H	
	PROJECT NO: 5995		SCALE: 1" = 40' HORIZ. NA. VERT.	
	CHECKED BY: KFN		DESIGNED BY: R.M.S.	
	DRAWN BY: R.M.S.		AUG. '01 AUG. '01	
	DECATUR BOULEVARD STRIPING AND STREET LIGHTING PLAN		XB HOME 750 PILOT ROAD, SUITE F LAS VEGAS, NEVADA 89119 (702) 814-2500	
	IRON MOUNTAIN RANCH HORSE/ THOM/ DECATUR INFRASTRUCTURE		CITY OF LAS VEGAS 2727 SOUTH RAINBOW BOULEVARD LAS VEGAS, NEVADA 89146-5148 PH. (702) 873-7550 FAX (702) 362-2587 	
PROJECT NO: 5995		SCALE: 1" = 40' HORIZ. NA. VERT.		
CHECKED BY: KFN		DESIGNED BY: R.M.S.		
DRAWN BY: R.M.S.		AUG. '01 AUG. '01		
DECATUR BOULEVARD STRIPING AND STREET LIGHTING PLAN		XB HOME 750 PILOT ROAD, SUITE F LAS VEGAS, NEVADA 89119 (702) 814-2500		
IRON MOUNTAIN RANCH HORSE/ THOM/ DECATUR INFRASTRUCTURE		CITY OF LAS VEGAS 2727 SOUTH RAINBOW BOULEVARD LAS VEGAS, NEVADA 89146-5148 PH. (702) 873-7550 FAX (702) 362-2587 		
PROJECT NO: 5995		SCALE: 1" = 40' HORIZ. NA. VERT.		
CHECKED BY: KFN		DESIGNED BY: R.M.S.		
DRAWN BY: R.M.S.		AUG. '01 AUG. '01		
DECATUR BOULEVARD STRIPING AND STREET LIGHTING PLAN		XB HOME 750 PILOT ROAD, SUITE F LAS VEGAS, NEVADA 89119 (702) 814-2500		
IRON MOUNTAIN RANCH HORSE/ THOM/ DECATUR INFRASTRUCTURE		CITY OF LAS VEGAS 2727 SOUTH RAINBOW BOULEVARD LAS VEGAS, NEVADA 89146-5148 PH. (702) 873-7550 FAX (702) 362-2587 		
PROJECT NO: 5995		SCALE: 1" = 40' HORIZ. NA. VERT.		
CHECKED BY: KFN		DESIGNED BY: R.M.S.		
DRAWN BY: R.M.S.		AUG. '01 AUG. '01		
DECATUR BOULEVARD STRIPING AND STREET LIGHTING PLAN		XB HOME 750 PILOT ROAD, SUITE F LAS VEGAS, NEVADA 89119 (702) 814-2500		
IRON MOUNTAIN RANCH HORSE/ THOM/ DECATUR INFRASTRUCTURE		CITY OF LAS VEGAS 2727 SOUTH RAINBOW BOULEVARD LAS VEGAS, NEVADA 89146-5148 PH. (702) 873-7550 FAX (702) 362-2587 		
PROJECT NO: 5995		SCALE: 1" = 40' HORIZ. NA. VERT.		
CHECKED BY: KFN		DESIGNED BY: R.M.S.		
DRAWN BY: R.M.S.		AUG. '01 AUG. '01		
DECATUR BOULEVARD STRIPING AND STREET LIGHTING PLAN		XB HOME 750 PILOT ROAD, SUITE F LAS VEGAS, NEVADA 89119 (702) 814-2500		
IRON MOUNTAIN RANCH HORSE/ THOM/ DECATUR INFRASTRUCTURE		CITY OF LAS VEGAS 2727 SOUTH RAINBOW BOULEVARD LAS VEGAS, NEVADA 89146-5148 PH. (702) 873-7550 FAX (702) 362-2587 		
PROJECT NO: 5995		SCALE: 1" = 40' HORIZ. NA. VERT.		
CHECKED BY: KFN		DESIGNED BY: R.M.S.		
DRAWN BY: R.M.S.		AUG. '01 AUG. '01		
DECATUR BOULEVARD STRIPING AND STREET LIGHTING PLAN		XB HOME 750 PILOT ROAD, SUITE F LAS VEGAS, NEVADA 89119 (702) 814-2500		
IRON MOUNTAIN RANCH HORSE/ THOM/ DECATUR INFRASTRUCTURE		CITY OF LAS VEGAS 2727 SOUTH RAINBOW BOULEVARD LAS VEGAS, NEVADA 89146-5148 PH. (702) 873-7550 FAX (702) 362-2587 		
PROJECT NO: 5995		SCALE: 1" = 40' HORIZ. NA. VERT.		
CHECKED BY: KFN		DESIGNED BY: R.M.S.		
DRAWN BY: R.M.S.		AUG. '01 AUG. '01		
DECATUR BOULEVARD STRIPING AND STREET LIGHTING PLAN		XB HOME 750 PILOT ROAD, SUITE F LAS VEGAS, NEVADA 89119 (702) 814-2500		
IRON MOUNTAIN RANCH HORSE/ THOM/ DECATUR INFRASTRUCTURE		CITY OF LAS VEGAS 2727 SOUTH RAINBOW BOULEVARD LAS VEGAS, NEVADA 89146-5148 PH. (702) 873-7550 FAX (702) 362-2587 		
PROJECT NO: 5995		SCALE: 1" = 40' HORIZ. NA. VERT.		
CHECKED BY: KFN		DESIGNED BY: R.M.S.		
DRAWN BY: R.M.S.		AUG. '01 AUG. '01		
DECATUR BOULEVARD STRIPING AND STREET LIGHTING PLAN		XB HOME 750 PILOT ROAD, SUITE F LAS VEGAS, NEVADA 89119 (702) 814-2500		
IRON MOUNTAIN RANCH HORSE/ THOM/ DECATUR INFRASTRUCTURE		CITY OF LAS VEGAS 2727 SOUTH RAINBOW BOULEVARD LAS VEGAS, NEVADA 89146-5148 PH. (702) 873-7550 FAX (702) 362-2587 		
PROJECT NO: 5995		SCALE: 1" = 40' HORIZ. NA. VERT.		
CHECKED BY: KFN		DESIGNED BY: R.M.S.		
DRAWN BY: R.M.S.		AUG. '01 AUG. '01		
DECATUR BOULEVARD STRIPING AND STREET LIGHTING PLAN		XB HOME 750 PILOT ROAD, SUITE F LAS VEGAS, NEVADA 89119 (702) 814-2500		

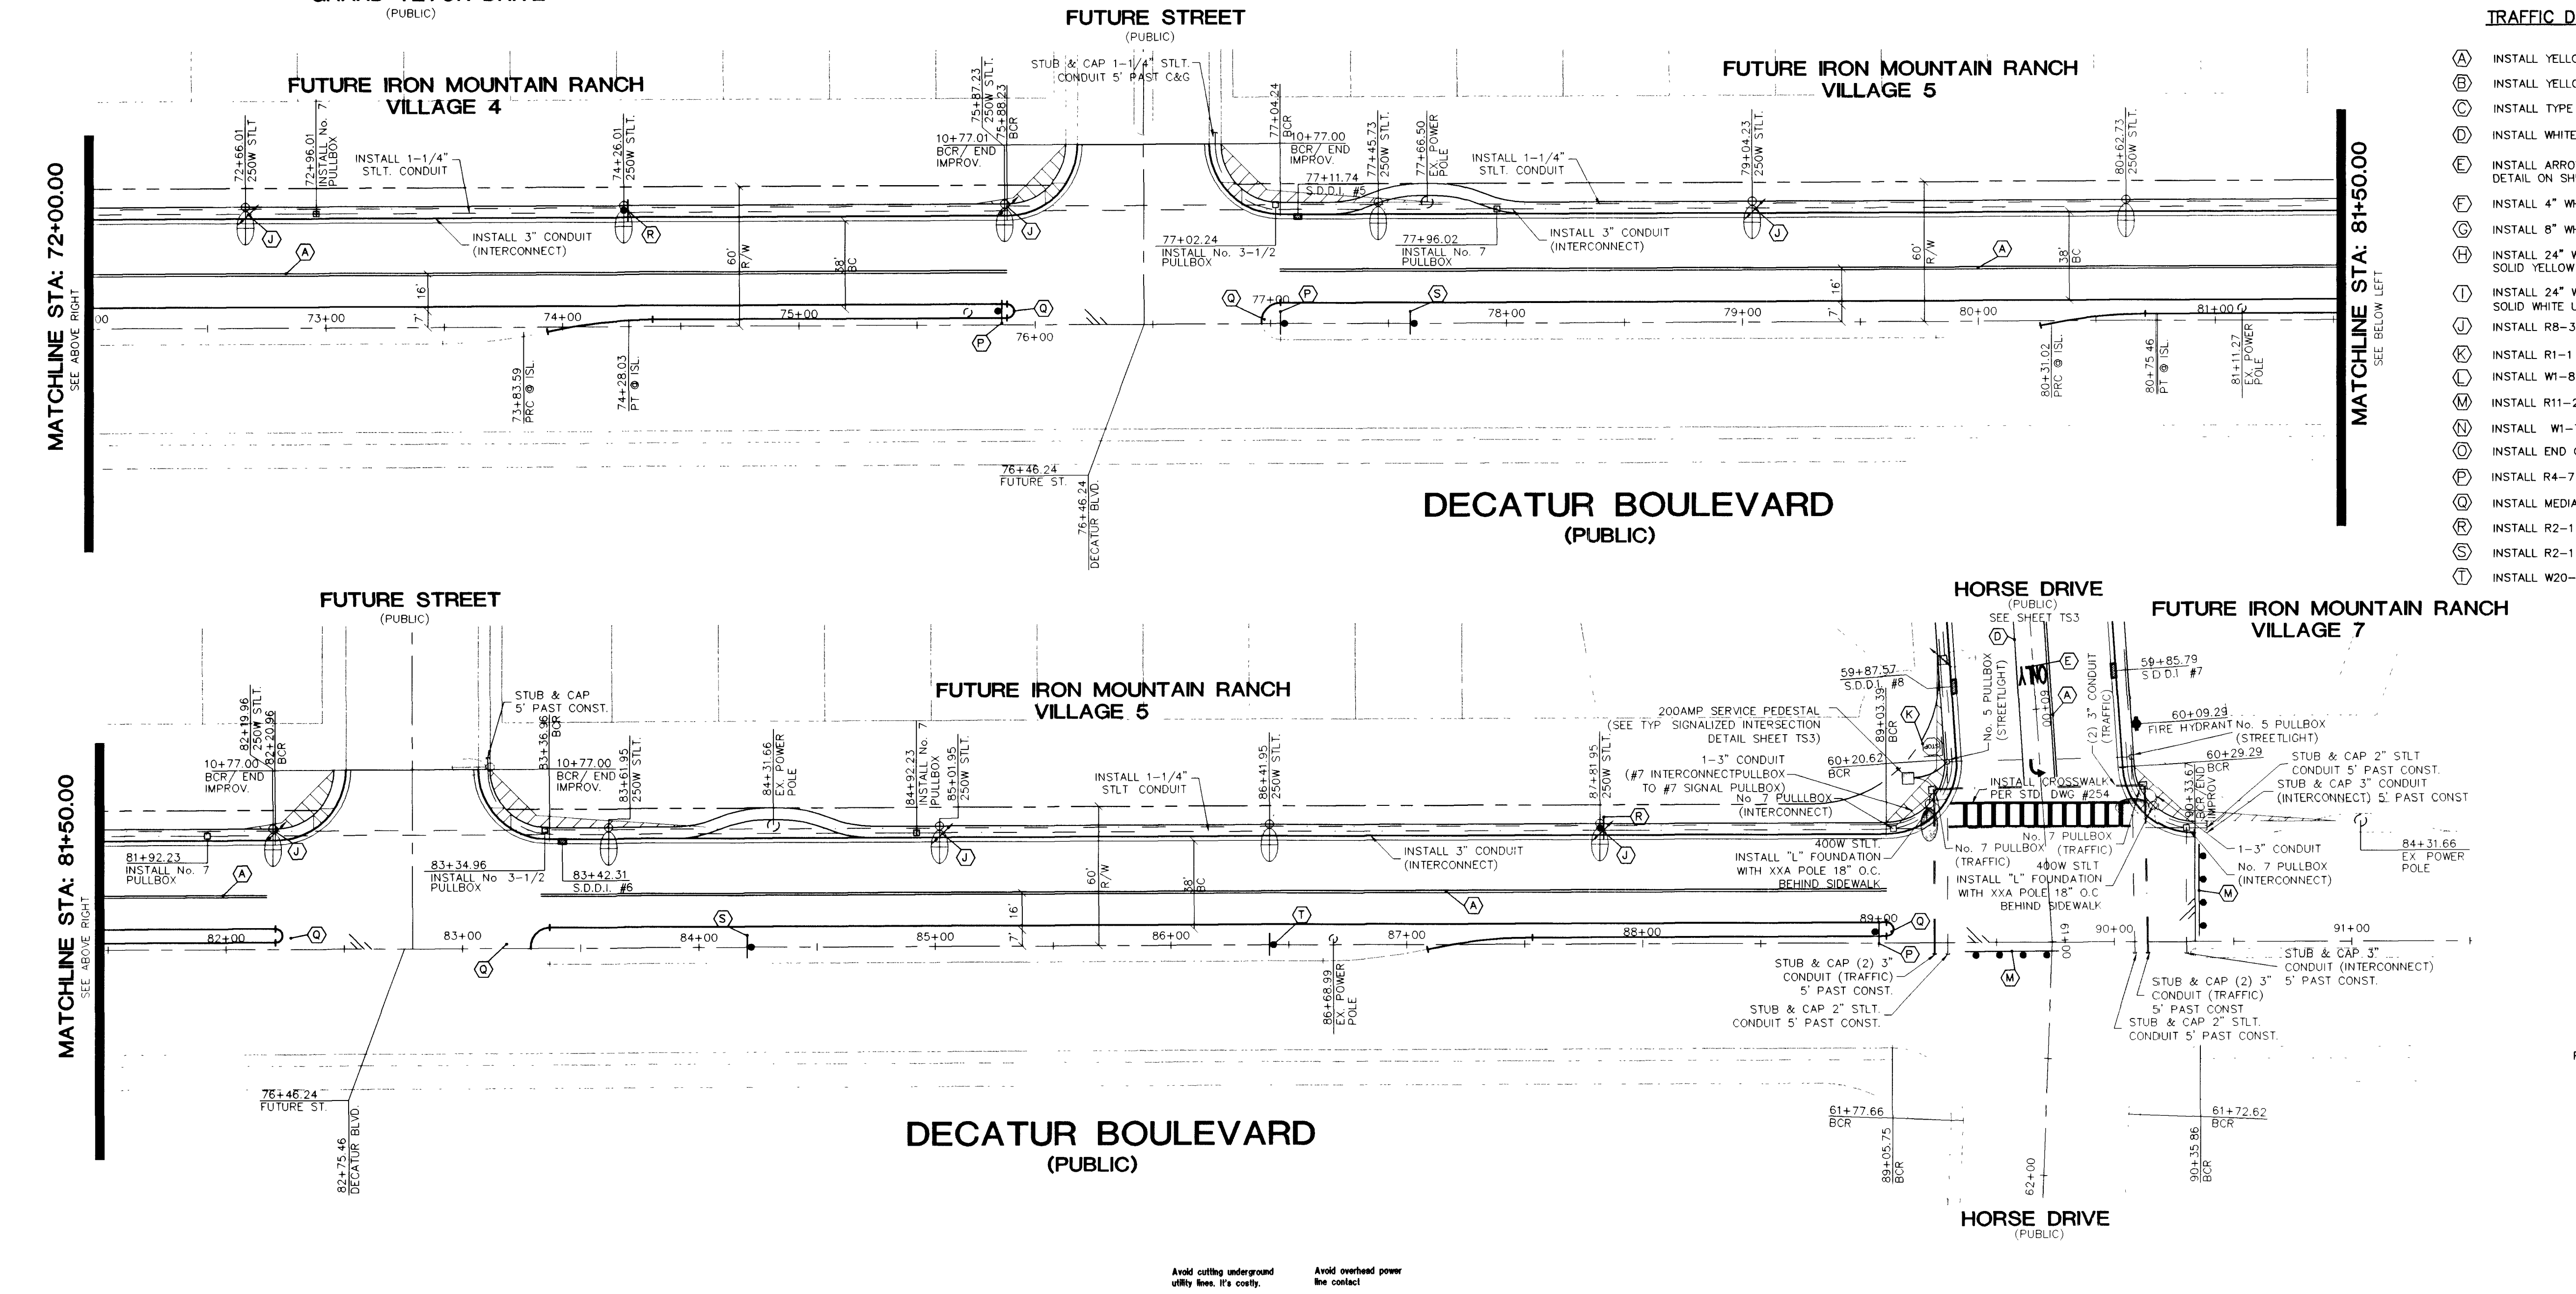

STREET LIGHT DETAIL

NOTE: CONTRACTOR SHALL VERIFY HORIZONTAL AND VERTICAL LOCATION OF EXISTING UTILITIES AND NOTIFY THE DESIGN ENGINEER IMMEDIATELY OF ANY DISCREPANCIES PRIOR TO CONSTRUCTION.