


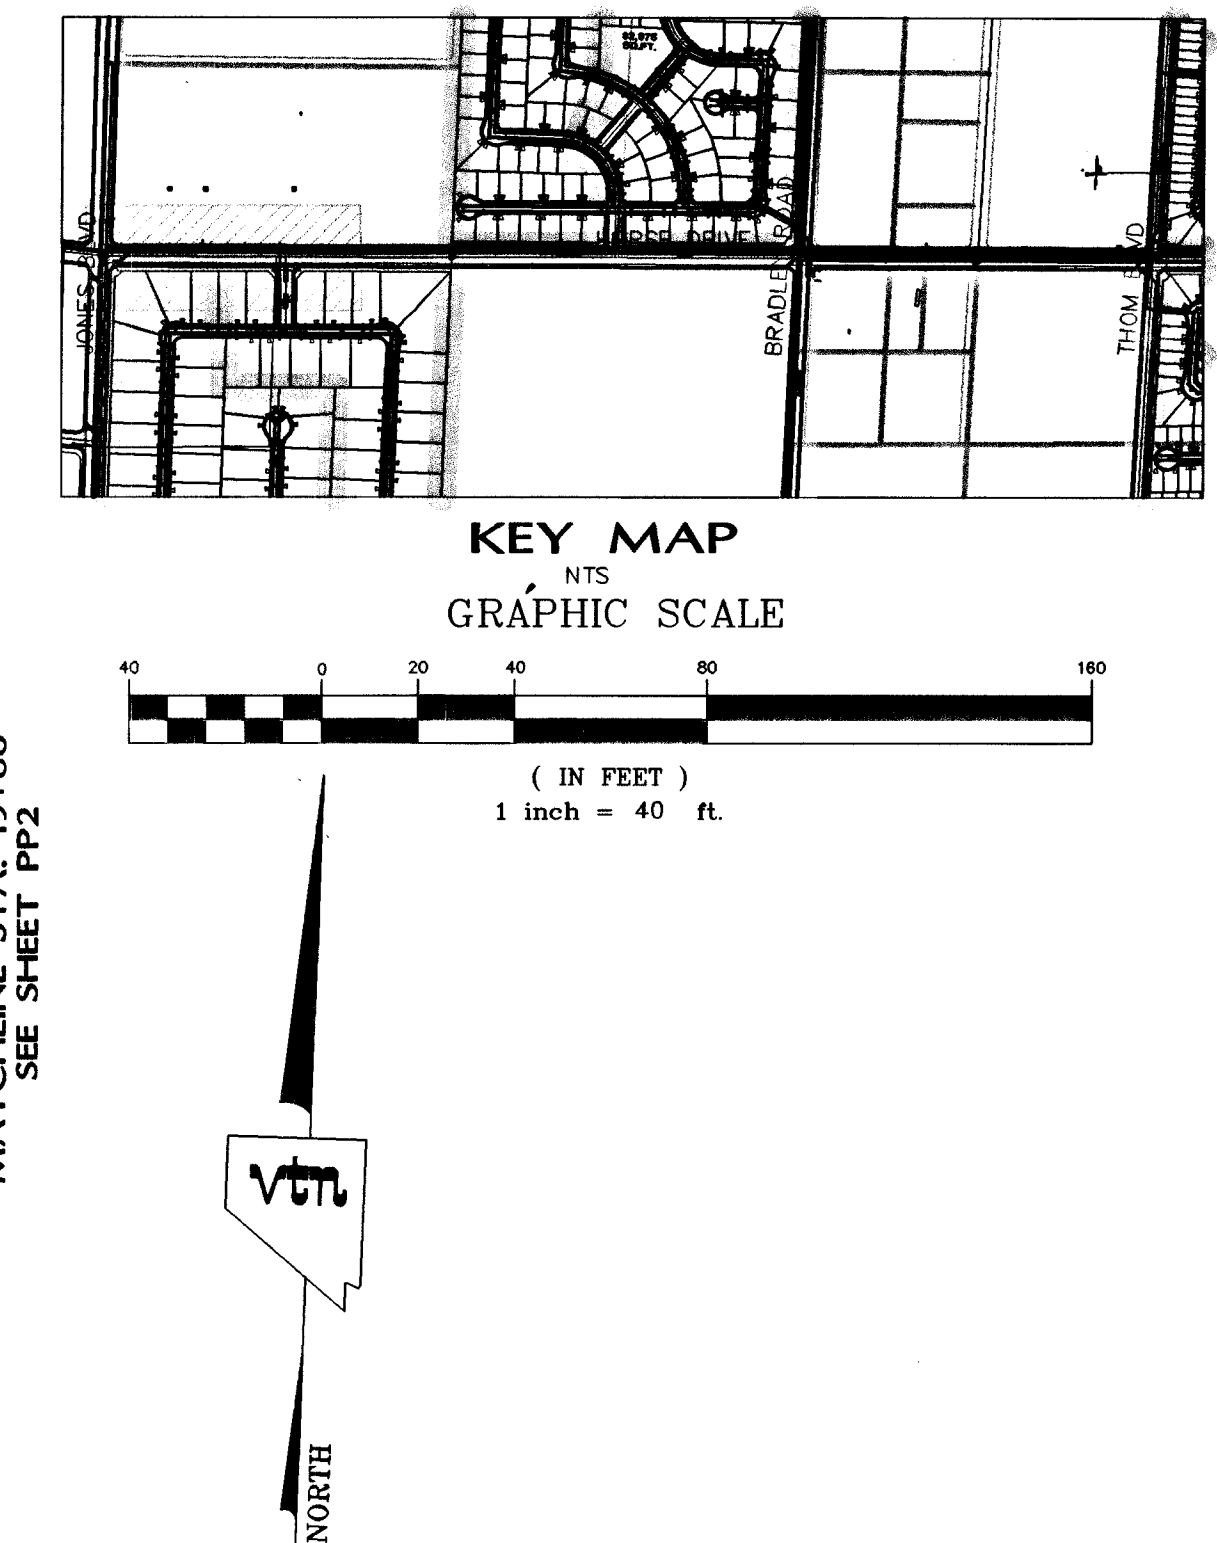

CONDITIONAL APPROVAL OF VALVED OUTLETS(6" AND LARGER)

THE WATER PLANS SHOW ONE OR MORE VALVED OUTLETS EXTENDING OUT OF PAVED AREAS. INSTALLATION OF THESE OUTLETS IS ACCEPTABLE, HOWEVER, IF THE OUTLETS ARE INCORRECTLY LOCATED OR NOT USED FOR ANY REASON WHEN THE PROPERTY IS ACTUALLY OCCUPIED, THE DEVELOPER SHALL ABANDON THE OUTLETS AT THE CONNECTION TO THE ACTIVE MAIN IN ACCORDANCE WITH THE DISTRICT'S STANDARDS AND AT THE DEVELOPER'S EXPENSE.

APPROVAL OF THESE PLANS FOR THE SERVICE LATERALS & METERS TO FUTURE LOTS WILL NOT BE CONSTRUED AS A COMMITMENT TO WATER SERVICES FOR THESE PROPERTIES.

NO FIRE HYDRANTS ON THIS SHEET

CITY OF LAS VEGAS FIRE DEPARTMENT

DATE

NOTE
RESTRAIN ALL JOINTS (U.D.A.C.S. STD.
PLATE 5 MAY ALSO BE USED)
FROM STA. 10+00.00 TO STA. 11+15.00
FROM STA. 12+05.00 TO STA. 14+35.00

NEW PVC DATA
DR 18 C-905
O.D. = 21.6 INCHES
THICKNESS = 0.86 INCHES

CONTRACTOR SHALL FIELD LOCATE AND PROTECT ALL SNWA/SNWS APPEARANCES INCLUDING, BUT NOT LIMITED TO A/VAR, ACCESS MANWAYS AND CATHODIC PROTECTION SYSTEMS. ALL ABOVE GROUND STRUCTURES AND AT GRADE STRUCTURES MUST BE ADJUSTED TO NEW GRADE AT CONTRACTOR'S EXPENSE. CATHODIC PROTECTION TEST STATIONS, RECTIFIERS, AND A/VAR's MUST BE RELOCATED TO THE SIDEWALK PER SNWA STANDARDS AT THE CONTRACTOR'S EXPENSE. CONTRACTOR TO NOTIFY SOUTHERN NEVADA WATER AUTHORITY, DEVELOPMENT PLAN REVIEW, AT (702) 862-3444 AT LEAST 48 HOURS PRIOR TO CONSTRUCTION ACTIVITY.

SNWA APPROVAL IS VALID FOR ONE (1) YEAR FROM THE SIGNATURE DATE. IF CONSTRUCTION WITHIN THE EASEMENT OR RESTRICTED PIPE SAFETY ZONE IS NOT COMPLETE, PLANS MUST BE RESUBMITTED TO SNWA FOR APPROVAL.

Leanne Mills 6/26/02
SOUTHERN NEVADA WATER AUTHORITY DATE

SOUTHERN NEVADA WATER AUTHORITY (SNWA) FACILITIES ARE LOCATED IN THE AREA OF THIS PROJECT AND IT IS REQUIRED THAT THEY BE INCLUDED IN THE COORDINATION AND APPROVAL PROCESS PRIOR TO DISTRICT SIGNATURE. IF YOU HAVE NOT ALREADY DONE SO, YOU MAY CONTACT SNWA AT:

SOUTHERN NEVADA WATER AUTHORITY
1900 E. FLAMINGO RD., SUITE 170
LAS VEGAS, NV 89119
(702) 862-3444
FAX (702) 862-3485

Avoid cutting underground utility lines. It's costly.

Call before you Dig

1-800-227-2600

UNDERGROUND SERVICE (USA)

APPROVED FOR CONSTRUCTION *1st app'd 5/15/02*
[Signature] *6/28/02*
 LAS VEGAS VALLEY WATER DISTRICT DATE

		SHEET PP1 4 OF 40 SHEETS DRAWING NO. 10744004-420			
DRAWN BY: DZM	SEPT 2001	20" WATER MAIN PLAN AND PROFILE STA 10+00 THRU STA 19+00 IRON MOUNTAIN RANCH HORSE DRIVE			
DESIGNED BY: CRG/DZM	SEPT 2001				
CHECKED BY: CRG	SEPT 2001				
PROJECT NO: 6001	SCALE: 1"=40' HORIZ. 1"=5' VERT.				
TITLE		KB HOME 750 PILOT ROAD, SUITE F LOS VEGAS, NEVADA 89119 (702) 614-2500			
SHEET		2727 SOUTH RAINBOW BOULEVARD LAS VEGAS, NEVADA 89146-5148 PH. (702) 873-7550 FAX (702) 362-2597 nevada CONSULTING ENGINEERS • PLANNERS • LAND SURVEYORS			
REVISION		REV	DATE	BY	FIELD CONDITIONS SEE SHEET 10744004-420 REVISION THIS 7/18/01
REVISION		REV	DATE	BY	REVISION 20" CONNECTION TO MATCH

5825\5825-X-PP.DWG
original/Returned