

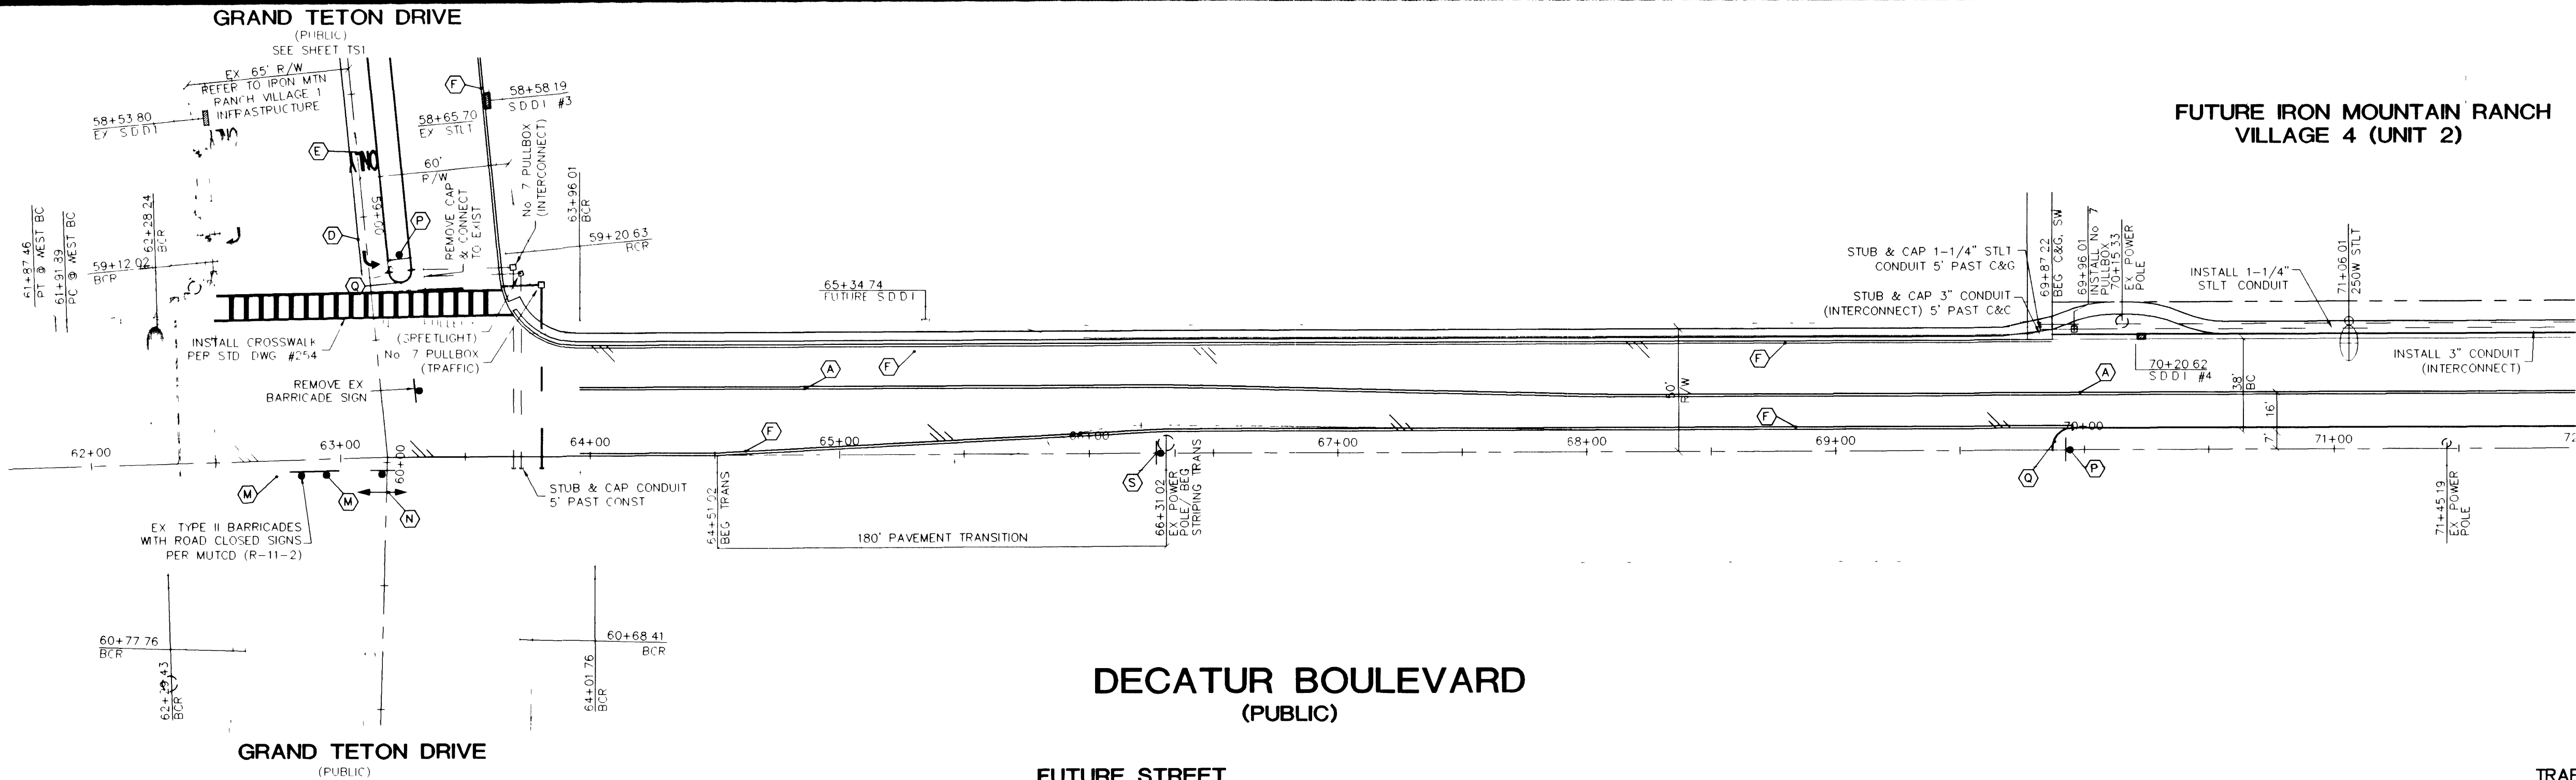


DECATUR BOULEVARD
(PUBLIC)
REFER TO IRON MOUNTAIN RANCH VILLAGE 1
INFRASTRUCTURE IMPROVEMENT PLANS PER VTN NV

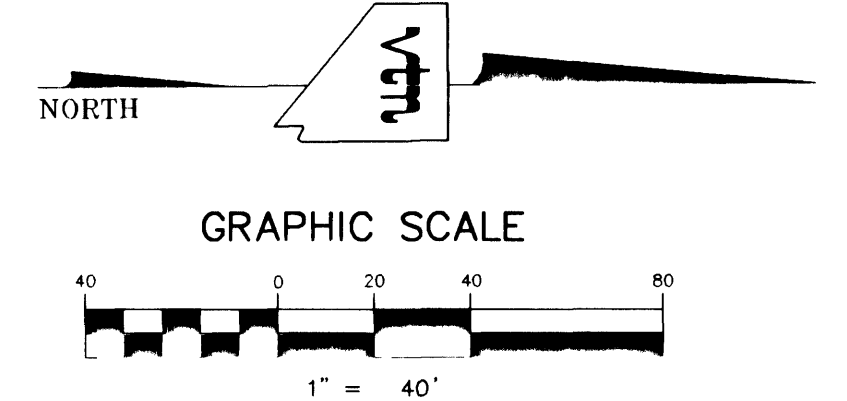


MATCHLINE STA: 72+00.00
SEE BELOW LEFT

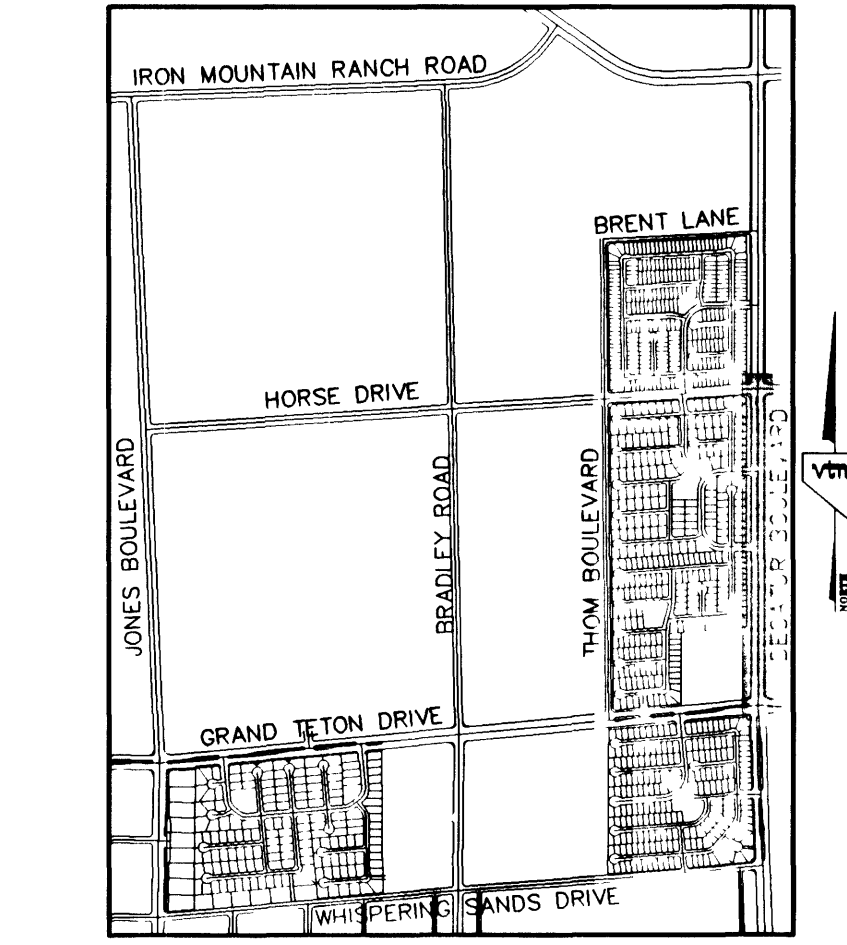

TRAFFIC DELINEATION AND SIGNAGE LEGEND



- (A) INSTALL YELLOW TYPE 1 CENTERLINE DELINEATION PER USD #244
- (B) INSTALL YELLOW TYPE 2 CENTERLINE DELINEATION PER USD #244
- (C) INSTALL TYPE 4 LANE LINE DELINEATION PER USD #244
- (D) INSTALL WHITE TURN LANE STORAGE LINE PER USD #246
- (E) INSTALL ARROWS & "ONLY" USING WHITE COLD POLYMER FILM. SEE TYPICAL SPACING DETAIL ON SHEET TS3
- (F) INSTALL 4" WHITE PAINTED EDGE LINE
- (G) INSTALL 8" WHITE PAINTED EDGE LINE
- (H) INSTALL 24" WIDE YELLOW DIAGONALS AT 25'oc USING COLD POLYMER FILM. TAPE SOLID YELLOW UNTIL TYPE 1 CENTERLINE ARE 5' APART
- (I) INSTALL 24" WIDE WHITE CHEVRONS AT 25'oc USING COLD POLYMER FILM. TAPE SOLID WHITE UNTIL TYPE 1 CENTERLINE ARE 5' APART
- (J) INSTALL R8-3A "NO PARKING" SIGNS
- (K) INSTALL R1-1 "STOP" SIGN & (2) D3 "STREET NAME" SIGNS
- (L) INSTALL W1-8 "CHEVRON" SIGNS @ 25'oc (TYP.)
- (M) INSTALL R11-2 (TYPE III) BARRICADES WITH ROAD CLOSED SIGN
- (N) INSTALL W1-7 "DOUBLE ARROW" SIGN
- (O) INSTALL END OF ROAD MARKERS (TYP.)
- (P) INSTALL R4-7 (KEEP RIGHT) SIGN
- (Q) INSTALL MEDIAN NOSE MARKINGS PER USD #248
- (R) INSTALL R2-1 (35 MPH) SIGN
- (S) INSTALL R2-1 (25 MPH) SIGN
- (T) INSTALL W20-3 (STREET CLOSED AHEAD) SIGN

MATCHLINE STA: 72+00.00
SEE ABOVE RIGHT

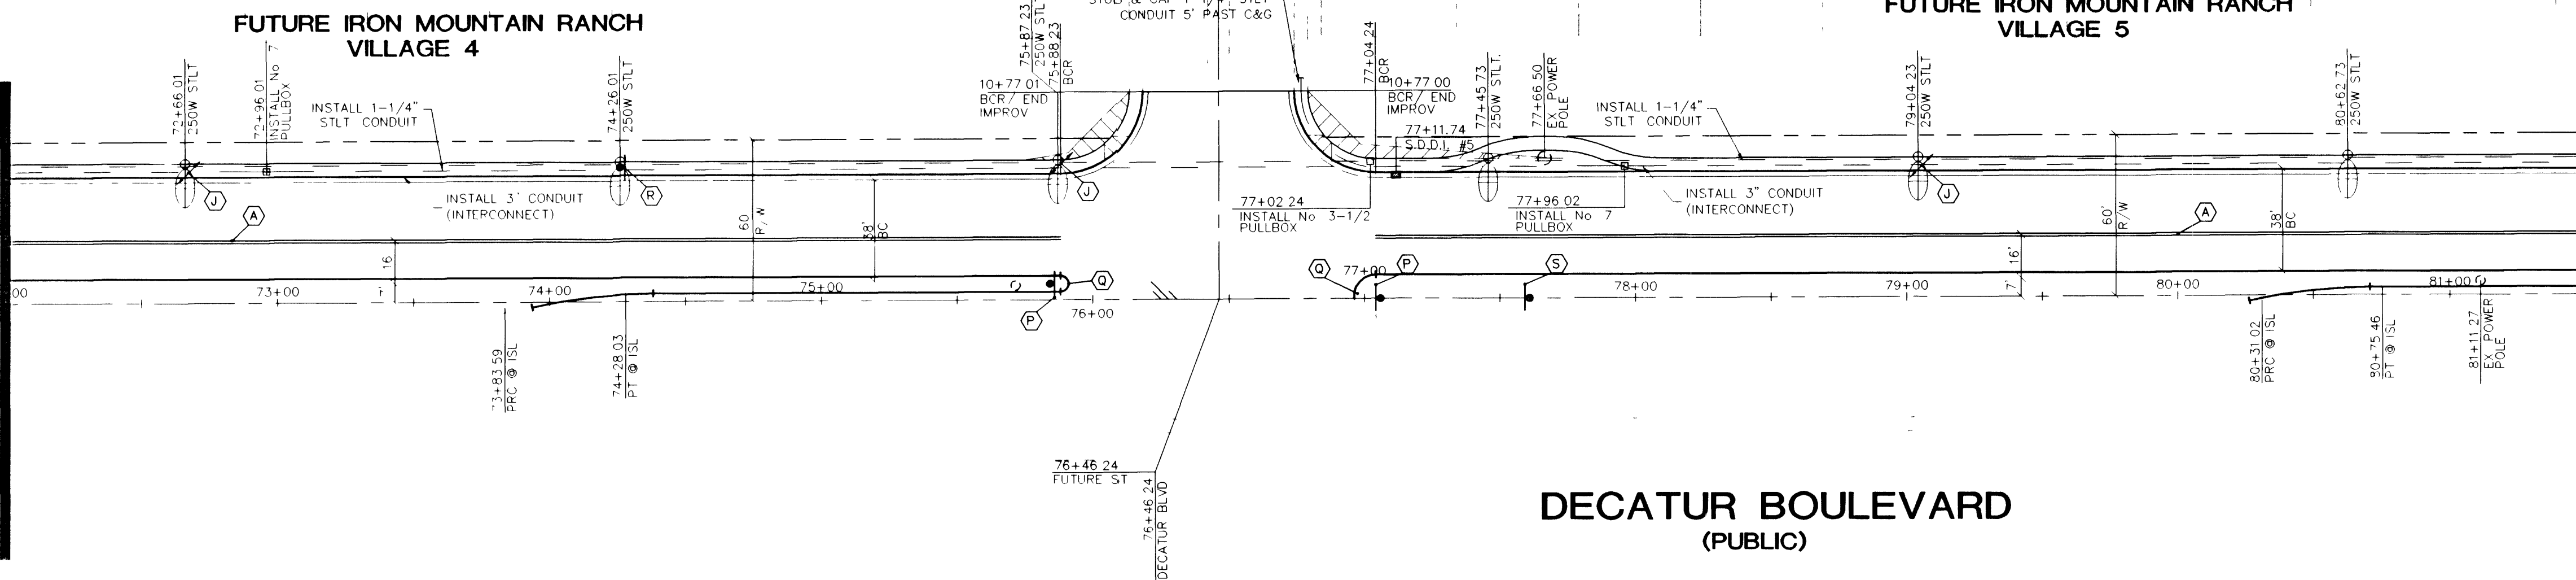

MATCHLINE STA: 81+50.00
SEE BELOW LEFT

MATCHLINE STA: 81+50.00
SEE ABOVE RIGHT

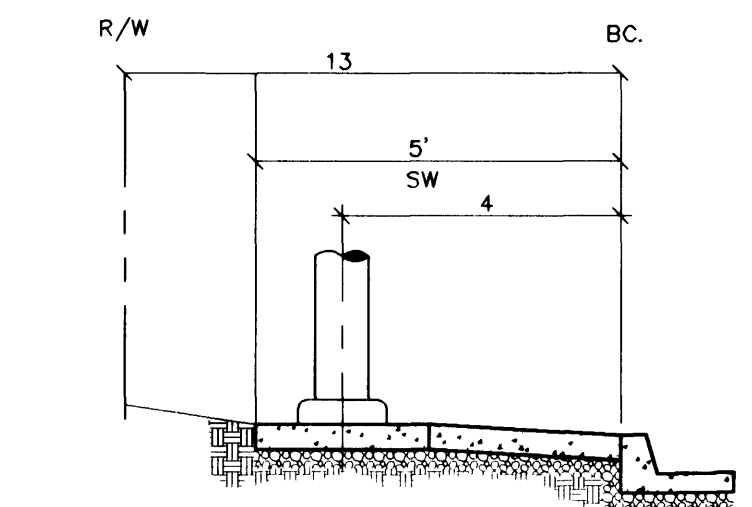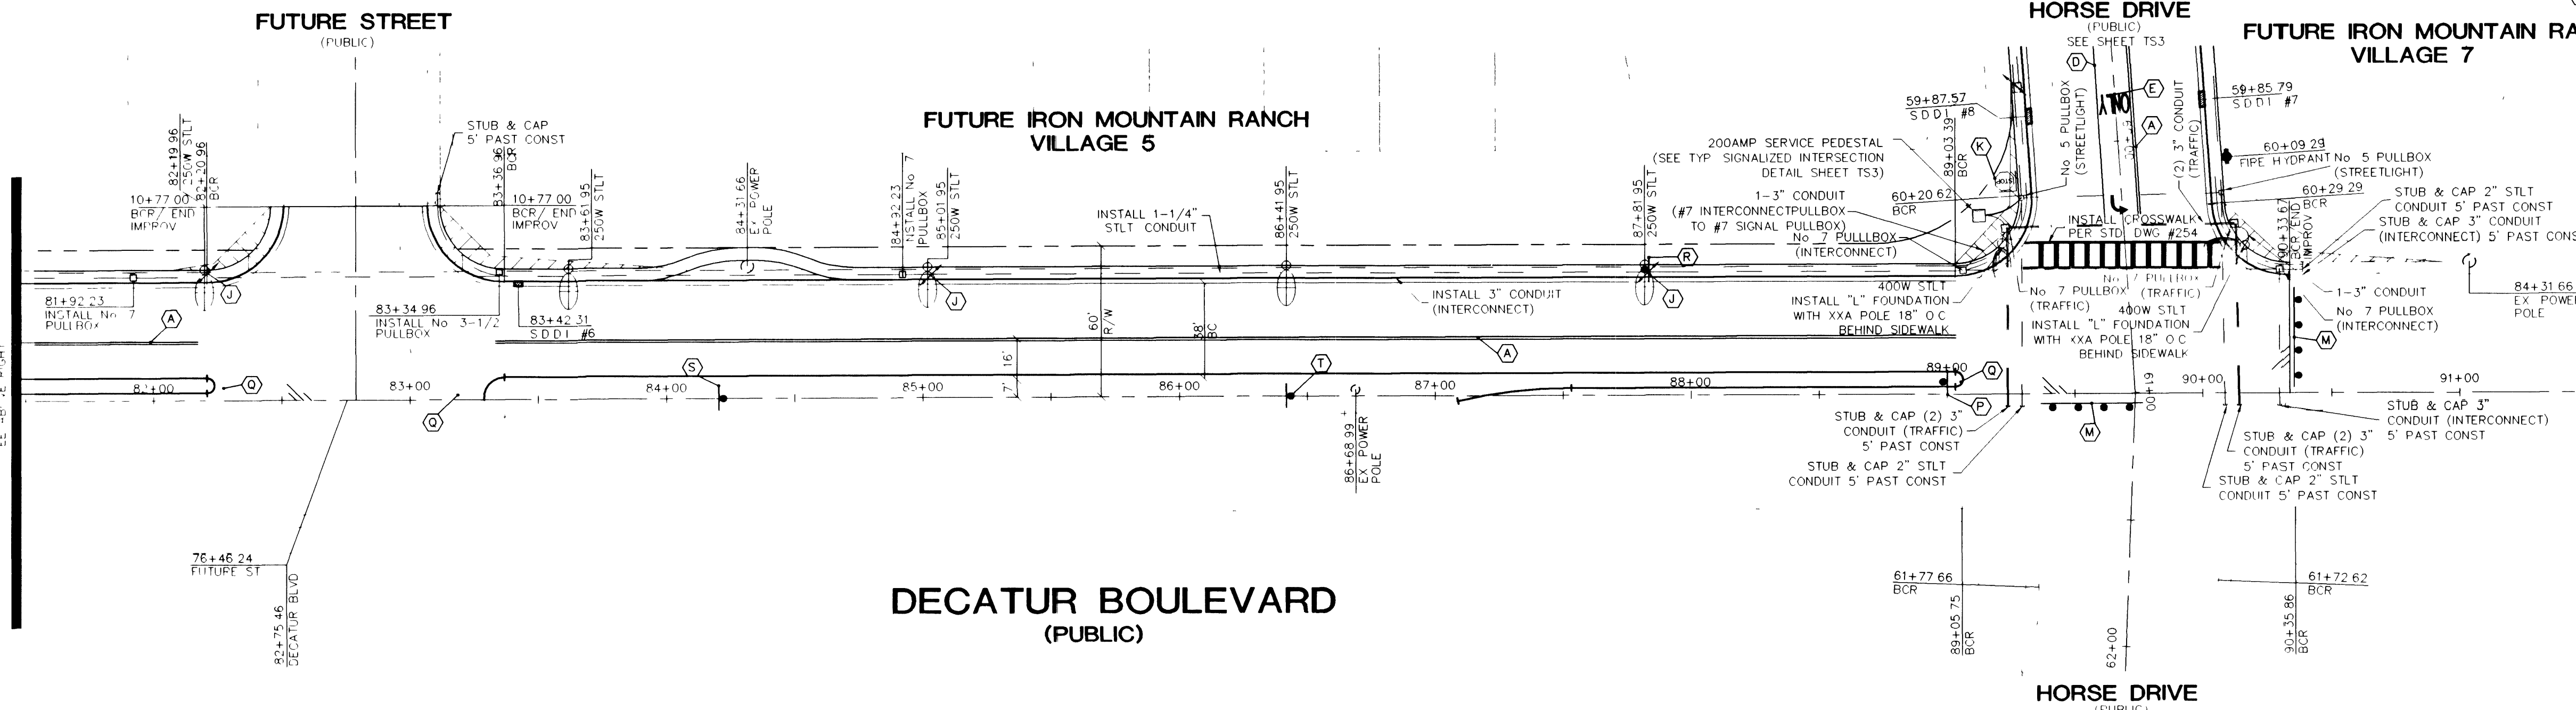

BENCHMARK
PROJECT DATUM NAVD88
CITY OF LAS VEGAS BENCHMARK 1LV90-13NES
NAVD88 ELEVATION 710.9608 METERS (2332.54 FEET)
ONLY B.M. 413148, DECATUR BLVD & GRAND TETON DRIVE
100' SW OF SECTION CORNER, NEXT TO METAL POWER POLE

BASIS OF BEARINGS
THE BASIS OF BEARINGS FOR THIS PROJECT IS GRID NORTH AS DEFINED
BY THE NEVADA COORDINATE SYSTEM OF 1983 (NCS83), EAST ZONE, (2701).
DETERMINED BY CLARK COUNTY GIS CONTROL POINTS 802, 803, 804, AND 805.
AS SHOWN ON A RECORD OF SURVEY ON FILE N IN THE CLARK COUNTY, NEVADA,
RECORDER'S OFFICE, IN BOOK 88 OF SURVEYS, AT PAGE 53.

Call before you Dig
1-800-227-2600

Call before you Overhead
1-702-593-6111

NOTE: CONTRACTOR SHALL VERIFY HORIZONTAL AND VERTICAL LOCATION OF EXISTING UTILITIES AND NOTIFY THE DESIGN ENGINEER IMMEDIATELY OF ANY DISCREPANCIES PRIOR TO CONSTRUCTION.

CITY OF LAS VEGAS

KB HOME
750 PILOT ROAD SUITE F
LAS VEGAS, NEVADA 89119
(702) 814-2500

DECATUR BOULEVARD
STRIPING AND
STREET LIGHTING PLAN

IRON MOUNTAIN RANCH
HORSE/ THOM/ DECATUR
INFRASTRUCTURE

DRAWN BY: AUG. '01
R.M.S.
DESIGNED BY: AUG. '01
R.M.S.
CHECKED BY: AUG. '01
KFN
PROJECT NO.: 5995
SCALE: 1"=40' HORZ.
VERT.

PROFESSIONAL ENGINEER
KENNETH A. NICHOLSON
10539 WYOMING
12/14/11

SHEET
TS2
18 OF 33 SHEETS
DRAWING NO.
207X-4604-H

H:\5407\VILLAGE\INFRA\5995TR.DWG (TS2)