


AVOID CUTTING UNDERGROUND UTILITY LINES. IT'S COSTLY.
Call before you Dig—
1-800-227-2600
UNDERGROUND SERVICE ALERT (USA)

AVOID OVERHEAD POWER LINE CONTACT
Call before you OVERHEAD
1-702-593-6111
NATIONAL POWER LINE SAFETY SERVICE



DELTA ENGINEERING ASSUMES NO RESPONSIBILITY FOR EXISTING UTILITY LOCATIONS AND ELEVATIONS. THE UTILITIES SHOWN ON THIS DRAWING HAVE BEEN PLOTTED FROM THE BEST AVAILABLE INFORMATION. IT IS, HOWEVER, THE CONTRACTOR'S RESPONSIBILITY TO FIELD VERIFY THE LOCATION AND ELEVATION OF ALL UTILITIES PRIOR TO THE COMMENCEMENT OF ANY CONSTRUCTION. CONTRACTOR TO FIELD VERIFY ALL EXISTING SITE CONDITIONS PRIOR TO CONSTRUCTION. IF A CONFLICT EXISTS BETWEEN WHAT IS SHOWN ON THESE DRAWINGS AND WHAT EXISTS IN THE FIELD, THE CONTRACTOR IS TO NOTIFY THE ARCHITECT, OWNER'S REPRESENTATIVE OR ENGINEER IMMEDIATELY.

GRADING NOTES
1. ALL STATIONING IS CENTERLINE OF ROAD AND PERPENDICULAR TO ROAD CENTERLINE, UNLESS SPECIFICALLY SHOWN OTHERWISE.

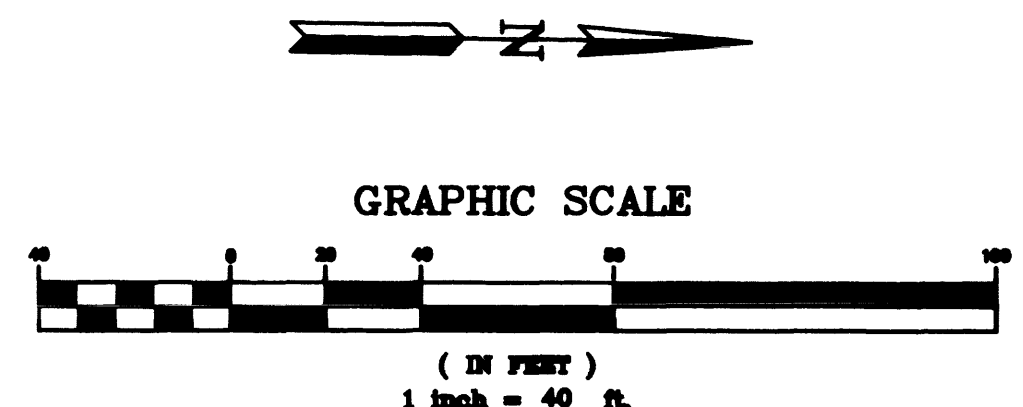

As Built Notes
ADDED

LEGEND	
EXISTING	PROPOSED
RIGHT-OF-WAY	RIGHT-OF-WAY
PROPERTY LINE	PROPERTY LINE
CENTERLINE	CENTERLINE
WATER LINE	WATER LINE
SANITARY SEWER LINE	SANITARY SEWER LINE
GAS LINE	GAS LINE
STORM DRAIN	STORM DRAIN
POWER LINE/POWER POLE	POWER LINE/POWER POLE
TELEPHONE LINE	TELEPHONE LINE
FIRE HYDRANT	FIRE HYDRANT
WATER VALVE	WATER VALVE
METERS/PULL BOXES	METERS/PULL BOXES
REDUCER	REDUCER
MANHOLE	MANHOLE
CLEANOUT	CLEANOUT
CONTOUR	CONTOUR
A.C. PAVING	A.C. PAVING
TYPE "L" CURB & GUTTER	TYPE "L" CURB & GUTTER
TYPE "A" CURB	TYPE "A" CURB
CONCRETE	CONCRETE
RETAINING WALL	RETAINING WALL
CHAIN LINK FENCE	CHAIN LINK FENCE
GRADE BREAK	GRADE BREAK
WIRE FENCE	WIRE FENCE
FINISH FLOOR	FINISH FLOOR
C.O. INV.	C.O. INV.
C.O. INV.	C.O. INV.
FLOW LINE	FLOW LINE
FINISH GRADE	FINISH GRADE
TOP OF CURB	TOP OF CURB
TOP OF WALL	TOP OF WALL
GATE	GATE
SIGN	SIGN
BACKWATER VALVE	BACKWATER VALVE
STREET LIGHTS	
100 W.H.P.S.	100 W.H.P.S.
150 W.H.P.S.	150 W.H.P.S.
200 W.H.P.S.	200 W.H.P.S.
250 W.H.P.S.	250 W.H.P.S.

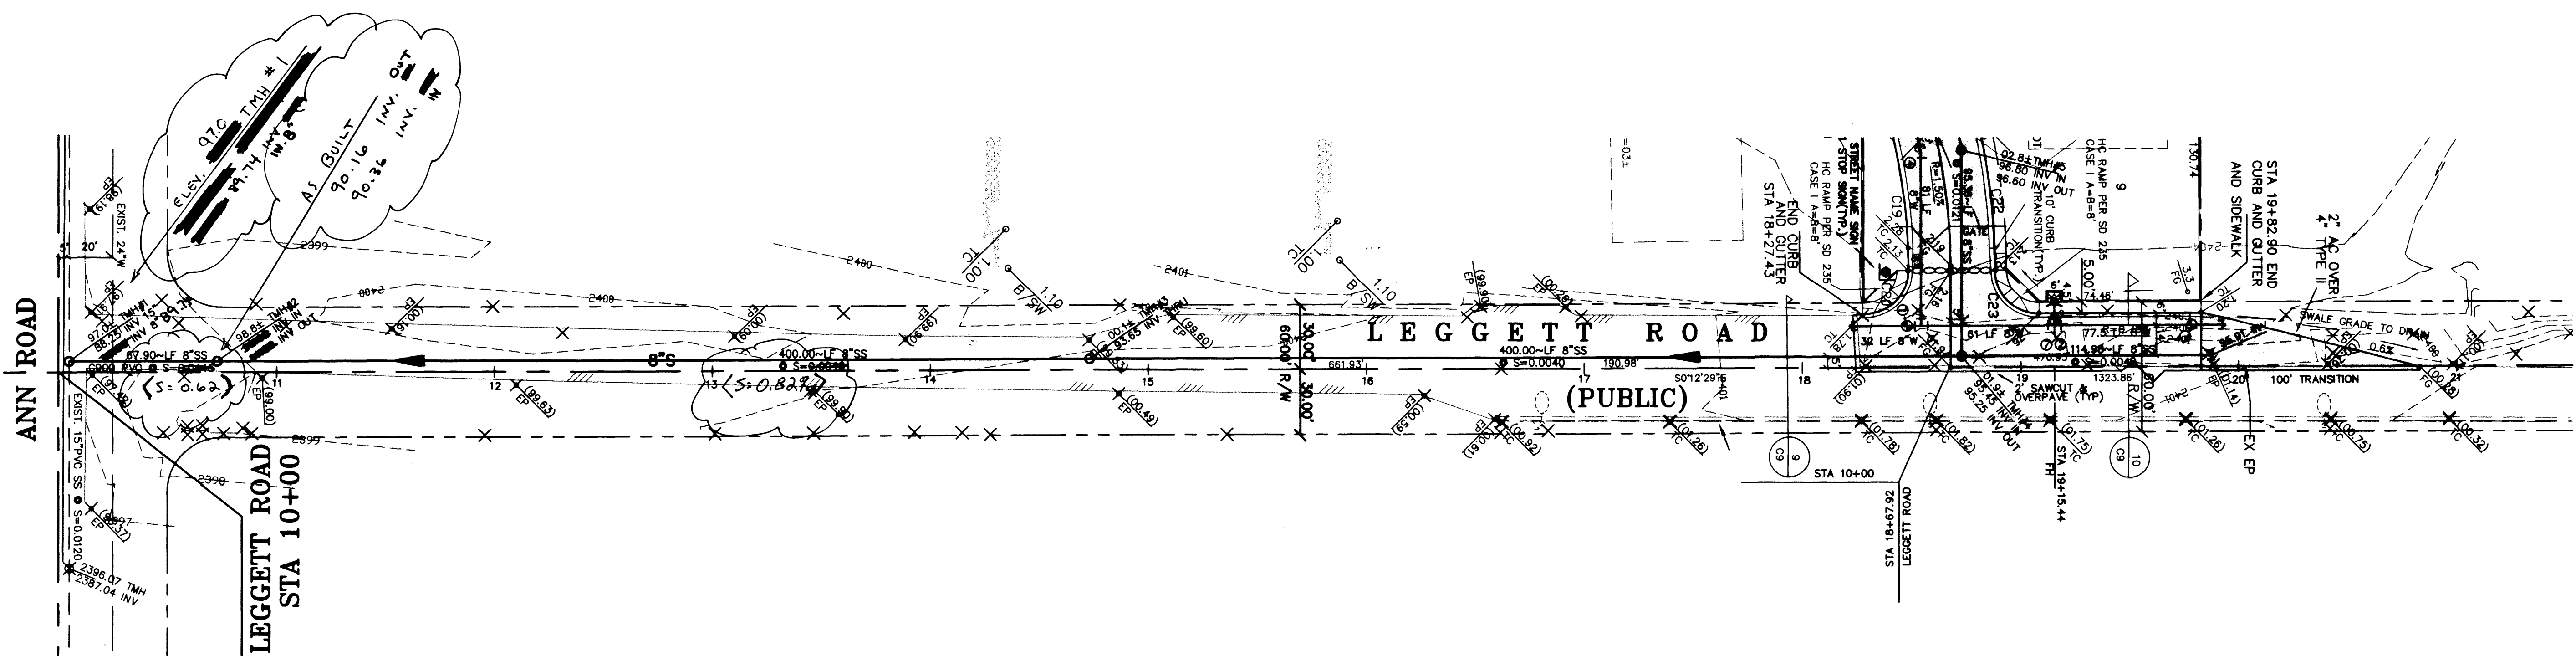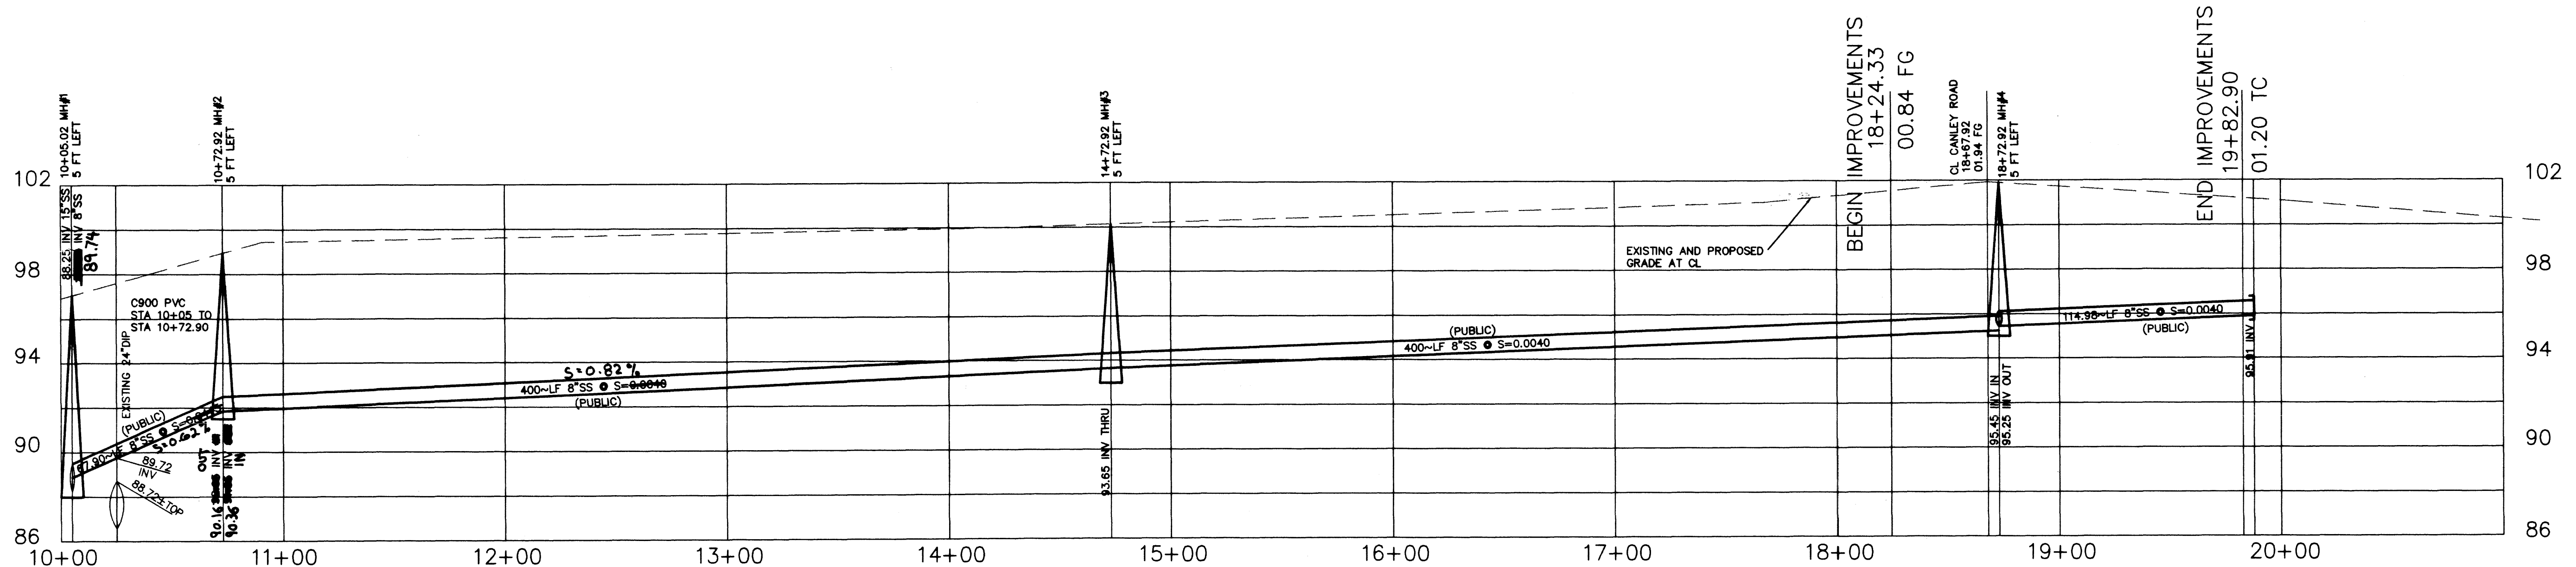

GRAND RONDE, INC. 4343 N. RANCHO ROAD # 132-110 LAS VEGAS, NEVADA 89130 (702) 396-6225	DELTA ENGINEERING 3131 MEADE AVENUE, SUITE D LAS VEGAS, NV 89102 (702) 364-3777 FAX (702) 364-9333 E-MAIL: ENG@DELTA@AOL.COM
PLAN AND PROFILE SHEET	GRANDE RONDE UNIT 2 RESIDENTIAL SUBDIVISION
SHEET DRAWN BY: 9/11/98 ACAD: 9/11/98 DESIGNED BY: 9/11/98 CHECKED BY: 9/11/98 PROJECT NO: 98005 SCALE: N/A	SEWER ASBUILT

As Built