

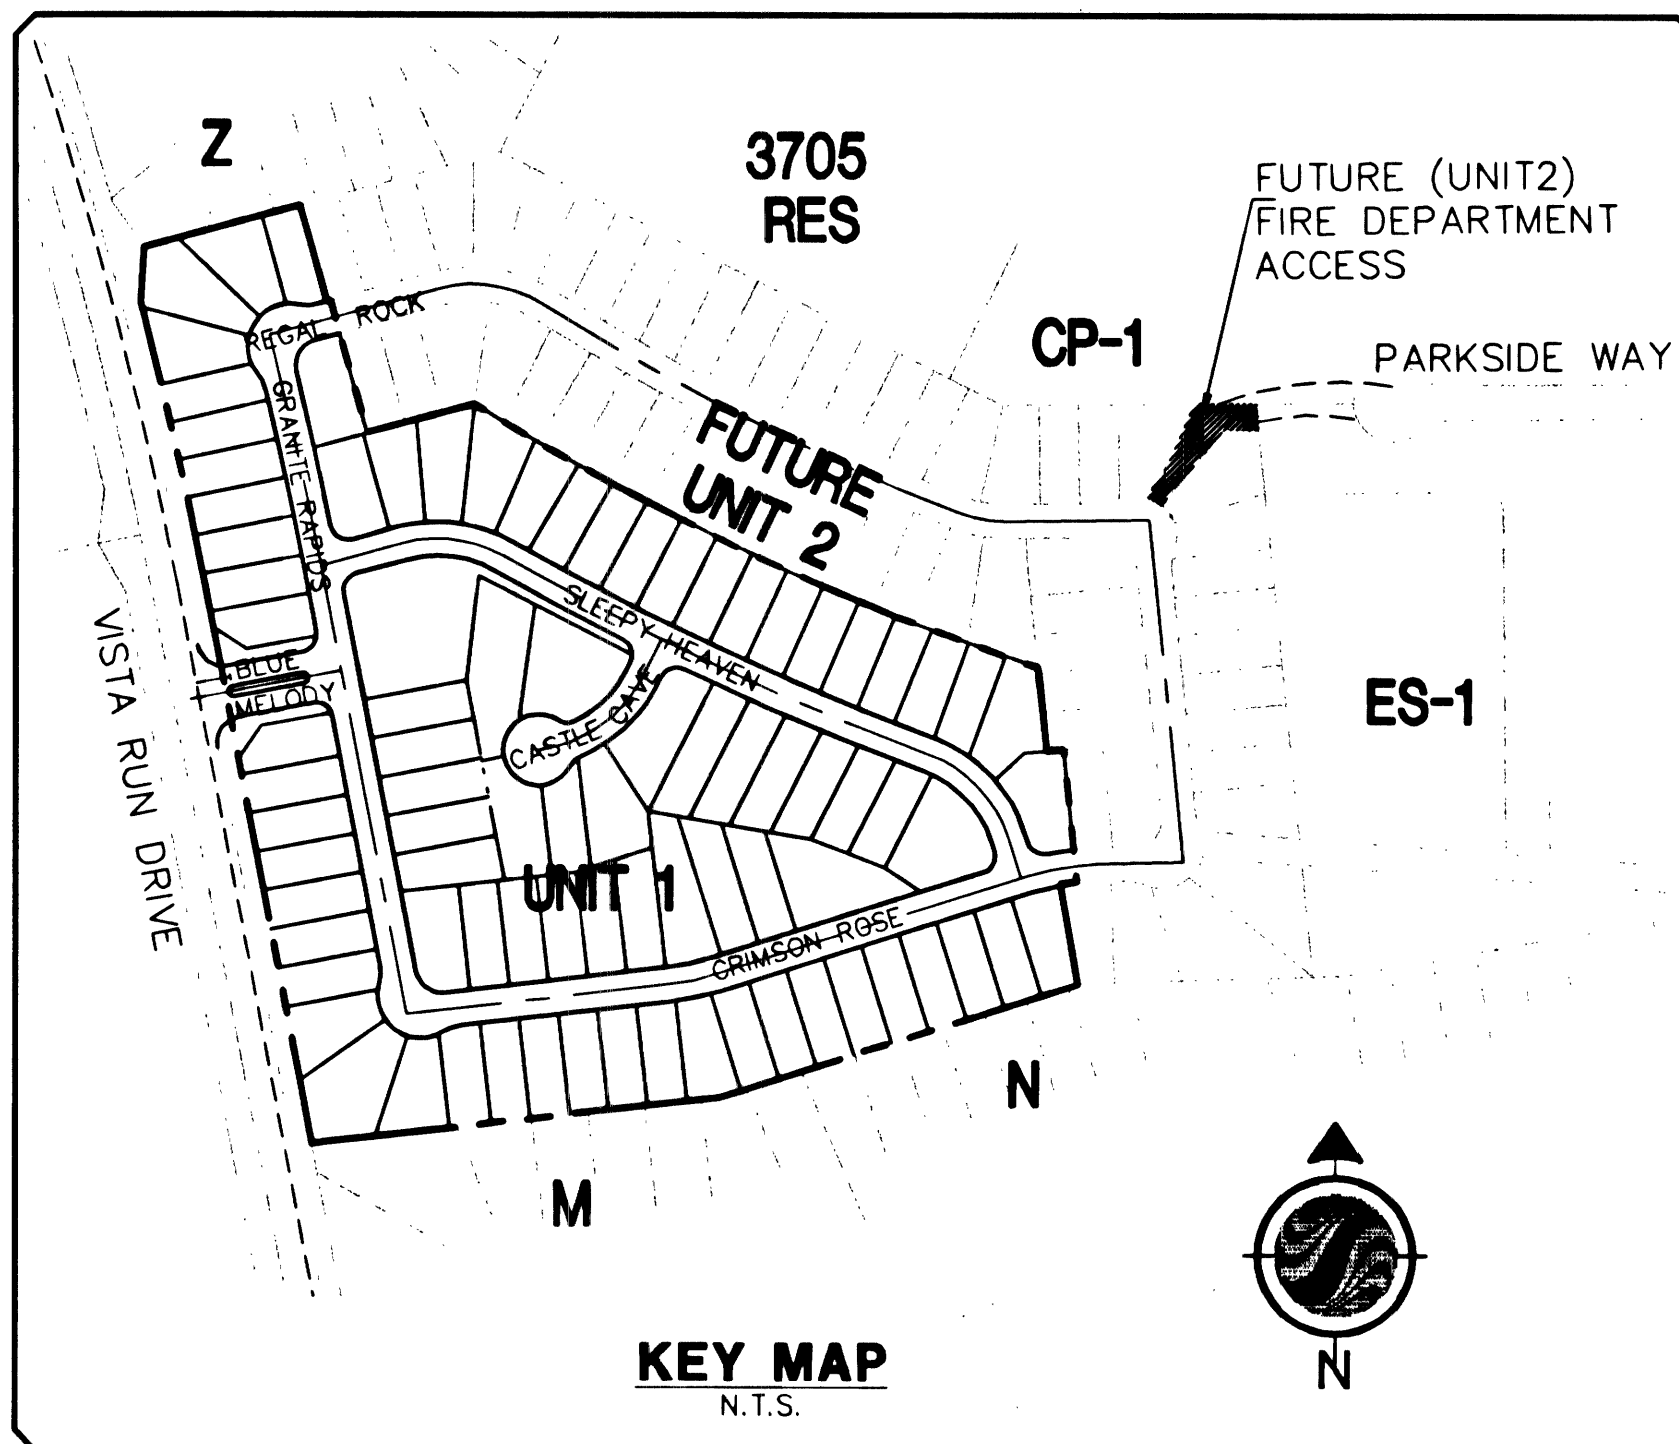


IMPROVEMENT PLANS
FOR
HILLSTONE UNIT 1
AT
THE SUMMERLIN VISTAS
APN # 137-35-211-002

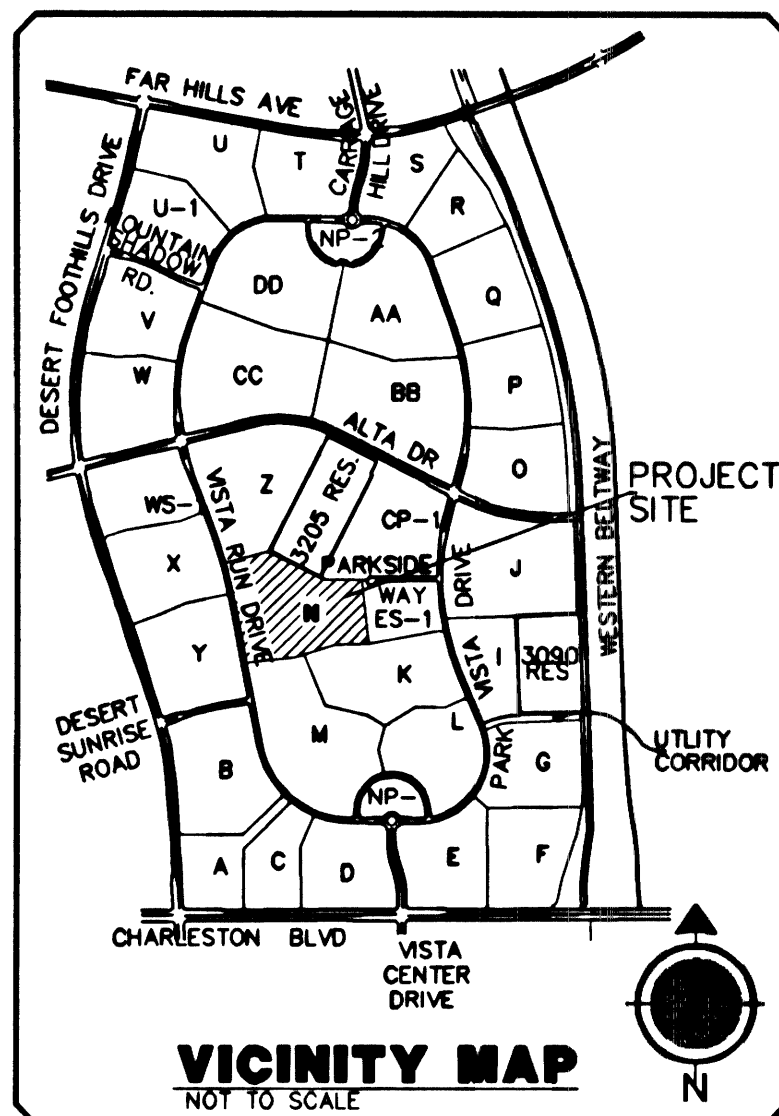

1635 VILLAGE CENTER CIRCLE, SUITE 250
LAS VEGAS, NEVADA 89134
(702) 256-7900

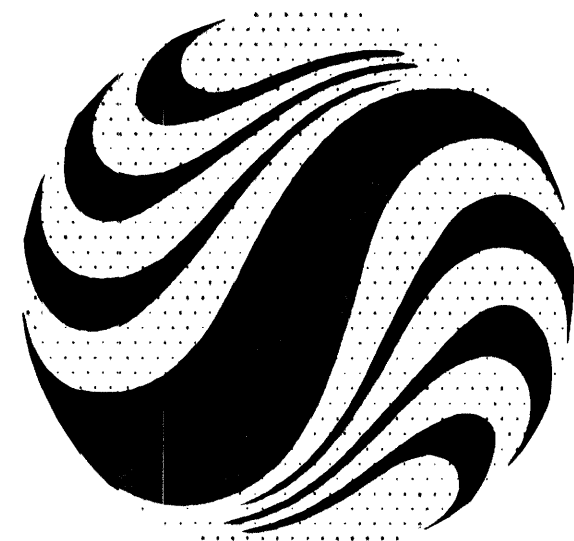

Stantec

Stantec Consulting Inc.

7251 W. Charleston Blvd.

Las Vegas NV U.S.A.

89117

Tel. 702.258.0115

Fax. 702.258.4956

www.stantec.com

PROJECT NAME: Hillstone @ Summerlin
Vista Unit 1, Pgs. 1, 9, 11, 12, 13, 14
This project water plan complies with the Las Vegas Valley Water District's technical requirements. However, this water plan is

NOT APPROVED FOR CONSTRUCTION

at this time and this signature does not provide or imply a water commitment.

LVWD #52 DATE 10-20-02

INDEX OF DRAWINGS

- 1 COVER SHEET
- 2 GENERAL NOTES AND ESTIMATE OF QUANTITIES
- 3 GRADING PLAN 1
- 4 GRADING PLAN 2
- 5 GRADING PLAN 3
- 6 GRADING SECTIONS & DETAILS
- 7 BLUE MELODY AVENUE, CASTLE CAVE COURT, & REGAL ROCK PLACE PLAN AND PROFILE
- 8 GRANITE RAPIDS PLAN AND PROFILE
- 9 CRIMSON ROSE AVENUE PLAN AND PROFILE
- 10 SLEEPY HEAVEN PLACE PLAN AND PROFILE
- 11 OFF-UNIT SEWER & WATER PLAN AND PROFILE
- 12 UTILITY, TRAFFIC & STREET LIGHTING PLAN 1
- 13 UTILITY, TRAFFIC & STREET LIGHTING PLAN 2
- 14 UTILITY, TRAFFIC & STREET LIGHTING NOTES AND DETAILS

APPROVALS

Charles K. Kowalski, Jr.
CHARLES K. KOWALSKI, JR.; PE #4784
CITY ENGINEER

10/10/2002
DATE

APPROVAL OF THESE PLANS IS LIMITED TO THOSE IMPROVEMENTS CONSTRUCTED IN THE DEDICATED RIGHTS-OF-WAY AND/OR DEDICATED EASEMENTS. THIS APPROVAL DOES NOT AUTHORIZE THE CONSTRUCTION OF ANY IMPROVEMENTS THAT DEVIATE FROM ADOPTED STANDARDS AND/OR SPECIFICATIONS, EXCEPT THOSE SPECIFICALLY LISTED UNDER DEVIATIONS FROM STANDARD. THE ENGINEER SHALL RESOLVE ANY DEVIATION OTHER THAN THOSE LISTED IN DEVIATIONS FROM STANDARDS IN FAVOR OF THE UNIFORM STANDARD DRAWINGS AND SPECIFICATIONS OF CLARK COUNTY AREA NEVADA.

Margo Wheeler
MARGO WHEELER, AICP, CURRENT PLANNING MANAGER

10/9/02
DATE

THIS PLAN MEETS THE APPLICABLE STANDARDS OF THE PLANNING AND DEVELOPMENT DEPARTMENT.

Robert Bull
CITY FIRE MARSHAL

9-27-02
DATE

LAS VEGAS VALLEY WATER DISTRICT (1, 9, 11-14)

DATE

Russell L. Vargo
SOUTHWEST GAS CORPORATION

9-26-02
DATE

Quanta Oddio
NEVADA POWER COMPANY

9-27-02
DATE


NEVADA POWER COMPANY ACKNOWLEDGES THAT WE HAVE RECEIVED YOUR PLANS AND WILL PROVIDE SERVICE TO ALL ELECTRICAL NEEDS ASSOCIATED WITH THIS PROJECT. NEVADA POWER COMPANY RESERVES THE RIGHT TO ADDRESS ANY EXISTING OR FUTURE CONFLICTS ONCE THE FINAL DESIGN IS COMPLETE. THE NEW SERVICE AND THE RESOLUTION OF ANY CONFLICTS WILL BE ACCOMPLISHED PURSUANT TO THE NEVADA PUBLIC UTILITY COMMISSION'S RULES AND REGULATIONS.

James M. Hall
SUMMERLIN DESIGN REVIEW COMMITTEE

10-8-02
DATE


DATE	9/26/2002	SLY	TMG	R.P.S.	MA	8817052	N.T.S.	DATE	APPROVED
PM									
DRAWN BY									
DESIGNED BY									
CHECKED BY									
ADA CHECKED									
JOB NO.									
SCALE									
N.O.									
DESCRIPTION									

Stantec Consulting Inc.
7251 West Charleston Blvd.
Las Vegas NV U.S.A.
89117
Tel. 702.258.0115
Fax. 702.258.4956
www.stantec.com

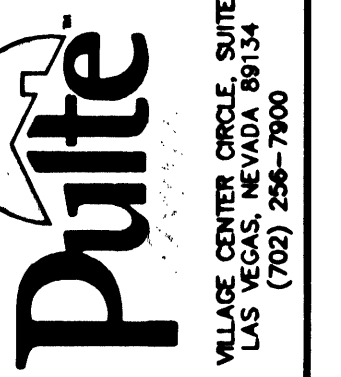

1635 VILLAGE CENTER CIRCLE, SUITE 250
LAS VEGAS, NEVADA 89134
(702) 256-7900

PULTE HOMES
HILLSTONE AT THE SUMMERLIN VISTAS
COVER SHEET

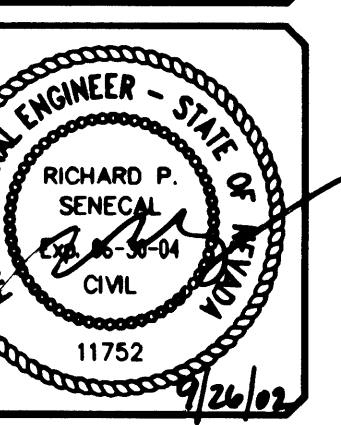

SHEET 1 OF 14
C.L.V. DWG # 1074-4723-1

Copyright © 2002 Stantec Consulting Inc. All rights reserved. No part of this document may be reproduced or transmitted in any form or by any means electronic or mechanical, including photocopying and recording, or by any information storage or retrieval system, without permission in writing from Stantec Consulting Inc. Reproduction or use for any purpose other than that authorized by Stantec is prohibited.