


Call before you Dig.  
1-800-227-2600  
UNDERGROUND SERVICE USA

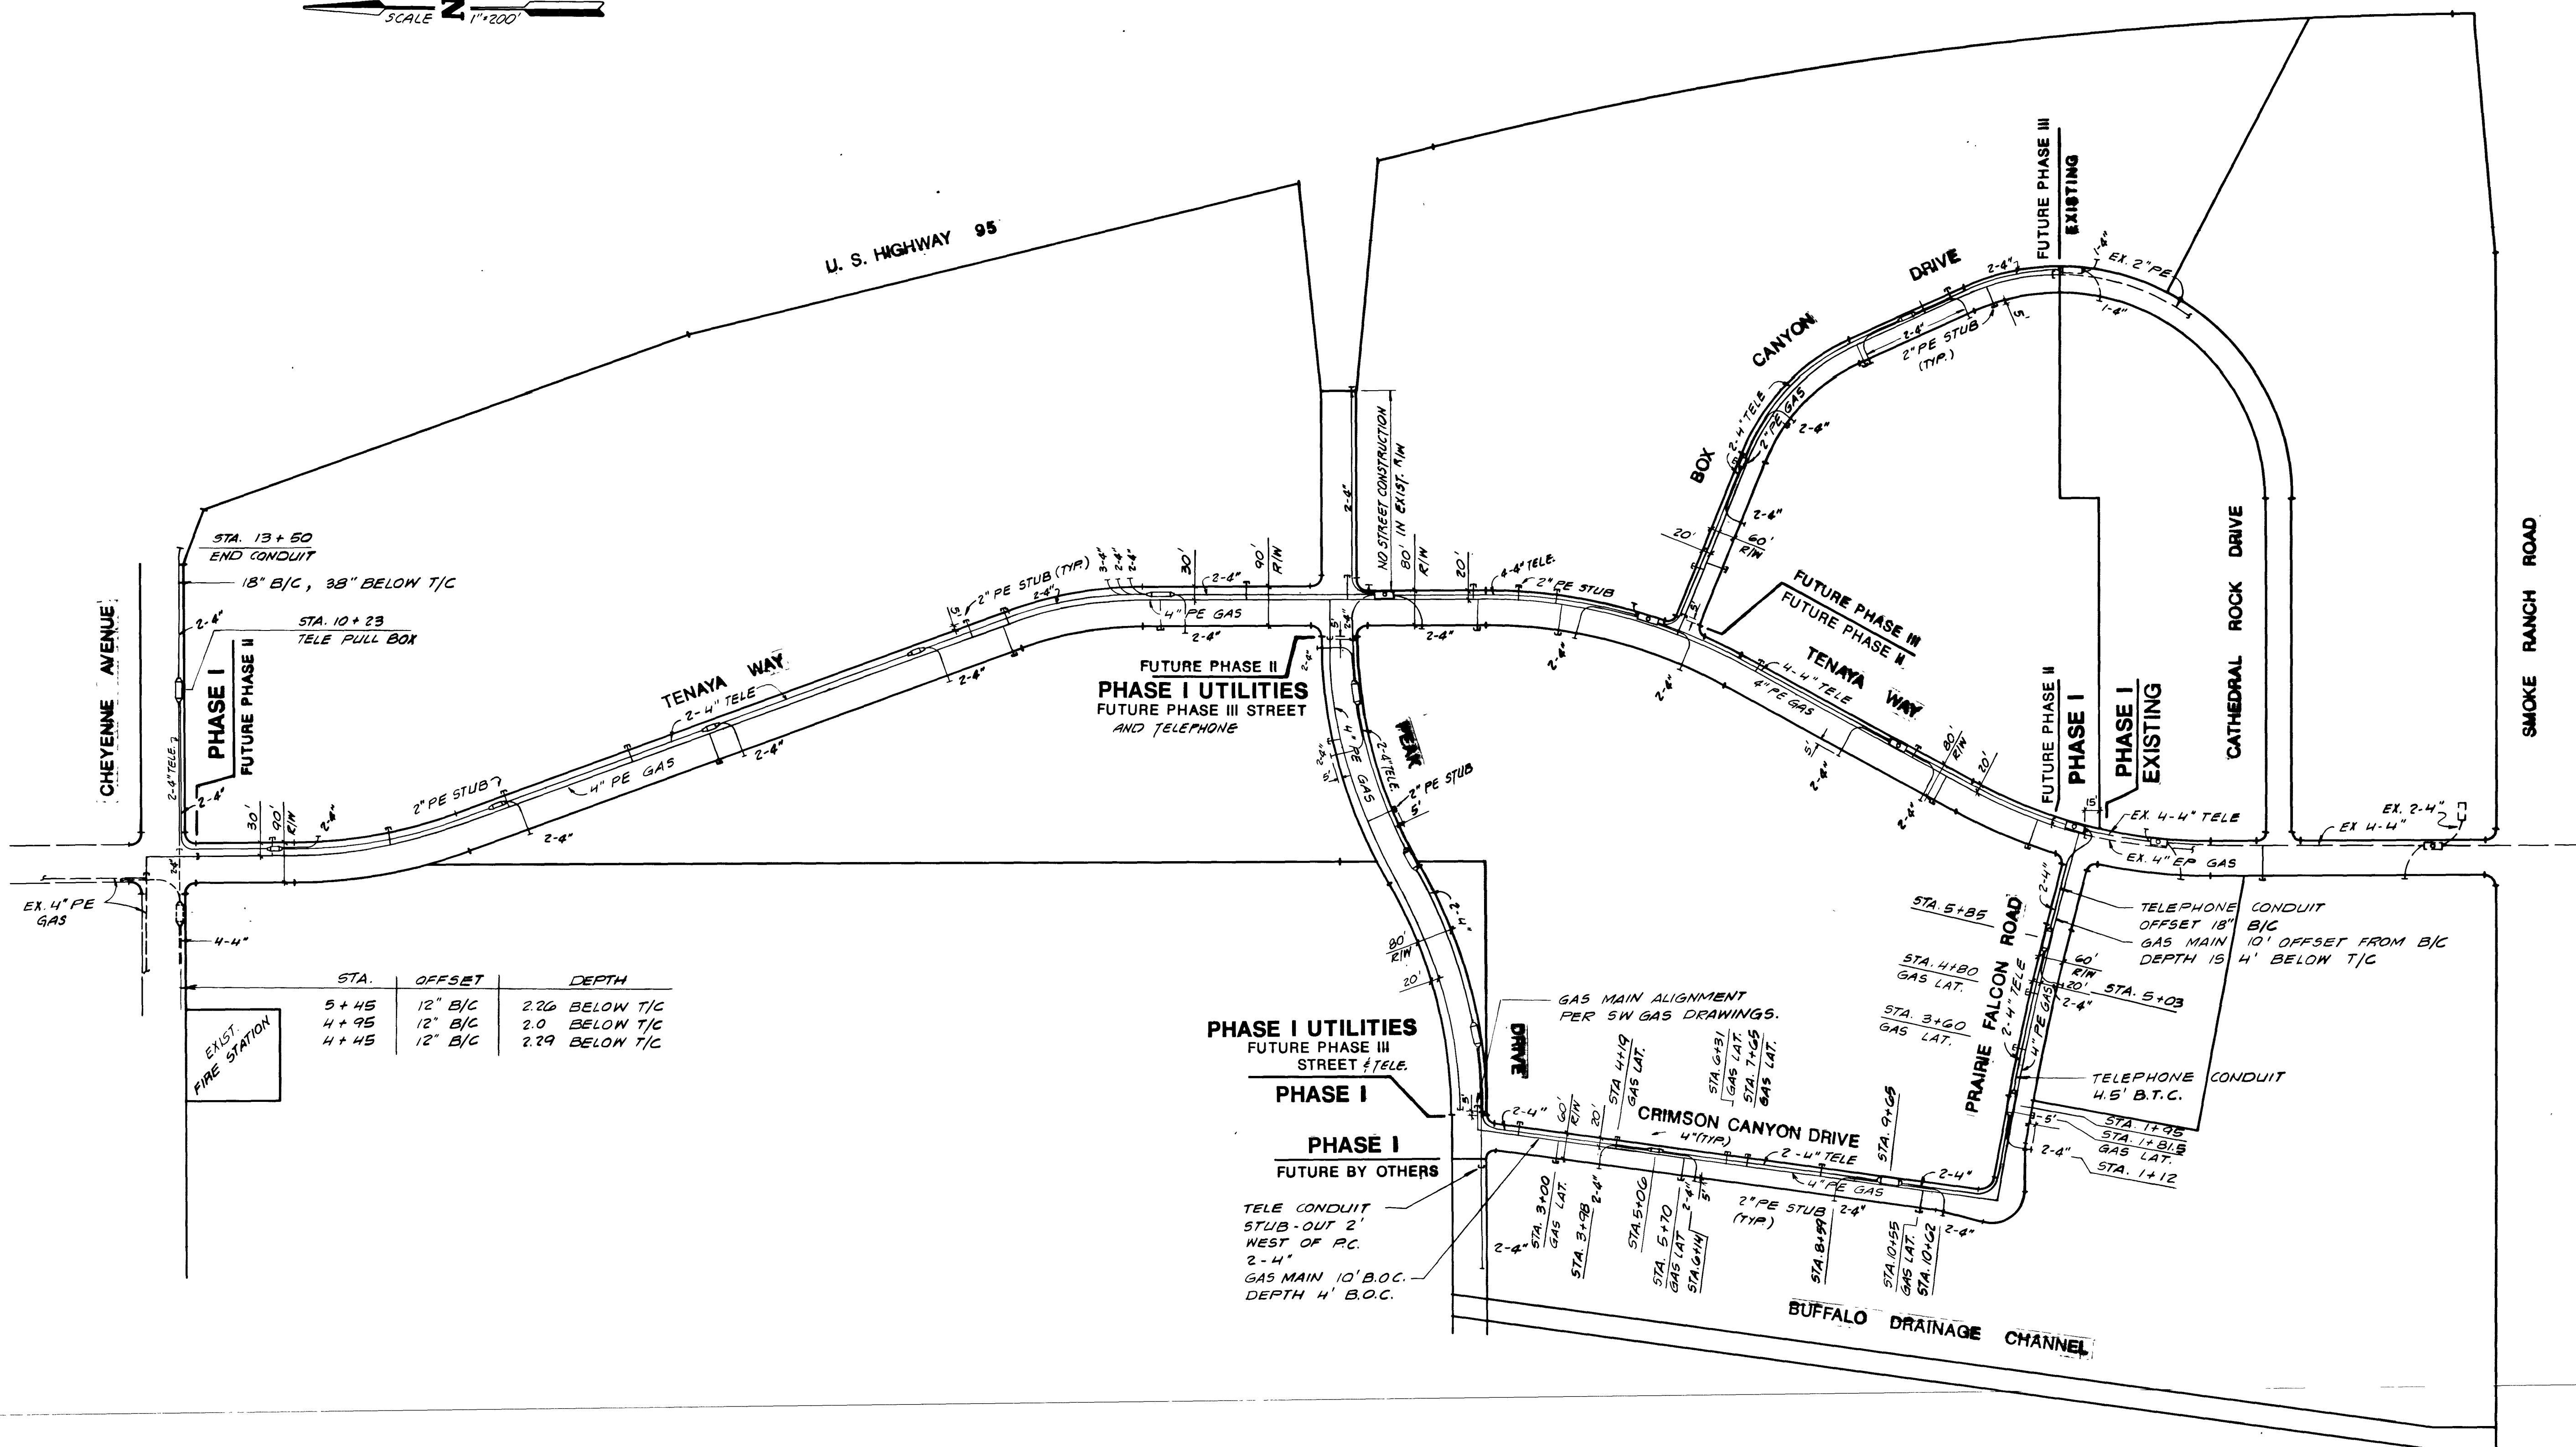

STA.	OFFSET	DEPTH
5+45	12" B/C	2.26 BELOW T/C
4+95	12" B/C	2.0 BELOW T/C
4+45	12" B/C	2.29 BELOW T/C

RECORD DRAWING  
From Information Provided  
By The City of Las Vegas  
*William S. Gaudet* 10/1/91  
Signature Date

**NOTE:**  
CONSTRUCTION OF GAS PIPE AND FACILITIES BY OTHERS.  
NOT A PART OF THIS CONTRACT.  
CONTRACTOR SHALL COORDINATE CONSTRUCTION WITH  
SOUTHWEST GAS CO.

**LEGEND**  
 5' x 10'-6" x 7' MANHOLE EQUIPPED WITH EIGHT 37-HOLE CABLE RACKS, ONE 9" LADDER, 30" COLLAR AND STEEL TRAFFIC COVER.  
 3' x 6' x 4' PULLBOX EQUIPPED WITH FOUR 18-HOLE CABLE RACKS AND STEEL TRAFFIC COVER.  
 4" CONDUIT, PVC - DR 300 GRADE.  
**NOTE:** TELE SERVICE LATERALS WERE INSTALLED WITH TRANSPONDERS AT ENDS.

DESIGNED: MEM/ASC  
DRAWN: EJI/MEF  
CHECKED: JSC  
DATE: OCT. 89  
J.N.: 890401

SCALE: 1" = 200'  
DESIGNED: MEM/ASC  
DRAWN: EJI/MEF  
CHECKED: JSC  
DATE: OCT. 89  
J.N.: 890401


REVISION

1 CHANGE CALICO BASIN TO CAMARON CANYON DR.  
2 REMOVE EX. CHANGING BOX LOCATIONS  
3 REMOVE EX. CHANGING BOX LOCATIONS

DELTA ENGINEERING INC.  
ENGINEERING • LAND SURVEYING • PLANNING  
4000 WEST OAKLEY BLVD. • LAS VEGAS, NEVADA 89102  
PHONE (702) 877-9858

GAS AND TELEPHONE UTILITY PLAN  
LAS VEGAS TECHNOLOGY CENTER  
INFRASTRUCTURE DEVELOPMENT PHASE I  
CITY OF LAS VEGAS, CLARK COUNTY, NEVADA

SHEET No.  
15 OF 18

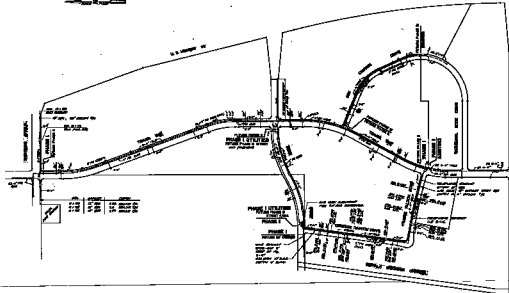

1:10	1:20	1:30	1:40	1:50	2:00
1:10	1:20	1:30	1:40	1:50	2:00

DRAWN BY  
**W. J. BROWN**  
 CHECKED BY  
**J. H. BROWN**

**NOTE:**  
 CONNECTIONS TO GAS MAIN AND TELEPHONE MAIN SHALL BE MADE IN ACCORDANCE WITH THE CITY OF LOS ANGELES ORDINANCES AND THE RULES AND REGULATIONS OF THE GAS AND TELEPHONE COMPANIES.  
 ALL WORK SHALL BE DONE IN ACCORDANCE WITH THE CITY OF LOS ANGELES ORDINANCES AND THE RULES AND REGULATIONS OF THE GAS AND TELEPHONE COMPANIES.

**LEGEND:**  
 (Symbol) GAS MAIN  
 (Symbol) TELEPHONE MAIN  
 (Symbol) MANHOLE  
 (Symbol) VALVE  
 (Symbol) CROSSING

GAS AND TELEPHONE UTILITY PLAN  
 LOS ANGELES TELEPHONE CENTER  
 INDUSTRIAL DISTRICT, LOS ANGELES, CALIF.

SHEET NO.  
 10 OF 10