

NOTES

1. INSTALL CONDUITS IN SLEEVES INSTALLED UNDER ROADWAY CONTRACT
2. CONVERT EXISTING 100W HPS FIXTURE TO 100W MV FIXTURE PER SCHEDULE 1 ON TABLE 1.
3. CONVERT EXISTING 100W SPOT MERCURY TO FLOOD TYPE PER SCHEDULE 2 ON TABLE 1.



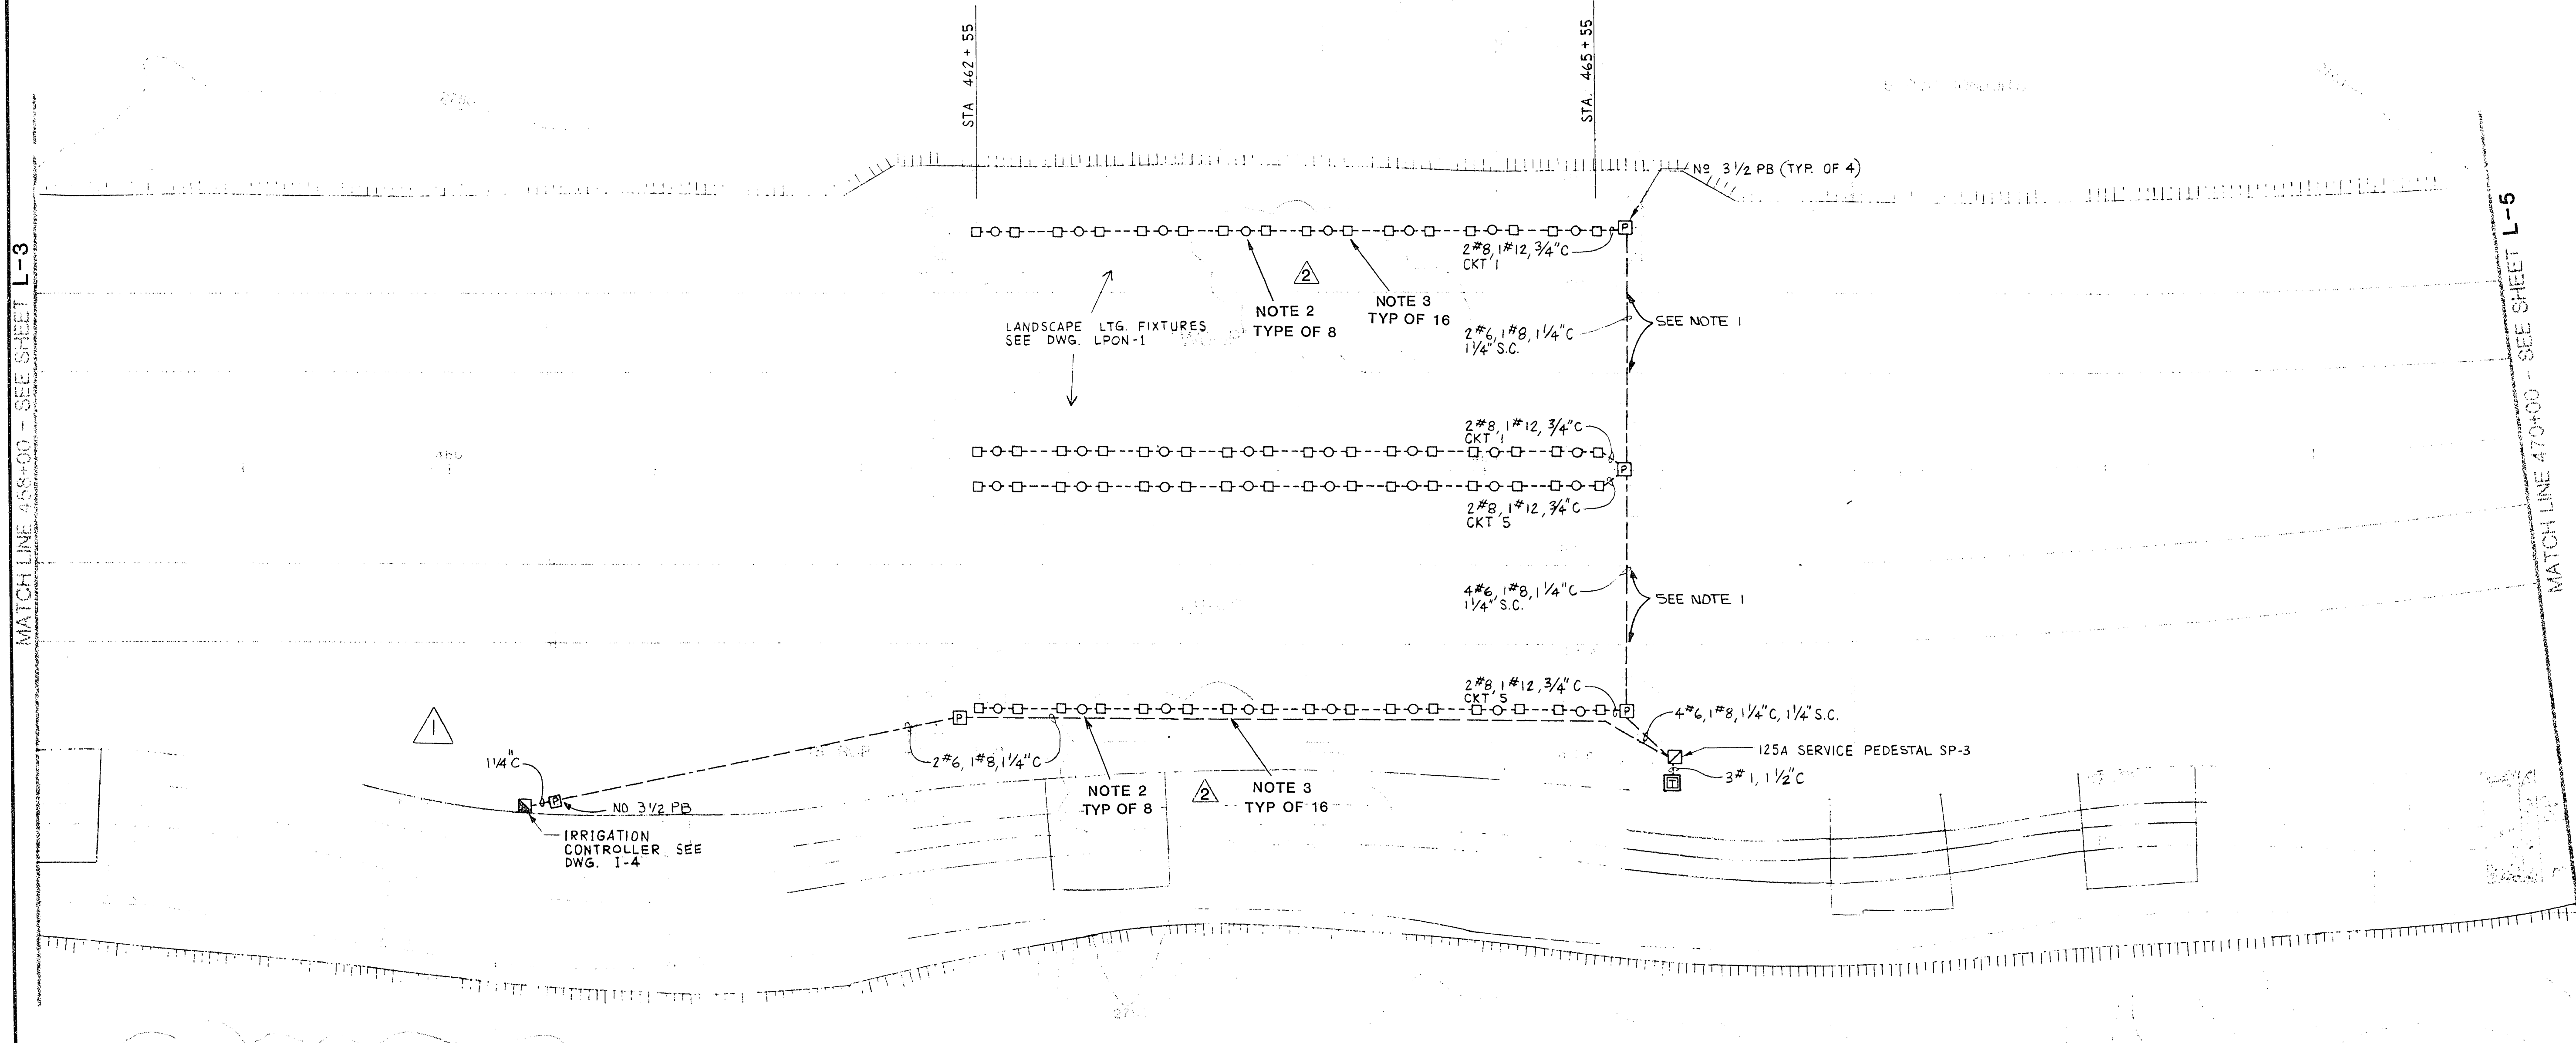


TABLE 1

REMOVE *	INSTALL	PART #
SCHEDULE 1 - CONVERT 100W HPS TO 100W MERCURY		
HPS BALLAST	100W MERCURY BALLAST	BRONZELITE
HPS LAMP	100W ED17 MV LAMP	600812
FLAT LENS	CONVEX LENS	604554
GASKET	GASKET	67190
TRIM RING	ROCK GUARD	77833
CONCRETE FROM SCREW HOLES	FLAT HEAD SS SCREWS WHERE MISSING	68938
SCHEDULE 2 - CONVERT 100W MERCURY SPOT TO FLOOD		
100W PAR 38 MV LAMP	100W ED17 MV LAMP	BRONZELITE
FLAT LENS	CONVEX LENS	604554
GASKET	GASKET	67190
TRIM RING	ROCK GUARD	77833
CONCRETE FROM SCREW HOLES	REFLECTOR	68938
	FLAT HEAD SS SCREWS WHERE MISSING	68967

* RETURN ALL SALVAGABLE PARTS FROM FIXTURE TO OWNER FOR FUTURE MAINTENANCE.
RETURN PART IN USED PART BOX WITH ITEM NOTED BY BLACK MARKER.

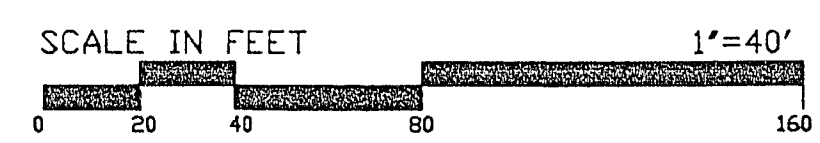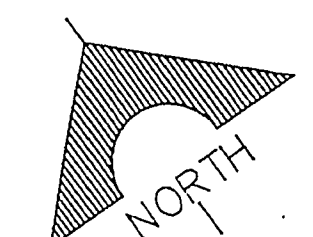

REV	DATE	DESCRIPTION
1	10-7-88	ADD. PS
2	10-2-98	CONVERT PALM BOSQUE TO PINE BOSQUE

TJKROB
CONSULTING ENGINEERS, INC.
3180 S. VALLEY VIEW BLVD. SUITE 207
LAS VEGAS, NEVADA 89102
(702) 871-3621

SHEET TITLE: **ELECTRICAL PLAN**
PROJECT: **HUSITE PARKWAY (ONSITE)**
LANDSCAPE LIGHTING CONSTRUCTION DRAWINGS

JOB NUMBER: 855
DATE: 9-9-88
DRAWN BY: JIM MARVOSE
CHECKED BY: TOM KROB
RECOMMENDED: *Thomas Krob*
DATE: 9-9-88
SHEET: **L-4**
OF: 12