


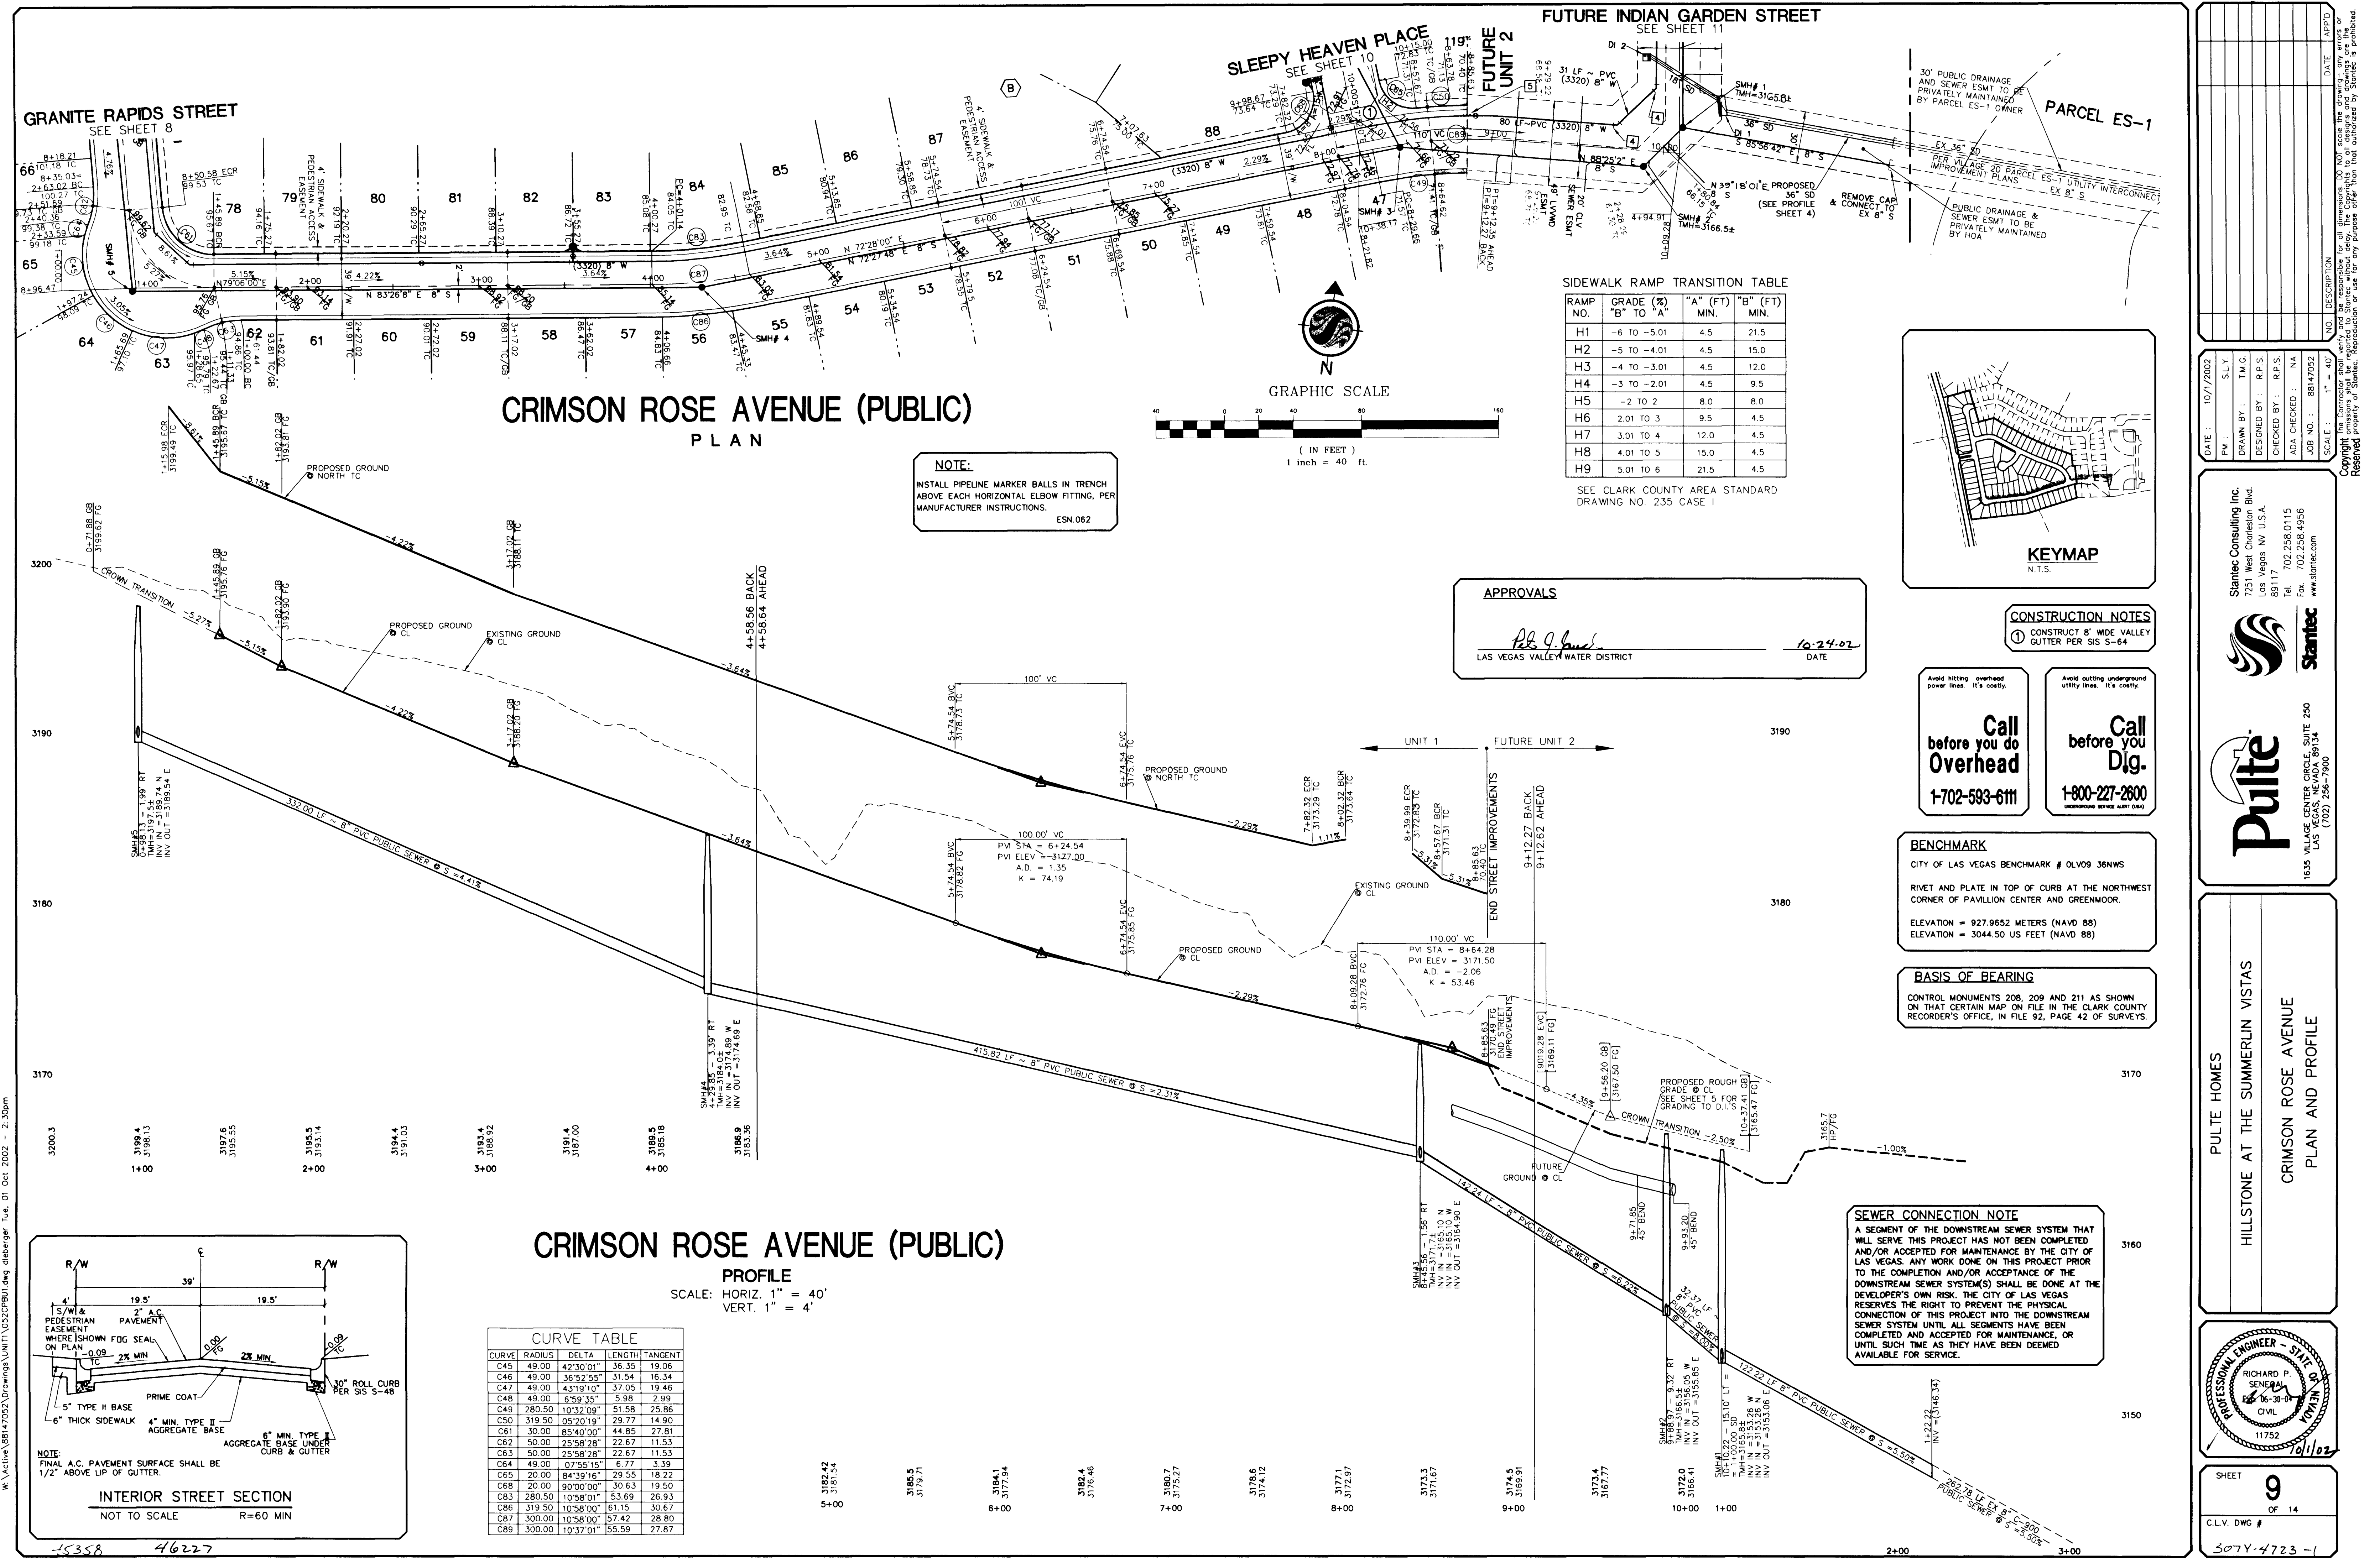

W:\Active\188147032\Drawings\UNIT\02\CPBU.dwg diebler Tue, 01 Oct 2002 - 2:30pm

NO. DESCRIPTION DATE APPROVED

DATE: 10/1/2002

DRAWN BY: T.M.G.

DESIGNED BY: R.P.S.

CHECKED BY: R.P.S.

ADA CHECKED: NA

JOB NO.: 88147032

SCALE: 1" = 40'

Stanlec Consulting Inc.
7251 West Charleston Blvd.
Las Vegas, NV 89117
Tel: 702.258.0115
Fax: 702.258.4956
www.stanlec.com

Stanlec

Pulte
1635 VILLAGE CENTER CIRCLE, SUITE 250
LAS VEGAS, NV 89134
(702) 258-7800

HILLSTONE AT THE SUMMERLIN VISTAS
CRIMSON ROSE AVENUE
PLAN AND PROFILE

PROFESSIONAL ENGINEER - STATE OF NEVADA
RICHARD P. STANLEC
11752
10/1/02

SHEET **9** OF 14
C.L.V. DWG #