
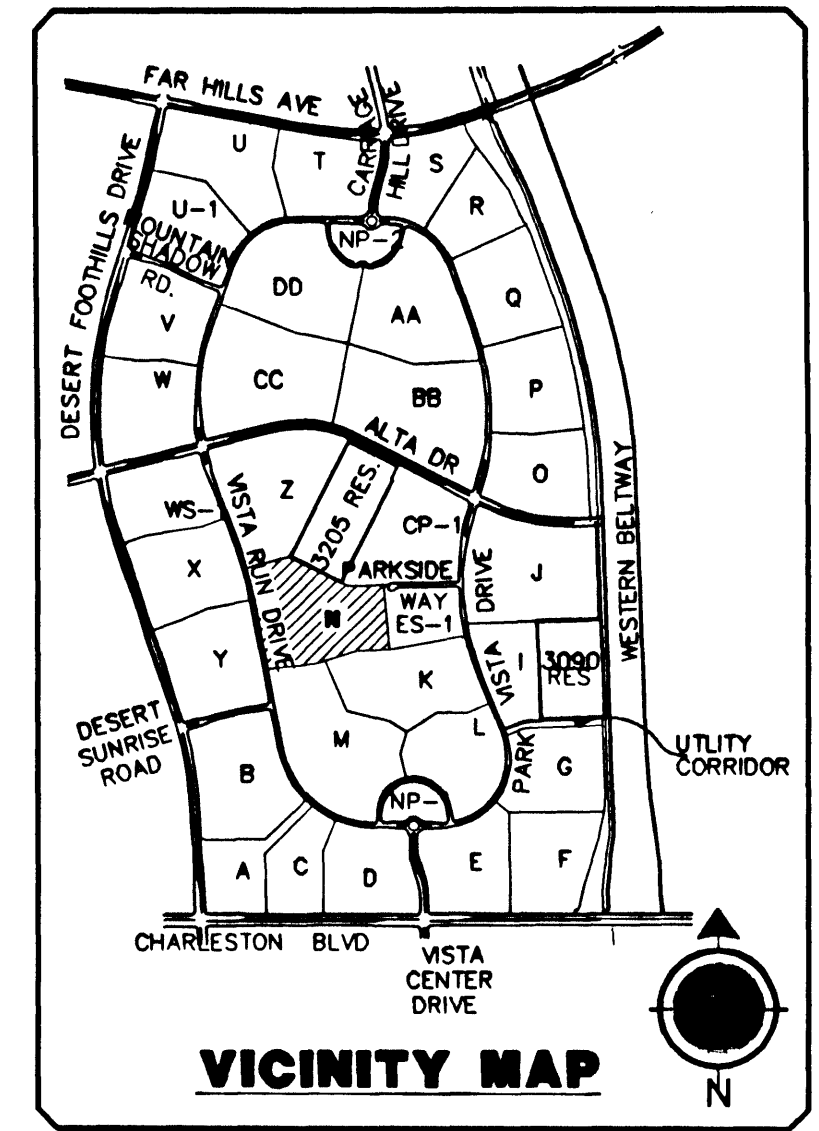


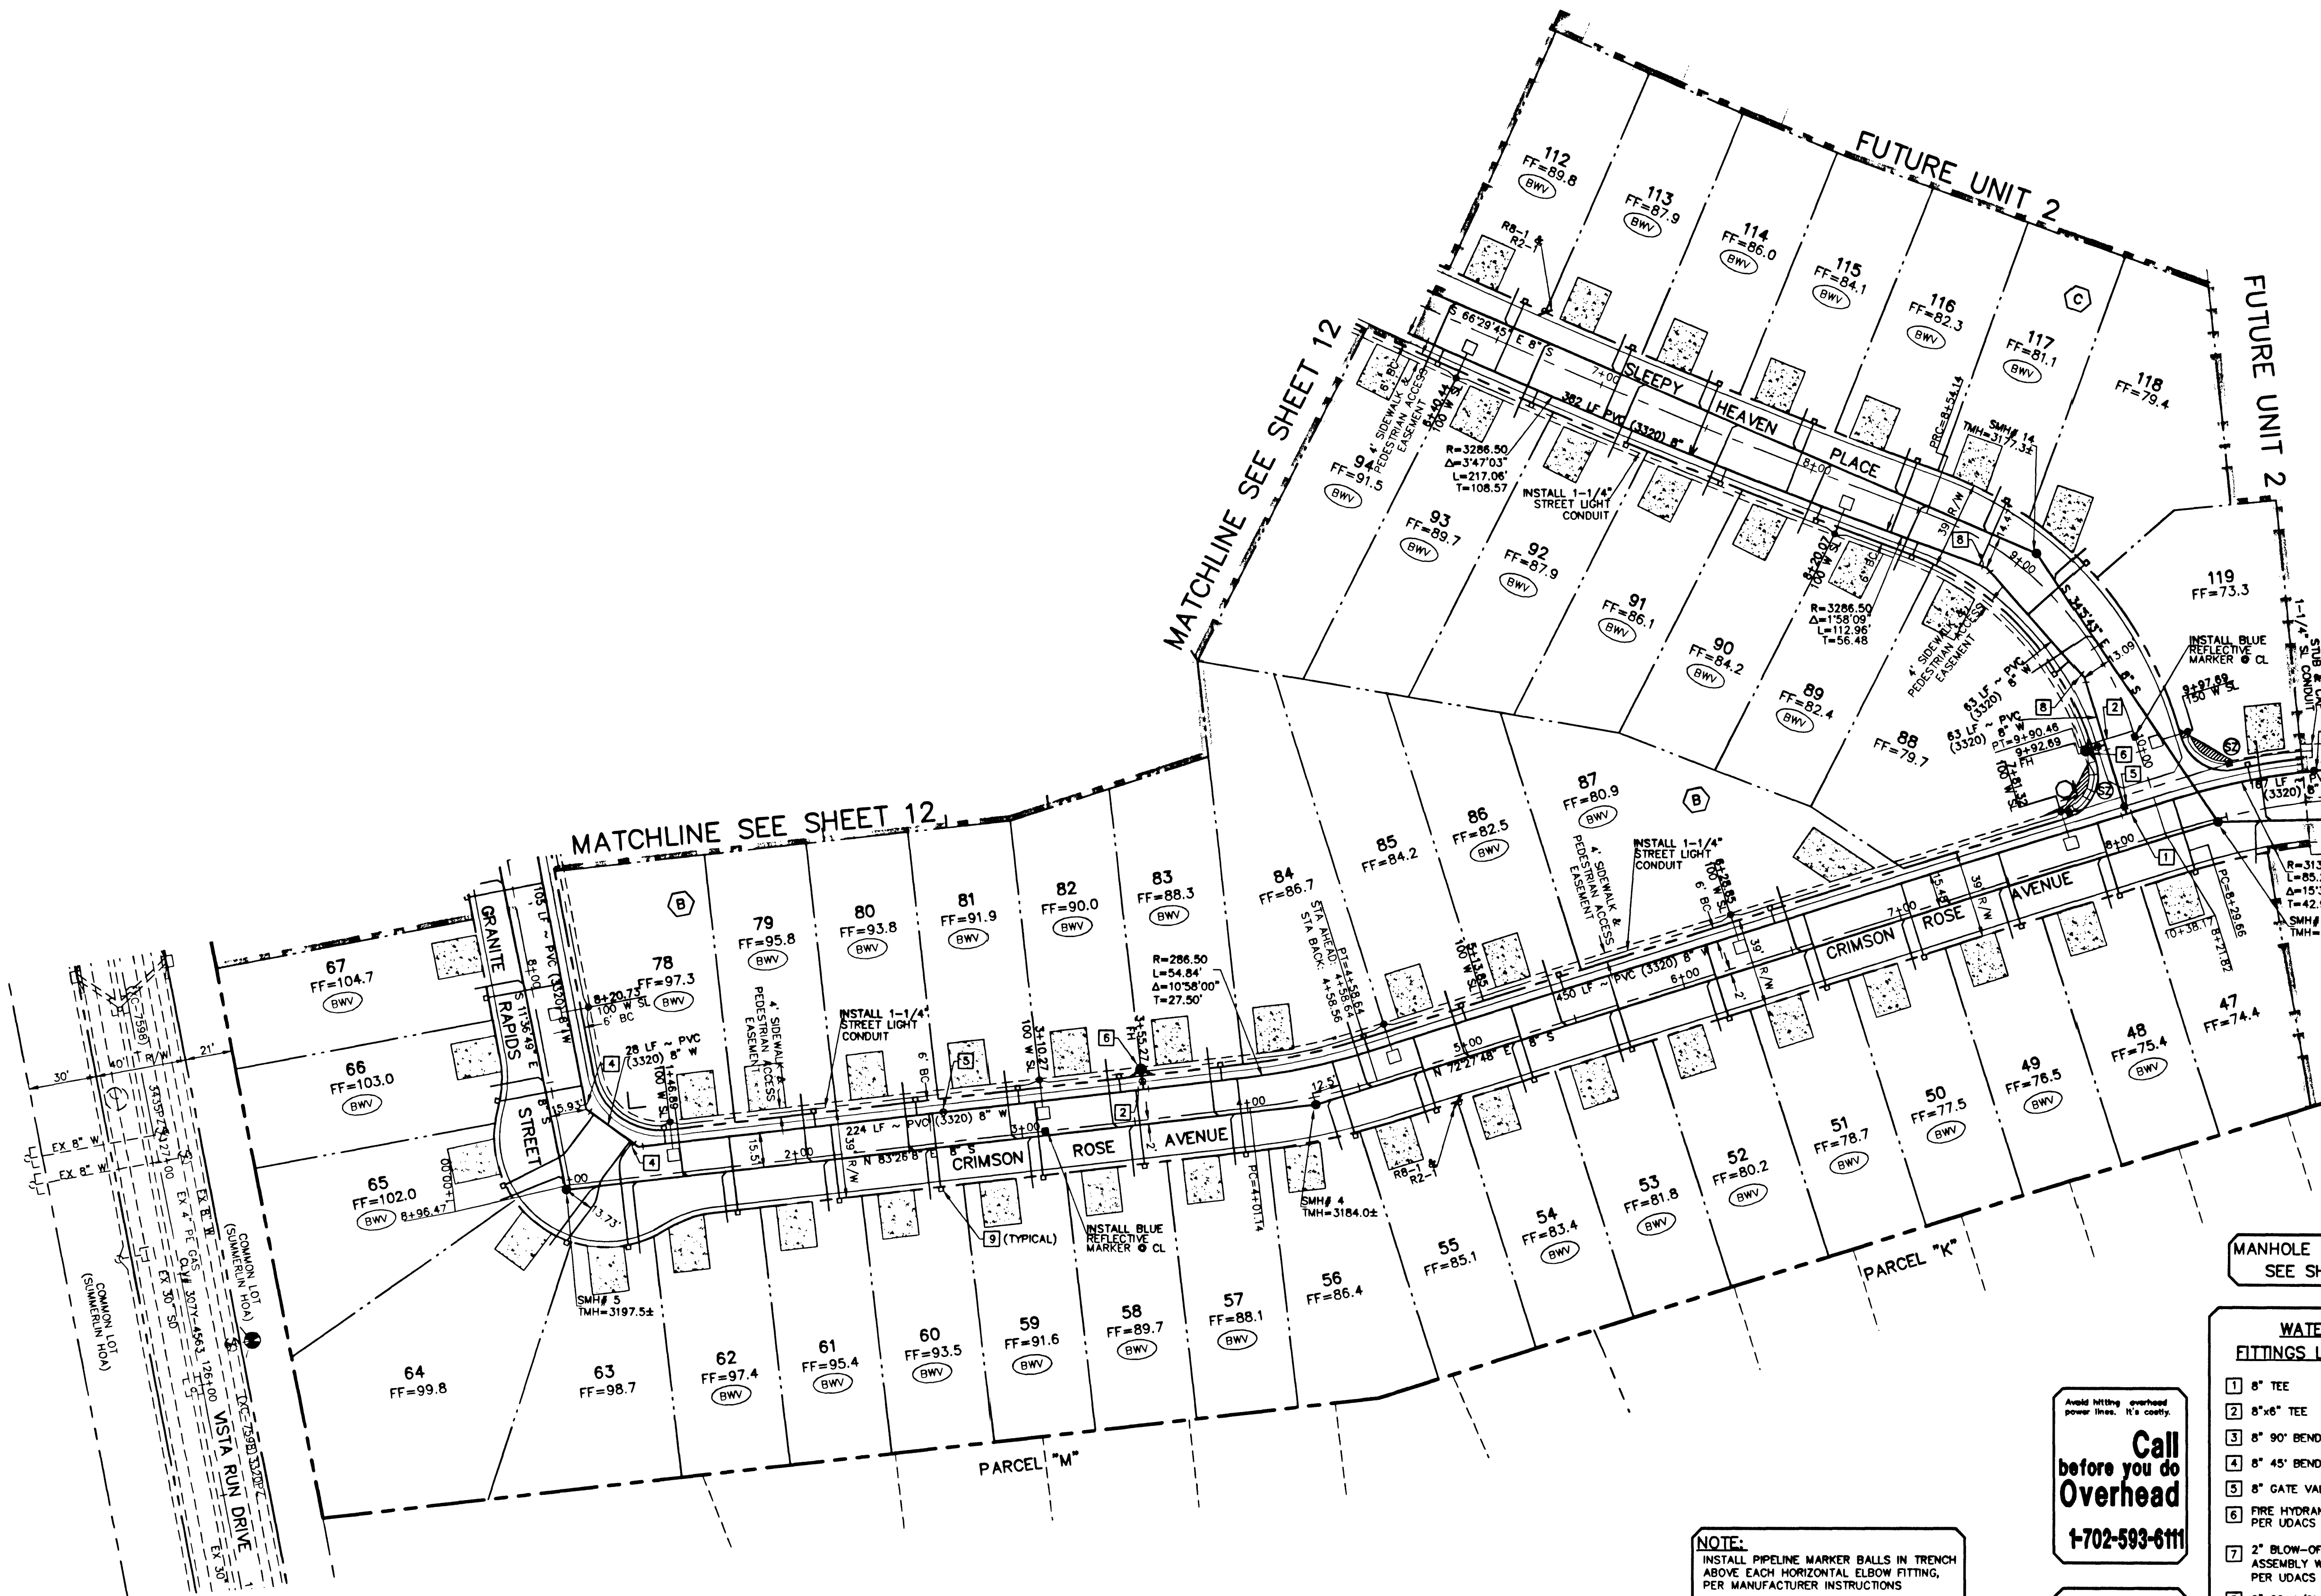

SEE SHEET 9
FOR WATER & SEWER CONTINUATION

BASIS OF BEARING
CONTROL MONUMENTS 208, 209 AND 211 AS SHOWN ON THAT CERTAIN MAP ON FILE IN THE CLARK COUNTY RECORDER'S OFFICE, IN FILE 92, PAGE 42 OF SURVEYS

BENCHMARK
CITY OF LAS VEGAS BENCHMARK # OLVO9 36NWS
RIVET AND PLATE IN TOP OF CURB AT THE NORTHWEST CORNER OF PAVILION CENTER AND GREENMOOR.
ELEVATION = 927.9552 METERS (NAVD 88)
ELEVATION = 3044.50 US FEET (NAVD 88)

- UTILITY LEGEND**
- EX 8" W --- EXISTING WATER LINE W/SIZE
 - 8" W --- PROPOSED WATER LINE W/SIZE
 - 3/4" PROPOSED WATER LATERAL & METER PER UDACS PLATE 1B UNLESS OTHERWISE NOTED
 - PROPOSED FIRE HYDRANT W/6" LATERAL & 6" G.V.
 - EX 8" S --- EXISTING SEWER LINE W/SIZE
 - 8" S --- PROPOSED SEWER LINE W/SIZE
 - PROPOSED SEWER LATERAL
 - EXISTING SEWER MANHOLE
 - PROPOSED SEWER MANHOLE
 - 0" LIP DRIVEWAY
 - GATE VALVE
 - 1-1/4" SL CONDUIT
 - 150W HPS LUMINAIRE STREET LIGHT PER SIS
 - 100W HPS LUMINAIRE STREET LIGHT PER SIS
 - EXISTING STREET LIGHT
 - CONCRETE DRIVEWAY
 - WATER REDUCER
 - NO 3 1/2 PULLBOX
 - 125A PAD MOUNTED STREET LIGHT SERVICE POINT
 - REQUIRES BACKWATER VALVE
 - REQUIRES PRESSURE REDUCER VALVE


MANHOLE SCHEDULE
SEE SHEET 12

- WATER FITTINGS LEGEND:**
- 1 8" TEE
 - 2 8"x6" TEE
 - 3 8" 90° BEND
 - 4 8" 45° BEND
 - 5 8" GATE VALVE
 - 6 FIRE HYDRANT ASSY. PER UDACS PLATE 7
 - 7 2" BLOW-OFF ASSEMBLY W/CAP PER UDACS PLATE 4
 - 8 8" 22-1/2° BEND
 - 9 3/4" WATER METER PER UDACS PLATE 1D
 - 9 3/4" WATER METER PER UDACS PLATE 1B (TYPICAL)
 - 10 5/8" WATER METER PER UDACS PLATE 1D
 - 11 8"x6" REDUCER
 - 12 8" 22-1/2° BEND

Call before you do Overhead
1-702-593-6111

Call before you Dig.
1-800-227-2600

NOTE:
INSTALL PIPELINE MARKER BALLS IN TRENCH ABOVE EACH HORIZONTAL ELBOW FITTING, PER MANUFACTURER INSTRUCTIONS
ESN.062

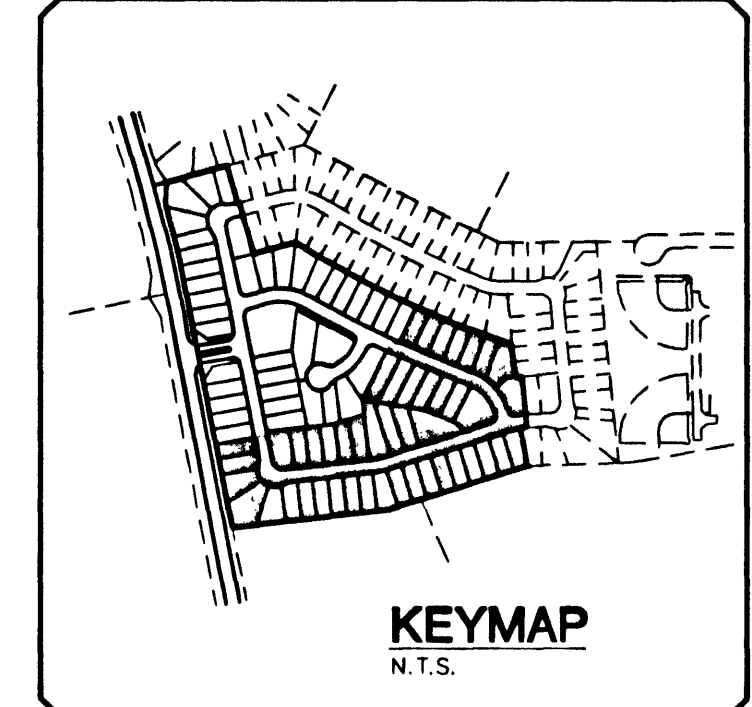


- TRAFFIC LEGEND**
- L 9" D3 STREET NAME SIGN (PER STD DWG 250)
 - O 30" STOP SIGN (R1-1) LOCATE AT BCR
 - BLUE REFLECTIVE MARKER
 - STREET SIGN AS NOTED PER PLAN

APPROVALS

Robert Bull
CITY FIRE MARSHAL
DATE: 9-27-02

LAS VEGAS VALLEY WATER DISTRICT
DATE:

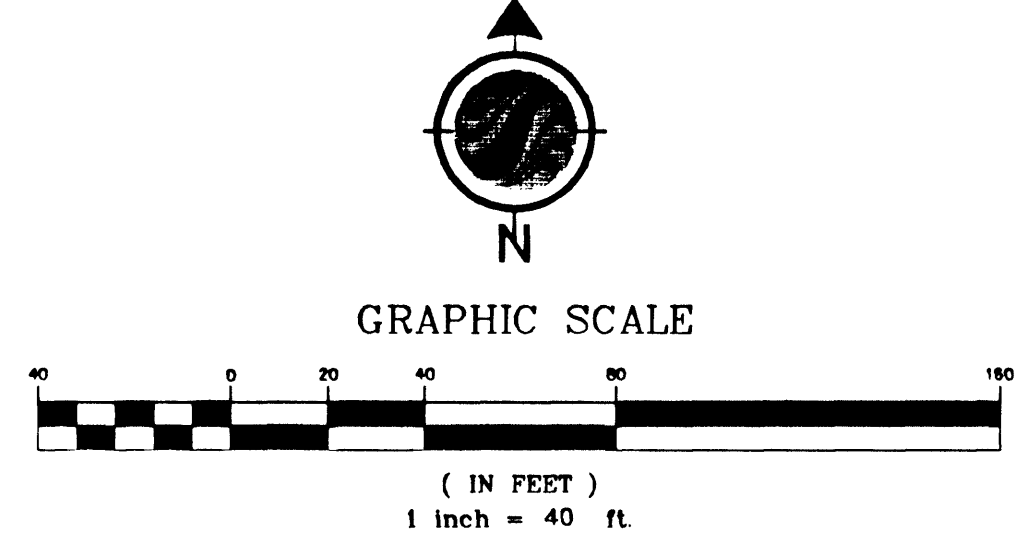

DATE: 9/26/2002
DRAWN BY: SLY
DESIGNED BY: T.M.G.
CHECKED BY: R.P.S.
ADA CHECKED: NA
JOB NO.: 88147052
SCALE: 1" = 40'

Stantec Consulting Inc.
7251 West Charleston Blvd.
Las Vegas NV 89117
Tel: 702.258.4956
Fax: 702.258.4956
www.stantec.com

Pulte
1635 VILLAGE CENTER CIRCLE, SUITE 250
LAS VEGAS, NEVADA 89134
(702) 258-7900

PULTE HOMES
HILLSTONE AT THE SUMMERLIN VISTAS
UTILITY, TRAFFIC & STREET LIGHTING PLAN 2

PROFESSIONAL ENGINEER STATE OF NEVADA
RICHARD P. SNEDECOR
11752
9/26/02

SHEET
13
OF 14
C.L.V. DWG #
307Y-4723-1