

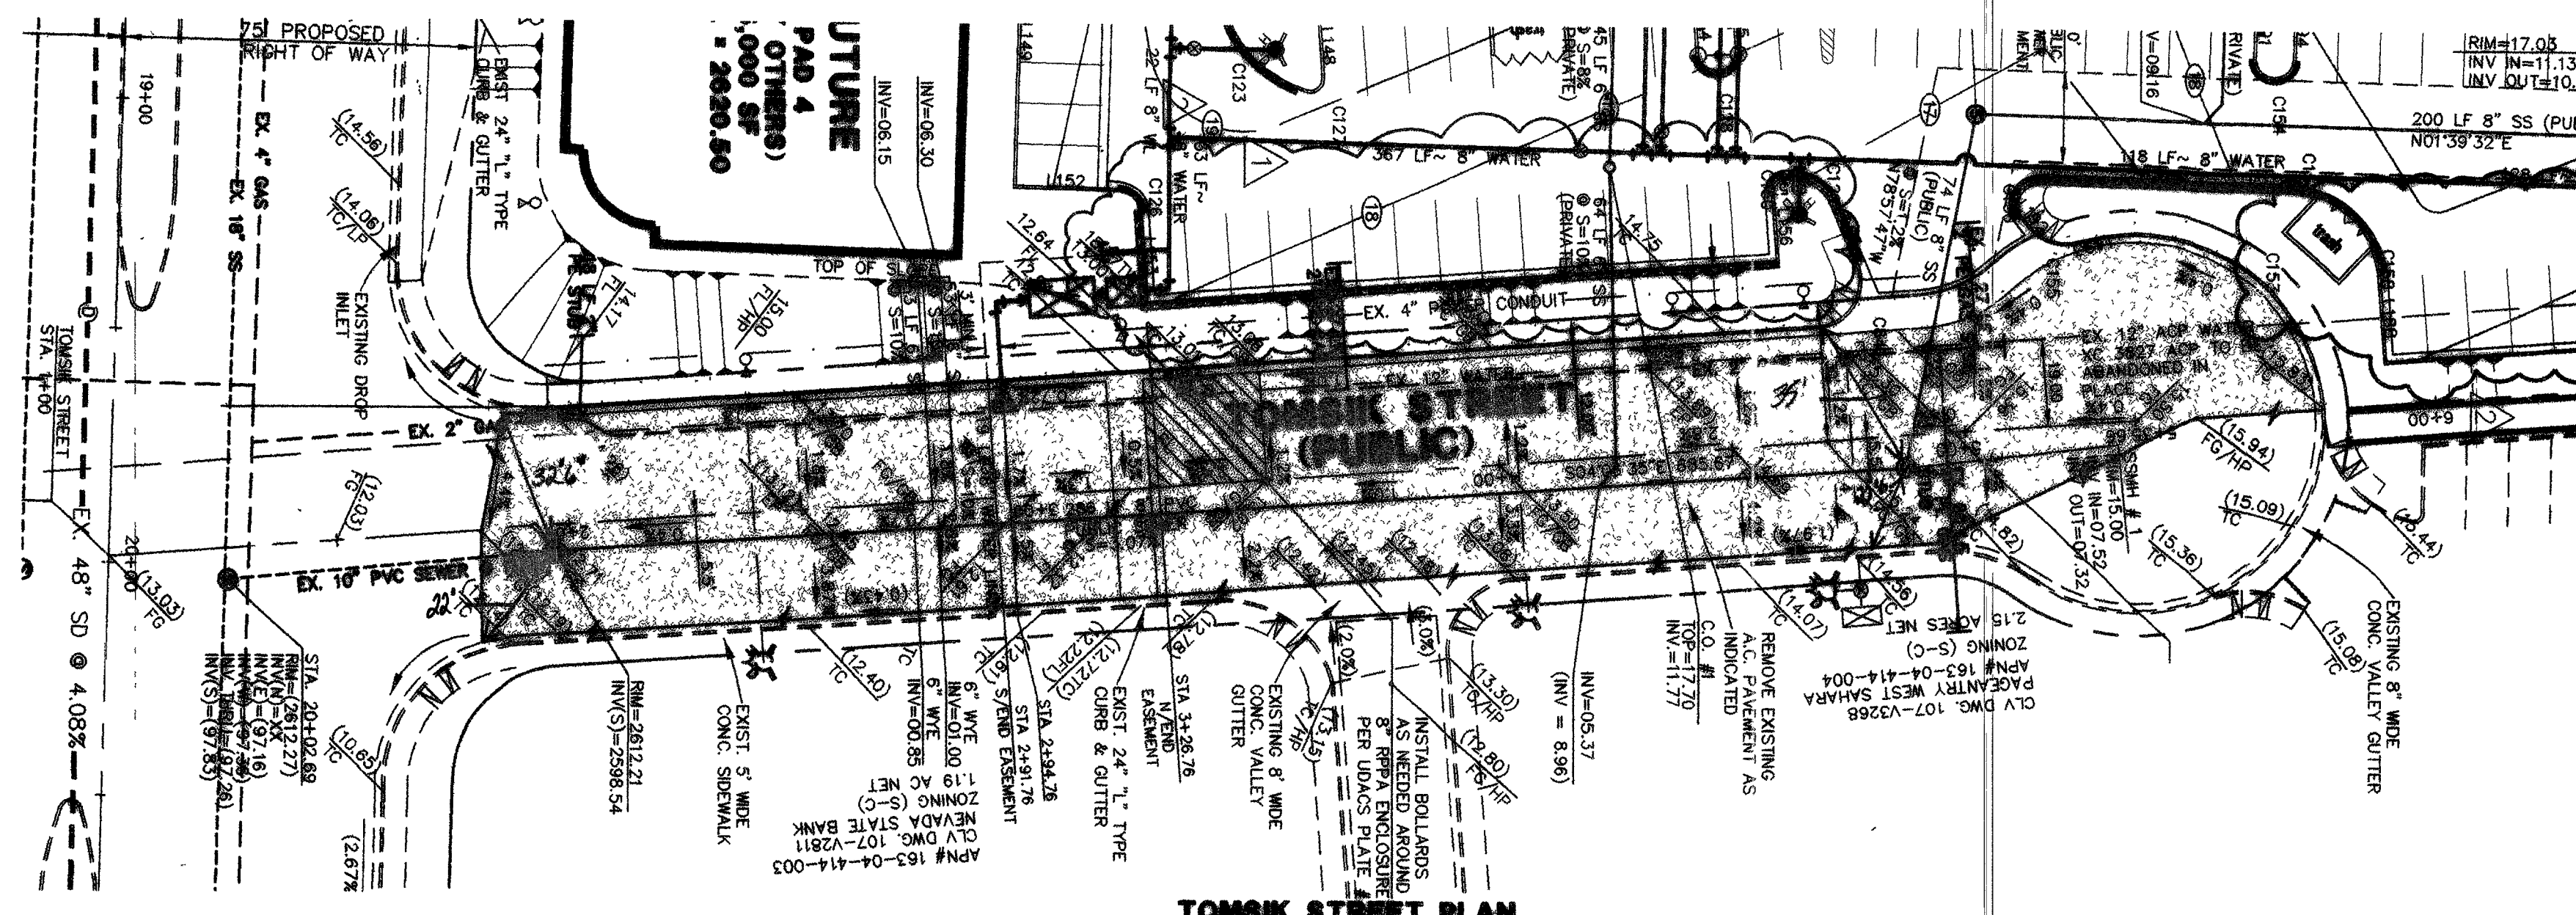


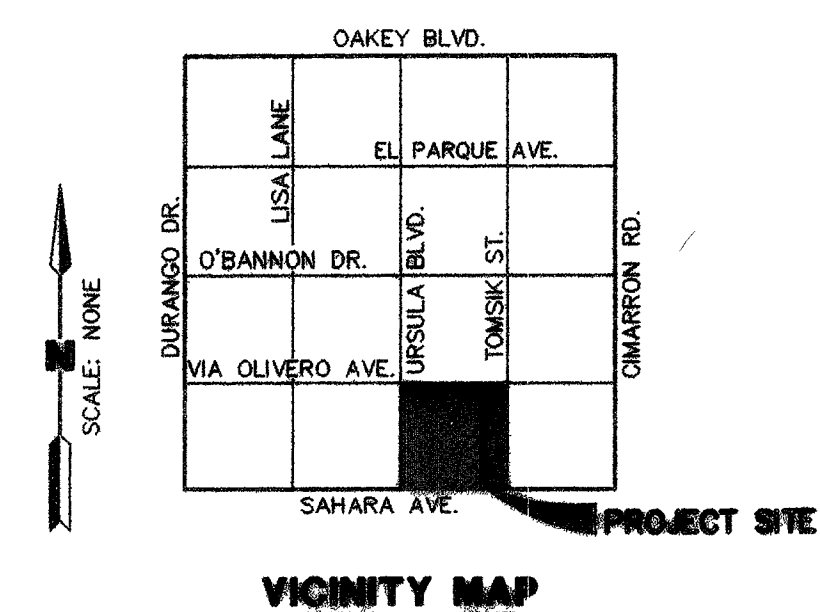

NOTE:
ONSET BROWN BEGINS AT
WEST END OF GUTTER.

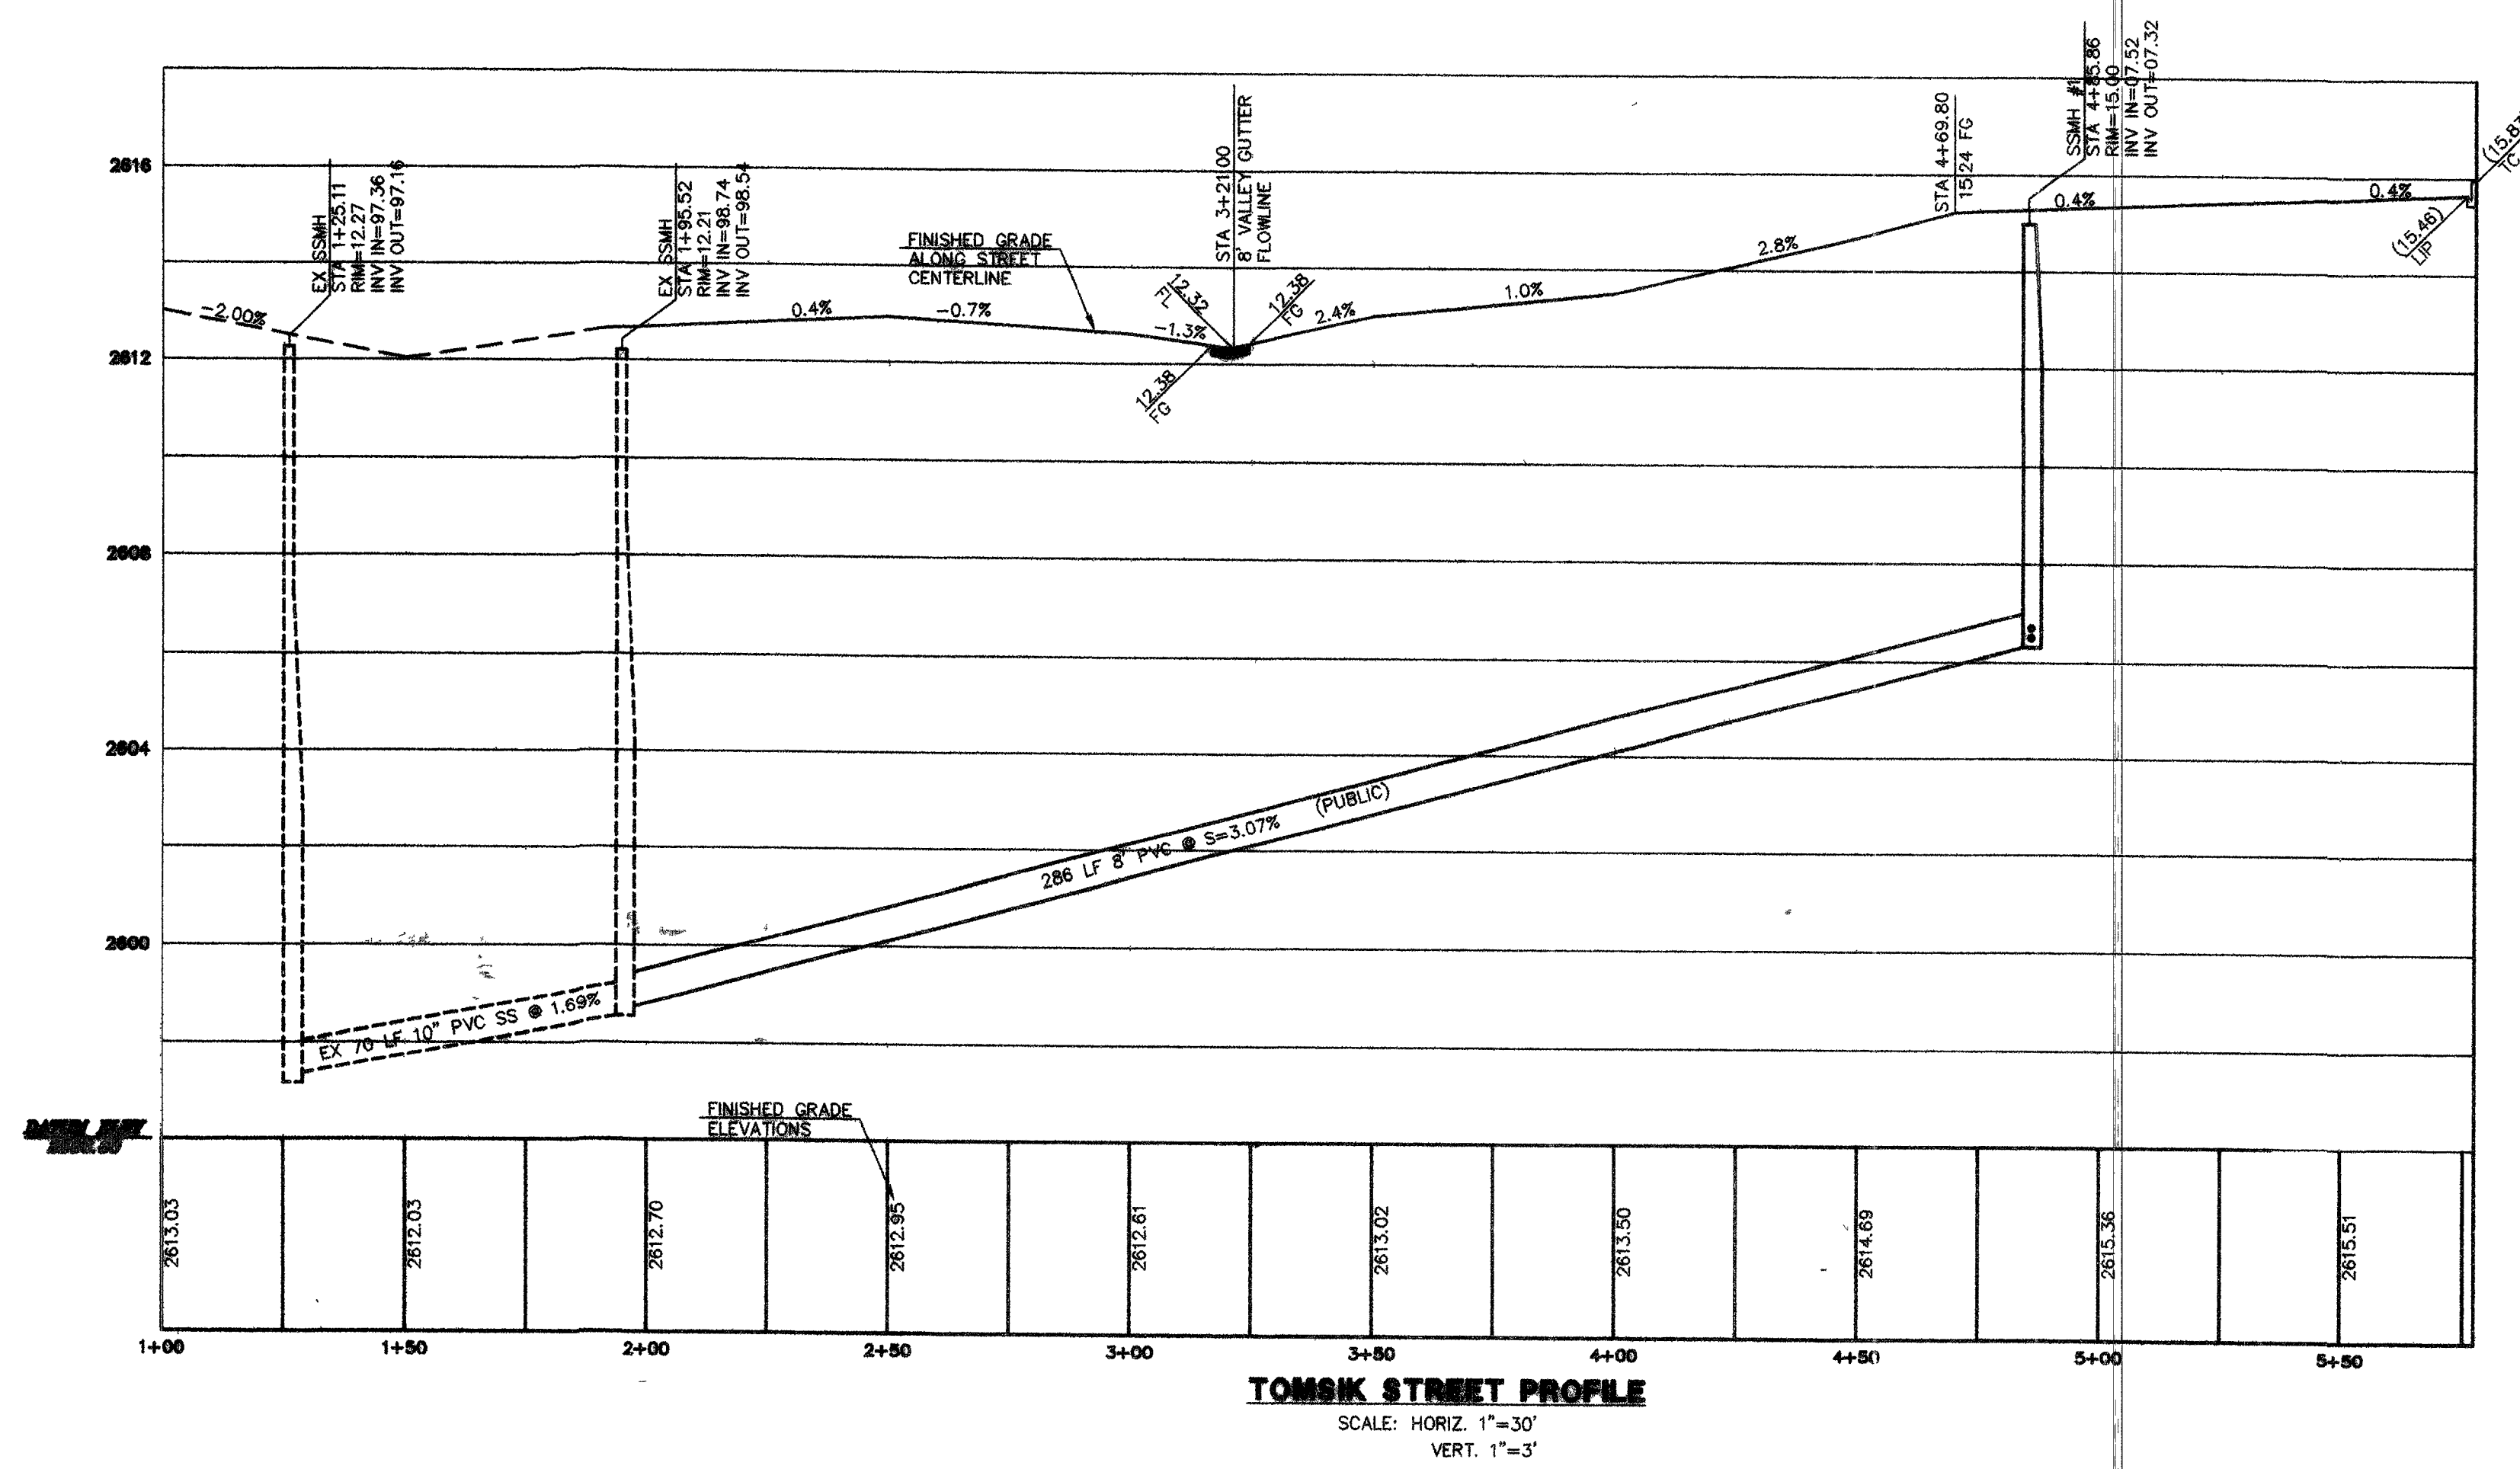


BASIS OF BEARINGS
SOUTH 88°20'28" EAST BEING THE SOUTH LINE OF THE SOUTHEAST QUARTER (SE 1/4) OF THE SOUTHWEST QUARTER (SW 1/4) OF SECTION 4, TOWNSHIP 21 SOUTH, RANGE 60 EAST, N.D.M., CLARK COUNTY, NEVADA, AS SHOWN IN BOOK 32 OF PLATS, PAGE 32, IN THE OFFICE OF THE CLARK COUNTY, NEVADA RECORDER.

BENCHMARK
CITY OF LAS VEGAS BENCHMARK NO. 1LV10 4SSW6 RIVET & PLATE IN THE TOP OF CURB 8260 W. SAHARA AVE. IN THE NORTH CURB LINE. (NE CORNER OF SAHARA & TOMSK)

OLD BENCHMARK ELEVATION
ELEVATION = 795.8136 METERS
(2610.93 U.S. SURVEY FEET) NAVD88 DATUM

NEW BENCHMARK ELEVATION
ELEVATION = 795.8314 METERS
(2610.99 U.S. SURVEY FEET) NAVD88 DATUM

METERS X $\left(\frac{3937}{1200}\right)$ = U.S. SURVEY FEET
1. THE ELEVATIONS SHOWN HEREON ARE BASED ON FEET.

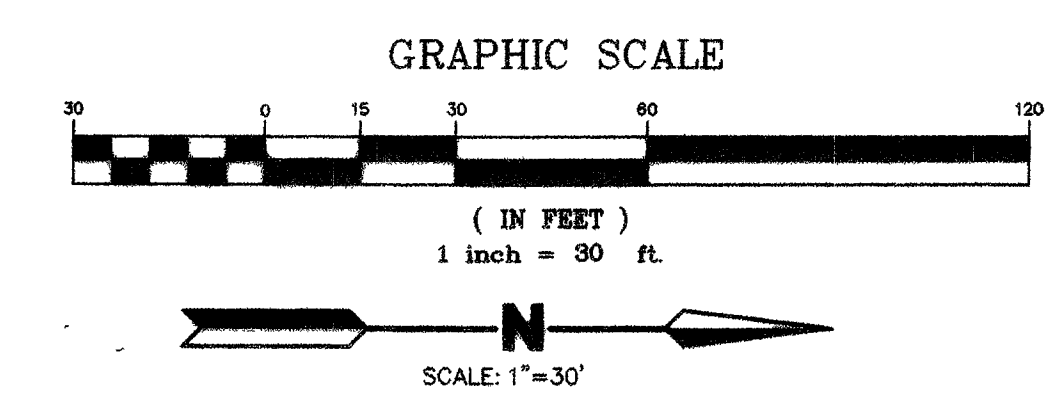

GREAT AMERICAN CAPITAL 8687 WEST SAHARA AVE. #201 LAS VEGAS, NEVADA 89117 (702)233-5751 FAX (702)360-5594		WRIGHT CIVIL ENGINEERS, INC 7310 SMOKE RANCH ROAD, SUITE P LAS VEGAS, NEVADA 89128 TEL (702) 233-6400 FAX (702) 233-1164	
DATE	REV	DATE	REV
5/24/02	1		
TOMSK STREET PLAN AND PROFILE		GREAT AMERICAN PLAZA	
DRAWN BY:	DESIGNED BY:	CHECKED BY:	PROJECT NO.:
CJB	JEP	SFC	CN2210301
DATE:	DATE:	DATE:	SCALE:
09-26-02	09-26-02		1"=30'
SHEET PP1 14 OF 15 SHEETS		DRAWING NO. 10744745	

Call before you Dig.
1-800-227-2600
UNDERGROUND UTILITY LOCATING SERVICE

Call before you OVERHEAD
1-702-563-6111
OVERHEAD POWER LINE LOCATING SERVICE

DISCLAIMER NOTE
EXISTING UTILITY LOCATIONS SHOWN HEREIN ARE APPROXIMATE ONLY. IT SHALL BE THE CONTRACTOR'S RESPONSIBILITY TO DETERMINE THE EXACT VERTICAL AND HORIZONTAL LOCATION OF ALL EXISTING UNDERGROUND UTILITIES PRIOR TO COMMENCING CONSTRUCTION. NO REPRESENTATION IS MADE THAT ALL EXISTING UTILITIES ARE SHOWN HEREON. THE ENGINEER ASSUMES NO RESPONSIBILITY FOR UTILITIES NOT SHOWN OR UTILITIES NOT SHOWN IN THEIR PROPER LOCATION. ALL DISCREPANCIES MUST BE IMMEDIATELY REPORTED TO THE ENGINEER. CALL BEFORE YOU DIG: 1-800-227-2600.

99032
52993
KL

— SEWER AS BUILT —