


SEE DRAWING C-30
FOR DRAINAGE PLAN

SEE DRAWING U-16
FOR SANITARY SEWER

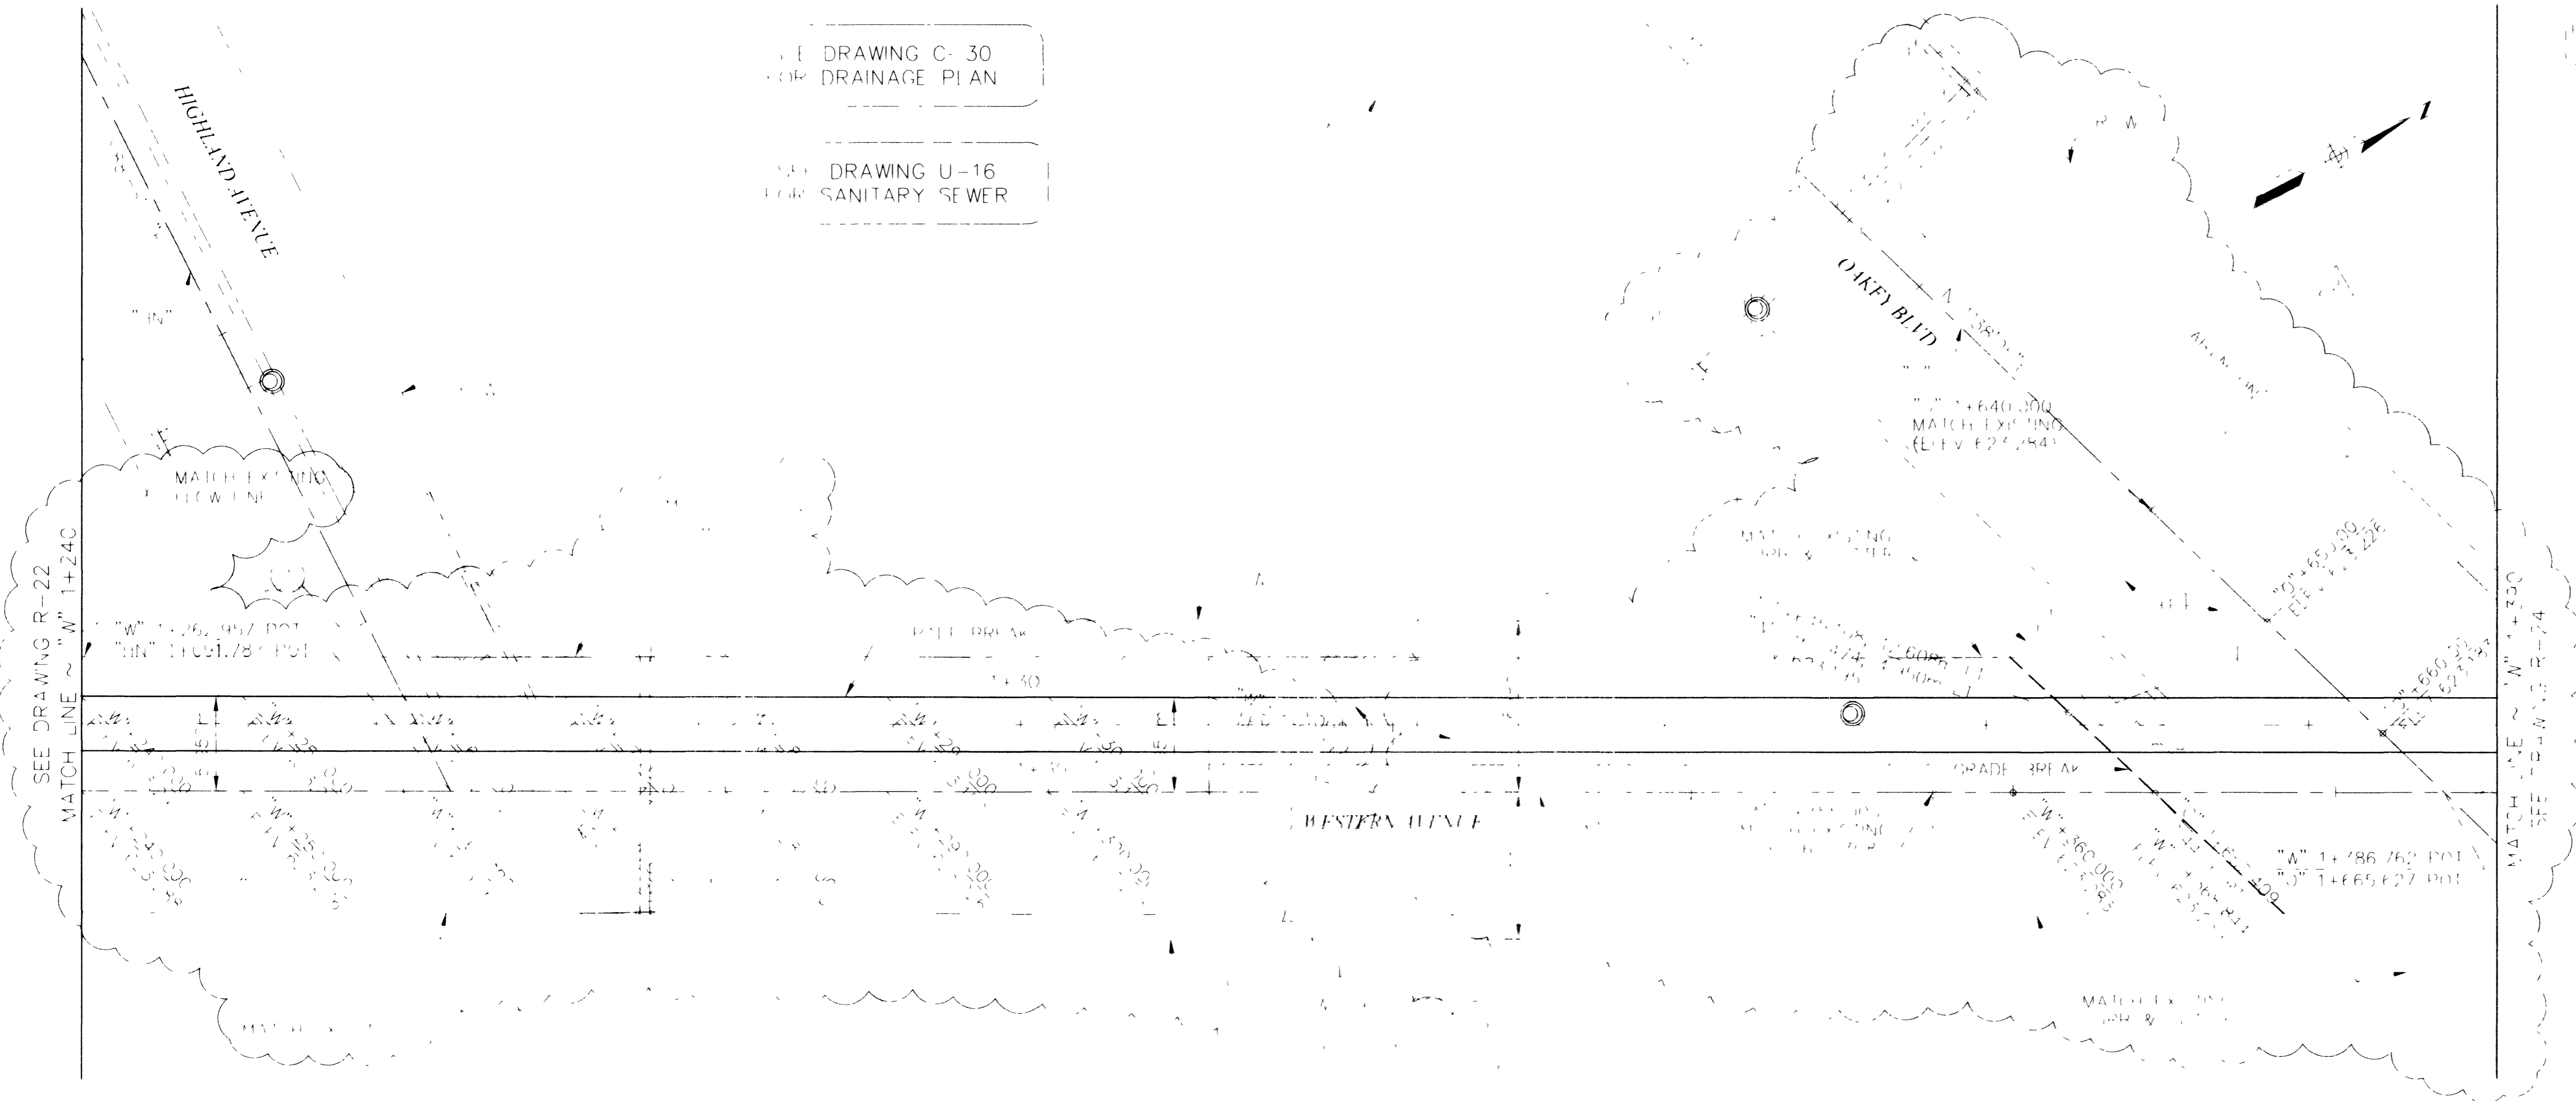


- REMOVAL ITEMS
- REMOVE ASPHALT PAVEMENT
 - REMOVE CROSS CUTTER

LEGEND

ALL DIMENSIONS IN FEET
UNLESS OTHERWISE NOTED

<p>Call before you Dig.</p> <p>1-800-277-2800</p> <p>UNDERGROUND SERVICE (USA)</p>	<p>Call before you Overhead</p> <p>563-6111</p> <p>OVERHEAD SERVICE (USA)</p>
--	---

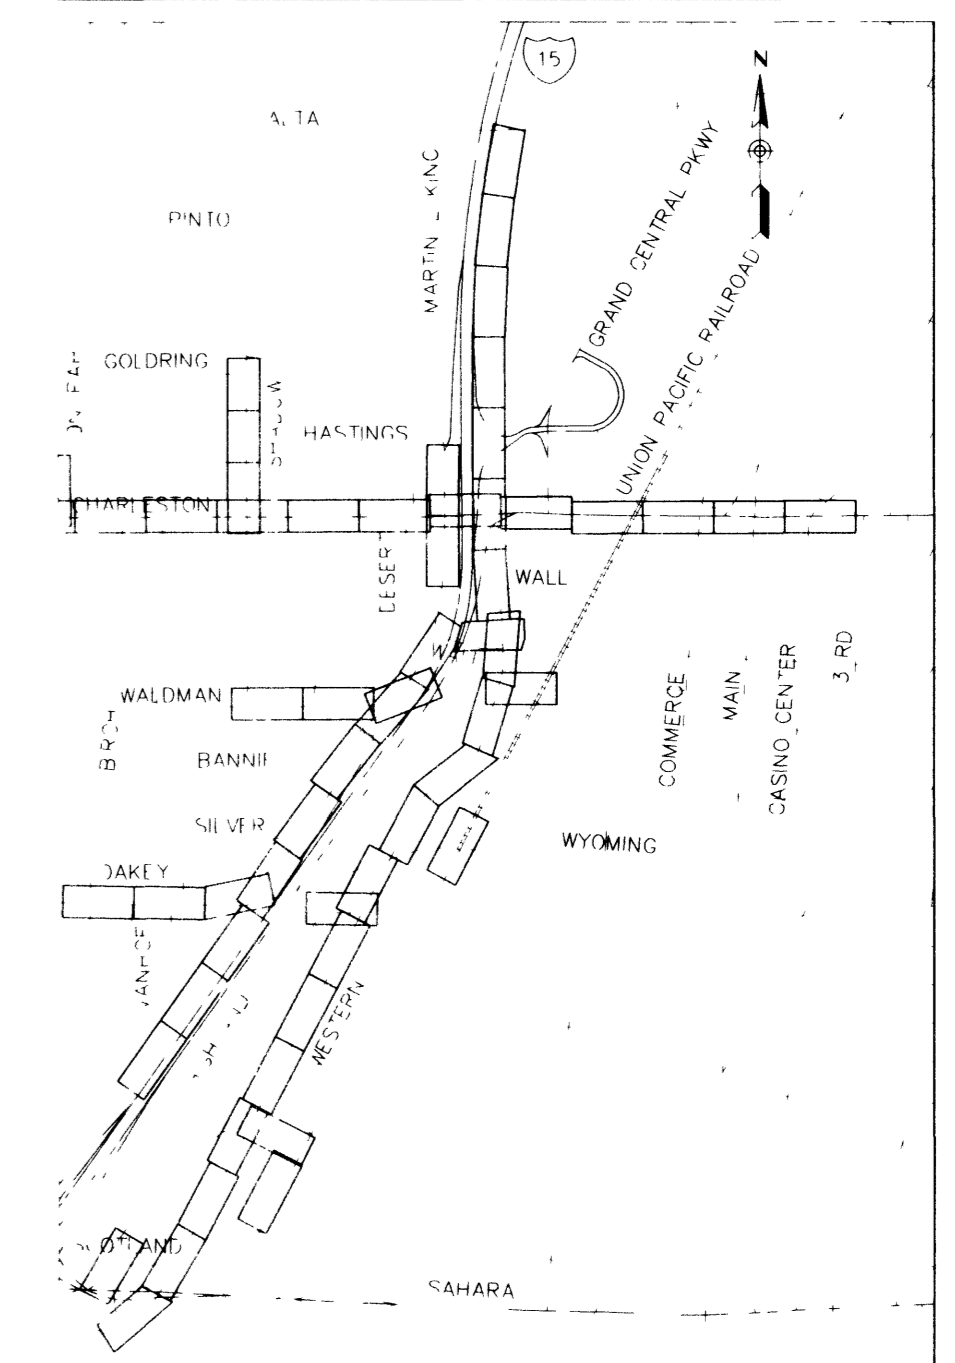

DATE: DECEMBER 11, 1998
DESIGN BY: BPD

PROJECT # 1-15
SHEET # 119

P3 PARSONS BRINCKERHOFF




DEPARTMENT OF PUBLIC WORKS

I-15 FREEWAY CHANNEL

CONSTRUCTION PLAN AND PROFILE

"W" 1+240 TO "W" 1+390

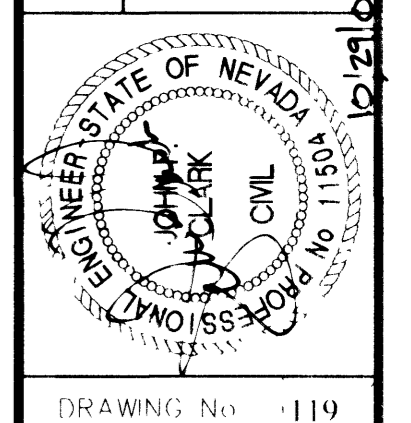

DRAWING No. 119

R-23

3288

METRIC

RE-LOT 327-V254