


- REMOVAL ITEMS**
- [T] REMOVE MH
- CONSTRUCTION ITEMS**
- ① "W" 2+140.000, 4.169m LT TO CONSTRUCT 375mm SANITARY SEWER PIPE
  - "W" 2+170.000, 2.075m LT
  - "W" 2+170.000, 2.075m LT TO
  - "W" 2+178.169, 1.504m LT
  - "W" 2+162.256, 5.690m RT TO
  - "W" 2+162.958, 4.100m RT
  - "W" 2+162.958, 4.100m RT TO
  - "W" 2+170.000, 2.075m LT
  - ② "W" 2+178.169, 1.504m LT CONSTRUCT TYPE I SANITARY SEWER MH
  - "W" 2+162.256, 5.690m RT
  - ④ "W" 2+170.000, 2.075m LT CONSTRUCT TYPE I T-LOCK LINED SANITARY SEWER MH

SEE DRAWING C-11 FOR DRAINAGE PLAN

SEE DRAWING R-29 AND R-30 FOR ROADWAY

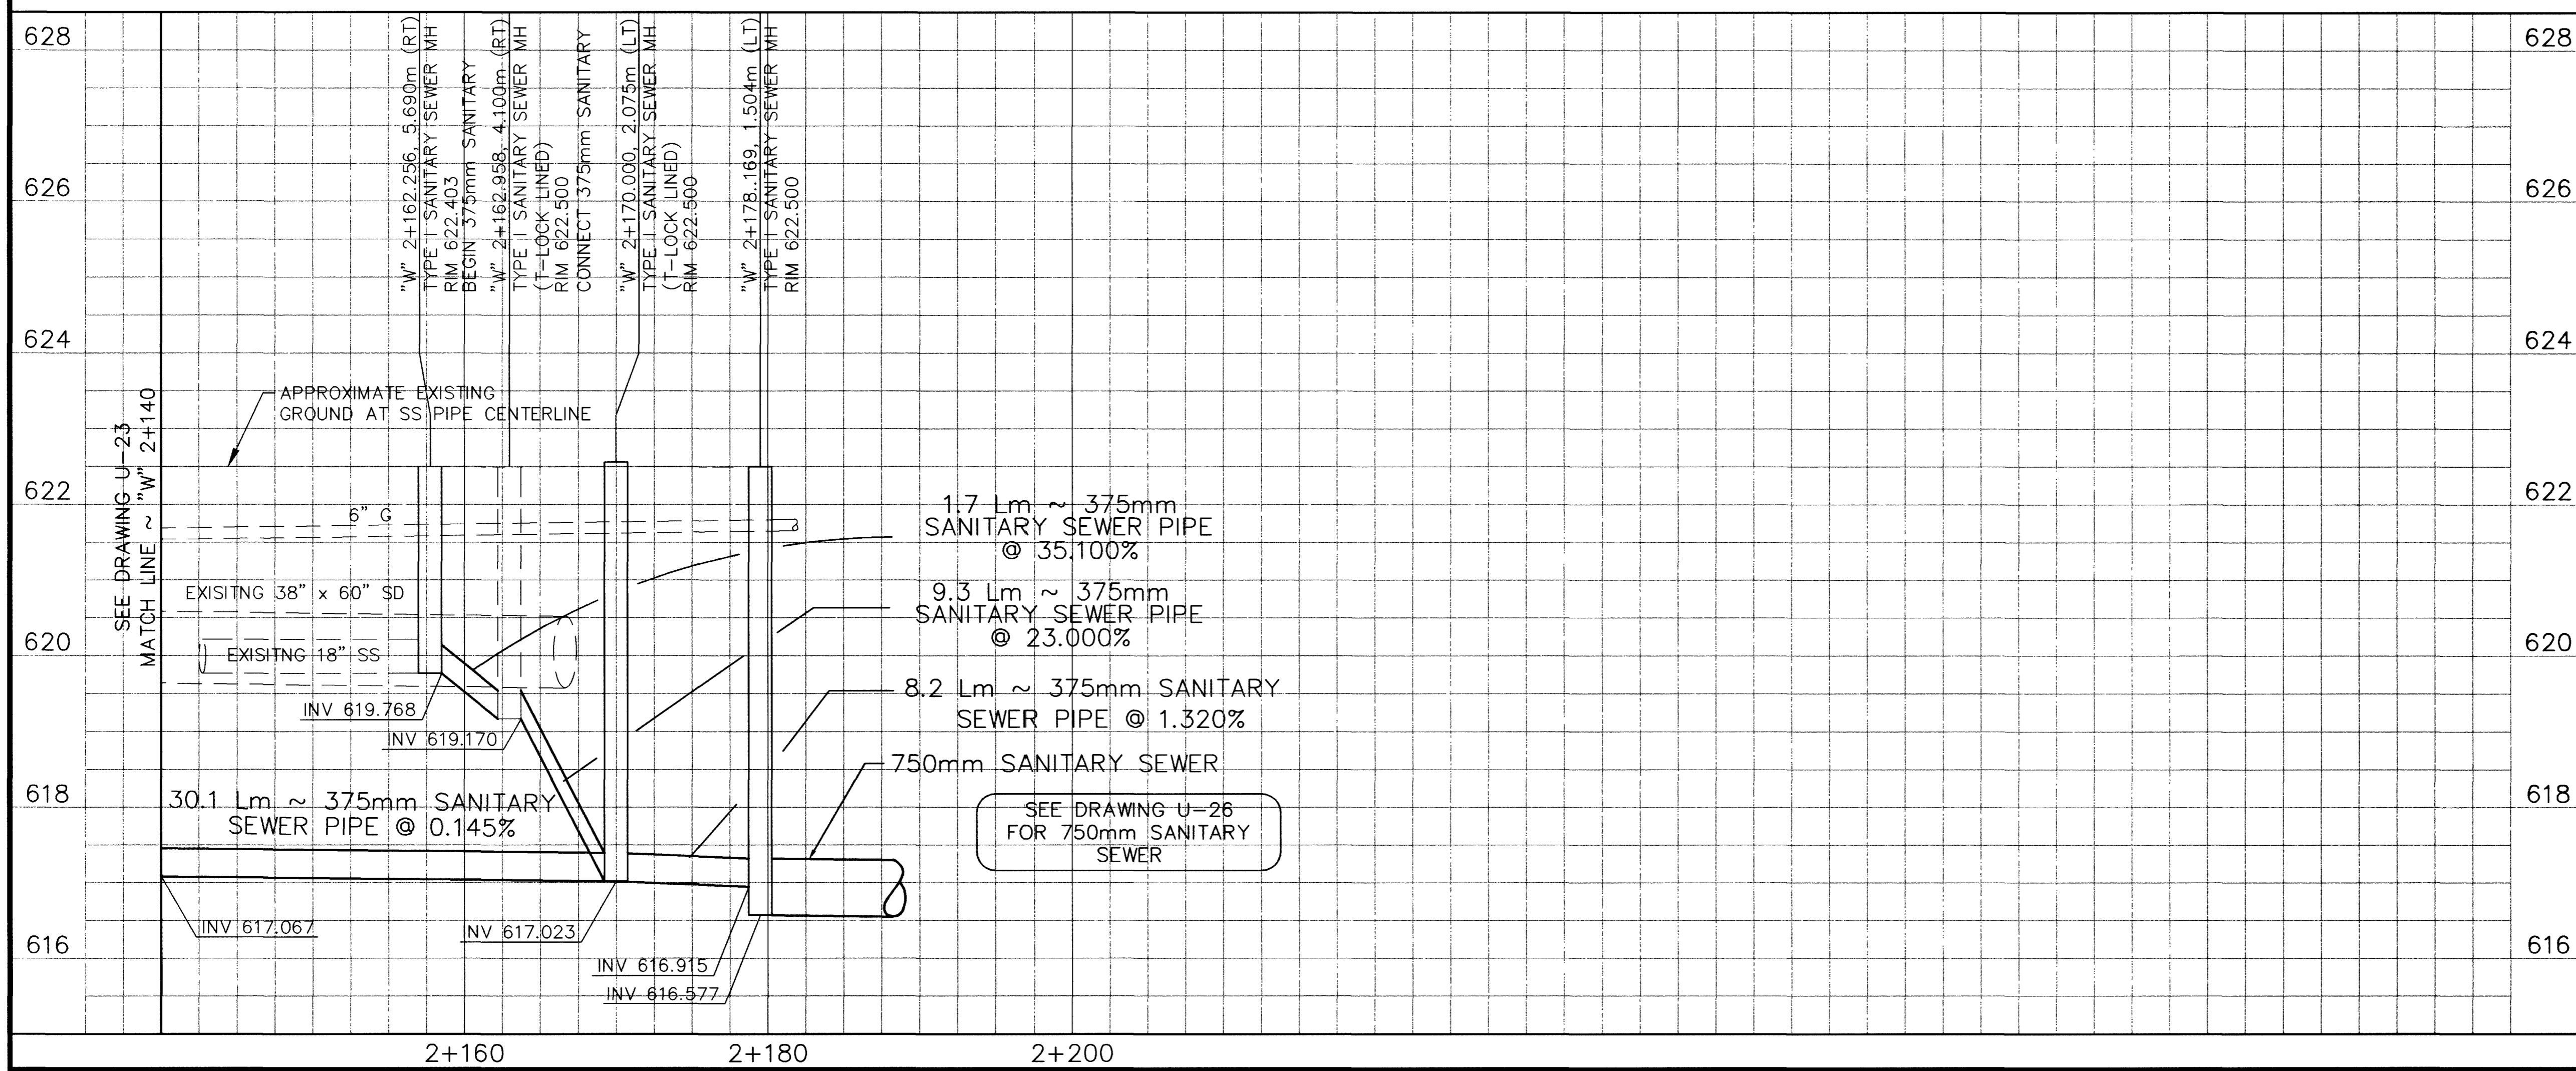


APPROVED FOR CONSTRUCTION

LAS VEGAS VALLEY WATER DISTRICT DATE

**Call before you Dig.**  
1-800-227-2600  
UNDERGROUND SERVICE (USA)

**Call before you Crane.**  
227-2929  
OVERHEAD SERVICE (USA)

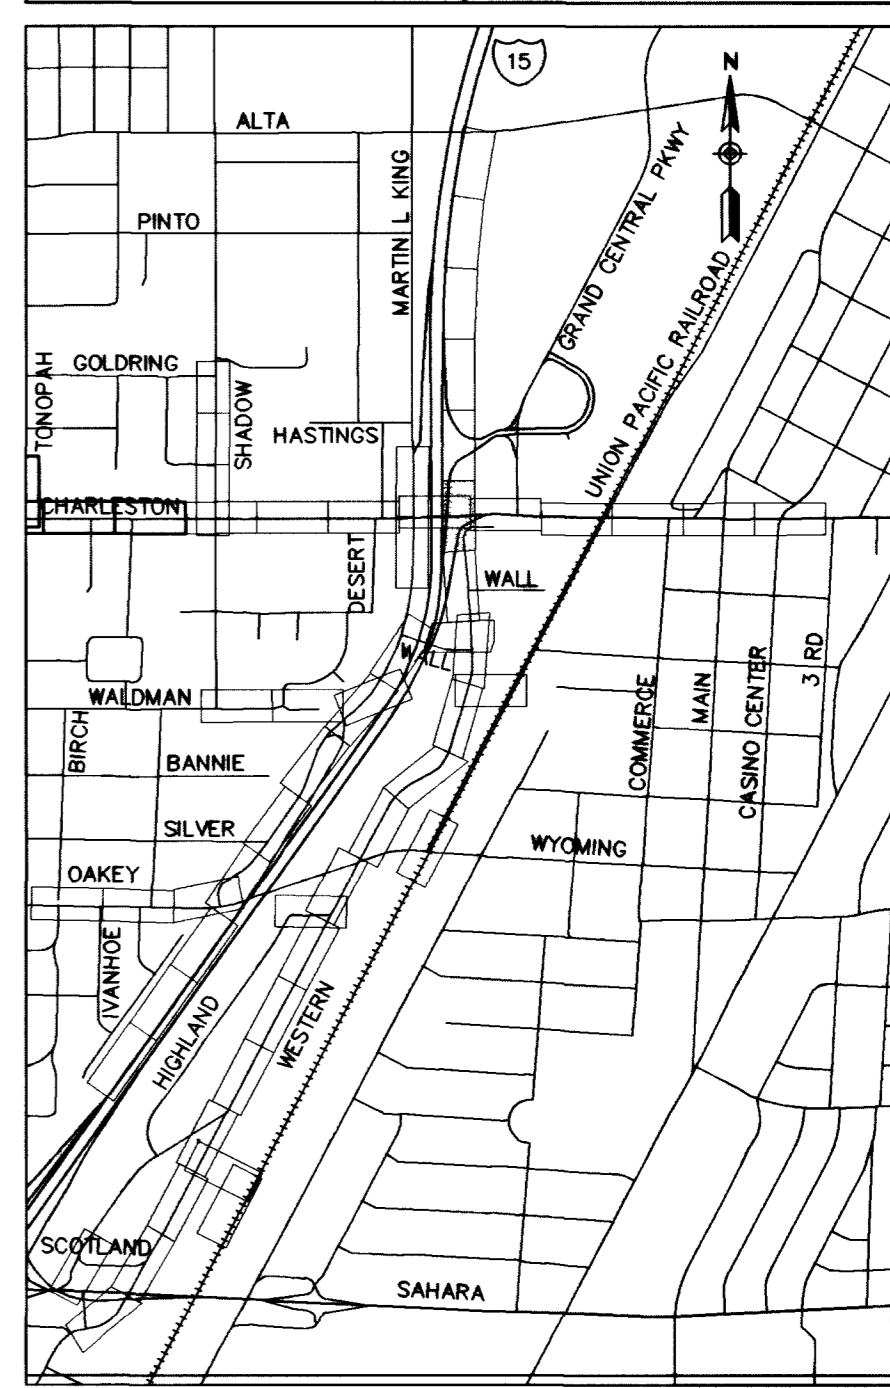

DATE: 3/20/00 / 4/20/03

REVISIONS: APPENDUM 2 RECORD DRAWING

SCALE (V): 1:50 DATE: DEC 17, 1999 DESIGN BY: BPP

SCALE (H): 1:250 FLD. BK. # N/A

PROJECT # 31604 PROJECT: I-15 FREEWAY CHANNEL

DESIGN BY: BPP

**PARSONS BRINCKERHOFF**  
Las Vegas, Nevada

STATE OF NEVADA PROFESSIONAL ENGINEER JOHN P. CLARK C.E.C.

DEPARTMENT OF PUBLIC WORKS  
I-15 FREEWAY CHANNEL  
UTILITY RELOCATION (WESTERN AVE)  
"W" 2+140 TO "W" 2+181.21

DRAWING No. 183 U-24 241