


- CONSTRUCTION ITEMS
- ① "Xm" 3+107.500, 0.650m LT TO CONSTRUCT 250mm SANITARY SEWER PIPE
 - ② "Xm" 3+110.000, 1.430m LT CONSTRUCT TYPE I SANITARY SEWER MANHOLE

SEE DRAWING R-33 FOR ROADWAY

SEE DRAWING C-41 FOR DRAINAGE PLAN

MATCH LINE ~ "Xm" 3+110
SEE DRAWING U-26

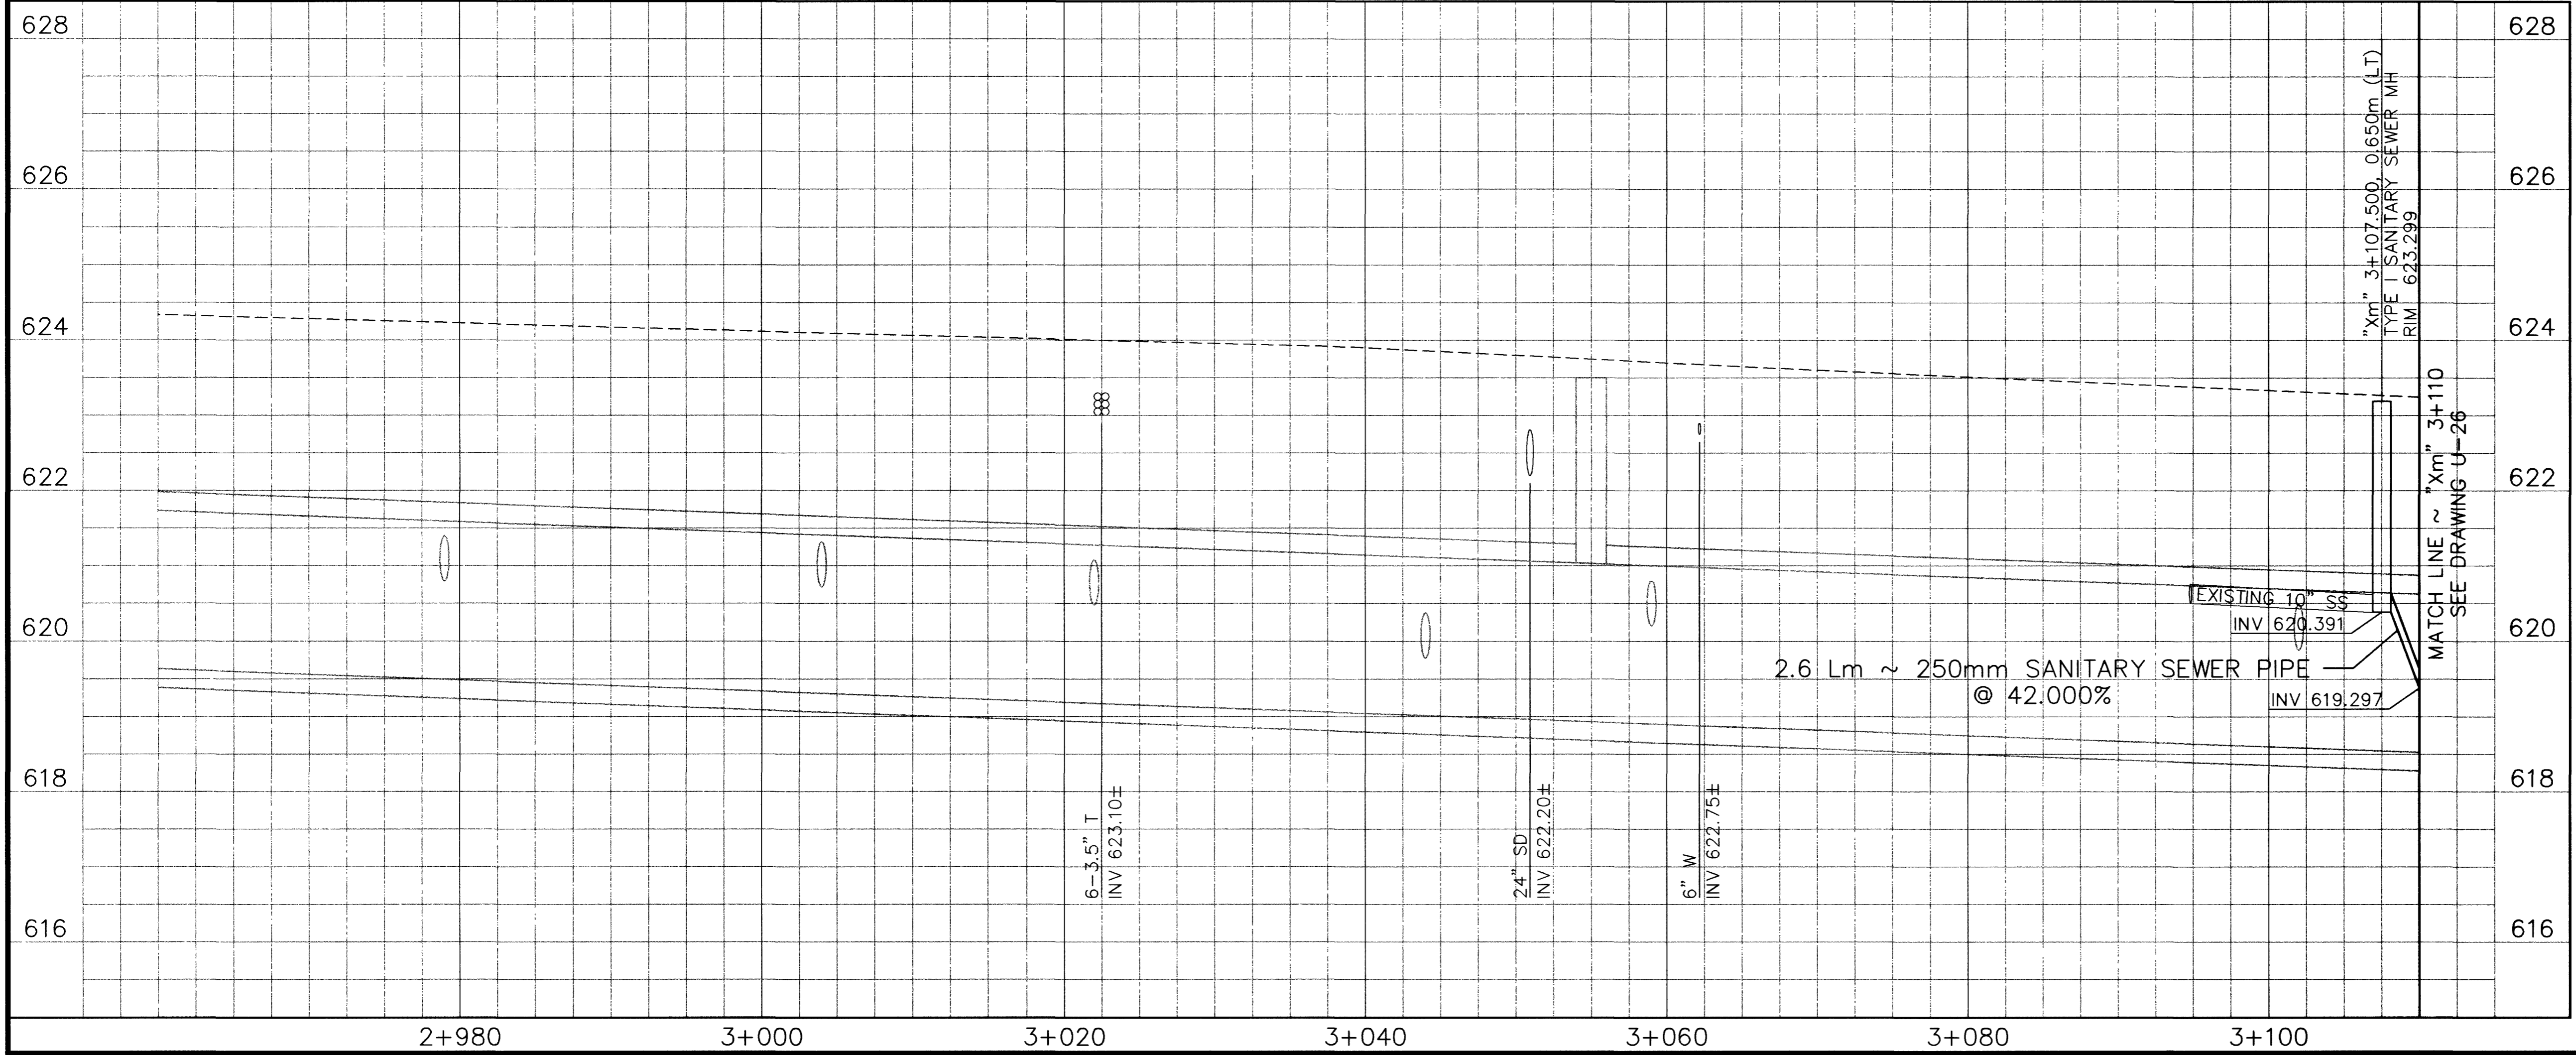


APPROVED FOR CONSTRUCTION

LAS VEGAS VALLEY WATER DISTRICT DATE

Call before you Dig.
1-800-277-2600
UNDERGROUND SERVICE (USA)

Call before you Overhead
563-6111
OVERHEAD SERVICE (USA)

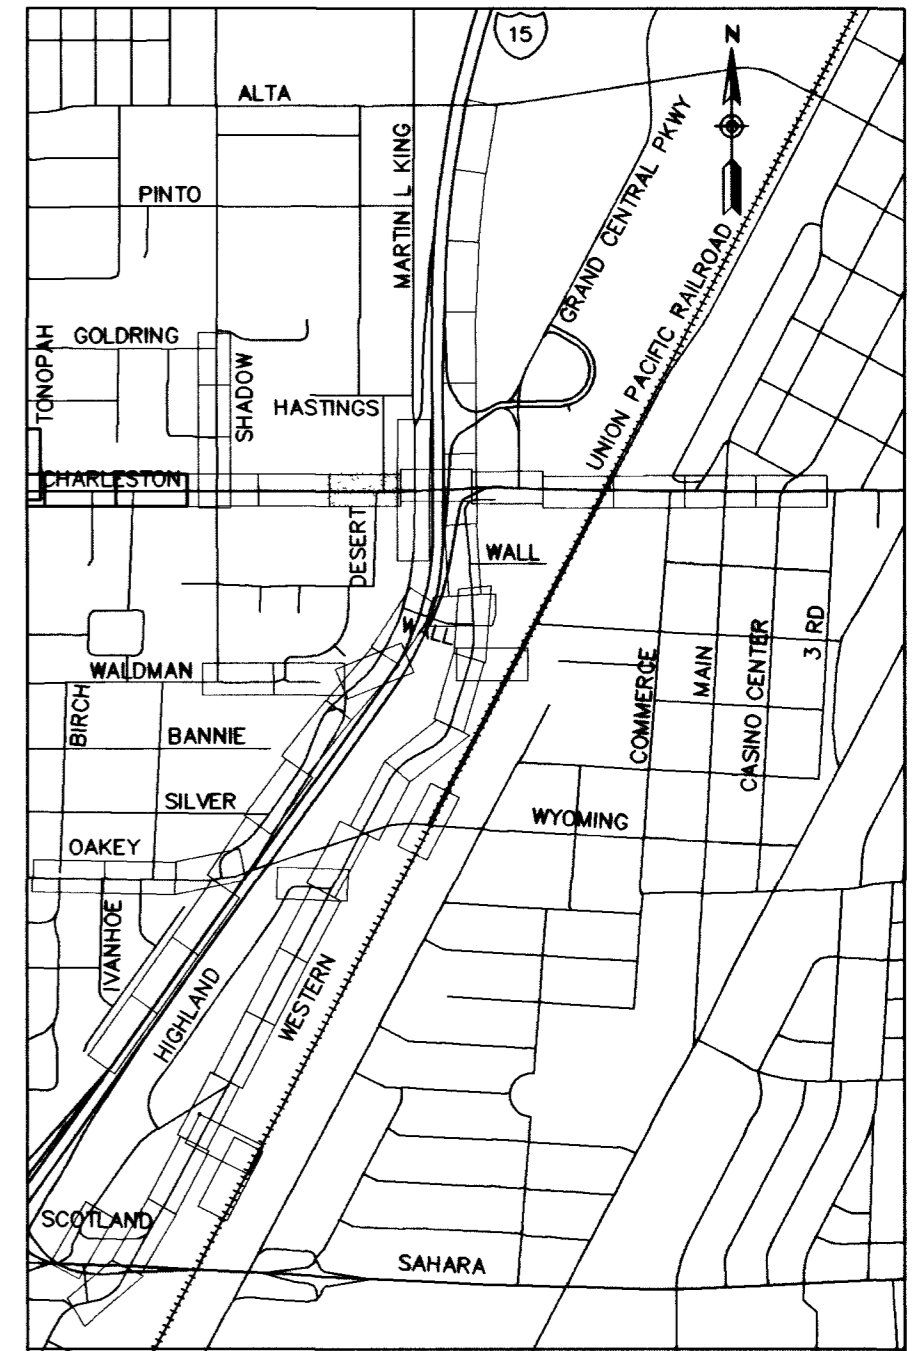

DATE	4/30/03
REVISIONS	
RECORD DRAWING	
PROJECT #	31604
DESIGN BY	KFN
SCALE (V)	1:50
DATE	DEC 17, 1999
SCALE (H)	1:250
F.L.D. BK. #	N/A

PARSONS BRINCKERHOFF
Las Vegas, Nevada

STATE OF NEVADA
REGISTERED PROFESSIONAL ENGINEER
JOHN P. CLARK
C.E.

DRAWING No. 184
U-25 241

DEPARTMENT OF PUBLIC WORKS
I-15 FREEWAY CHANNEL
UTILITY RELOCATION (CHARLESTON BLVD)
"Xm" 2+960 TO "Xm" 3+110