


- CONSTRUCTION ITEMS**
- ① "W" 1+210.000, 7.400m LT CONSTRUCT TYPE I SANITARY SEWER MH
  - ② "W" 1+090.000, 7.400m LT TO  
"W" 1+210.000, 7.400m LT TO  
"W" 1+210.000, 7.400m LT TO  
"W" 1+240.000, 7.400m LT TO CONSTRUCT 200mm SANITARY SEWER PIPE
  - ③ "W" 1+213.500, 5.500m RT TO  
"W" 1+222.500, 5.500m RT TO RELOCATE 200mm WATER LINE SEE DETAIL DRAWING U-40

SEE DRAWING C-29  
FOR DRAINAGE PLAN

SEE DRAWING R-22  
FOR ROADWAY

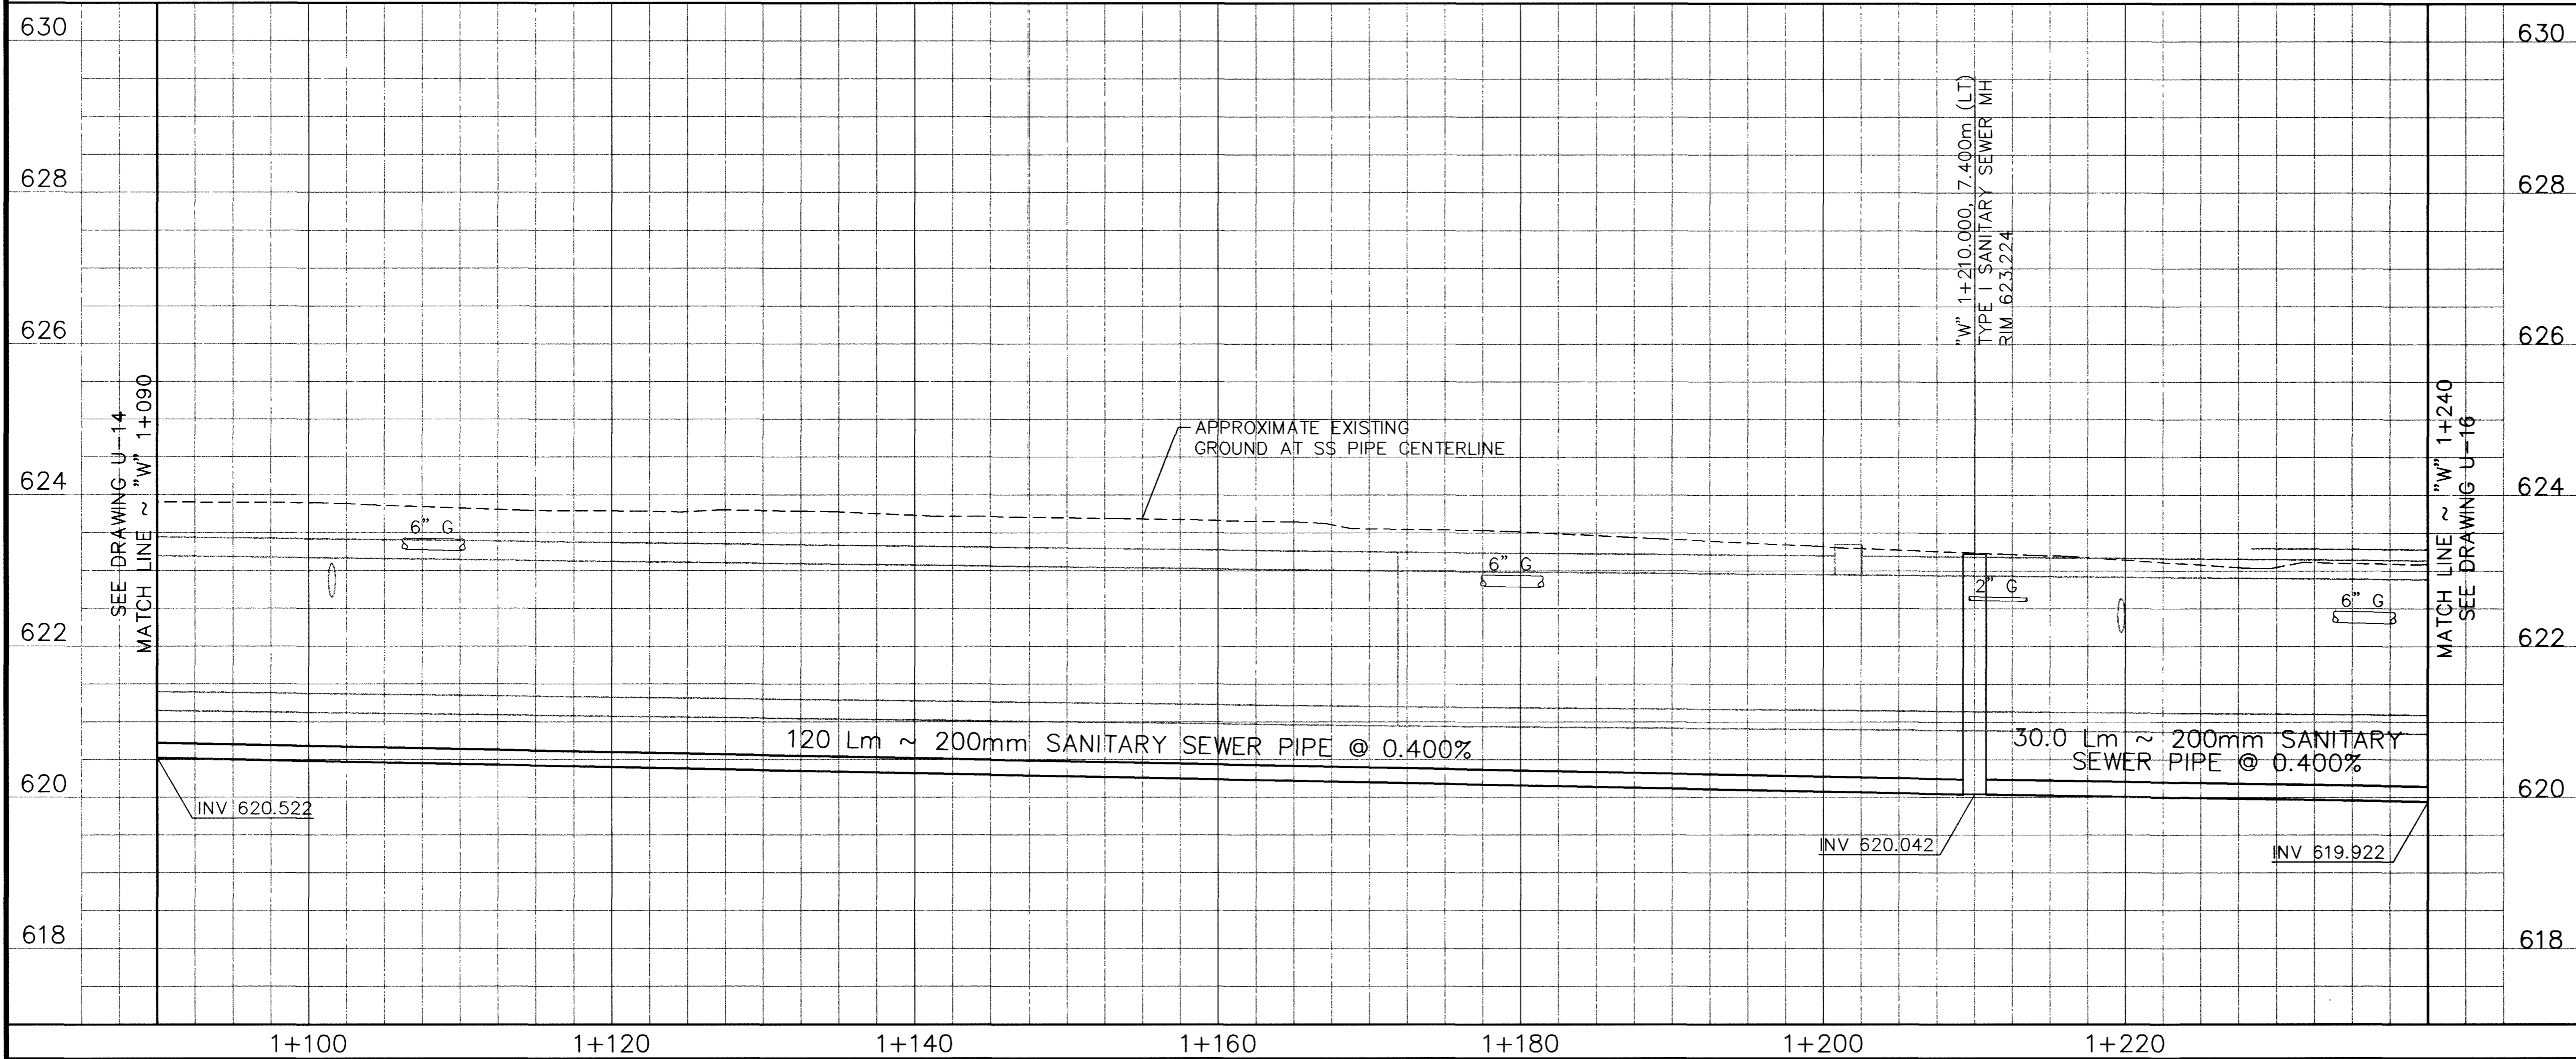


APPROVED FOR CONSTRUCTION

LAS VEGAS VALLEY WATER DISTRICT DATE

**Call before you Dig.**  
1-800-277-2600  
UNDERGROUND SERVICE (USA)

**Call before you Overhead**  
563-6111  
OVERHEAD SERVICE (USA)

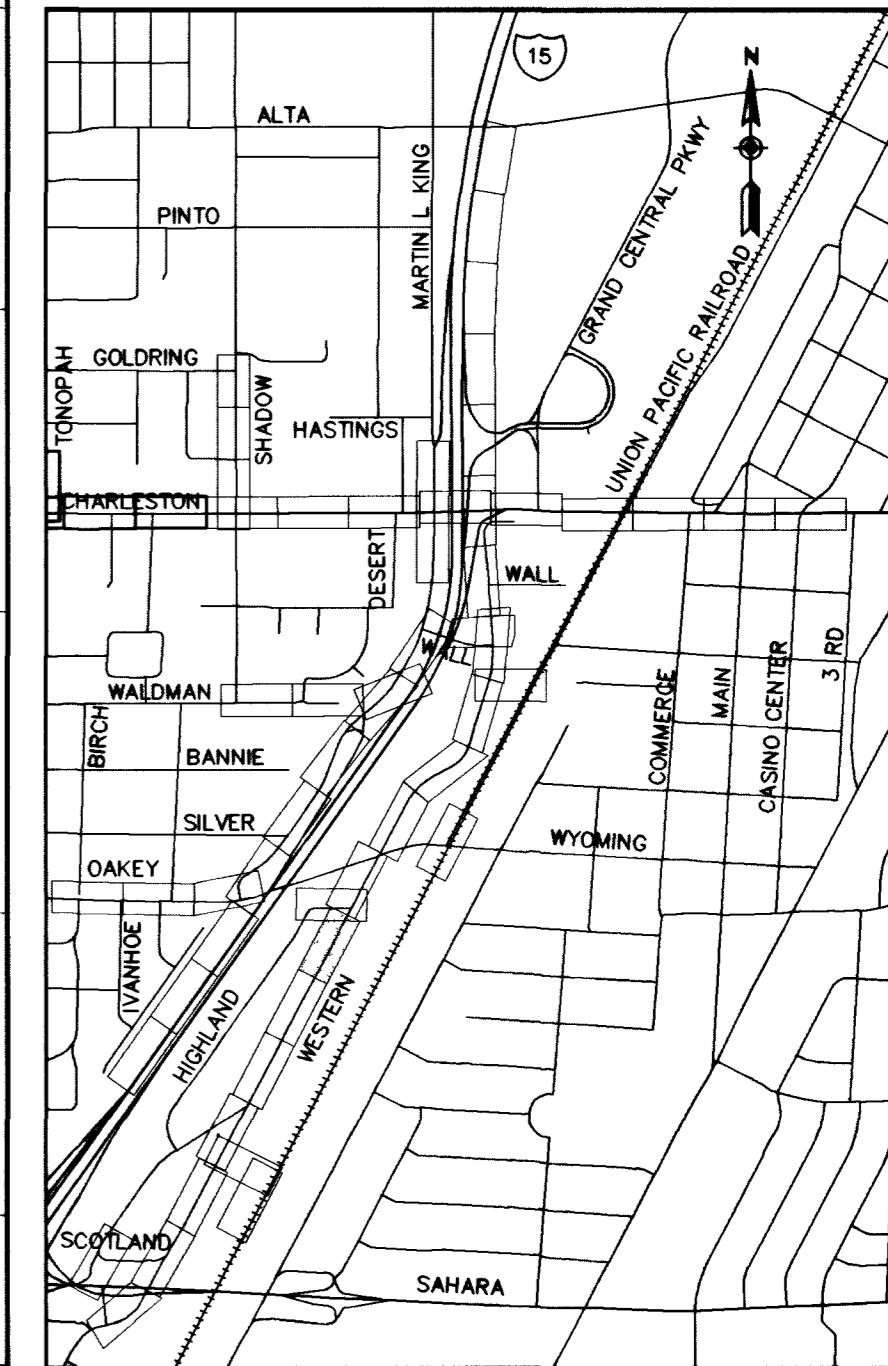

DATE	4/30/03
REVISIONS	
RECORD DRAWING	
PROJECT #	31604
DESIGN BY	KFN
SCALE (V)	1:50
DATE	DEC 17, 1999
SCALE (H)	1:250
F.L.D. Bk. #	N/A

**PARSONS BRINCKERHOFF**  
Las Vegas, Nevada

**DEPARTMENT OF PUBLIC WORKS**  
I-15 FREEWAY CHANNEL  
UTILITY RELOCATION (WESTERN AVE)  
"W" 1+090 TO "W" 1+240

**RECORD DRAWING METRIC**

DRAWING No. 174  
**U-15**  
241

327-V254

52620