

SS CURVE TABLE


No.	Δ	R	L	T
W1	34°16'15"	159.806m	95.586m	49.271m
W3	45°31'30"	75.754m	60.191m	31.786m

SEE DRAWING U-20 FOR SANITARY SEWER PROFILE

SEE DRAWING C-32 FOR DRAINAGE PLAN

SEE DRAWING R-25 FOR ROADWAY

- CONSTRUCTION ITEMS**
- ① "W" 1+597.364, 1,000m LT CONSTRUCT TYPE I SANITARY SEWER MH
 - "W" 1+635.629, 7,405m LT
 - "W" 1+648.000, 0,000m LT
 - ② "W" 1+540.000, 7,405m LT TO CONSTRUCT 200mm SANITARY SEWER PIPE
 - "W" 1+597.364, 7,405m LT TO
 - "W" 1+635.629, 7,405m LT TO
 - "W" 1+635.629, 7,405m LT TO
 - "W" 1+690.000, 7,405m LT
 - ③ "W" 1+558.900 LT RECONNECT EX SANITARY SEWER LATERAL
 - "W" 1+607.500 LT
 - "W" 1+620.800 RT
 - "W" 1+641.100 LT
 - "W" 1+658.600 LT
 - ④ "W" 1+600.000, 1,000m LT TO CONSTRUCT 300mm SANITARY SEWER PIPE
 - "W" 1+648.000, 1,000m LT
 - "W" 1+648.000, 1,000m LT TO
 - "W" 1+683.760, 1,510m RT
 - ⑥ "W" 1+554.500 LT RECONNECT EX WATER SERVICE PER LVVWD UDS PLATE No. 1B OR 1D
 - "W" 1+608.800 LT
 - "W" 1+658.500 LT

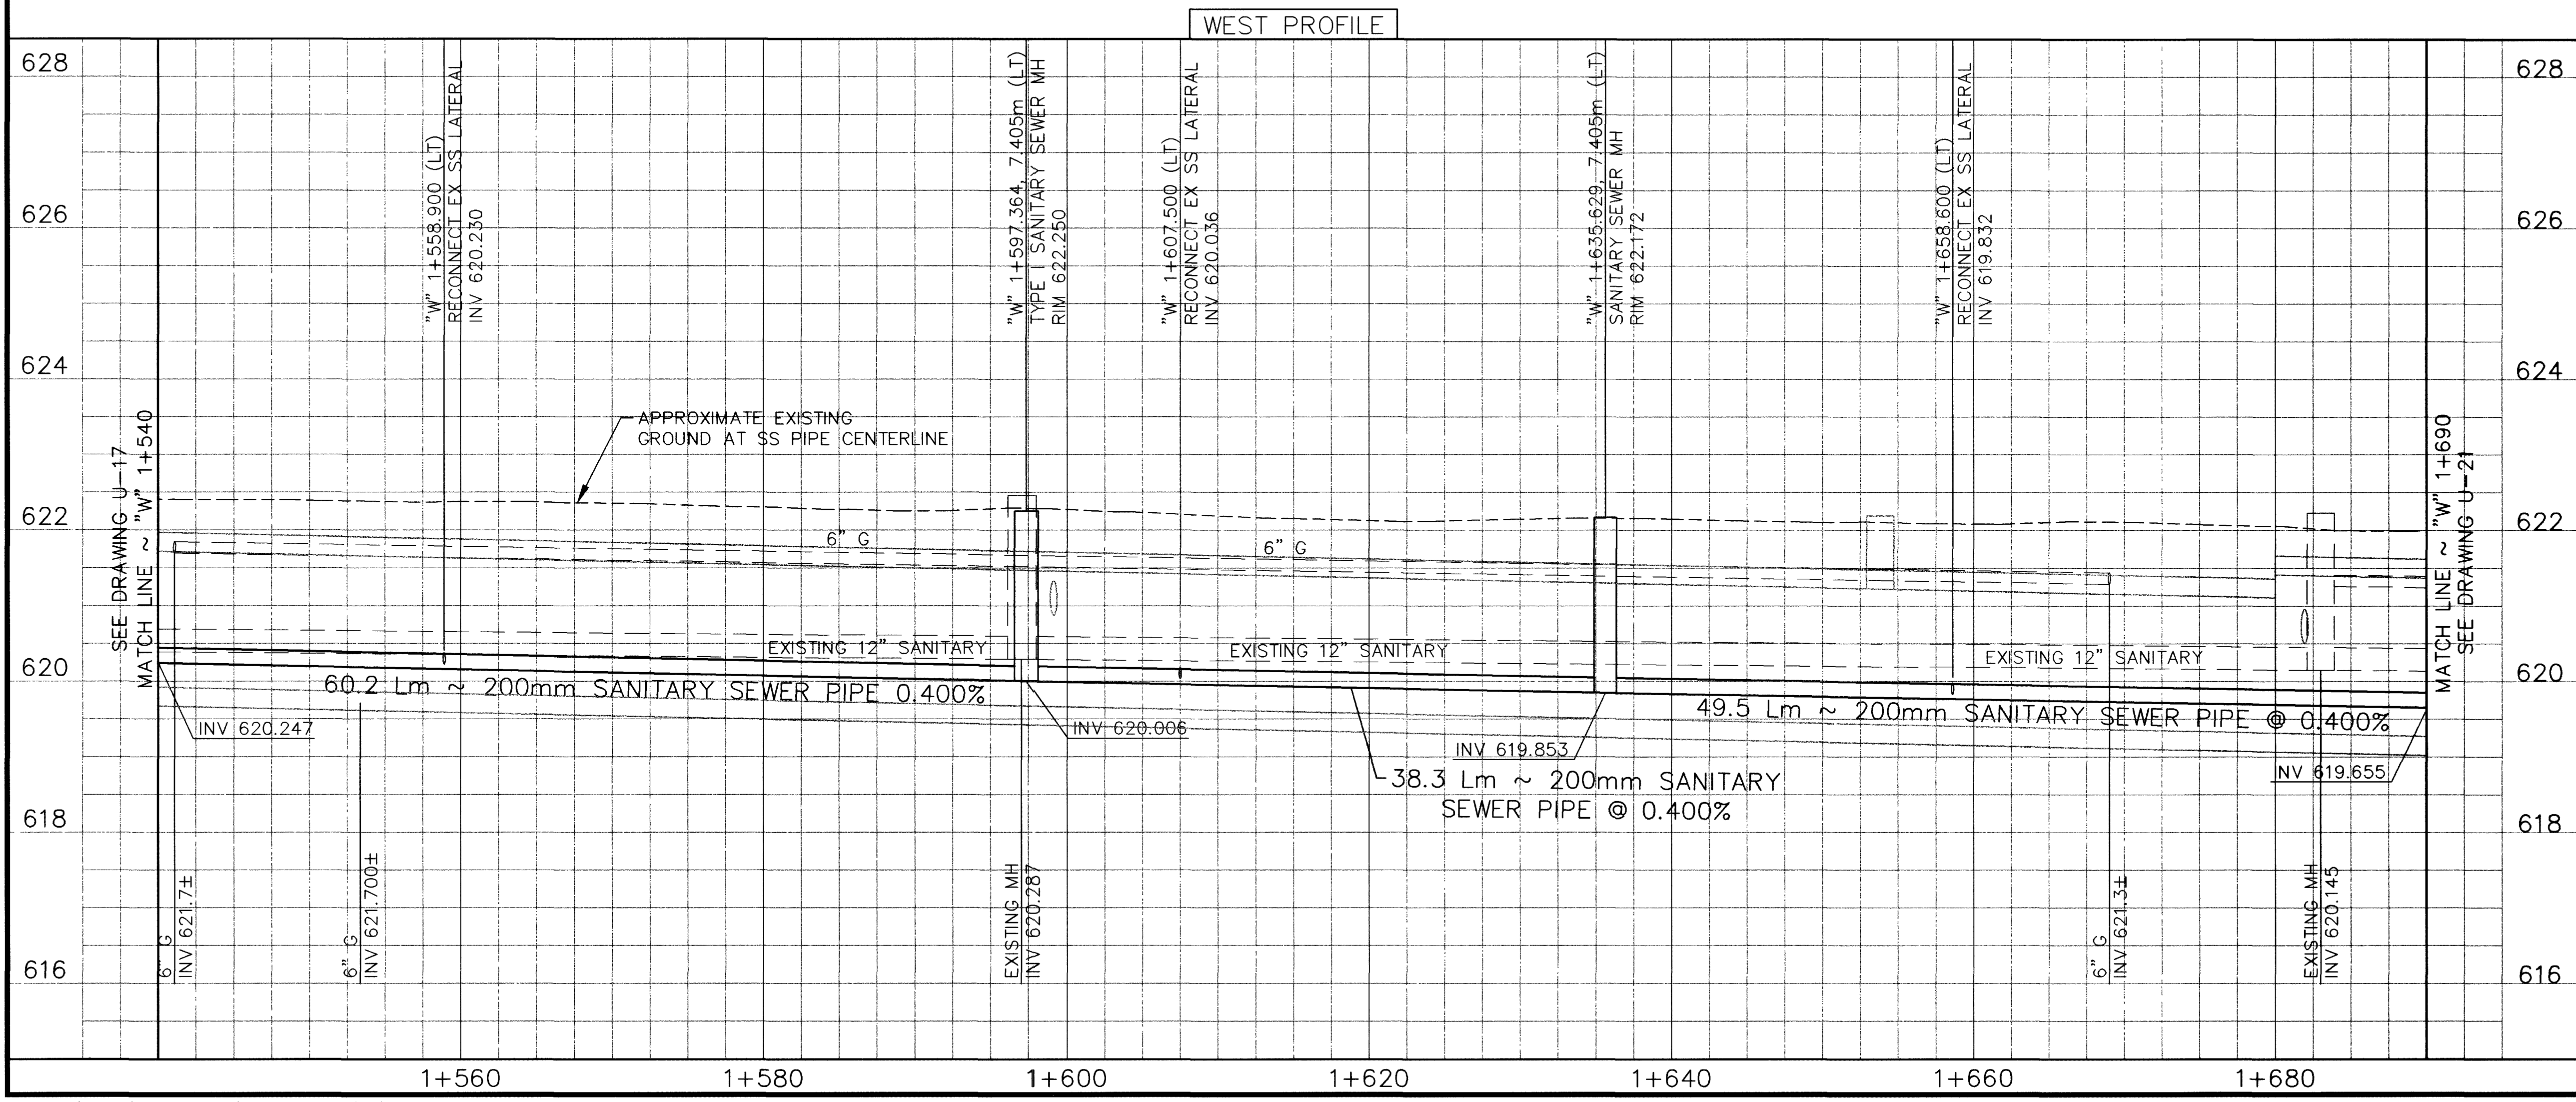


APPROVED FOR CONSTRUCTION

LAS VEGAS VALLEY WATER DISTRICT DATE

Call before you Dig. 1-800-277-2600 UNDERGROUND SERVICE (USA)

Call before you Overhead 563-6111 OVERHEAD SERVICE (USA)

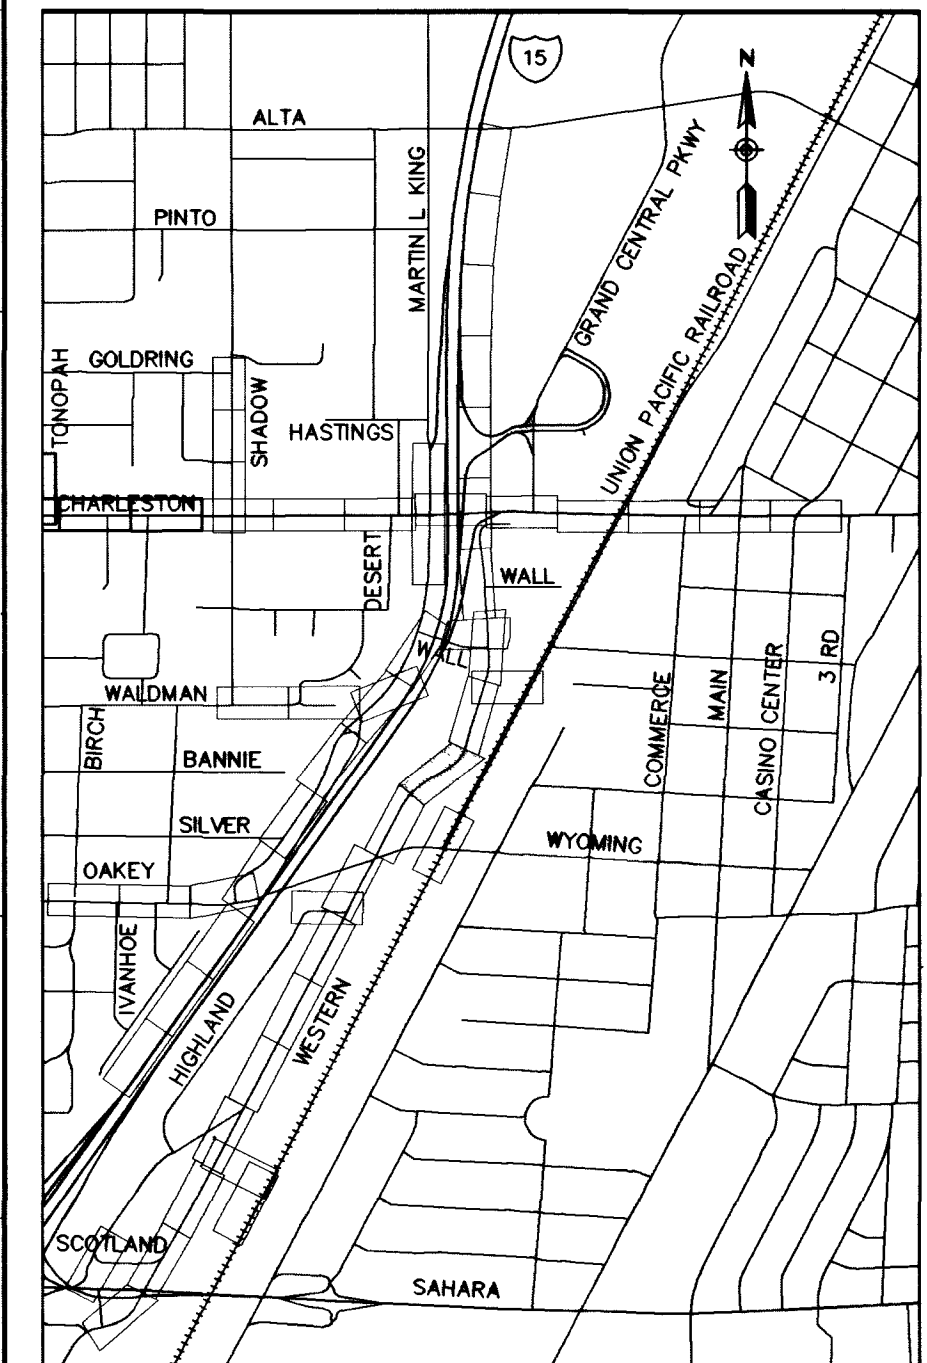

DATE: 4/20/03

REVISIONS:

PROJECT # 31604

DESIGN BY KFN

SCALE (V) 1:50

DATE DEC 17, 1999

SCALE (H) 1:250

FLD. BK. # N/A

PARSONS BRINCKERHOFF
Las Vegas, Nevada

DEPARTMENT OF PUBLIC WORKS

I-15 FREEWAY CHANNEL

UTILITY RELOCATION (WESTERN AVE)

"W" 1+540 TO "W" 1+690

PROFESSIONAL ENGINEER - STATE OF NEVADA 11501
JOHN CLARK CIVIL

DRAWING No. 178

U-19

241