



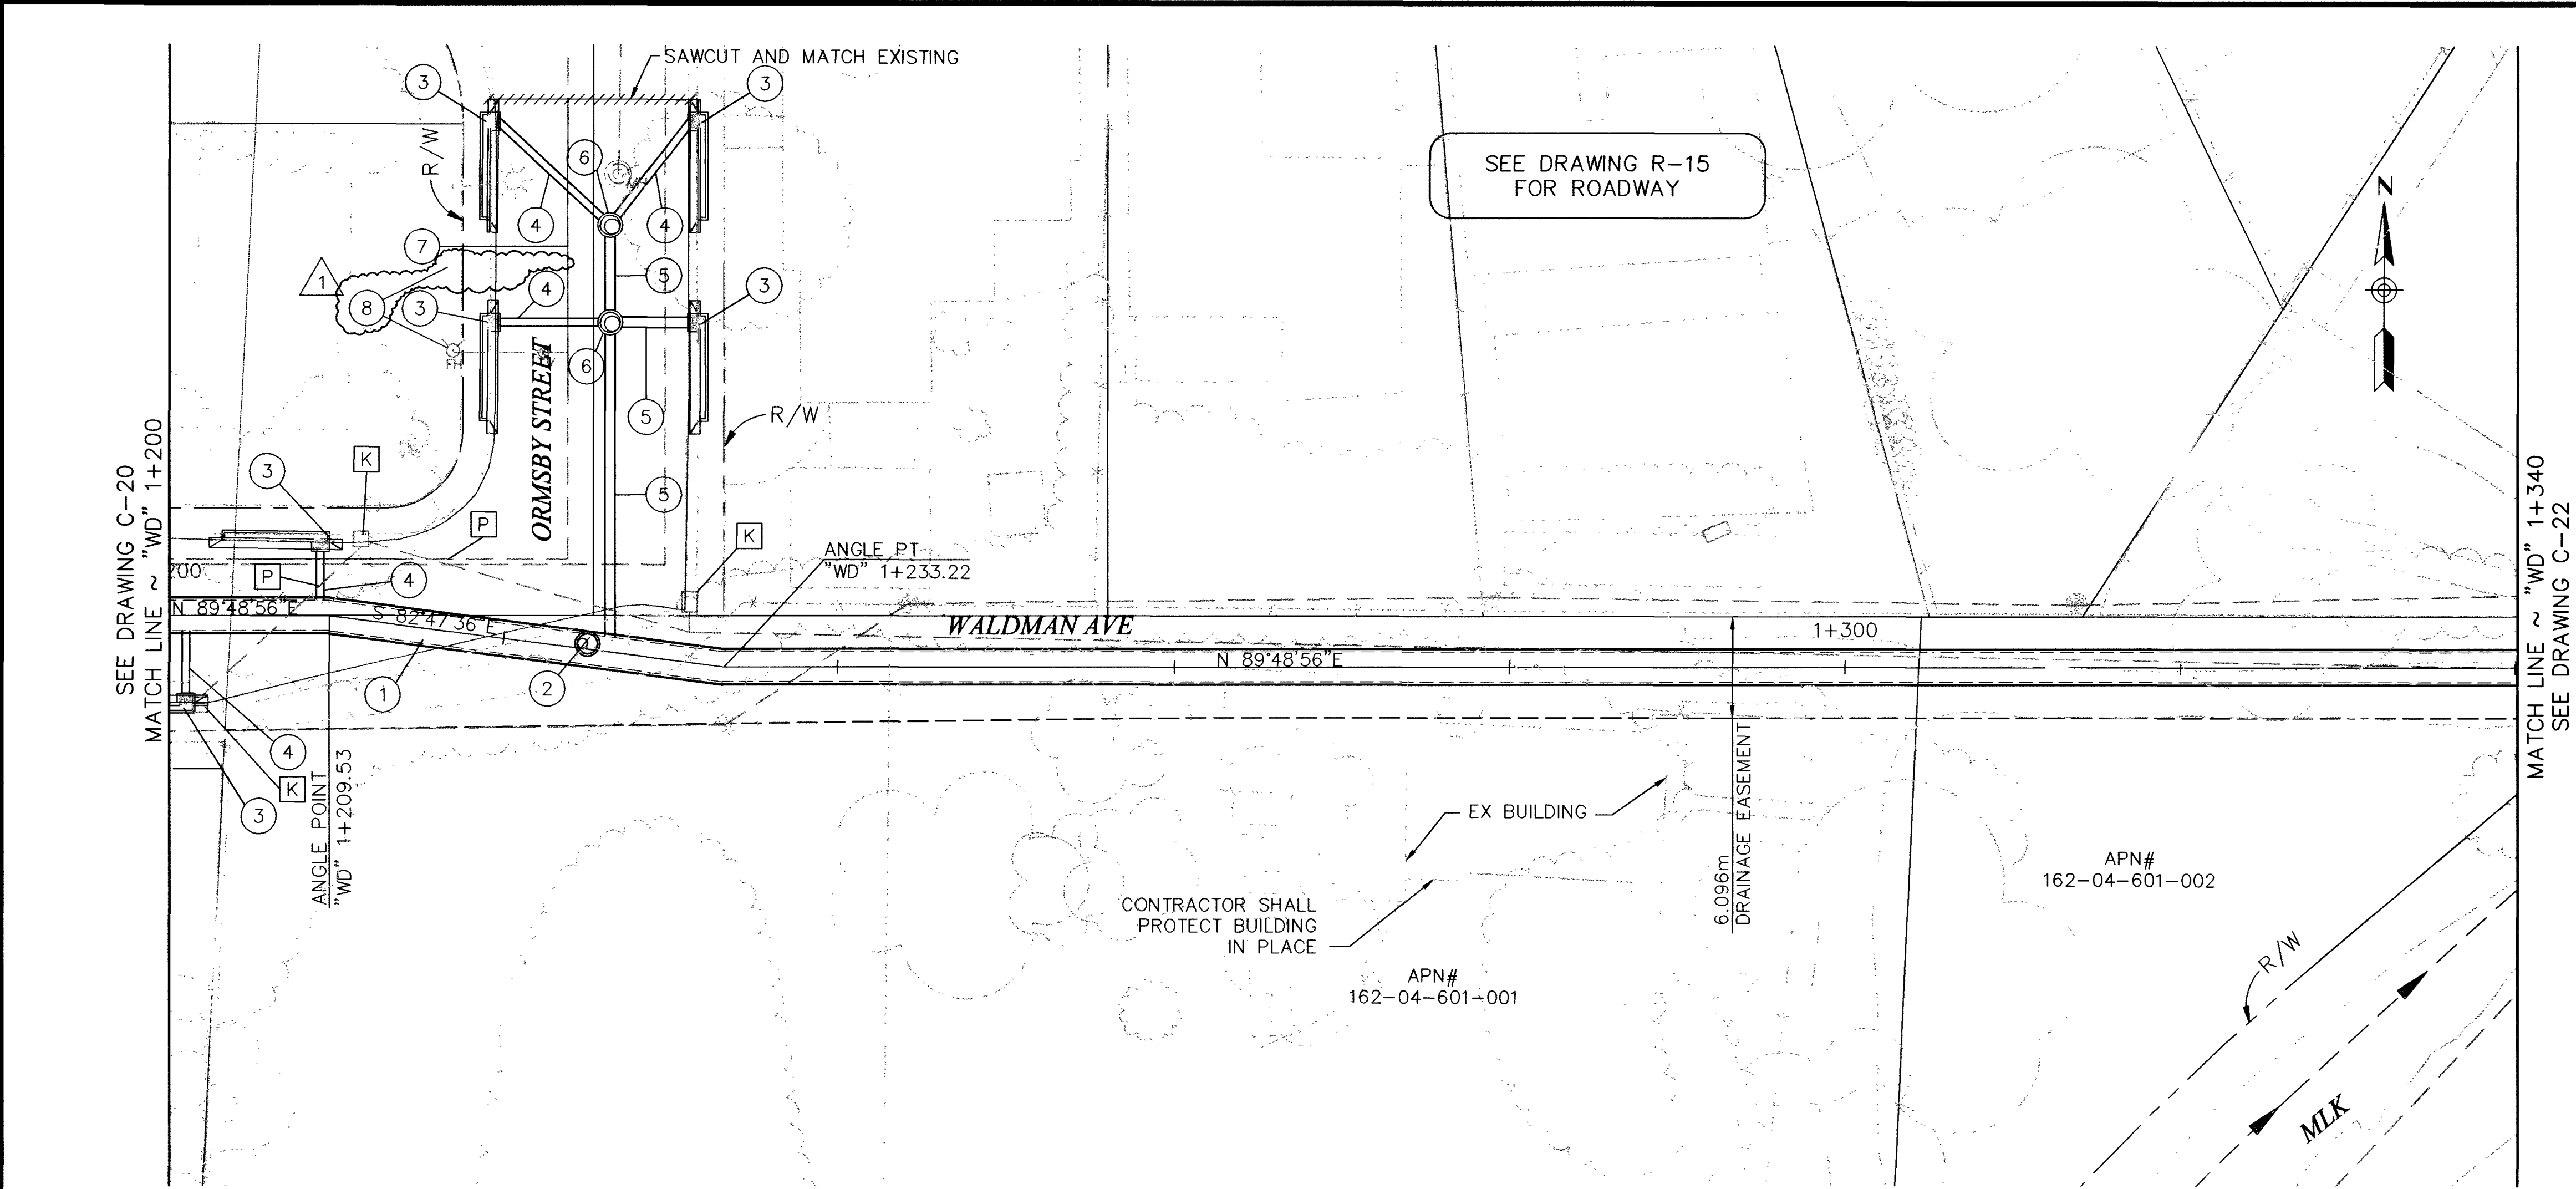

- REMOVAL ITEMS**
- [K] REMOVE DI
 - [P] REMOVE STORM DRAIN PIPE
- CONSTRUCTION ITEMS**
- "WD" 1+200.000 TO 1+340.000 PRECAST RCB
CONSTRUCT 1.8m x 1.8m PRECAST RCB
 - "WD" 1+225.000, 0.520m LT
CONSTRUCT RCB ACCESS MH
SEE DRAWING S-20
 - "WD" 1+201.000, 5.226m RT TO 1+209.000, 4.381m LT
"WD" 1+216.791, 18.550m LT TO 1+215.248, 30.460m LT
"WD" 1+227.482, 32.040m LT TO 1+229.030, 20.140m LT
CONSTRUCT 6.0m DI TYPE D MODIFIED
SEE DRAWING S-7A
 - "WD" 1+201.000, 5.226m RT TO 1+201.000, 0.900m RT
"WD" 1+209.000, 3.381m LT TO 1+209.000, 0.900m LT
"WD" 1+216.791, 18.550m LT TO 1+223.869, 19.500m LT
"WD" 1+229.030, 20.140m LT TO 1+223.869, 19.500m LT
"WD" 1+215.248, 30.460m LT TO 1+223.121, 25.230m LT
CONSTRUCT 450mm PVC
 - "WD" 1+227.482, 32.040m LT TO 1+223.121, 25.230m LT
"WD" 1+223.121, 25.230m LT TO 1+223.869, 19.500m LT
"WD" 1+223.869, 19.500m LT TO 1+226.227, 0.900m LT
CONSTRUCT 600mm PVC
 - "WD" 1+223.869, 19.500m LT TO 1+223.121, 25.230m LT
CONSTRUCT TYPE I MH WITH 750mm FRAME AND COVER
 - "WD" 1+200.000, 3.350m LT TO 1+213.500, 3.350m LT
RELOCATE 150mm WATER LINE
SEE DRAWING U-40
 - "WD" 1+214.814, 16.599m LT TO 1+214.152, 21.702m LT
RELOCATE EX FIRE HYDRANT PER LVWD UDS PLATE NO. 7

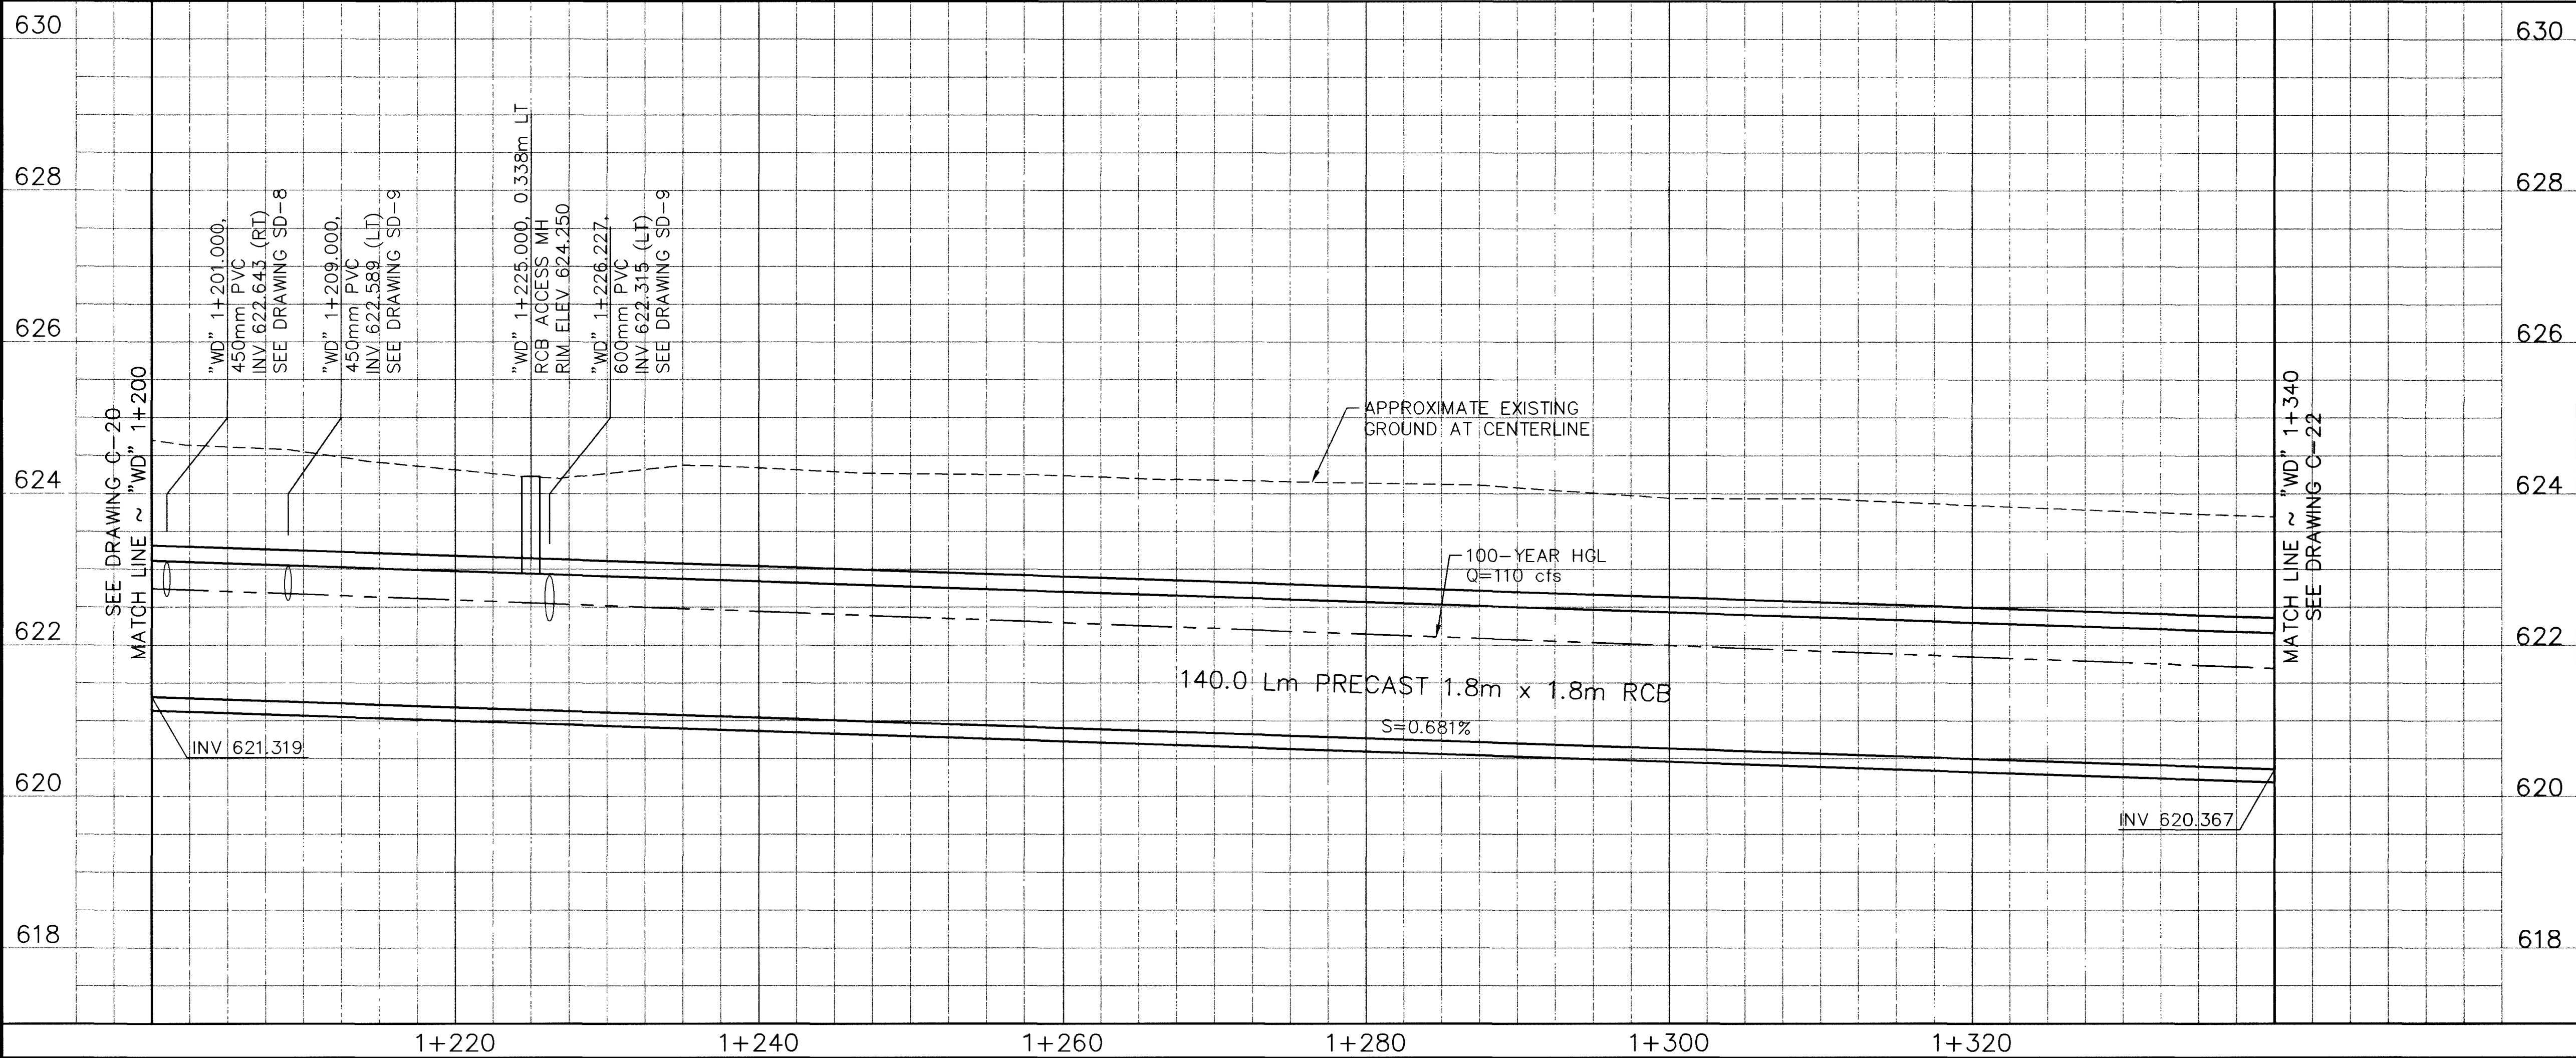


APPROVED FOR CONSTRUCTION

LAS VEGAS VALLEY WATER DISTRICT DATE

Call before you Dig.
1-800-277-2600
UNDERGROUND SERVICE (USA)

Call before you Overhead
563-6111
OVERHEAD SERVICE (USA)

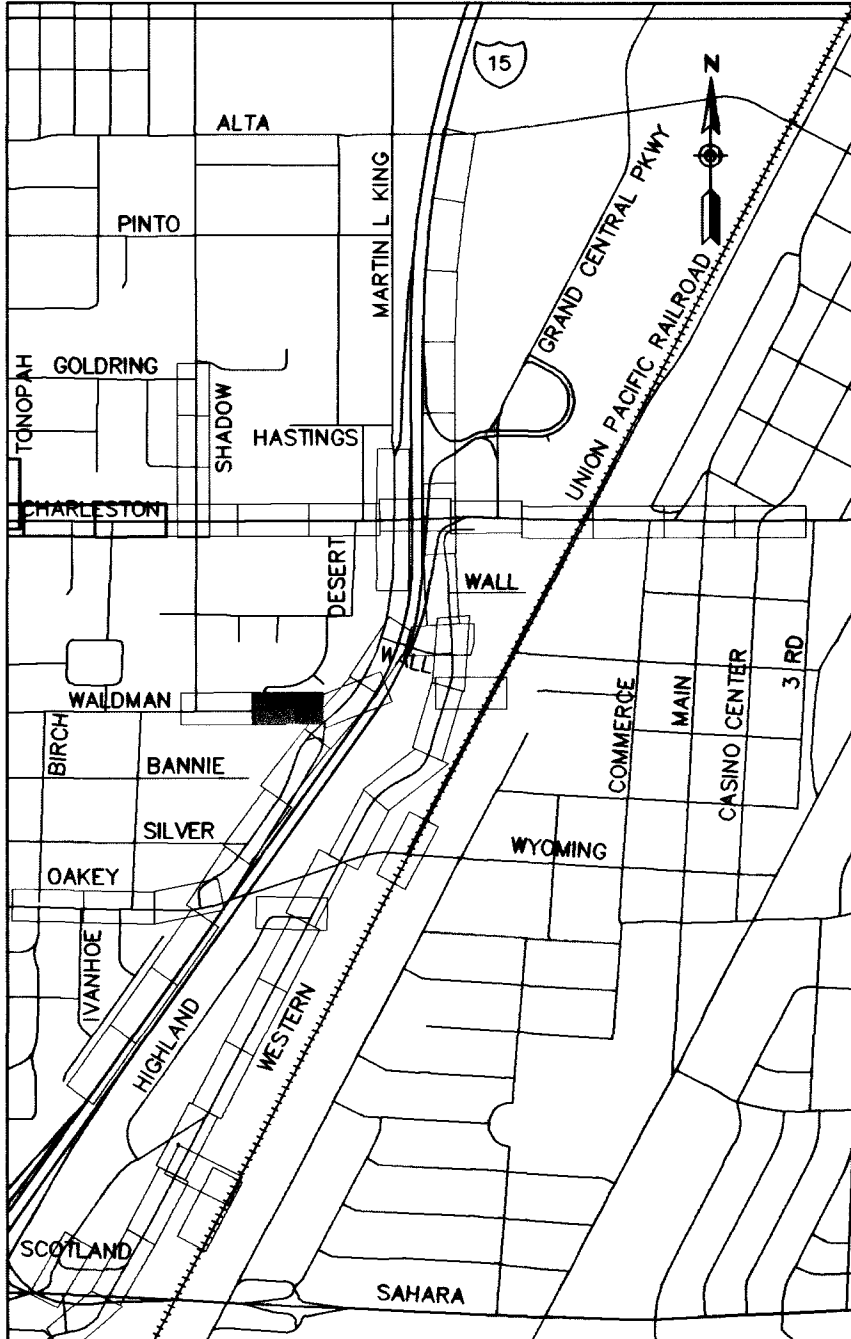

DATE	REVISIONS	PROJECT #	SCALE (V)	SCALE (H)	FLD. BK. #	DATE	DESIGN BY	PROJECT #	SCALE (V)	SCALE (H)	FLD. BK. #	DATE	DESIGN BY
3/20/00		31604	1:50	1:250	N/A	DEC 17, 1999	BPP	31604	1:50	1:250	N/A	DEC 17, 1999	BPP
4/20/03													

PARSONS BRINCKERHOFF
Las Vegas, Nevada

DEPARTMENT OF PUBLIC WORKS
I-15 FREEWAY CHANNEL
CONSTRUCTION PLAN AND PROFILE
"WD" 1+200 TO "WD" 1+340

JOHN P. CLARK
CIVIL
No. 115014

DRAWING No. **C-21**
44