


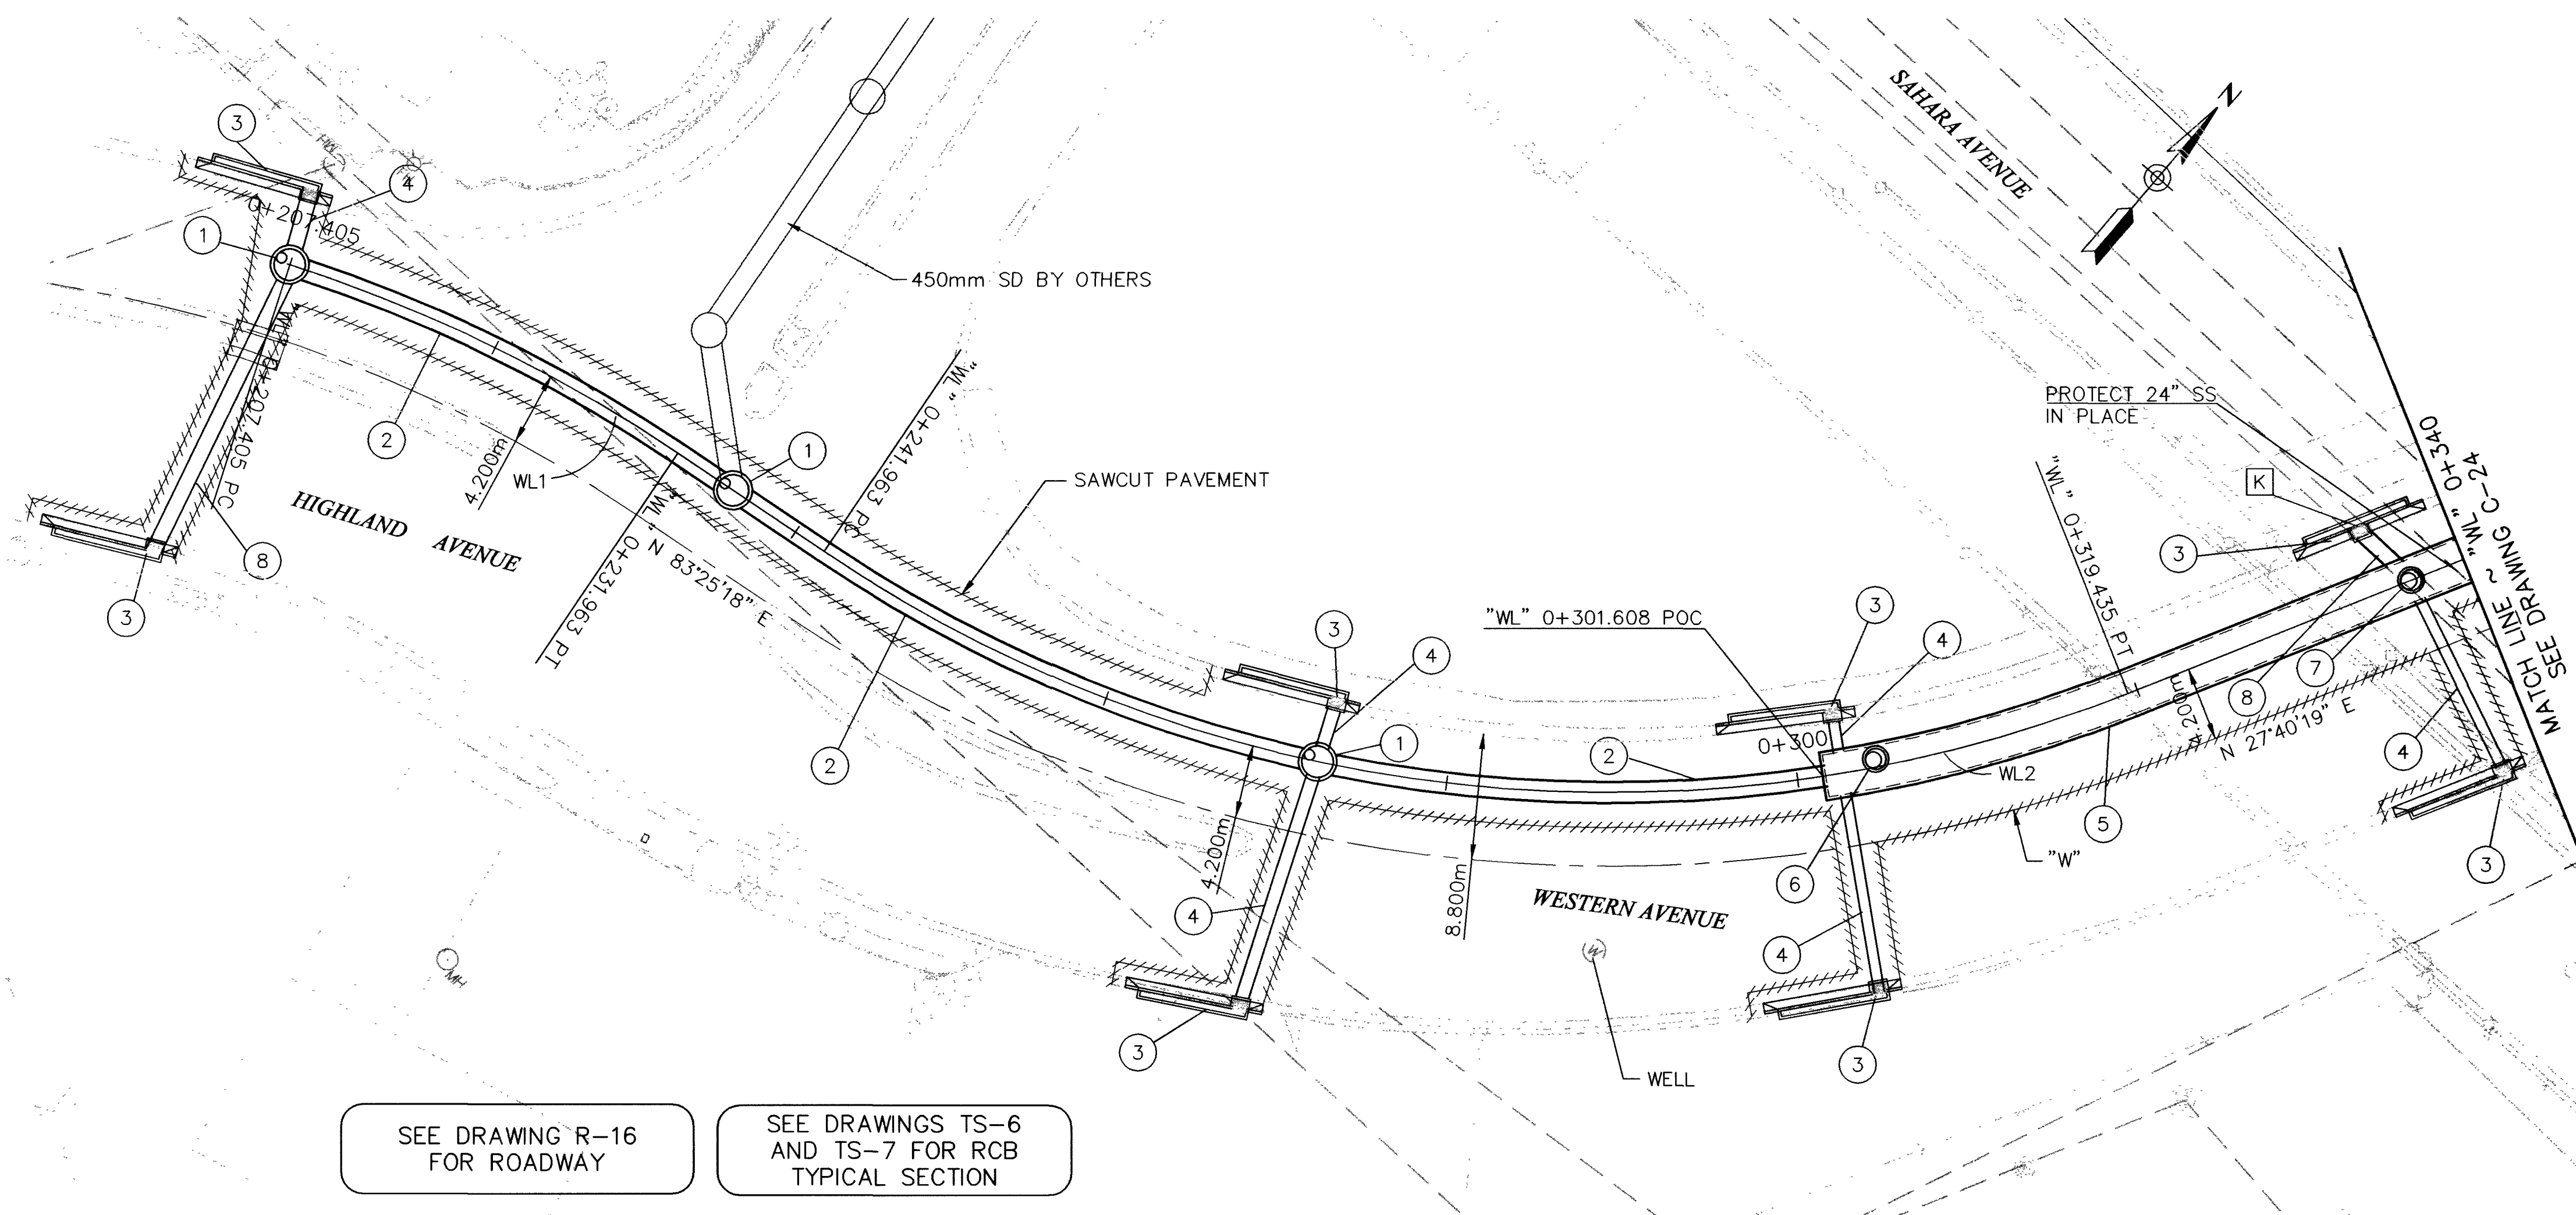

SEE DRAWING R-16
FOR ROADWAY

SEE DRAWINGS TS-6
AND TS-7 FOR RCB
TYPICAL SECTION


- REMOVAL ITEMS**
- [K] REMOVE DI
- CONSTRUCTION ITEMS**
- 1 "WL" 0+207.405 TO 0+235.760
CONSTRUCT TYPE II MH
- 2 "WL" 0+207.405 TO 0+235.760
CONSTRUCT 1200mm RCP
- 3 "WL" 0+204.410, 17.736m RT
CONSTRUCT 6.0m DI
TYPE "D" MOD.
SEE DRAWING S-7
- 4 "WL" 0+271.358, 14.624m RT TO 0+301.608
CONSTRUCT 600mm PVC
- 5 "WL" 0+301.608 TO 0+340.000
CONSTRUCT 2.4m x 1.2m
PRECAST RCB
- 6 "WL" 0+304.570, 0.416m LT
CONSTRUCT RCB ACCESS MH
SEE DRAWING S-20
- 7 "WL" 0+336.785
CONSTRUCT TYPE I MH
- 8 "WL" 0+204.410, 17.736m RT TO 0+207.405, 0.600m RT
CONSTRUCT 900mm PVC

APPROVED FOR CONSTRUCTION

LAS VEGAS VALLEY WATER DISTRICT DATE

"WL" CURVE DATA

No.	Δ	R	L	T
WL1	55°44'56"	82.296m	24.558m	43.526m
WL2	55°44'59"	83.820m	77.472m	44.333m

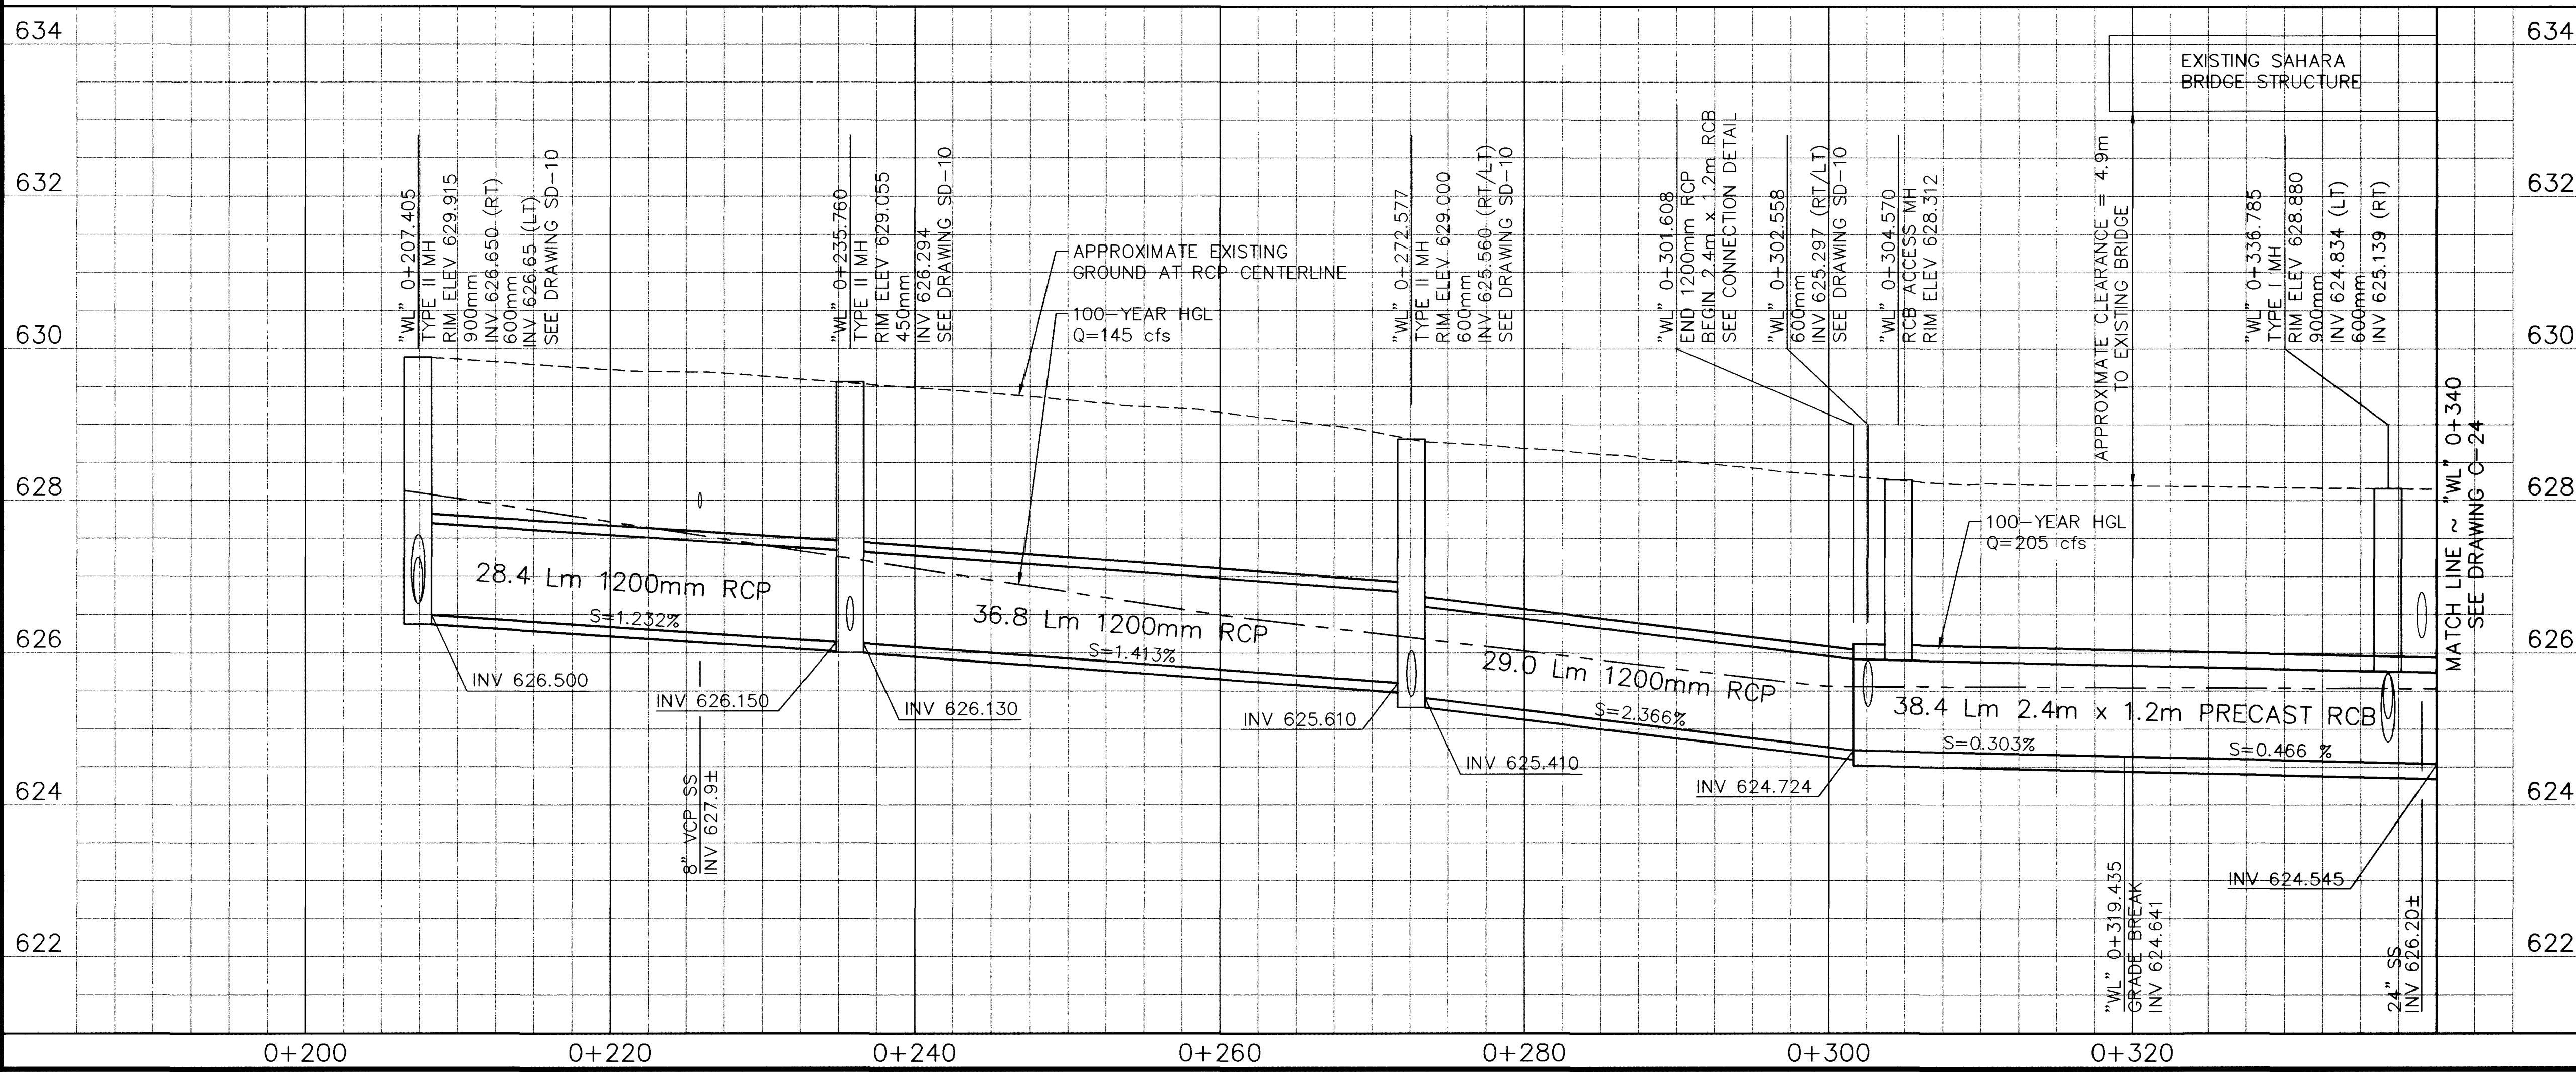

Call before you Dig.
1-800-277-2600
UNDERGROUND SERVICE (USA)

Call before you Overhead
563-6111
OVERHEAD SERVICE (USA)

DATE	REVISIONS	ADDITION 2	PROJECT #	DESIGN BY	SCALE (H)	SCALE (V)	DATE	DATE	DATE
3/30/00			31604	BPP	1:50	1:250	DEC 17, 1999	N/A	
4/30/03									

PARSONS BRINCKERHOFF
Los Vegas, Nevada

RECORD DRAWING METRIC

DEPARTMENT OF PUBLIC WORKS
I-15 FREEWAY CHANNEL
CONSTRUCTION PLAN AND PROFILE
"WL" 0+207.405 TO "WL" 0+340

JOHN P. CLARK
REGISTERED PROFESSIONAL ENGINEER
STATE OF NEVADA
NO. 11540

DRAWING No. **C-23** 46
241

327-V254