


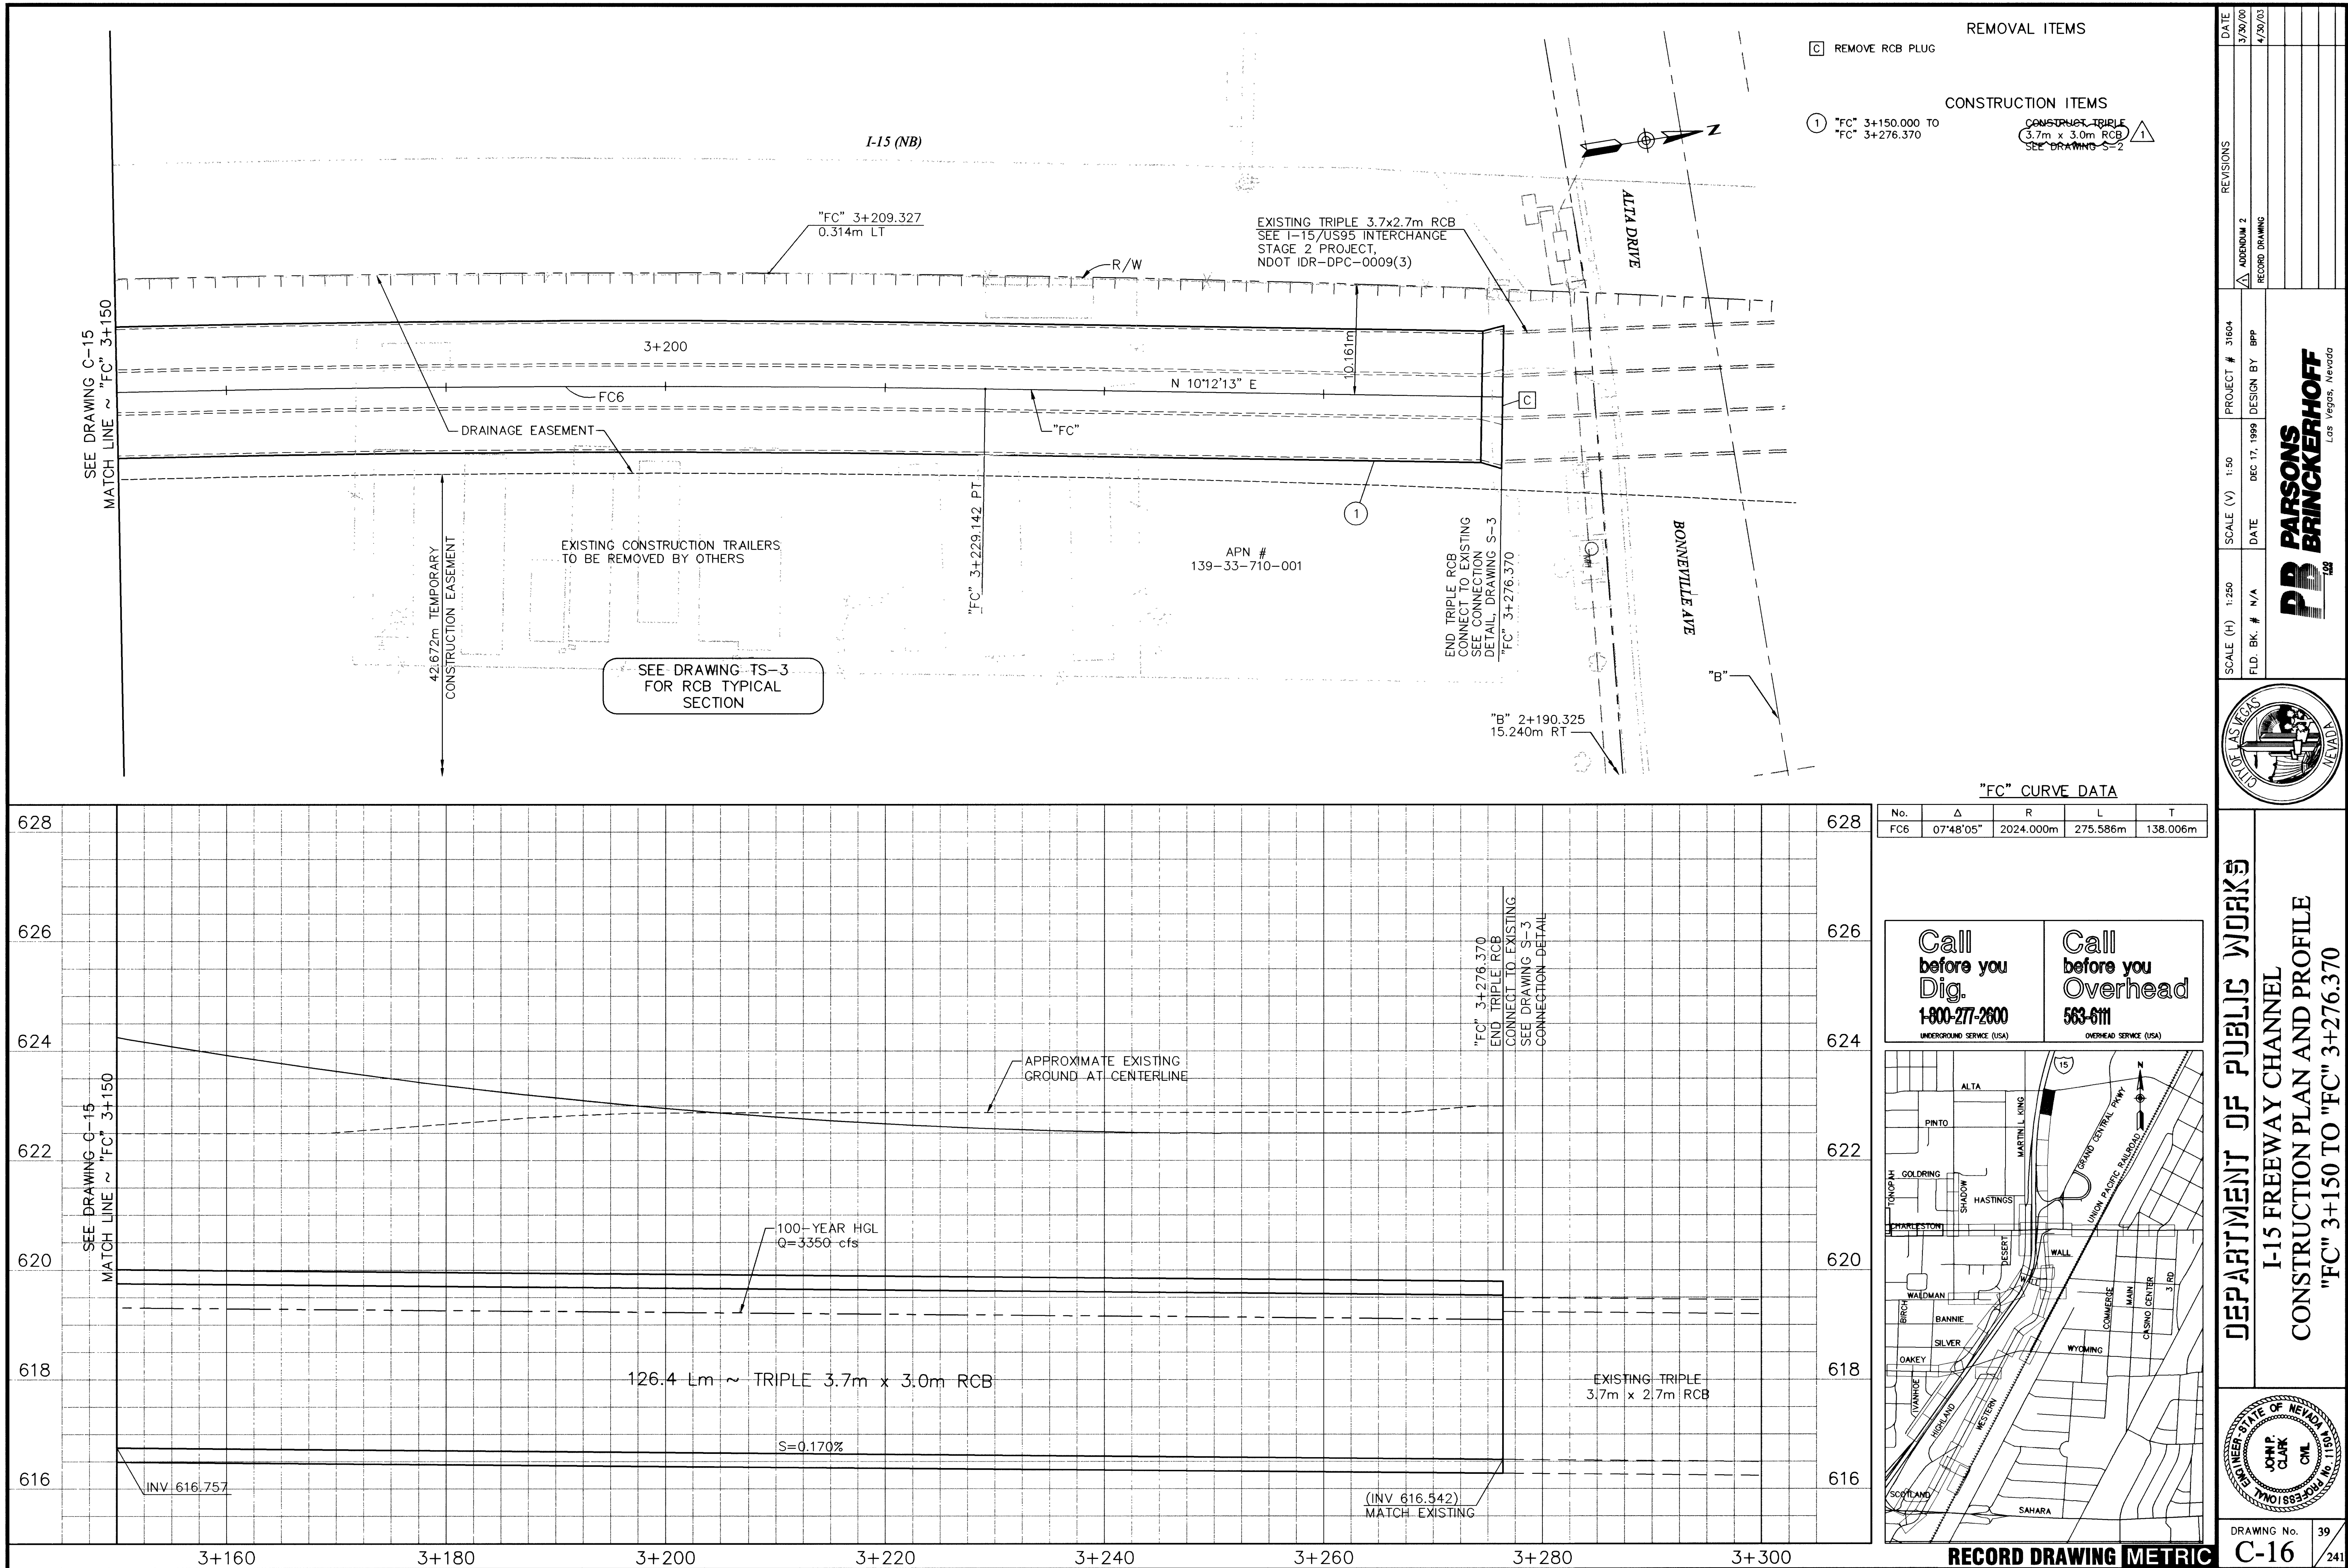

- REMOVAL ITEMS
- C


REMOVE RCB PLUG
- CONSTRUCTION ITEMS
- 1

"FC" 3+150.000 TO
"FC" 3+276.370
- CONSTRUCT TRIPLE
3.7m x 3.0m RCB
SEE DRAWING S-2

"FC" CURVE DATA				
No.	Δ	R	L	T
FC6	07°48'05"	2024.000m	275.586m	138.006m

Call before you Dig.
1-800-277-2600
UNDERGROUND SERVICE (USA)

Call before you Overhead
563-6111
OVERHEAD SERVICE (USA)

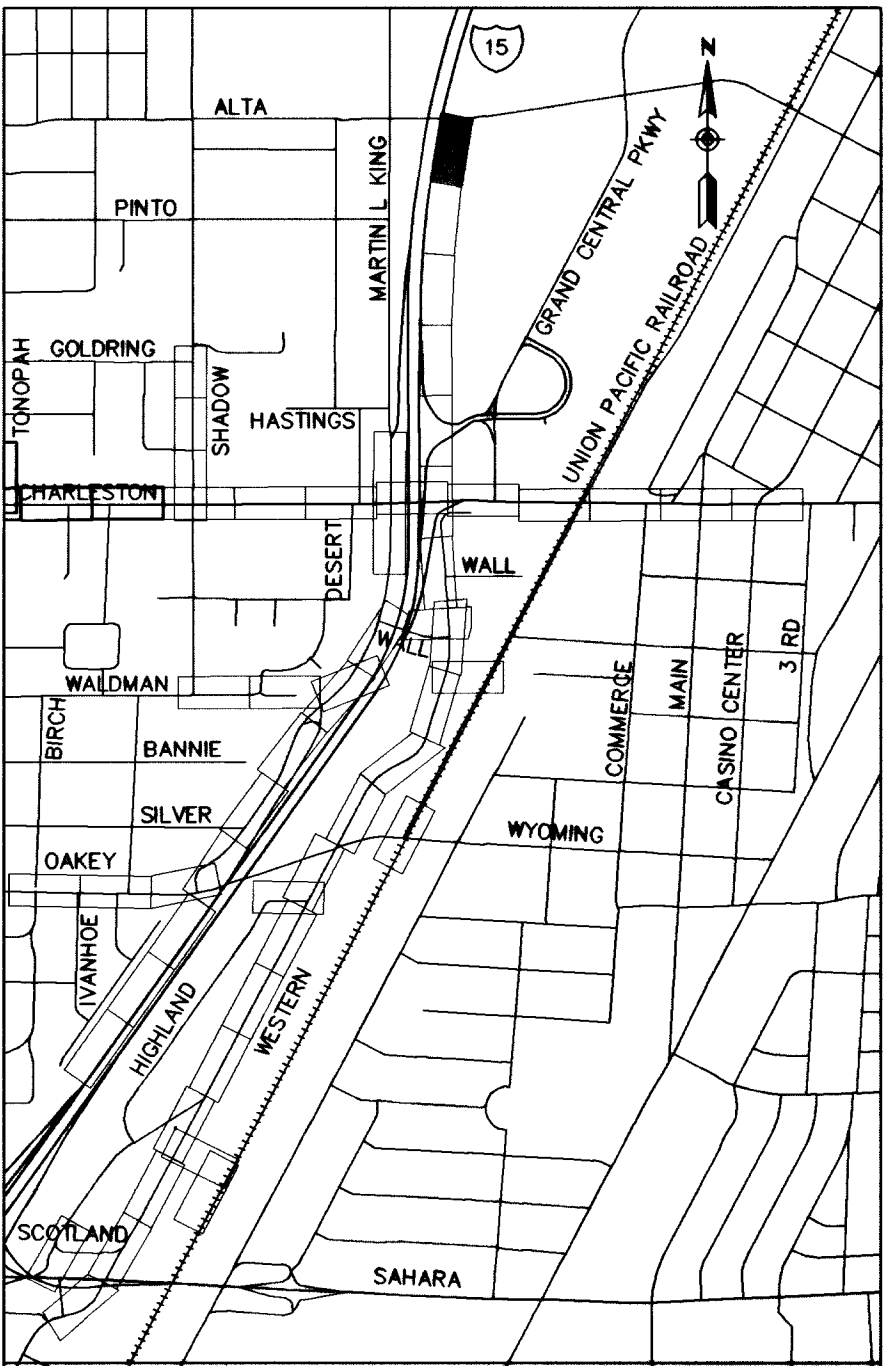

REVISIONS

DATE

3/30/00

4/30/03

ADDITION 2

RECORD DRAWING

PROJECT # 31604

DESIGN BY BPP

SCALE (V) 1:50

DATE DEC 17, 1999

SCALE (H) 1:250

F.L.D. BK. # N/A

PARSONS
BRINCKERHOFF
LOS VEGAS, NEVADA

DEPARTMENT OF PUBLIC WORKS

I-15 FREEWAY CHANNEL
CONSTRUCTION PLAN AND PROFILE
"FC" 3+150 TO "FC" 3+276.370

ENGINEER STATE OF NEVADA
JOHN CLARK
PROFESSIONAL SEAL

DRAWING No. 39

C-16

241

327-V254