


- CONSTRUCTION ITEMS**
- ① "SHL" 1+110.000 TO 1+220.000 CONSTRUCT 2.1m x 1.2m PRECAST RCB
 - ② "SHL" 1+191.000, 0.239m RT CONSTRUCT RCB ACCESS MH (SEE DRAWING S-20)
 - ③ "SHL" 1+116.000, 10.190m RT CONSTRUCT 3.0m DI TYPE "D" MOD. SEE DRAWING S-7
 - ④ "SHL" 1+189.000, 9.832m RT "SHL" 1+212.000, 5.987m LT CONSTRUCT 6.0m DI TYPE "D" MOD. SEE DRAWING S-7
 - ⑤ "SHL" 1+214.000, 10.103m RT "SHL" 1+116.000, 1.050m RT TO "SHL" 1+189.000, 9.832m RT TO "SHL" 1+189.000, 1.050m RT "SHL" 1+212.000, 5.987m LT TO "SHL" 1+212.000, 1.050m LT "SHL" 1+214.000, 10.103m RT TO "SHL" 1+214.000, 1.050m RT CONSTRUCT 450mm PVC
 - ⑥ "SHL" 1+106.420, 4.500m LT TO "SHL" 1+113.000, 7.000m LT CONSTRUCT 1200mm RCP
 - ⑦ "SHL" 1+113.000, 10.000m LT CONSTRUCT NDOT TYPE 2 MH
 - ⑧ "SHL" 1+219.400 LT RECONNECT EX WATER SERVICE PER LVWD UDS PLATE No. 1B OR 1D

"SHL" CURVE DATA

No.	Δ	R	L	T
SHL2	30°10'16"	9.000m	4.740m	2.430m
SHL3	30°10'12"	9.000m	4.740m	2.430m

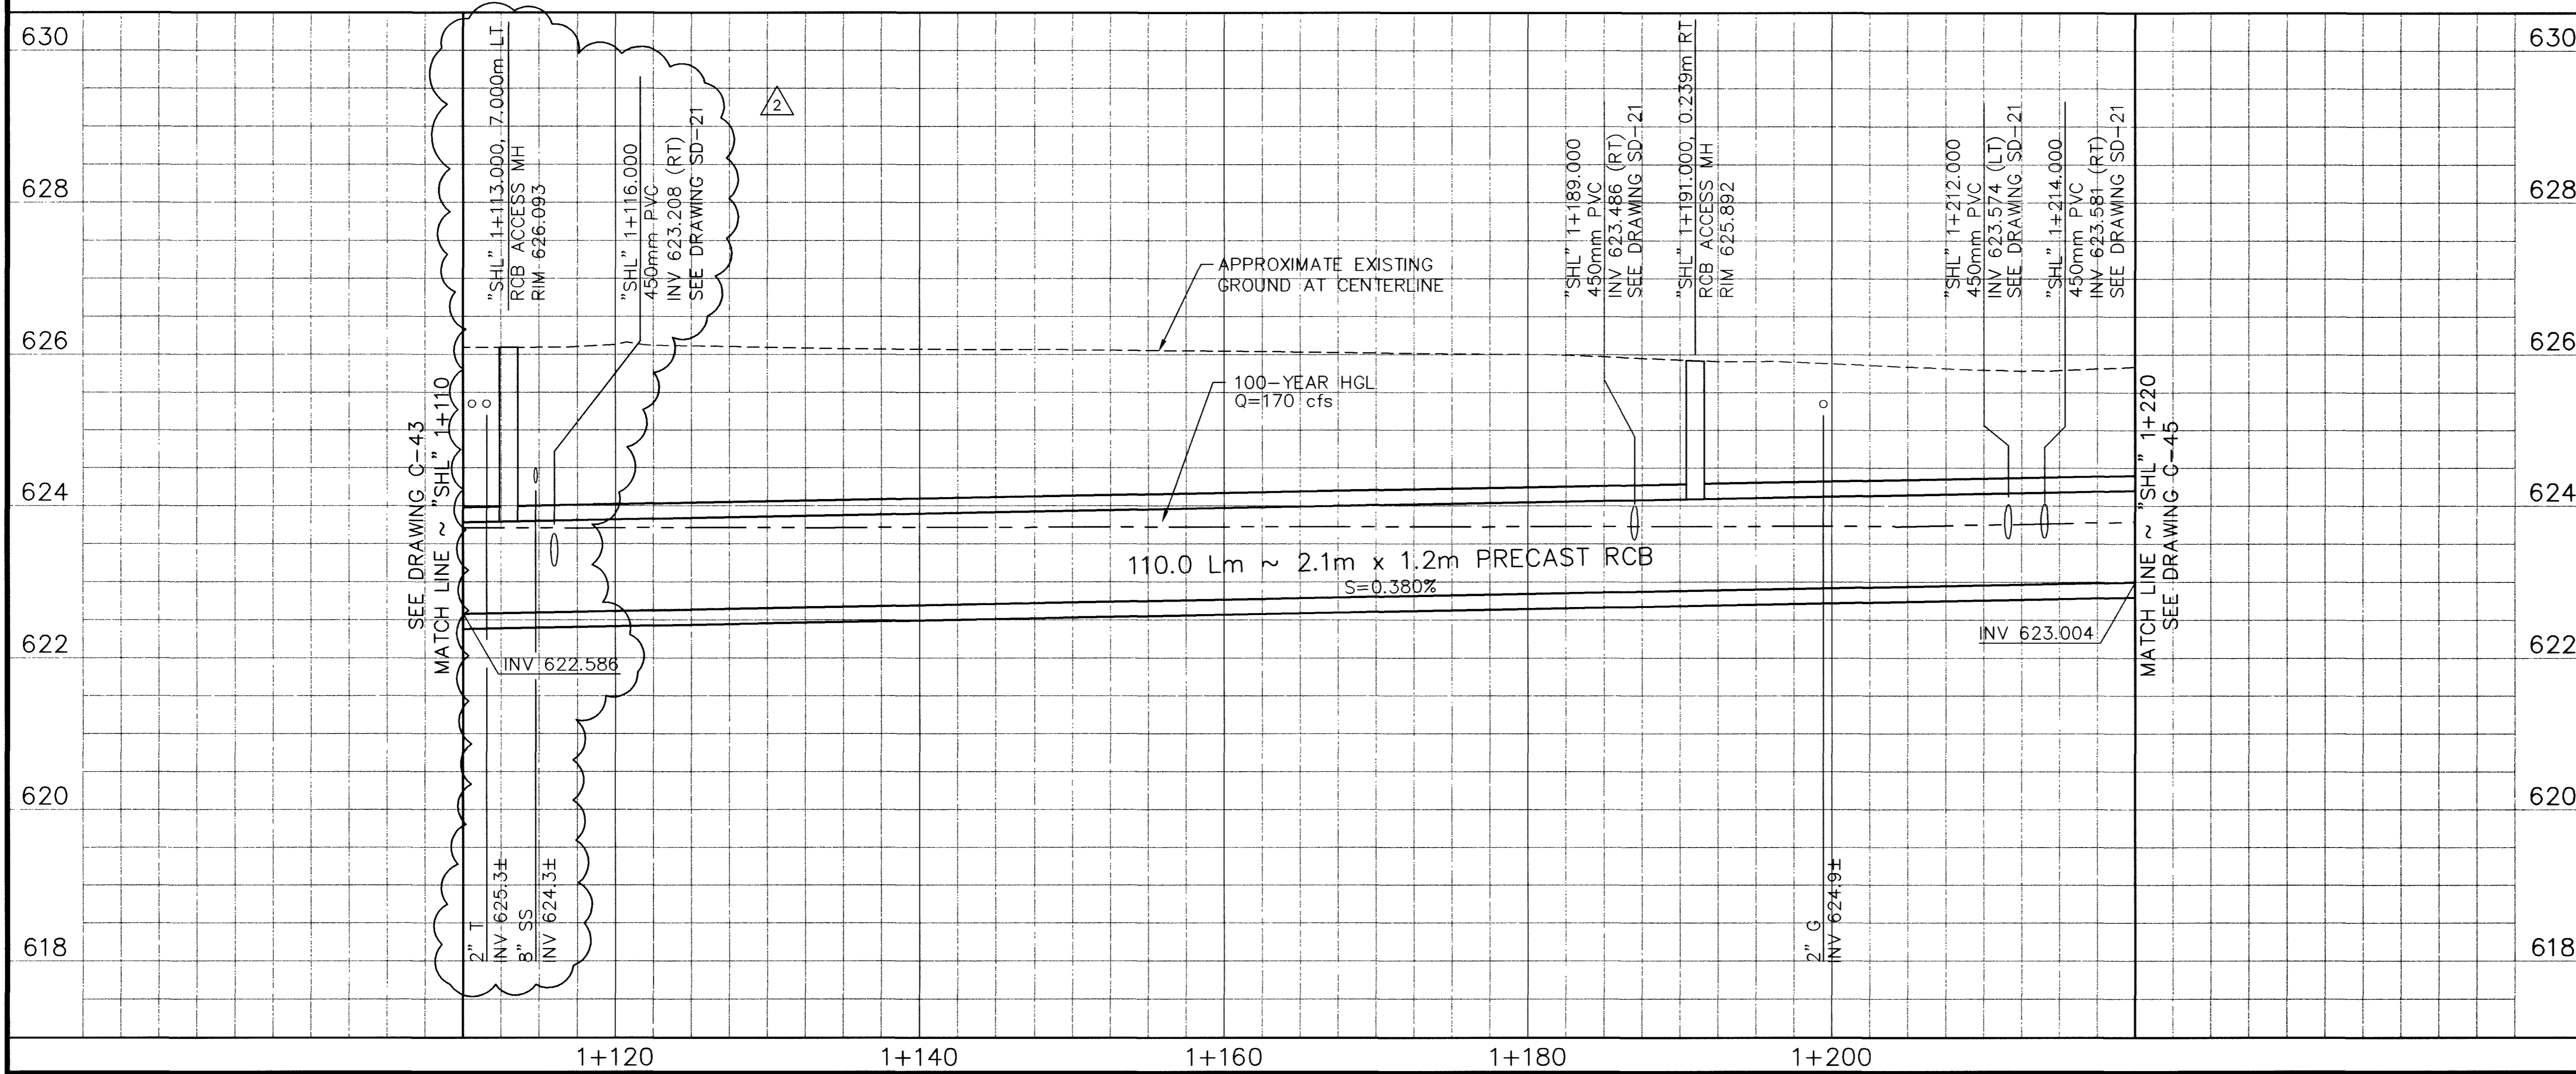


APPROVED FOR CONSTRUCTION

LAS VEGAS VALLEY WATER DISTRICT DATE _____

Call before you Dig.
1-800-277-2600
UNDERGROUND SERVICE (USA)

Call before you Overhead.
563-6111
OVERHEAD SERVICE (USA)

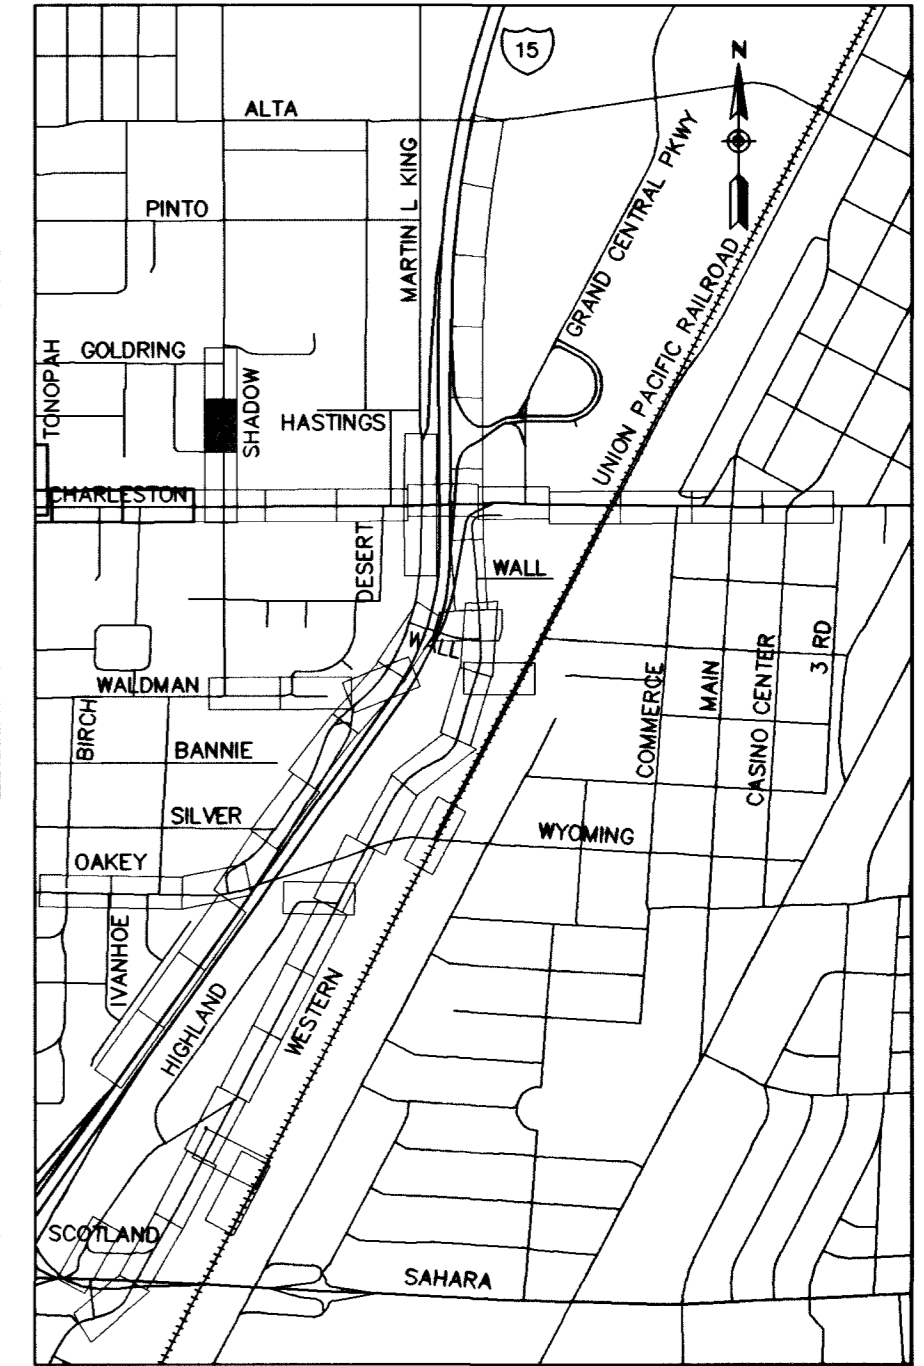

REVISIONS

DATE	REVISIONS
3/20/00	
4/12/01	
4/20/03	

ADDITION # 2

PROJECT # 31604

SCALE (V) 1:50

SCALE (H) 1:250

DATE DEC 17, 1999

DESIGN BY BPP

RECORD DRAWING

PARSONS BRINCKERHOFF
Las Vegas, Nevada

APPROVED FOR CONSTRUCTION

LAS VEGAS VALLEY WATER DISTRICT DATE _____

Call before you Dig.
1-800-277-2600
UNDERGROUND SERVICE (USA)

Call before you Overhead.
563-6111
OVERHEAD SERVICE (USA)

DEPARTMENT OF PUBLIC WORKS

I-15 FREEWAY CHANNEL

CONSTRUCTION PLAN AND PROFILE

"SHL" 1+110 TO "SHL" 1+220

DRAWING No. 67

C-44

241

RECORD DRAWING METRIC