


SEE DRAWING R-37 FOR ROADWAY

SEE DRAWING TS-12 FOR TYPICAL SECTION

- CONSTRUCTION ITEMS**
- 1 "SHL" 1+220.000 TO "SHL" 1+311.000 CONSTRUCT 2.1m x 1.2m PRECAST RCB
 - 2 "SHL" 1+305.000, 0.450m RT CONSTRUCT RCB ACCESS MH (SEE DRAWING S-20)
 - 3 "SHL" 1+225.000, 9.625m RT CONSTRUCT 3.0m DI TYPE "D" MOD. SEE DRAWING S-7
 - 4 "SHL" 1+240.000, 9.639m RT "SHL" 1+270.000, 6.408m LT "SHL" 1+285.000, 9.338m RT "SHL" 1+295.000, 10.780m LT "SHL" 1+296.000, 9.338m RT "SHL" 1+310.000, 10.780m RT CONSTRUCT 6.0m DI TYPE "D" MOD. SEE DRAWING S-7
 - 5 "SHL" 1+225.000, 9.825m RT TO "SHL" 1+225.000, 1.050m RT "SHL" 1+240.000, 9.639m RT TO "SHL" 1+240.000, 1.050m RT CONSTRUCT 450mm PVC
 - 6 "SHL" 1+270.000, 6.408m LT TO "SHL" 1+270.000, 1.050m LT "SHL" 1+295.000, 10.780m LT TO "SHL" 1+295.000, 1.050m LT "SHL" 1+296.000, 9.338m RT TO "SHL" 1+296.000, 1.050m RT "SHL" 1+310.000, 10.780m LT TO "SHL" 1+310.000, 1.050m LT CONSTRUCT 600mm PVC
 - 7 "SHL" 1+285.000, 9.338m RT TO "SHL" 1+285.000, 1.050m RT CONSTRUCT 750mm PVC
 - 8 "SHL" 1+311.000 CONSTRUCT RCB PLUG NDOT STD DWG B-20.1.7


APPROVED FOR CONSTRUCTION

LAS VEGAS VALLEY WATER DISTRICT DATE

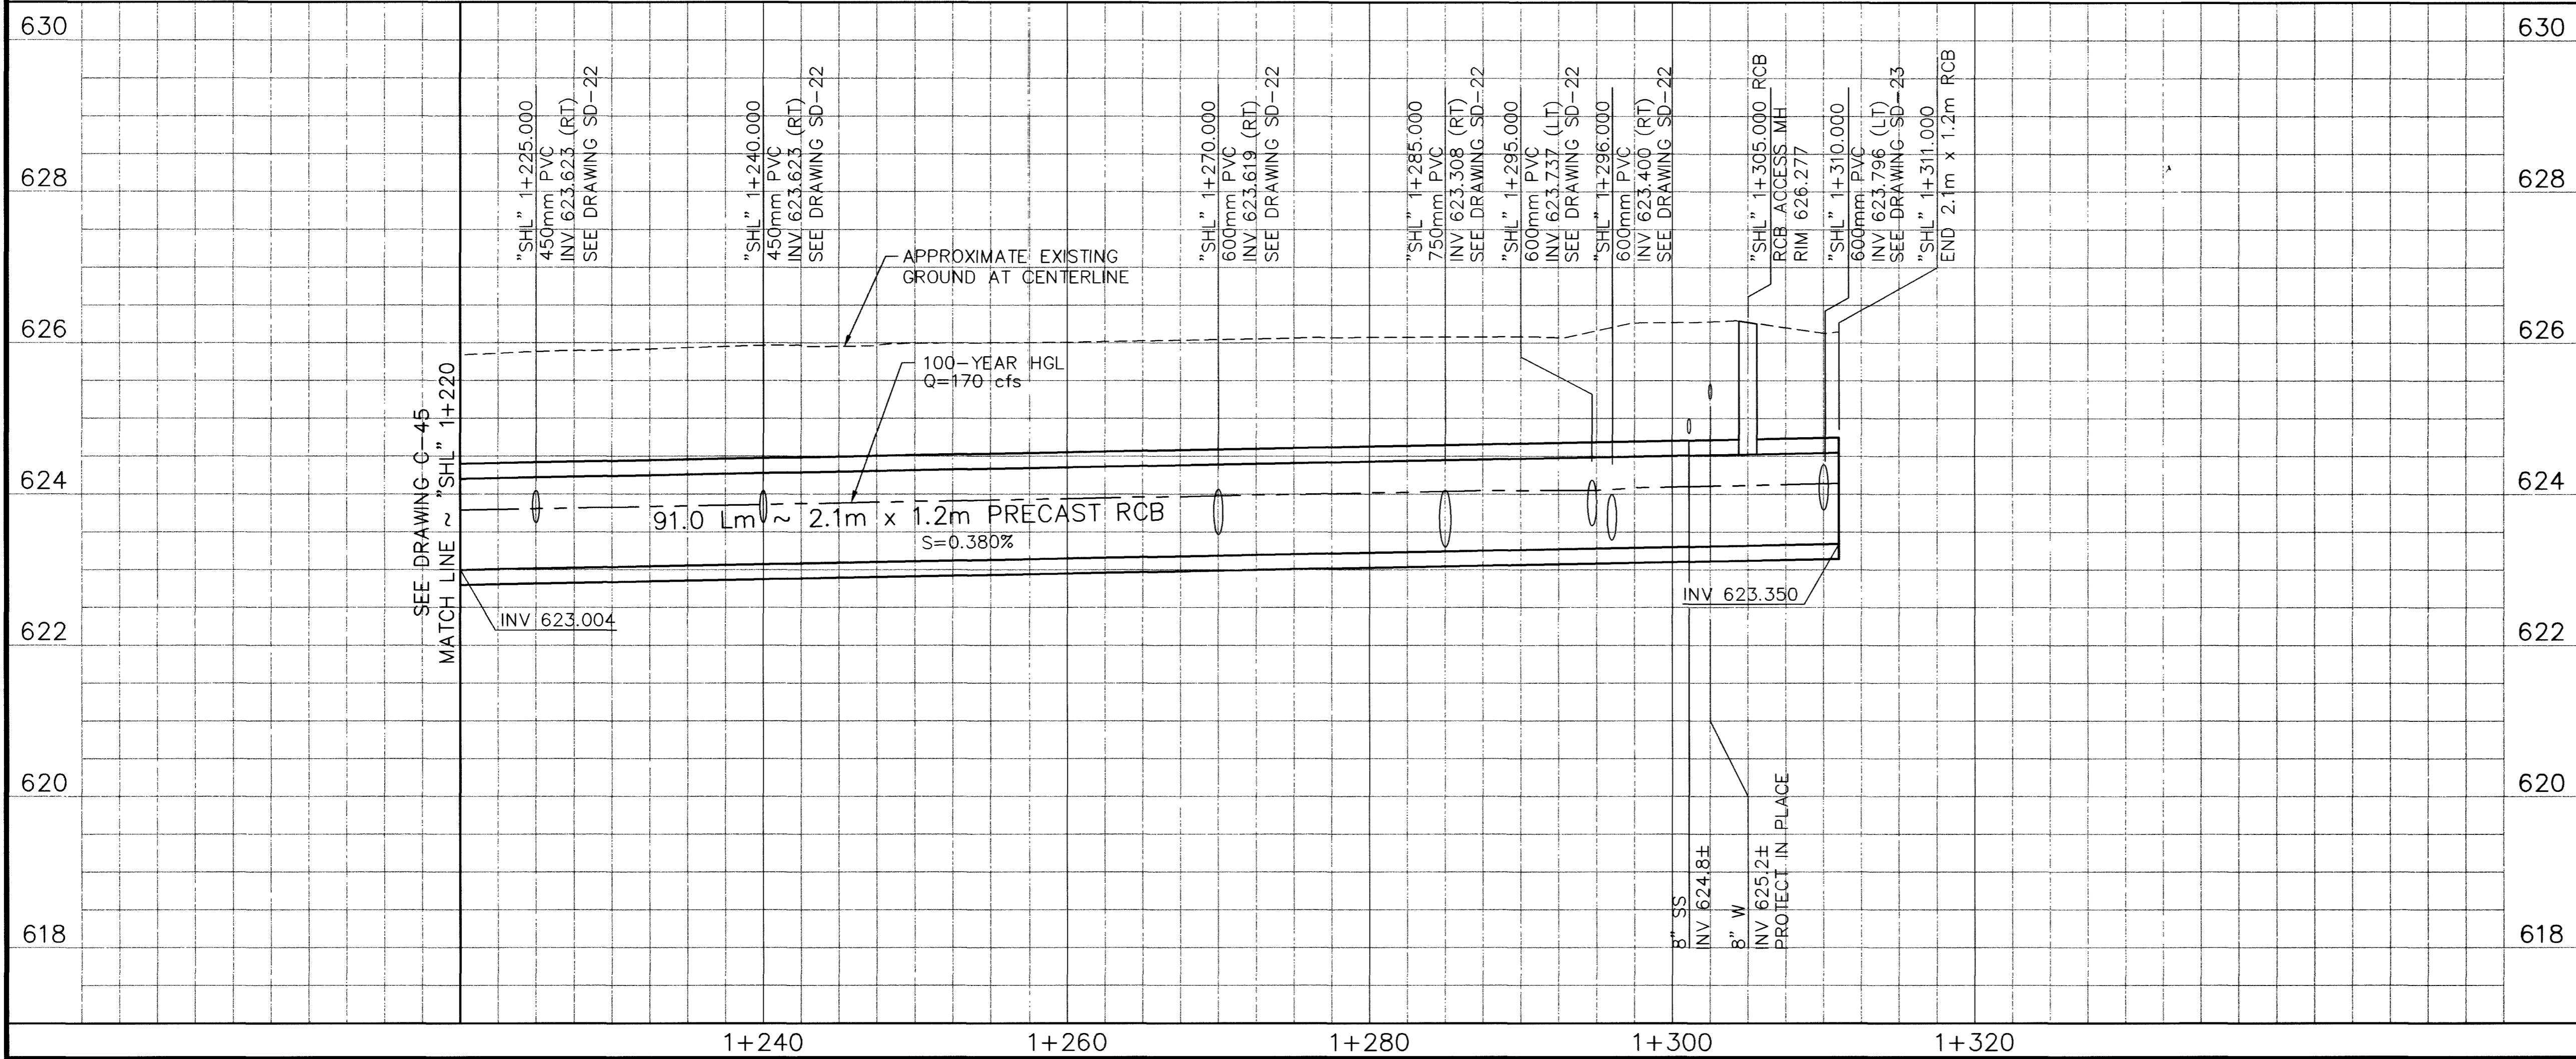

Call before you Dig.
1-800-277-2600
UNDERGROUND SERVICE (USA)

Call before you Overhead
563-6111
OVERHEAD SERVICE (USA)

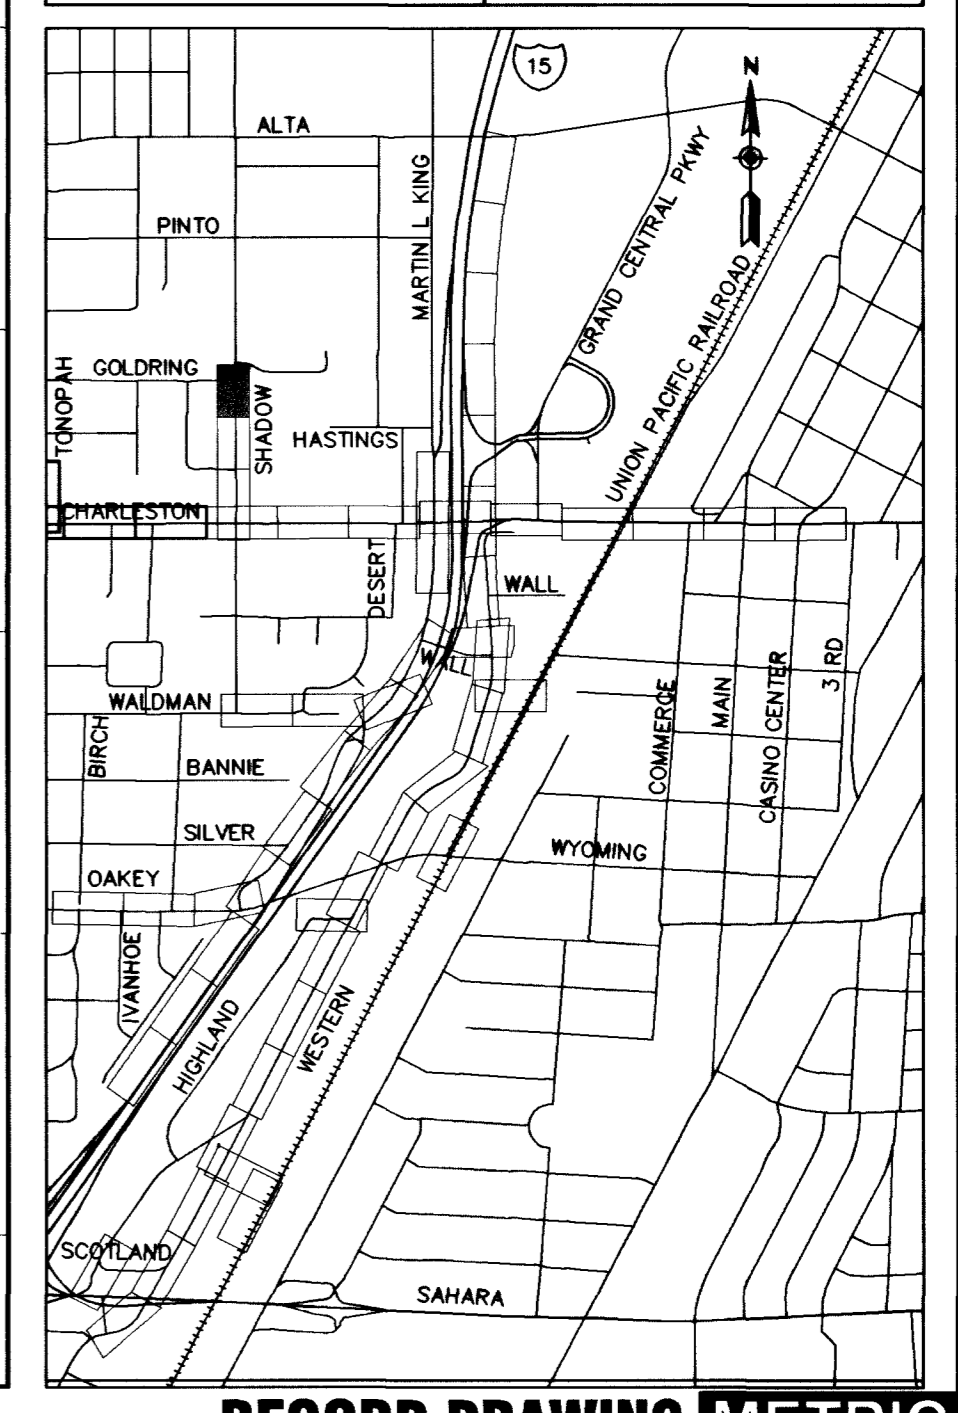

DATE	3/30/03	REVISIONS	ADDITION 2 RECORD DRAWING
PROJECT #	31604	DESIGN BY	BRP
SCALE (V)	1:50	DATE	DEC 17, 1999
SCALE (H)	1:250	DATE	DEC 17, 1999
F.L.D. Bk. #	N/A	DATE	DEC 17, 1999

PARSONS BRINCKERHOFF
Las Vegas, Nevada

STATE OF NEVADA
ENGINEER JOHN CLARK
No. 11500

DEPARTMENT OF PUBLIC WORKS
I-15 FREEWAY CHANNEL
CONSTRUCTION PLAN AND PROFILE
"SHL" 1+220 TO "SHL" 1+311.000

DRAWING No. 68
C-45
241