


- REMOVAL ITEMS**
- [E] PLUG STORM DRAIN PIPE
  - [F] REMOVE AC PAVEMENT
  - [K] REMOVE DI
- CONSTRUCTION ITEMS**
- ① "MLK" 1+878.000, 4.000m LT TO "MLK" 1+936.000, 4.000m LT CONSTRUCT 900mm PVC
  - ② "MLK" 1+878.000, 4.000m LT "MLK" 1+892.000, 4.000m LT "MLK" 1+915.000, 4.000m LT "MLK" 1+936.000, 4.000m LT CONSTRUCT TYPE I MH
  - ③ "MLK" 1+878.000, 4.000m LT TO "MLK" 1+878.000, 11.000m LT "MLK" 1+892.000, 4.00m LT TO "MLK" 1+892.000, 11.000m LT "MLK" 1+915.000, 4.000m LT TO "MLK" 1+915.000, 11.000m LT "MLK" 1+936.000, 4.000m LT TO "MLK" 1+936.000, 11.000m LT "MLK" 1+936.000, 4.000m LT TO "MLK" 1+936.000, 18.240m RT CONSTRUCT 900mm PVC
  - ④ "MLK" 1+878.000, 11.000m LT "MLK" 1+892.000, 11.000m LT "MLK" 1+915.000, 11.000m LT "MLK" 1+936.000, 11.000m LT "MLK" 1+936.000, 18.240m RT CONSTRUCT 6.0m DI TYPE "D" MOD. SEE DRAWING S-7A

SEE DRAWING C-42 FOR CHARLESTON LATERAL

SEE DRAWING TS-4 FOR TYPICAL SECTION


APPROVED FOR CONSTRUCTION

LAS VEGAS VALLEY WATER DISTRICT DATE

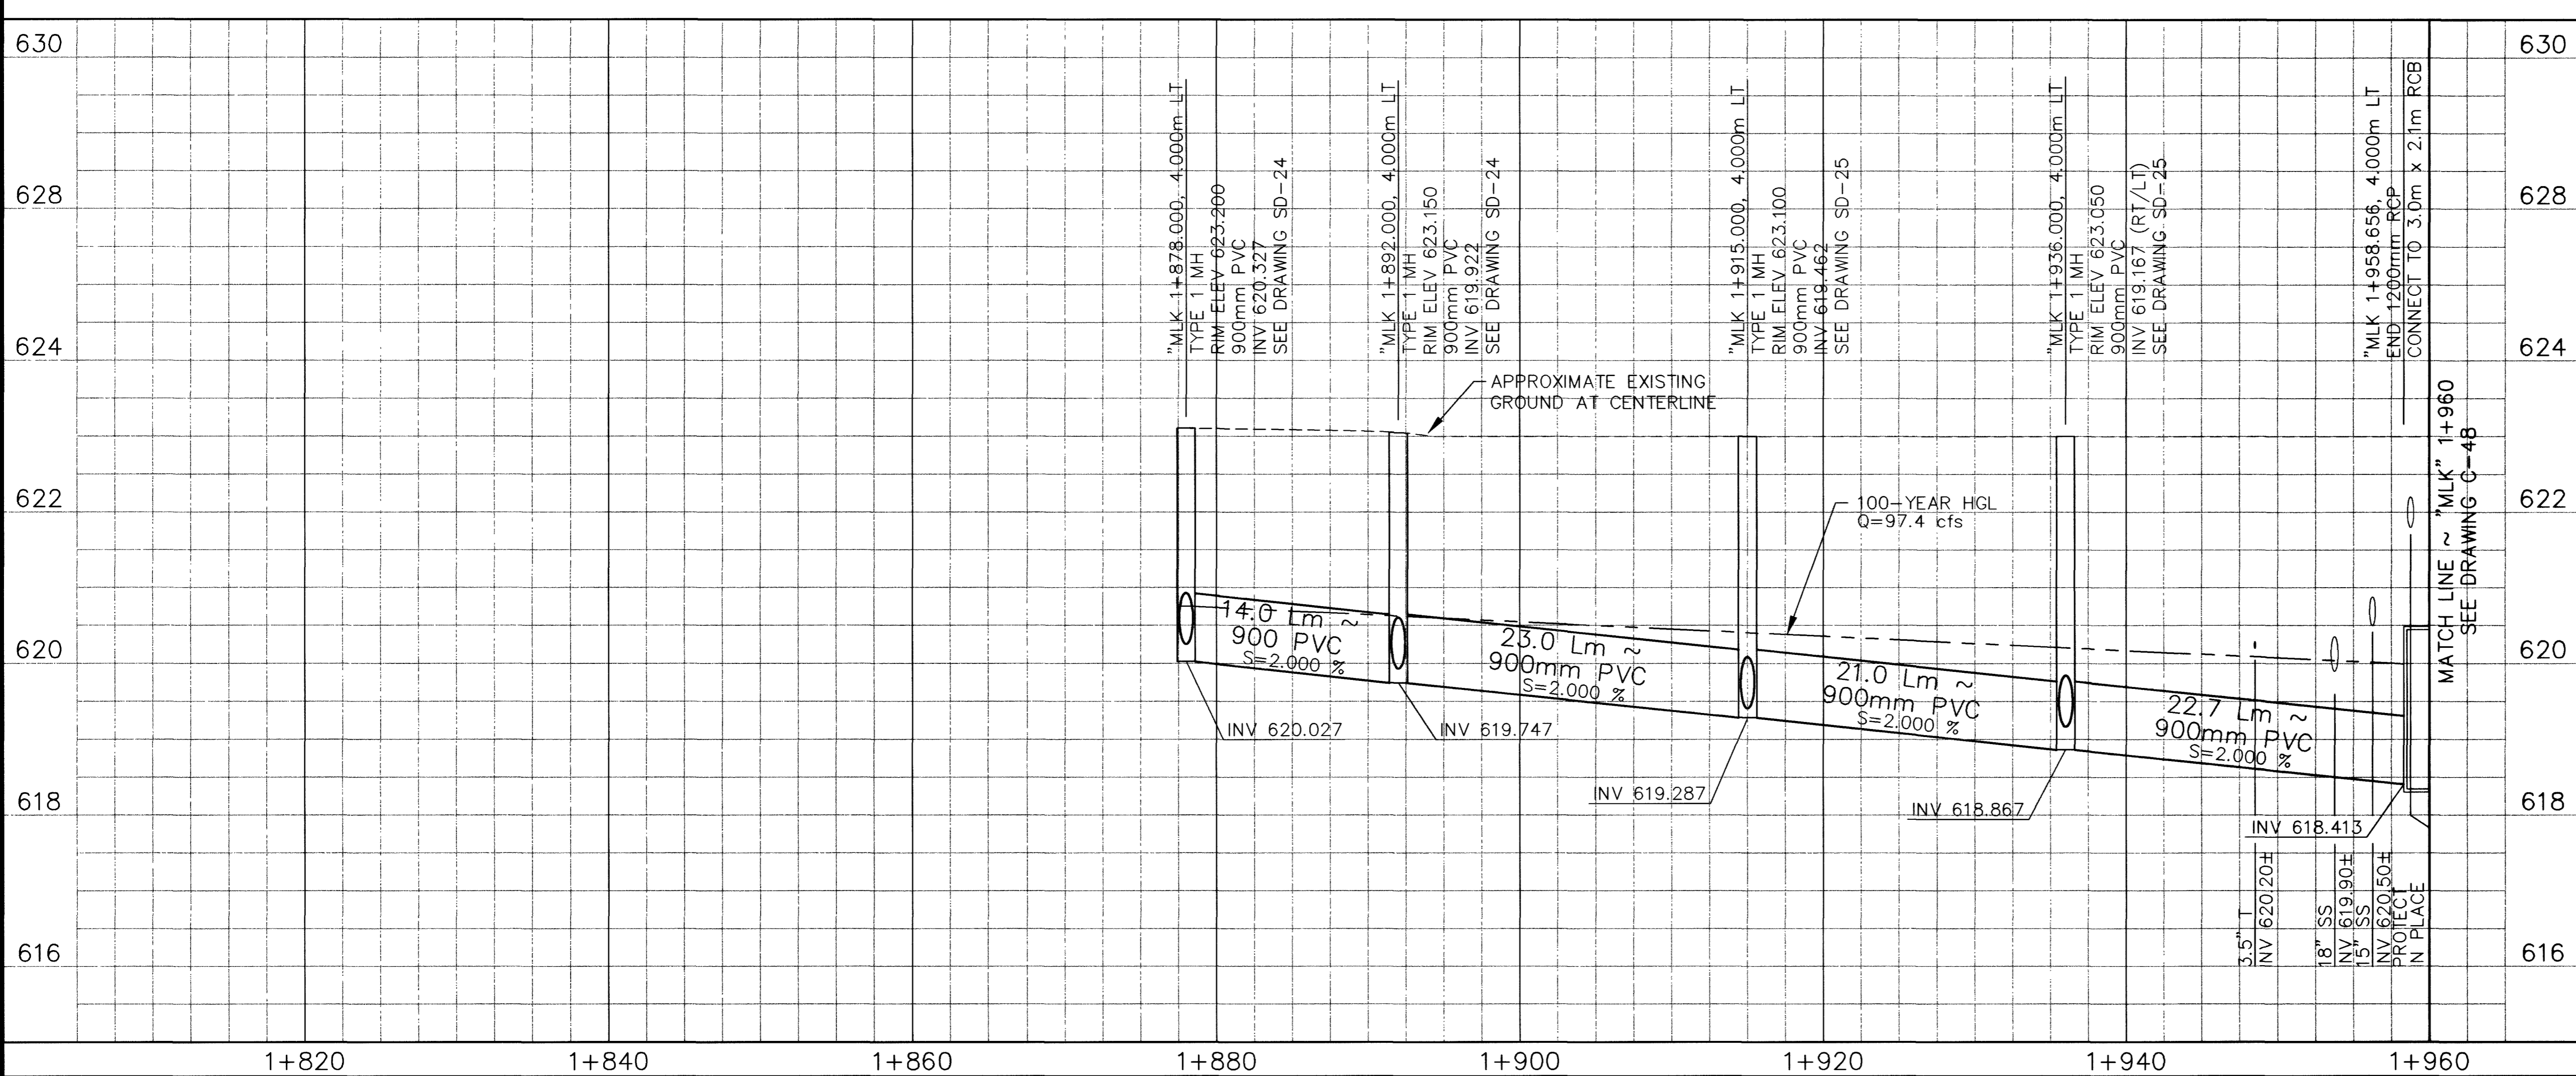

Call before you Dig. 1-800-277-2600 UNDERGROUND SERVICE (USA)

Call before you Overhead 563-6111 OVERHEAD SERVICE (USA)

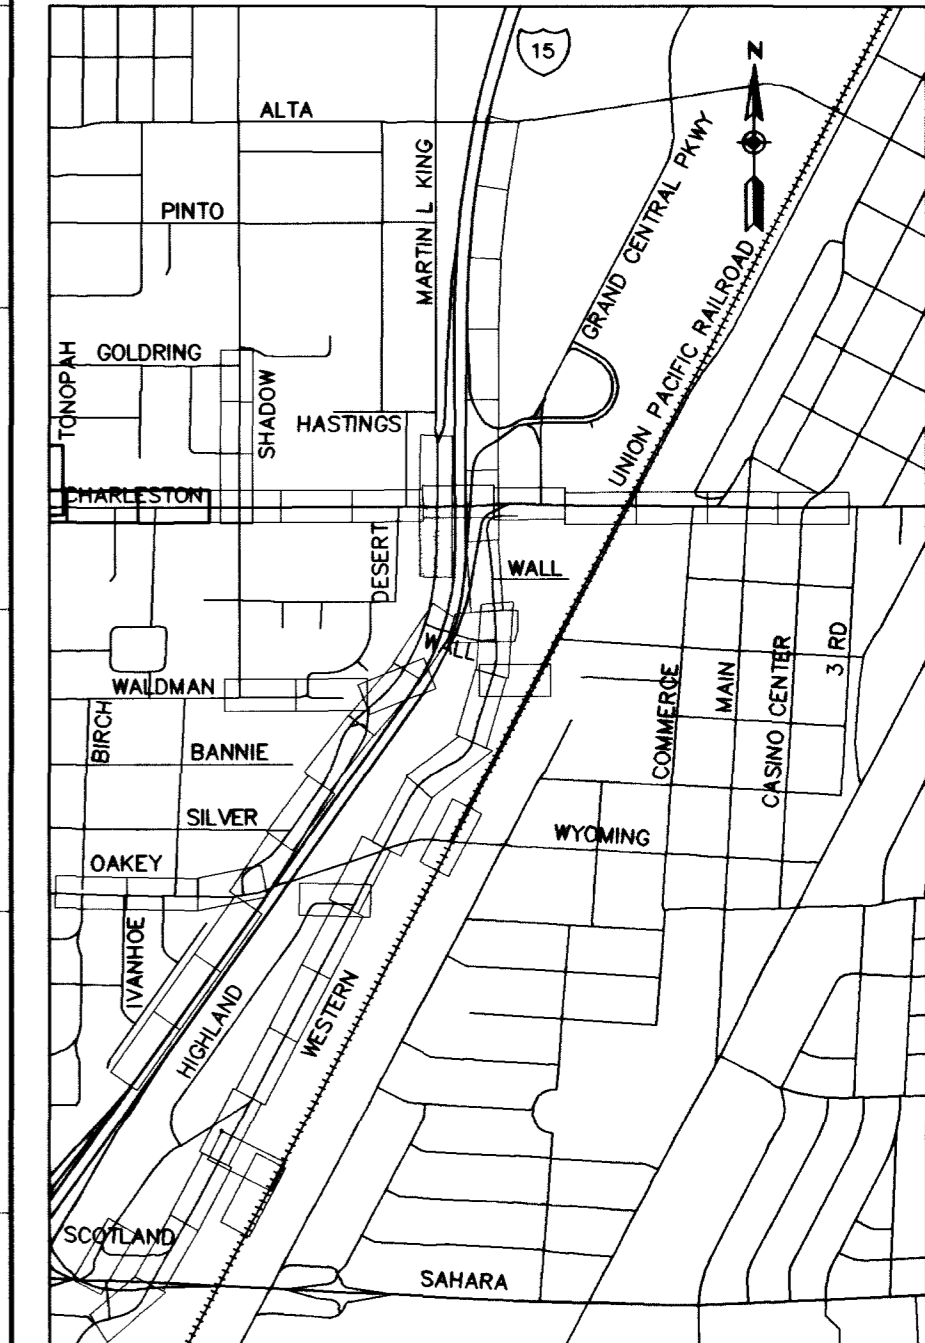

DATE 4/30/03

REVISIONS

RECORD DRAWING

PROJECT # 31604

DESIGN BY BPP

SCALE (V) 1:50 DATE DEC 17, 1999

SCALE (H) 1:250 FLD. BK. # N/A

**PB PARSONS BRINCKERHOFF**  
Las Vegas, Nevada

CIVIL ENGINEER

**DEPARTMENT OF PUBLIC WORKS**

I-15 FREEWAY CHANNEL

CONSTRUCTION PLAN AND PROFILE

"MLK" 1+860 TO "MLK" 1+960

ENGINEER-STATE OF NEVADA 1931

JOHN P. CLARK  
CIVIL ENGINEER

DRAWING No. 69

**RECORD DRAWING METRIC**

C-46

241