


- CONSTRUCTION ITEMS**
- ① "WL" 1+090.000 TO 1+240.000 CONSTRUCT 3.0m x 1.8m PRECAST RCB
 - ② "WL" 1+201.654, 1.120m LT CONSTRUCT RCB ACCESS MH (SEE DRAWING S-20)
 - ③ "WL" 1+101.551, 4.826m LT CONSTRUCT 3.0m DI TYPE "D" MOD. SEE DRAWING S-7
"WL" 1+219.717, 12.207m RT
 - ④ "WL" 1+101.551, 4.826m LT TO 1+101.551, 1.500m LT CONSTRUCT 450mm PVC
"WL" 1+219.717, 12.207m RT TO "WL" 1+219.717, 1.500m RT

DATE	REVISIONS
3/30/00	
5/03/01	
4/30/03	


SCALE (H)	SCALE (V)	PROJECT #
1:250	1:50	31604
F.L.D. BK. #	DATE	DESIGN BY
N/A	DEC 17, 1999	BPP



DEPARTMENT OF PUBLIC WORKS
I-15 FREEWAY CHANNEL
CONSTRUCTION PLAN AND PROFILE
"WL" 1+090 TO "WL" 1+240

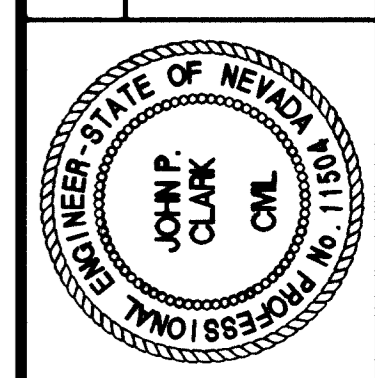

DRAWING No. **C-29**

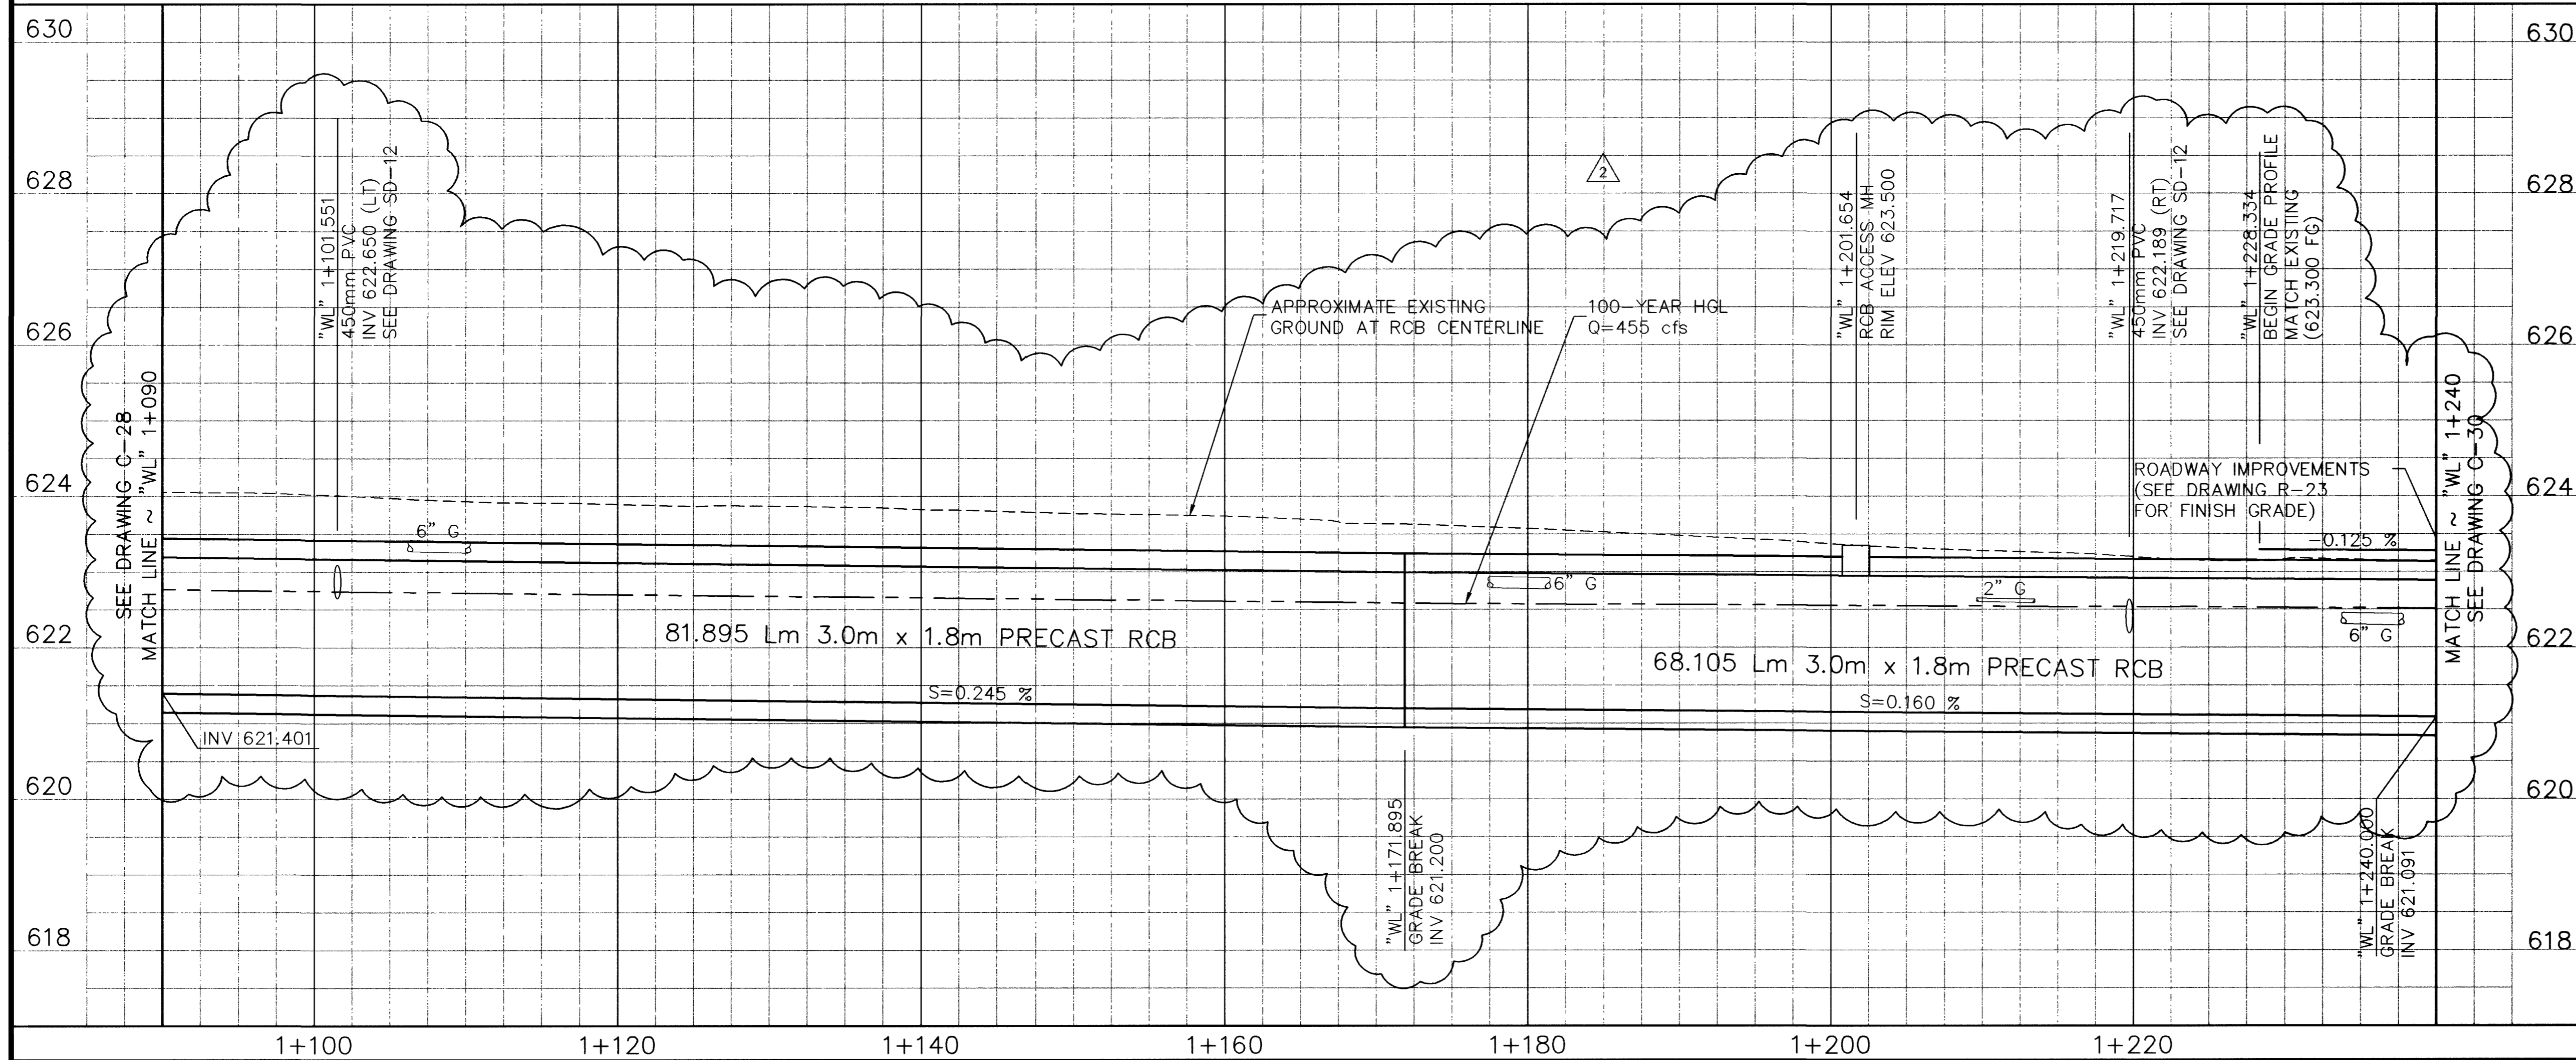


APPROVED FOR CONSTRUCTION

 LAS VEGAS VALLEY WATER DISTRICT DATE

Call before you Dig.
 1-800-277-2600
 UNDERGROUND SERVICE (USA)

Call before you Overhead
 563-6111
 OVERHEAD SERVICE (USA)

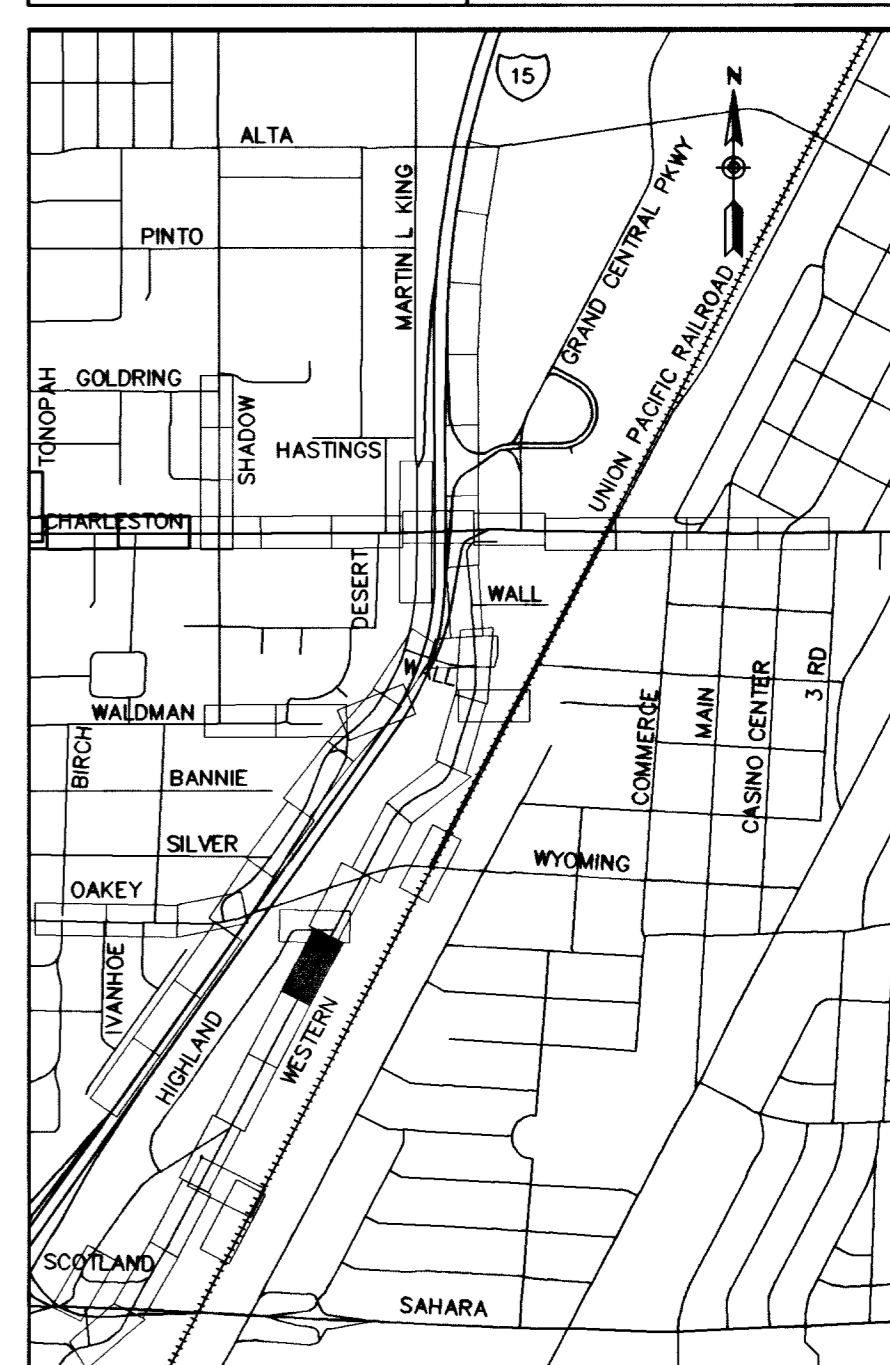

RECORD DRAWING METRIC