

- CONSTRUCTION ITEMS**
- ① "WL" 1+760.000 TO 1+840.000 CONSTRUCT 3.0m x 2.4m PRECAST RCB
  - ② "WL" 1+800.845, 0.820m LT CONSTRUCT RCB ACCESS MH SEE DRAWING S-20
  - ③ "WL" 1+761.841, 4.450m LT CONSTRUCT 3.0m DI TYPE "D" MOD. SEE DRAWING S-7A
  - ④ "WL" 1+754.107, 12.250m RT CONSTRUCT 6.0m DI TYPE "D" MOD. SEE DRAWING S-7
  - ⑤ "WL" 1+825.000, 4.450m LT TO 1+825.000, 1.500m LT CONSTRUCT 450mm PVC
  - ⑥ "WL" 1+754.107, 12.250m RT TO 1+754.107, 1.500m RT "WL" 1+761.841, 4.450m LT TO 1+761.841, 1.500m LT CONSTRUCT 600mm PVC
  - ⑨ "WL" 1+690.000 TO 1+760.000 CONSTRUCT 3.0m x 2.1m PRECAST RCB

SEE DRAWING R-26 FOR ROADWAY

SEE DRAWING U-38 FOR WATER LINE RELOCATION

SEE DRAWING U-21 FOR SANITARY SEWER


SEE DRAWING TS-7 FOR TYPICAL SECTION

APPROVED FOR CONSTRUCTION

LAS VEGAS VALLEY WATER DISTRICT DATE


**"WL" CURVE TABLE**

No.	Δ	R	L	T
WL 4	45°31'30"	83.159m	66.075m	34.893m

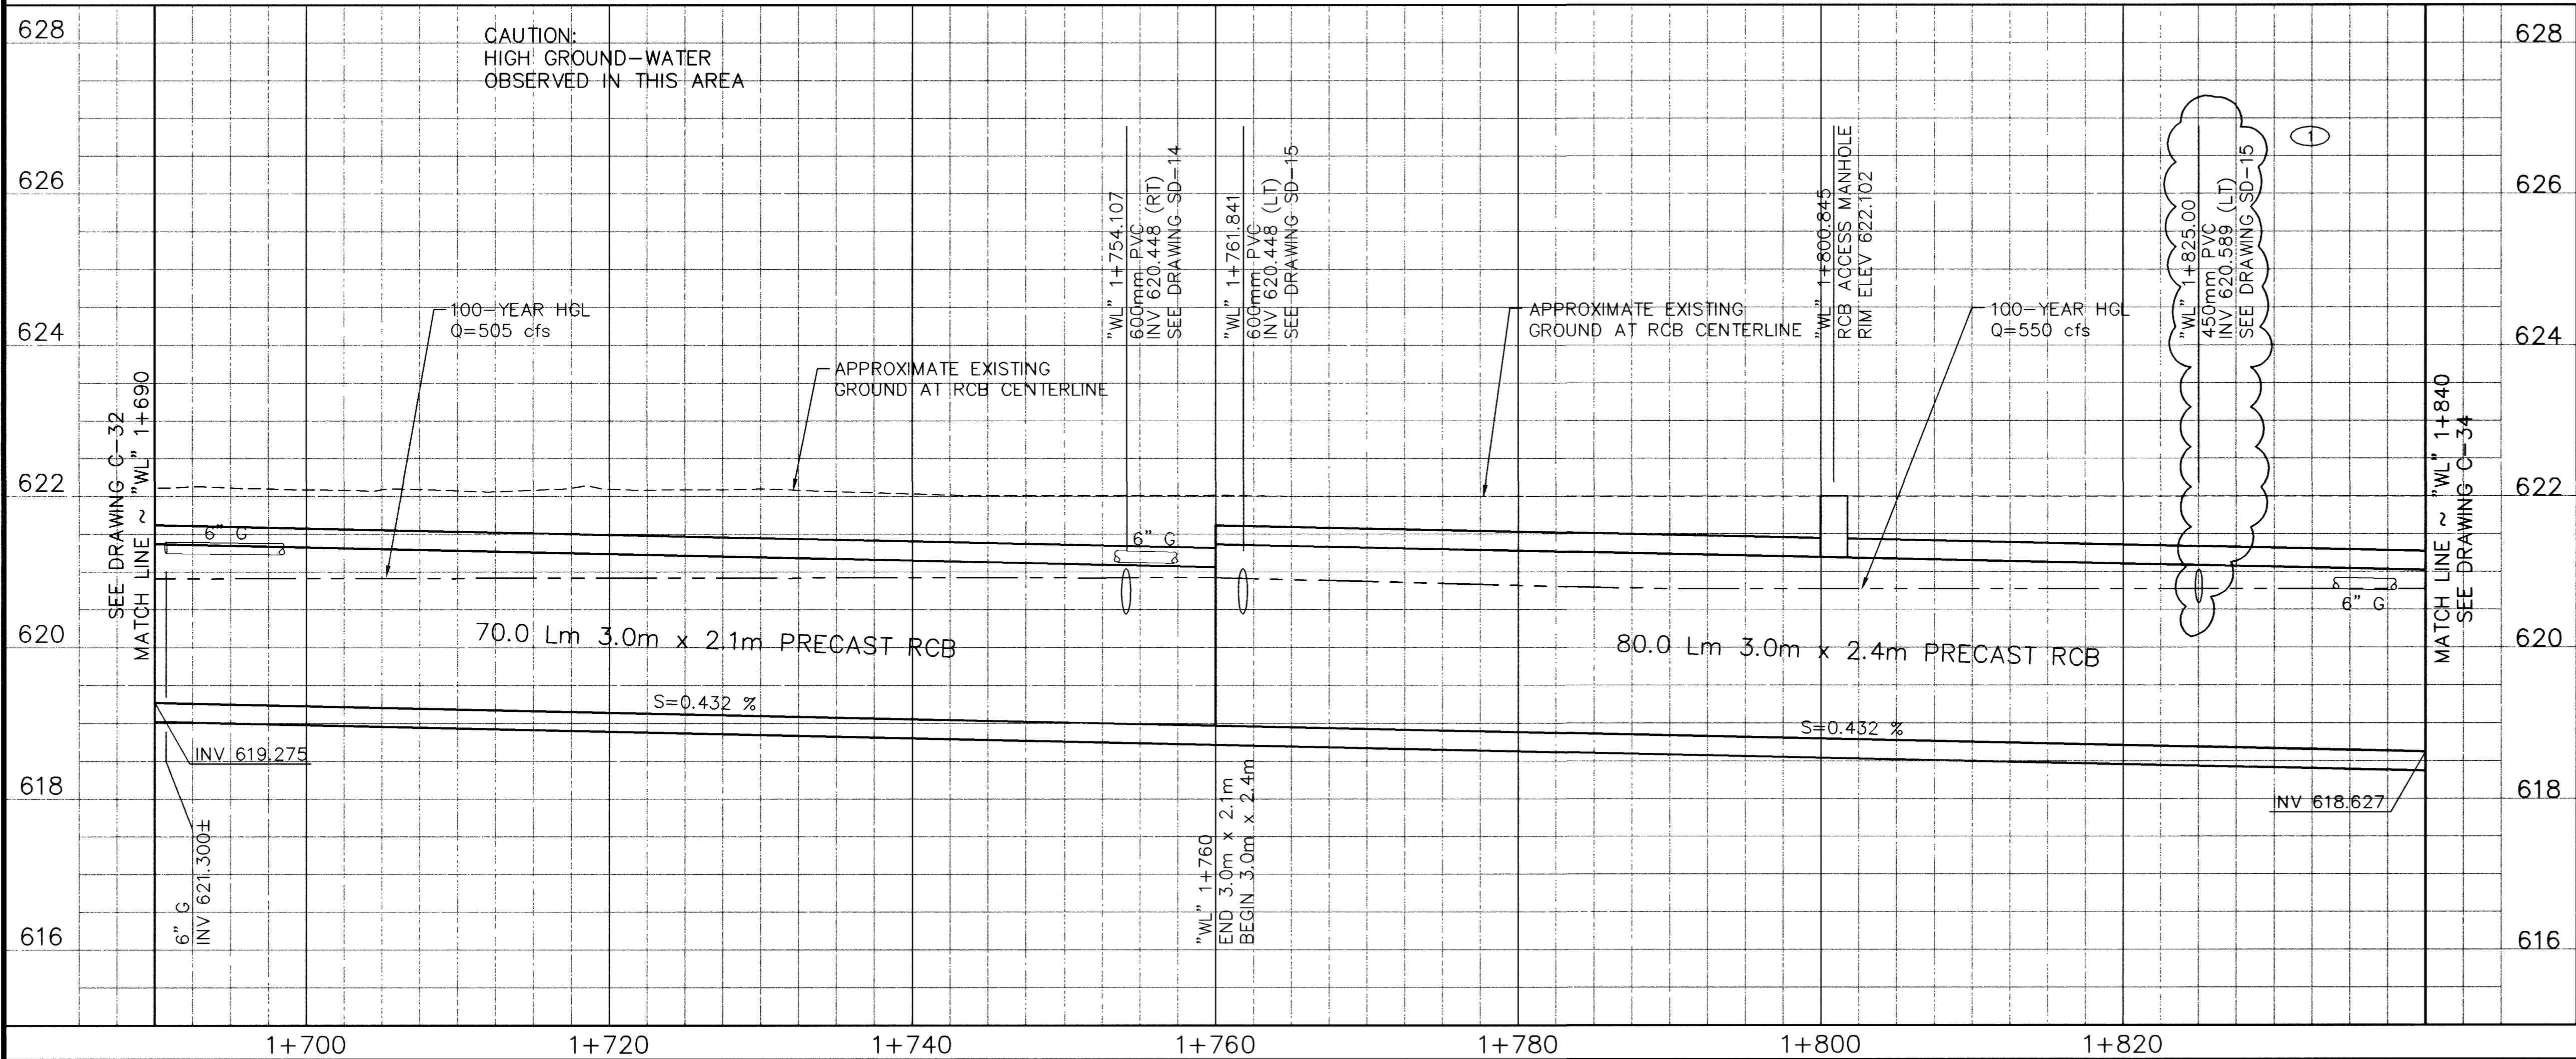

**Call before you Dig.**  
1-800-227-2600  
UNDERGROUND SERVICE (USA)

**Call before you Crane.**  
227-2929  
OVERHEAD SERVICE (USA)

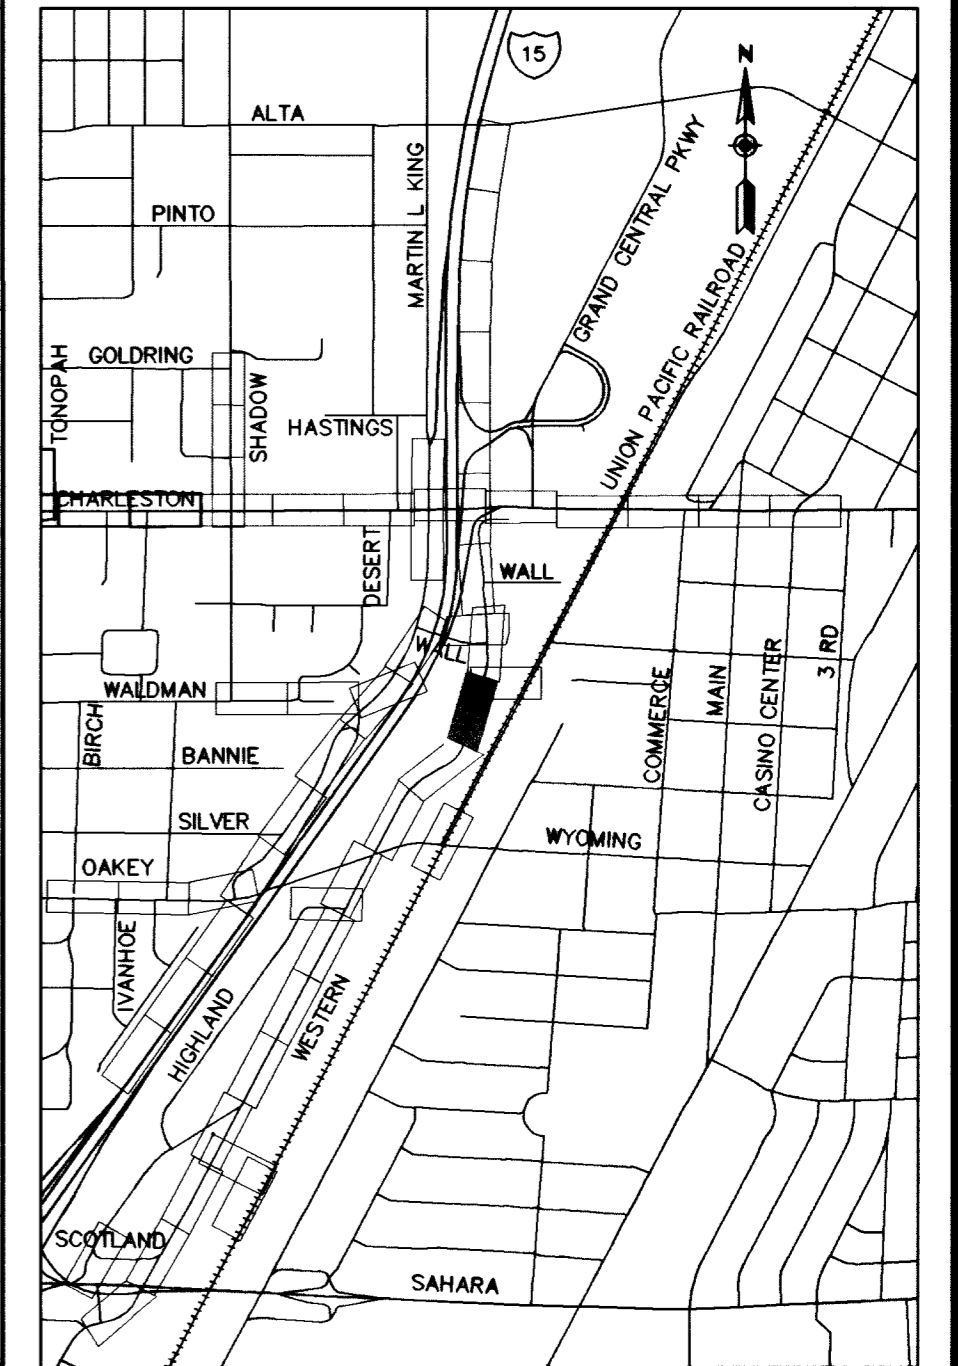

DATE: 3/30/00  
4/27/01  
4/30/03

REVISIONS: ADJUNCTION 2  
DESIGN BY: BPP  
RECORD DRAWING

PROJECT # 31604  
SCALE (V) 1:50  
DATE DEC 17, 1999  
SCALE (H) 1:250  
FLD. BK. # N/A

**PARSONS BRINCKERHOFF**  
Las Vegas, Nevada

APPROVED FOR CONSTRUCTION

LAS VEGAS VALLEY WATER DISTRICT DATE

**DEPARTMENT OF PUBLIC WORKS**  
I-15 FREEWAY CHANNEL  
CONSTRUCTION PLAN AND PROFILE  
"WL" 1+690 TO "WL" 1+840

**RECORD DRAWING METRIC**

DRAWING No. 56  
C-33 241

327-V254