

- CONSTRUCTION ITEMS**
- ① "W" 1+701.704, 7.405m LT  
"W" 1+780.000, 7.405m LT  
CONSTRUCT TYPE I SANITARY SEWER MH
  - ② "W" 1+690.000, 7.405m LT TO  
"W" 1+701.704, 7.405m LT TO  
"W" 1+701.704, 7.405m LT TO  
"W" 1+780.000, 7.405m LT TO  
"W" 1+840.000, 7.405m LT TO  
"W" 1+840.000, 7.796m LT  
CONSTRUCT 200mm SANITARY SEWER PIPE
  - ③ "W" 1+699.200 LT  
"W" 1+716.300 LT  
"W" 1+751.700 LT  
"W" 1+773.200 LT  
"W" 1+804.600 LT  
"W" 1+809.100 LT  
"W" 1+818.500 LT  
RECONNECT EX SANITARY SEWER LATERAL
  - ④ "W" 1+698.000 LT  
"W" 1+717.600 LT  
"W" 1+739.300 LT  
"W" 1+786.400 LT  
RECONNECT EX WATER SERVICE PER LVVWD UDS PLATE No. 1B OR 1D
  - ⑤ "W" 1+748.766, 4.570m RT TO  
"W" 1+757.766, 4.570m RT  
RELOCATE 150mm WATER LINE SEE DETAIL DRAWING U-40
  - ⑥ "W" 1+839.789, 3.901m RT  
"W" 1+840.000, 9.296m LT  
ADJUST VALVE COVER

SEE DRAWING R-26 FOR ROADWAY

SEE DRAWING C-33 FOR DRAINAGE PLAN

**SS CURVE TABLE**

No.	Δ	R	L	T
W3	45°31'30"	75.754m	60.191m	37.786m

APPROVED FOR CONSTRUCTION



*1st sign 3/13/10*

*2nd sign 5/12/10*

LAS VEGAS VALLEY WATER DISTRICT DATE

**Call before you Dig.**  
1-800-227-2600  
UNDERGROUND SERVICE (USA)

**Call before you Crane.**  
227-2929  
OVERHEAD SERVICE (USA)

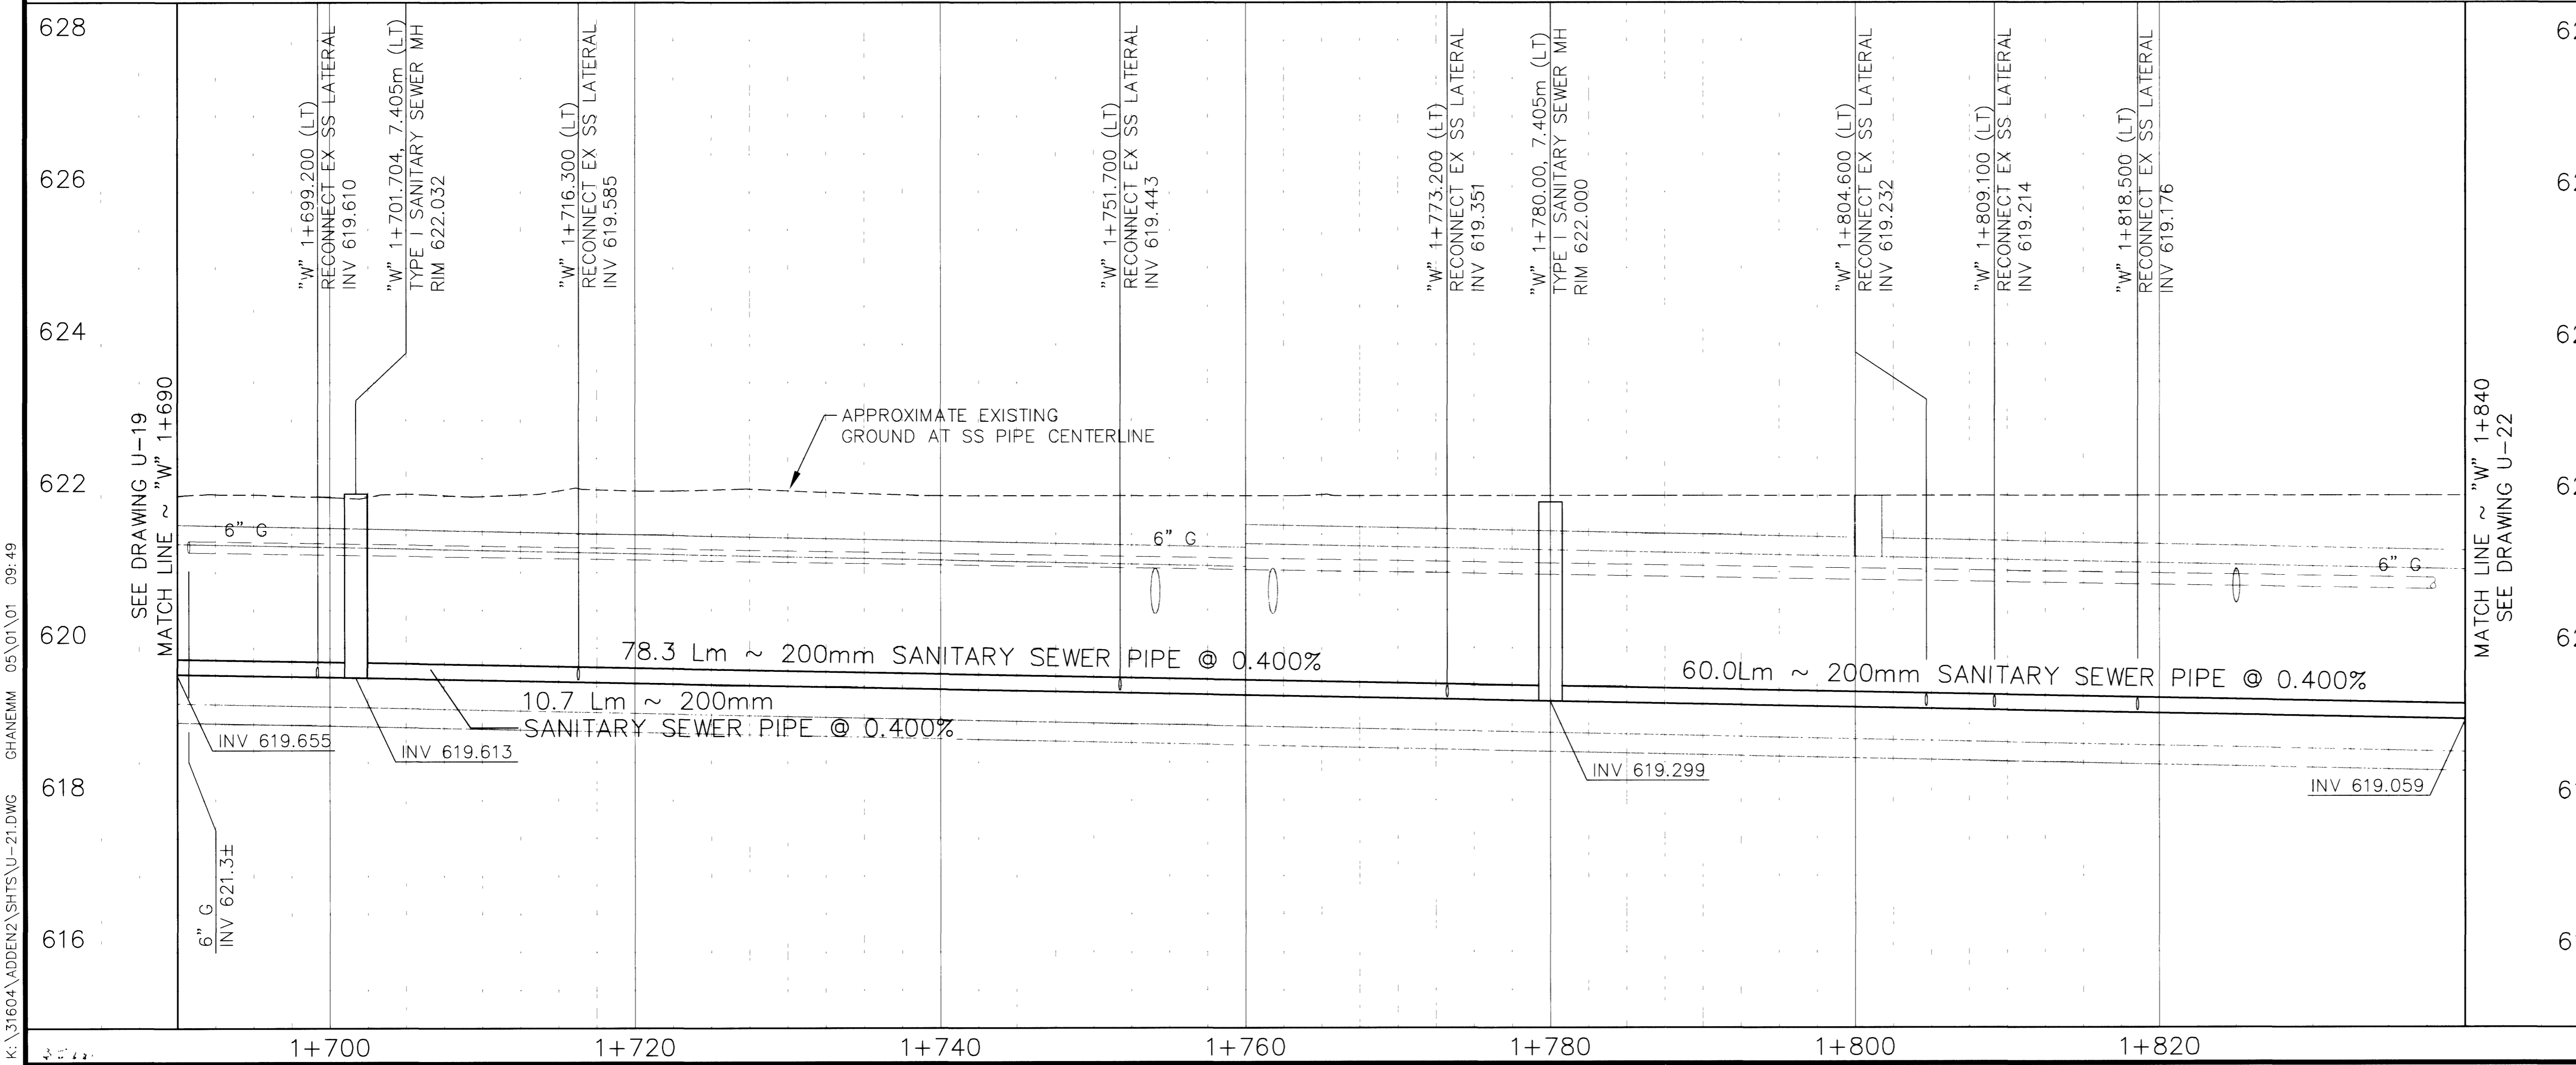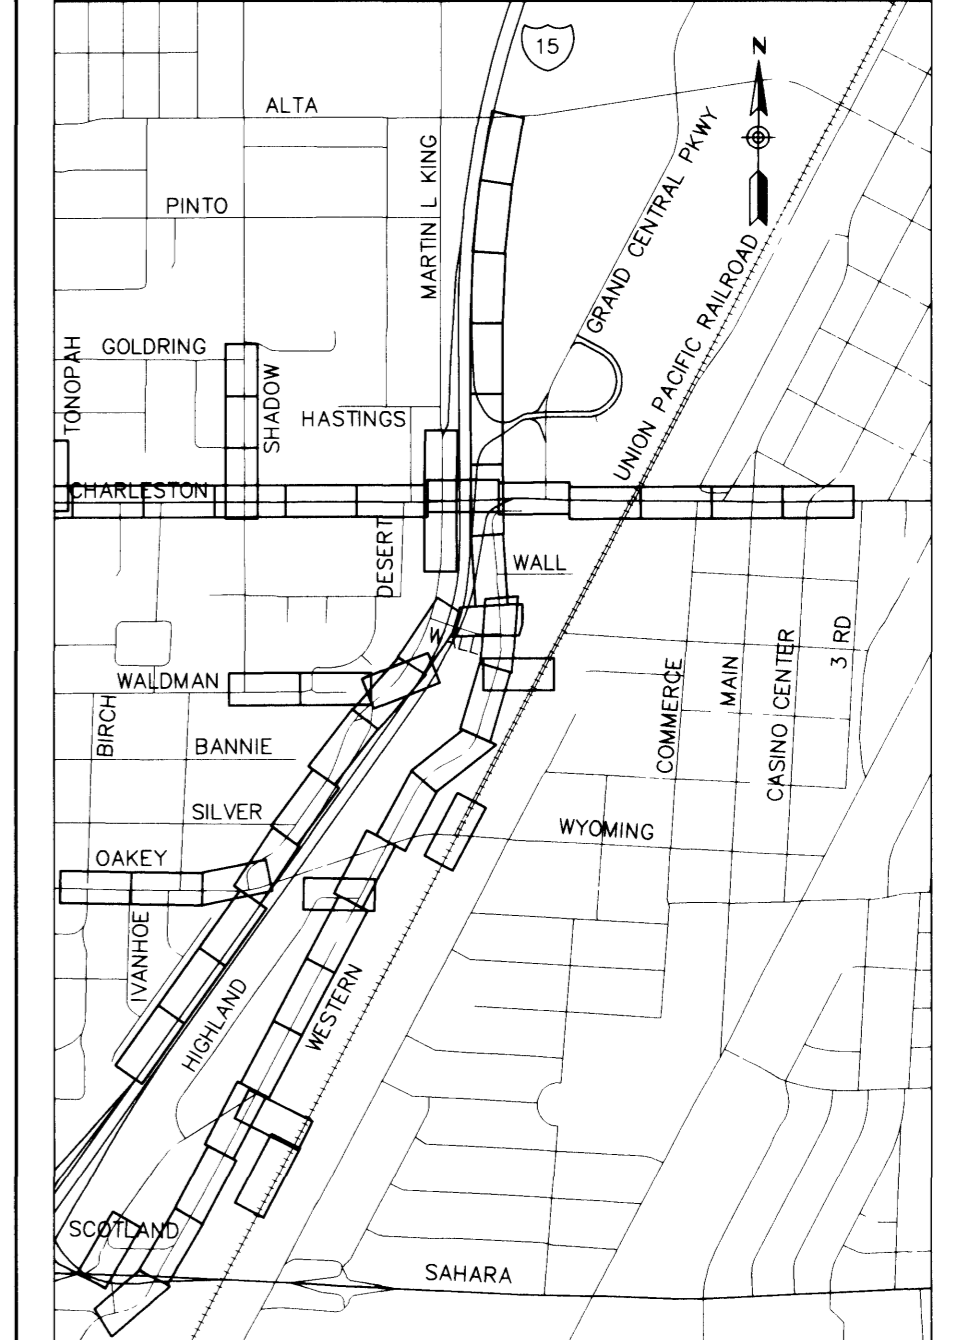

DATE: 4/27/10

REVISIONS: REVISED WESTERN AVENUE

PROJECT # 31604

DESIGN BY KFN

SCALE (H) 1:250

SCALE (V) 1:50

DATE: DECEMBER 17, 1999

FLD. Bk. # N/A

DESIGN BY KFN

**PARSONS BRINCKERHOFF**

STATE OF NEVADA

ENGINEER JOHN P. CLARK No. 111300

DEPARTMENT OF PUBLIC WORKS

I-15 FREEWAY CHANNEL

UTILITY RELOCATION (WESTERN AVE)

"W" 1+690 TO "W" 1+840

DRAWING No. U-21

180

241

K:\31604\ADDEN\SHTS\U-21.DWG GHANEM 05/01/01 09:49