


K:\16041\ADDEN\SHITS\U-22.DWG GHANEM 05/02/01 11:

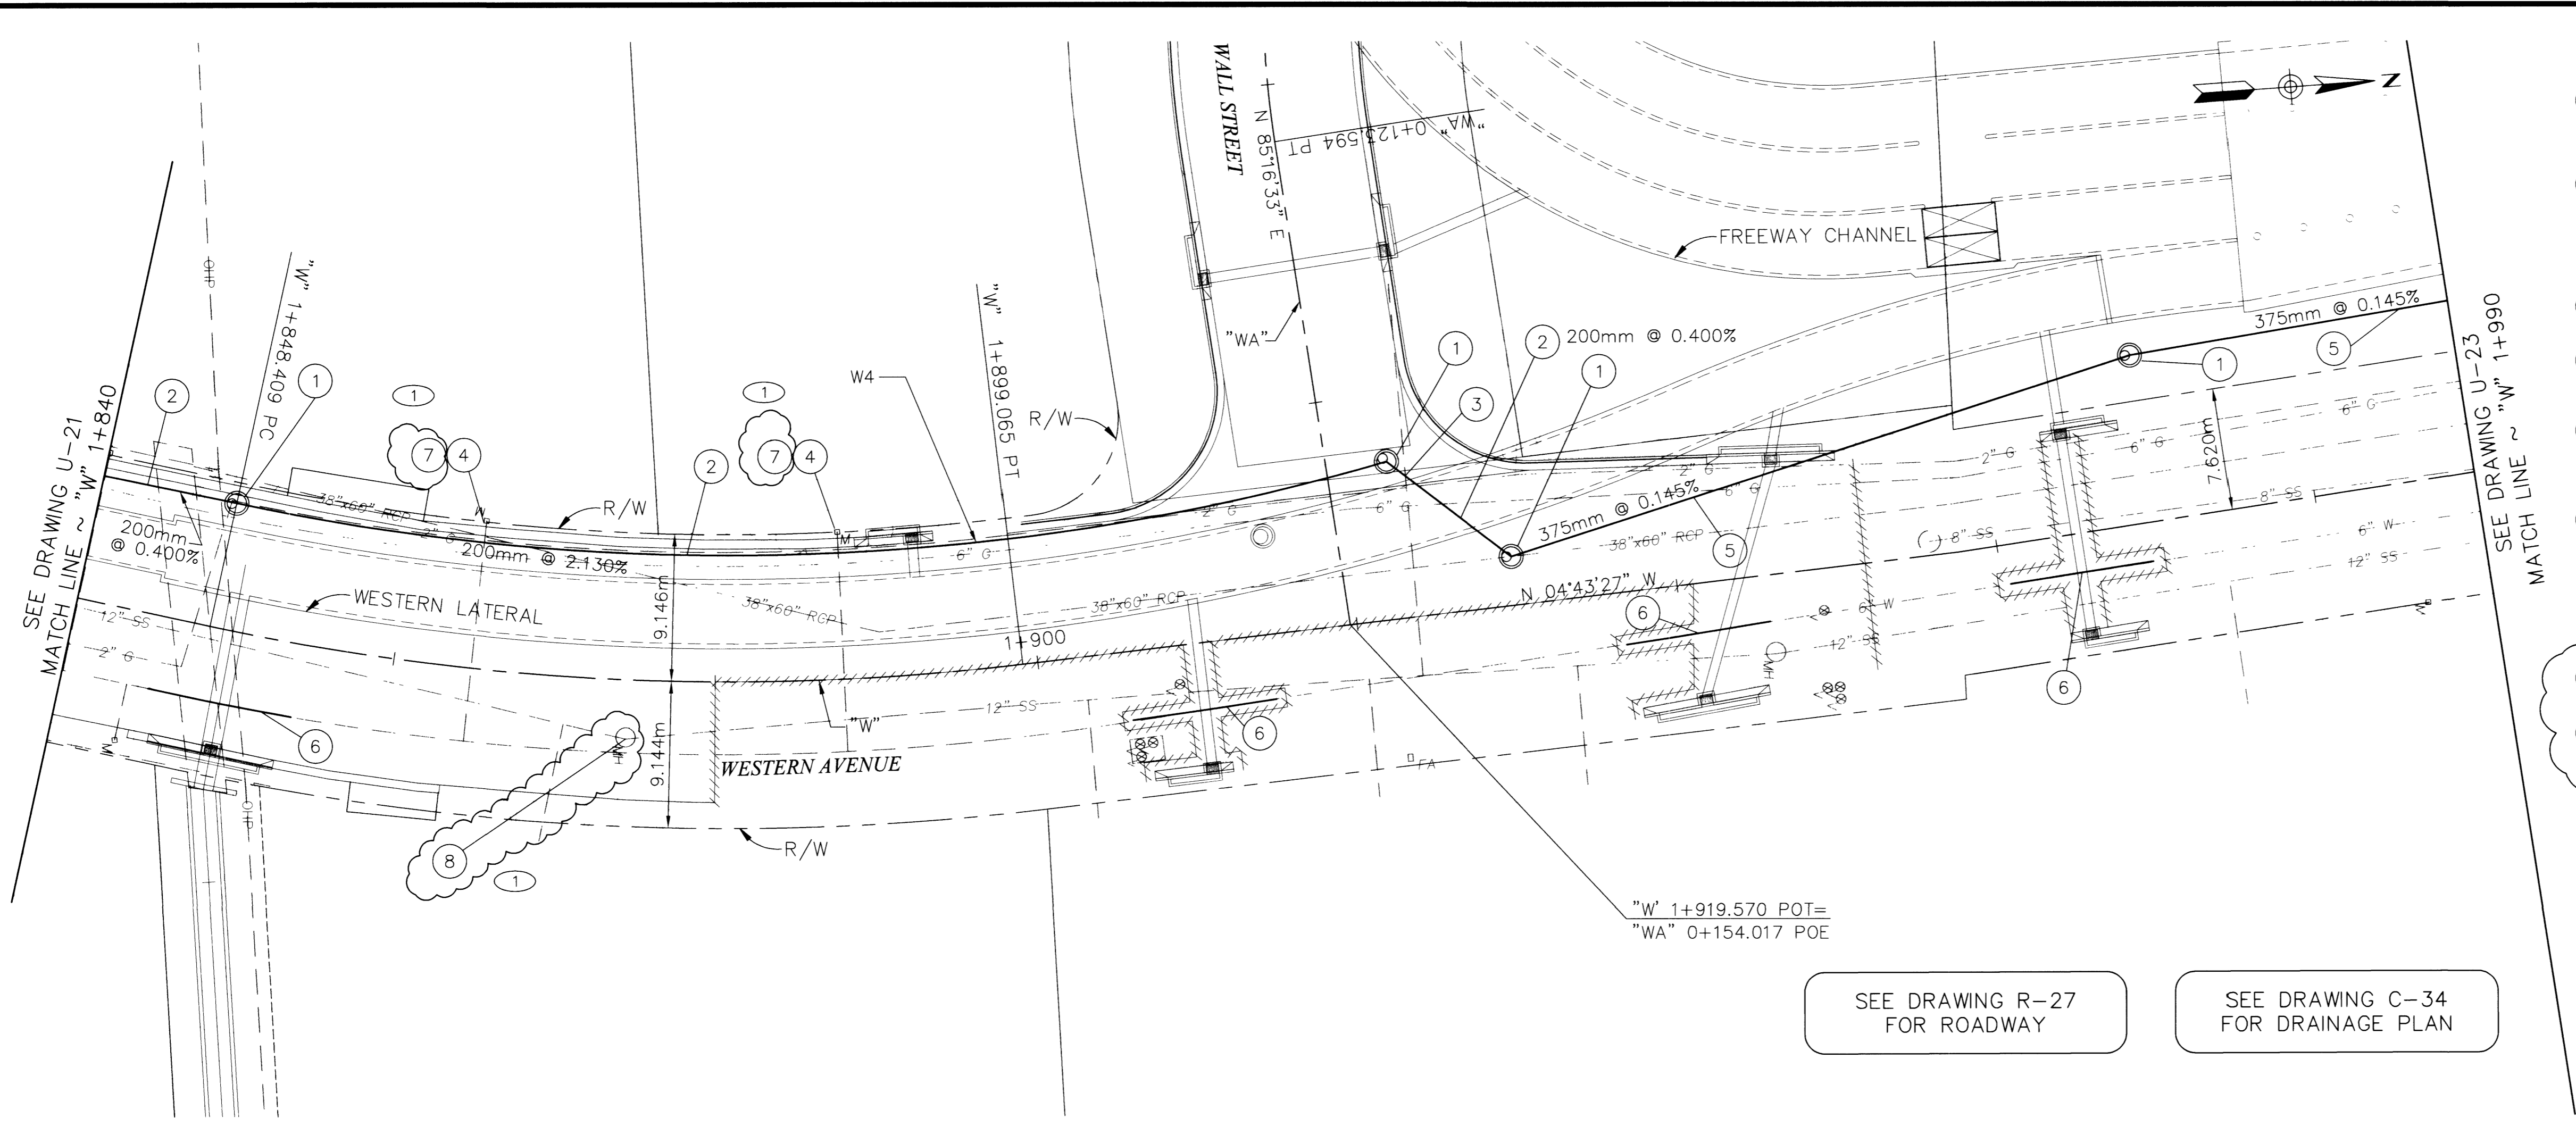

- CONSTRUCTION ITEMS**
- ① "W" 1+848.409, 7.850m LT CONSTRUCT TYPE I SANITARY SEWER MH
 - ② "W" 1+923.000, 9.845m RT CONSTRUCT 200mm SANITARY SEWER PIPE
 - ③ "W" 1+848.409, 7.850m LT TO "W" 1+923.000, 9.845m LT
 - ④ "W" 1+930.000, 3.048m LT RECONNECT EX. SANITARY SEWER LATERAL
 - ⑤ "W" 1+970.000, 10.500m LT RECONNECT EX. WATER SERVICE PER LVWD UDS PLATE NO 1A OR 1D
 - ⑥ "W" 1+864.800 LT CONSTRUCT 375mm SANITARY SEWER PIPE
 - ⑦ "W" 1+930.000, 3.048m LT TO "W" 1+970.000, 10.500m LT
 - ⑧ "W" 1+845.500, 4.575m RT TO "W" 1+854.500, 4.564m RT RELOCATE 150mm WATER LINE SEE DRAWING U-40
 - ⑨ "W" 1+900.500, 4.500m RT TO "W" 1+909.500, 4.500m RT
 - ⑩ "W" 1+935.500, 3.000m RT TO "W" 1+944.500, 3.000m RT
 - ⑪ "W" 1+960.500, 2.500m RT TO "W" 1+969.500, 2.500m RT
 - ⑫ "W" 1+887.978, 9.169m LT ADJUST WATER METER COVER
 - ⑬ "W" 1+864.805, 9.225m LT ADJUST MANHOLE COVER

SEE DRAWING R-27 FOR ROADWAY

SEE DRAWING C-34 FOR DRAINAGE PLAN

SS CURVE TABLE

No.	Δ	R	L	T
W4	28°34'09"	144.635m	72.093m	36.813m



APPROVED FOR CONSTRUCTION

For April 3, 2001

LAS VEGAS VALLEY WATER DISTRICT DATE

Call before you Dig.
1-800-227-2600
UNDERGROUND SERVICE (USA)

Call before you Crane
227-2929
OVERHEAD SERVICE (USA)

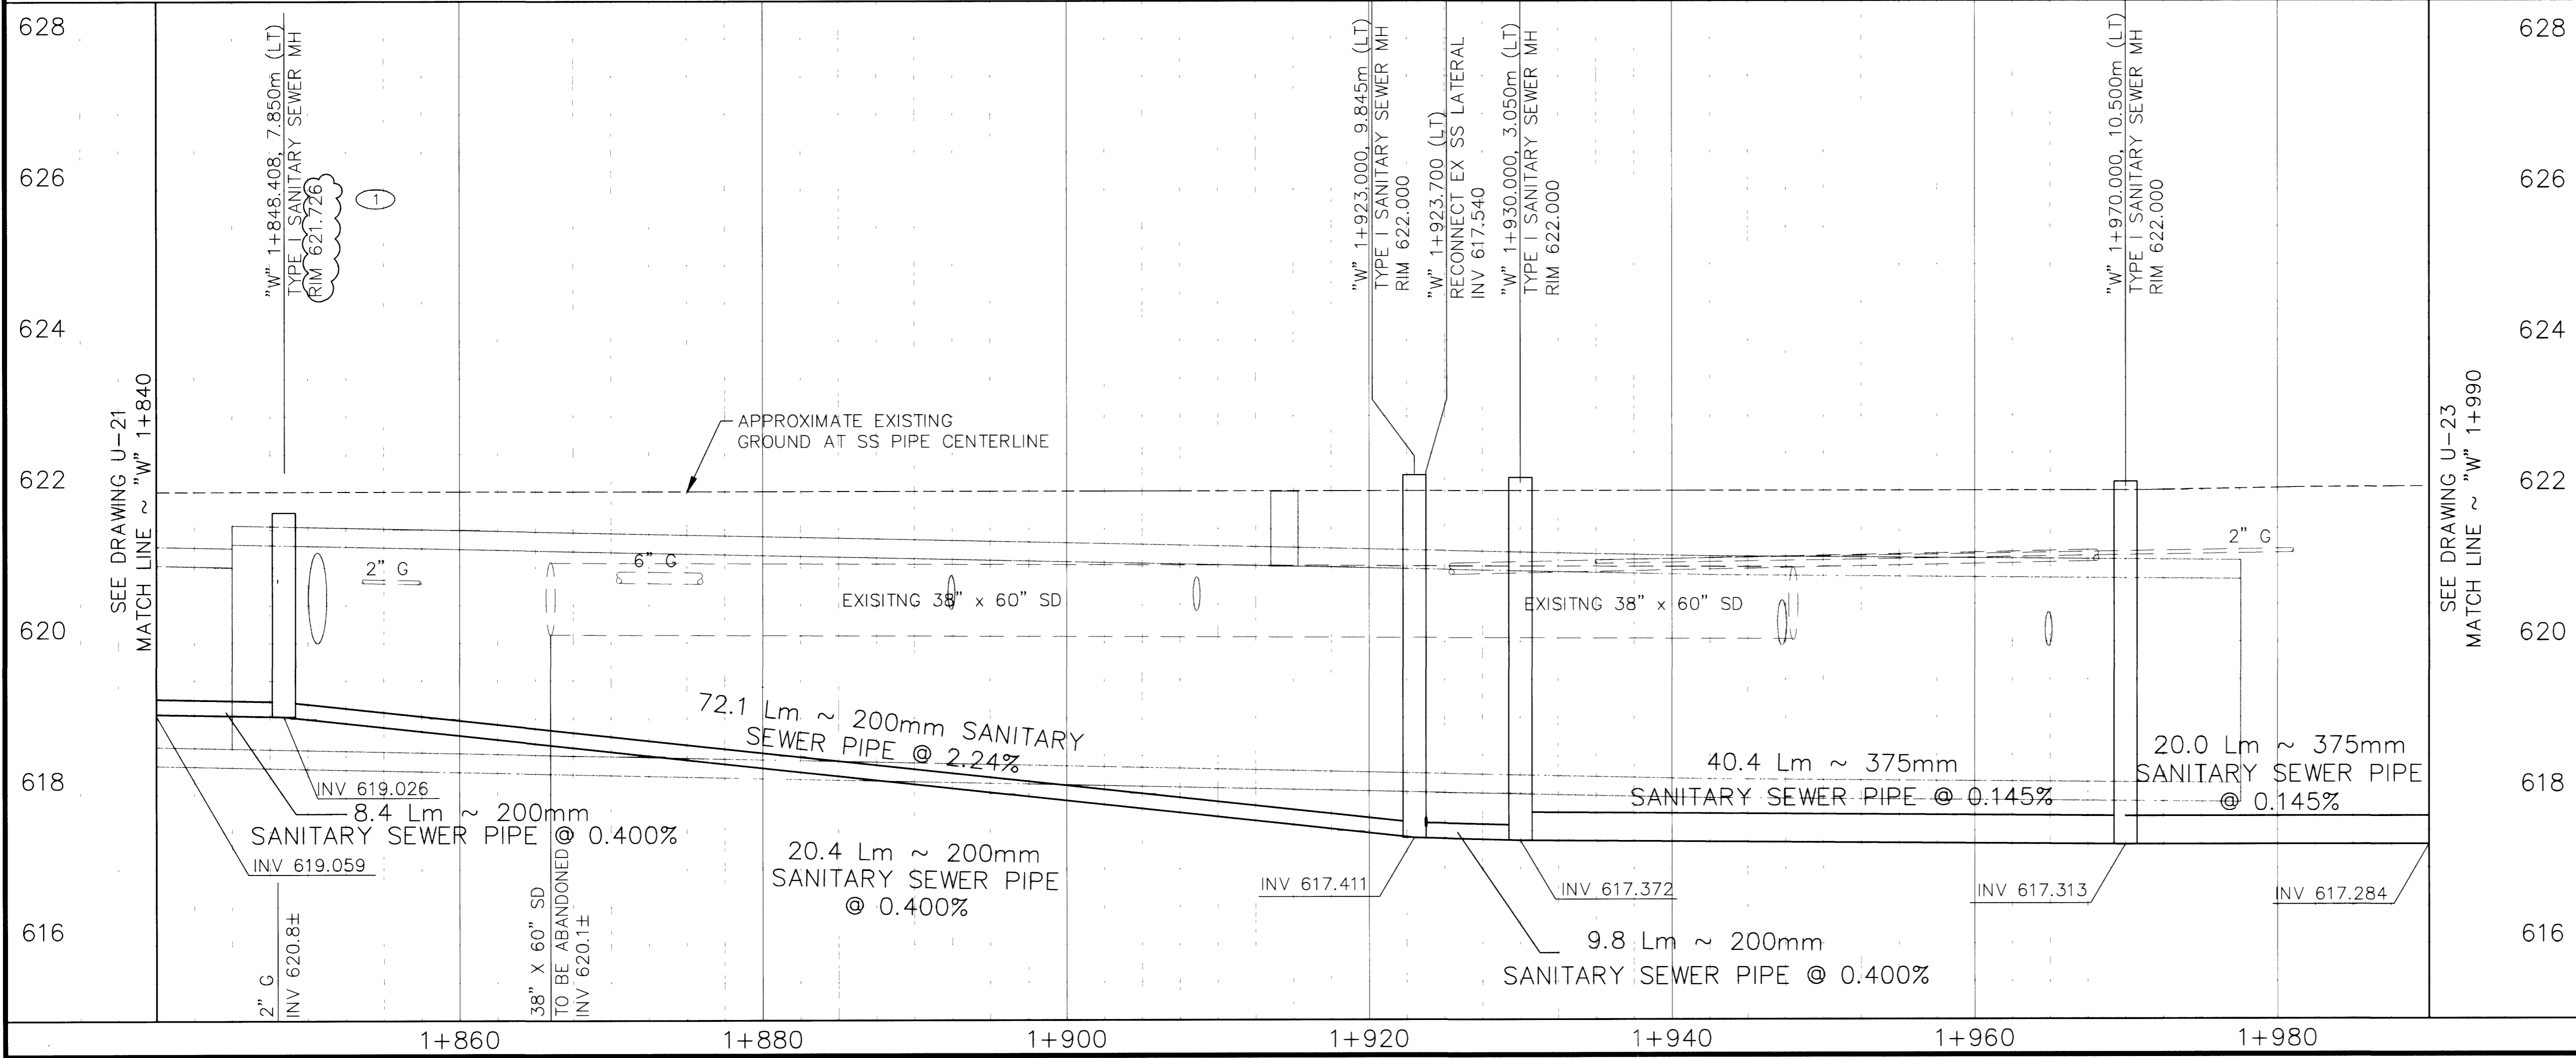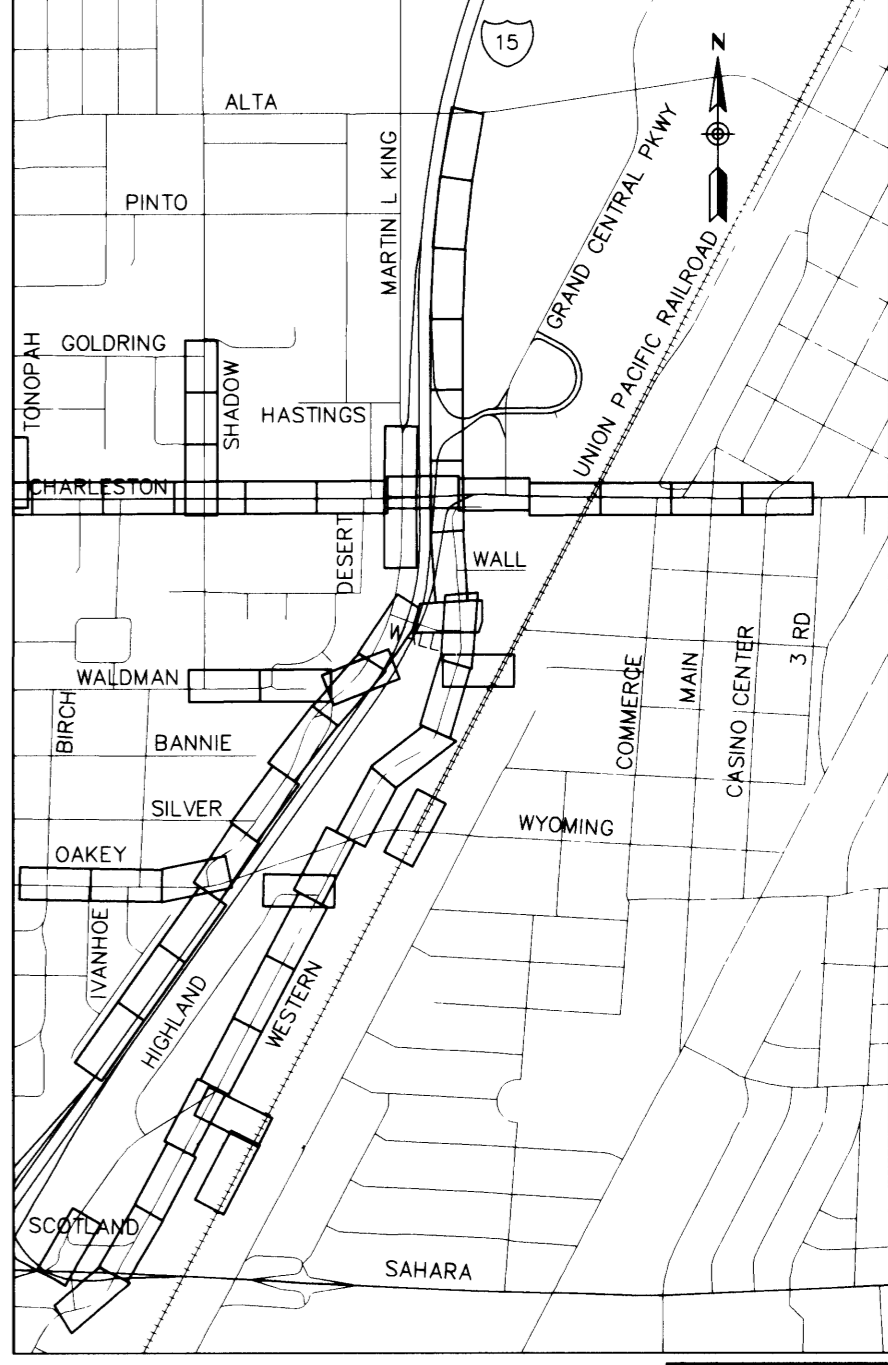

SEE DRAWING U-23
MATCH LINE ~ "W" 1+990

SEE DRAWING U-21
MATCH LINE ~ "W" 1+840

DATE: 4/27/01

REVISIONS: REVISED WESTERN AVENUE

PROJECT # 31604

DESIGN BY: KFN

SCALE (V): 1:50

DATE: APRIL 03, 2001

SCALE (H): 1:250

F.L.D. Bk. # N/A

PARSONS BRINCKERHOFF
Los Vegas, Nevada

DEPARTMENT OF PUBLIC WORKS

I-15 FREEWAY CHANNEL

UTILITY RELOCATION (WESTERN AVE)

"W" 1+840 TO "W" 1+990

DRAWING No. 181

U-22

241

METRIC

327-V254