
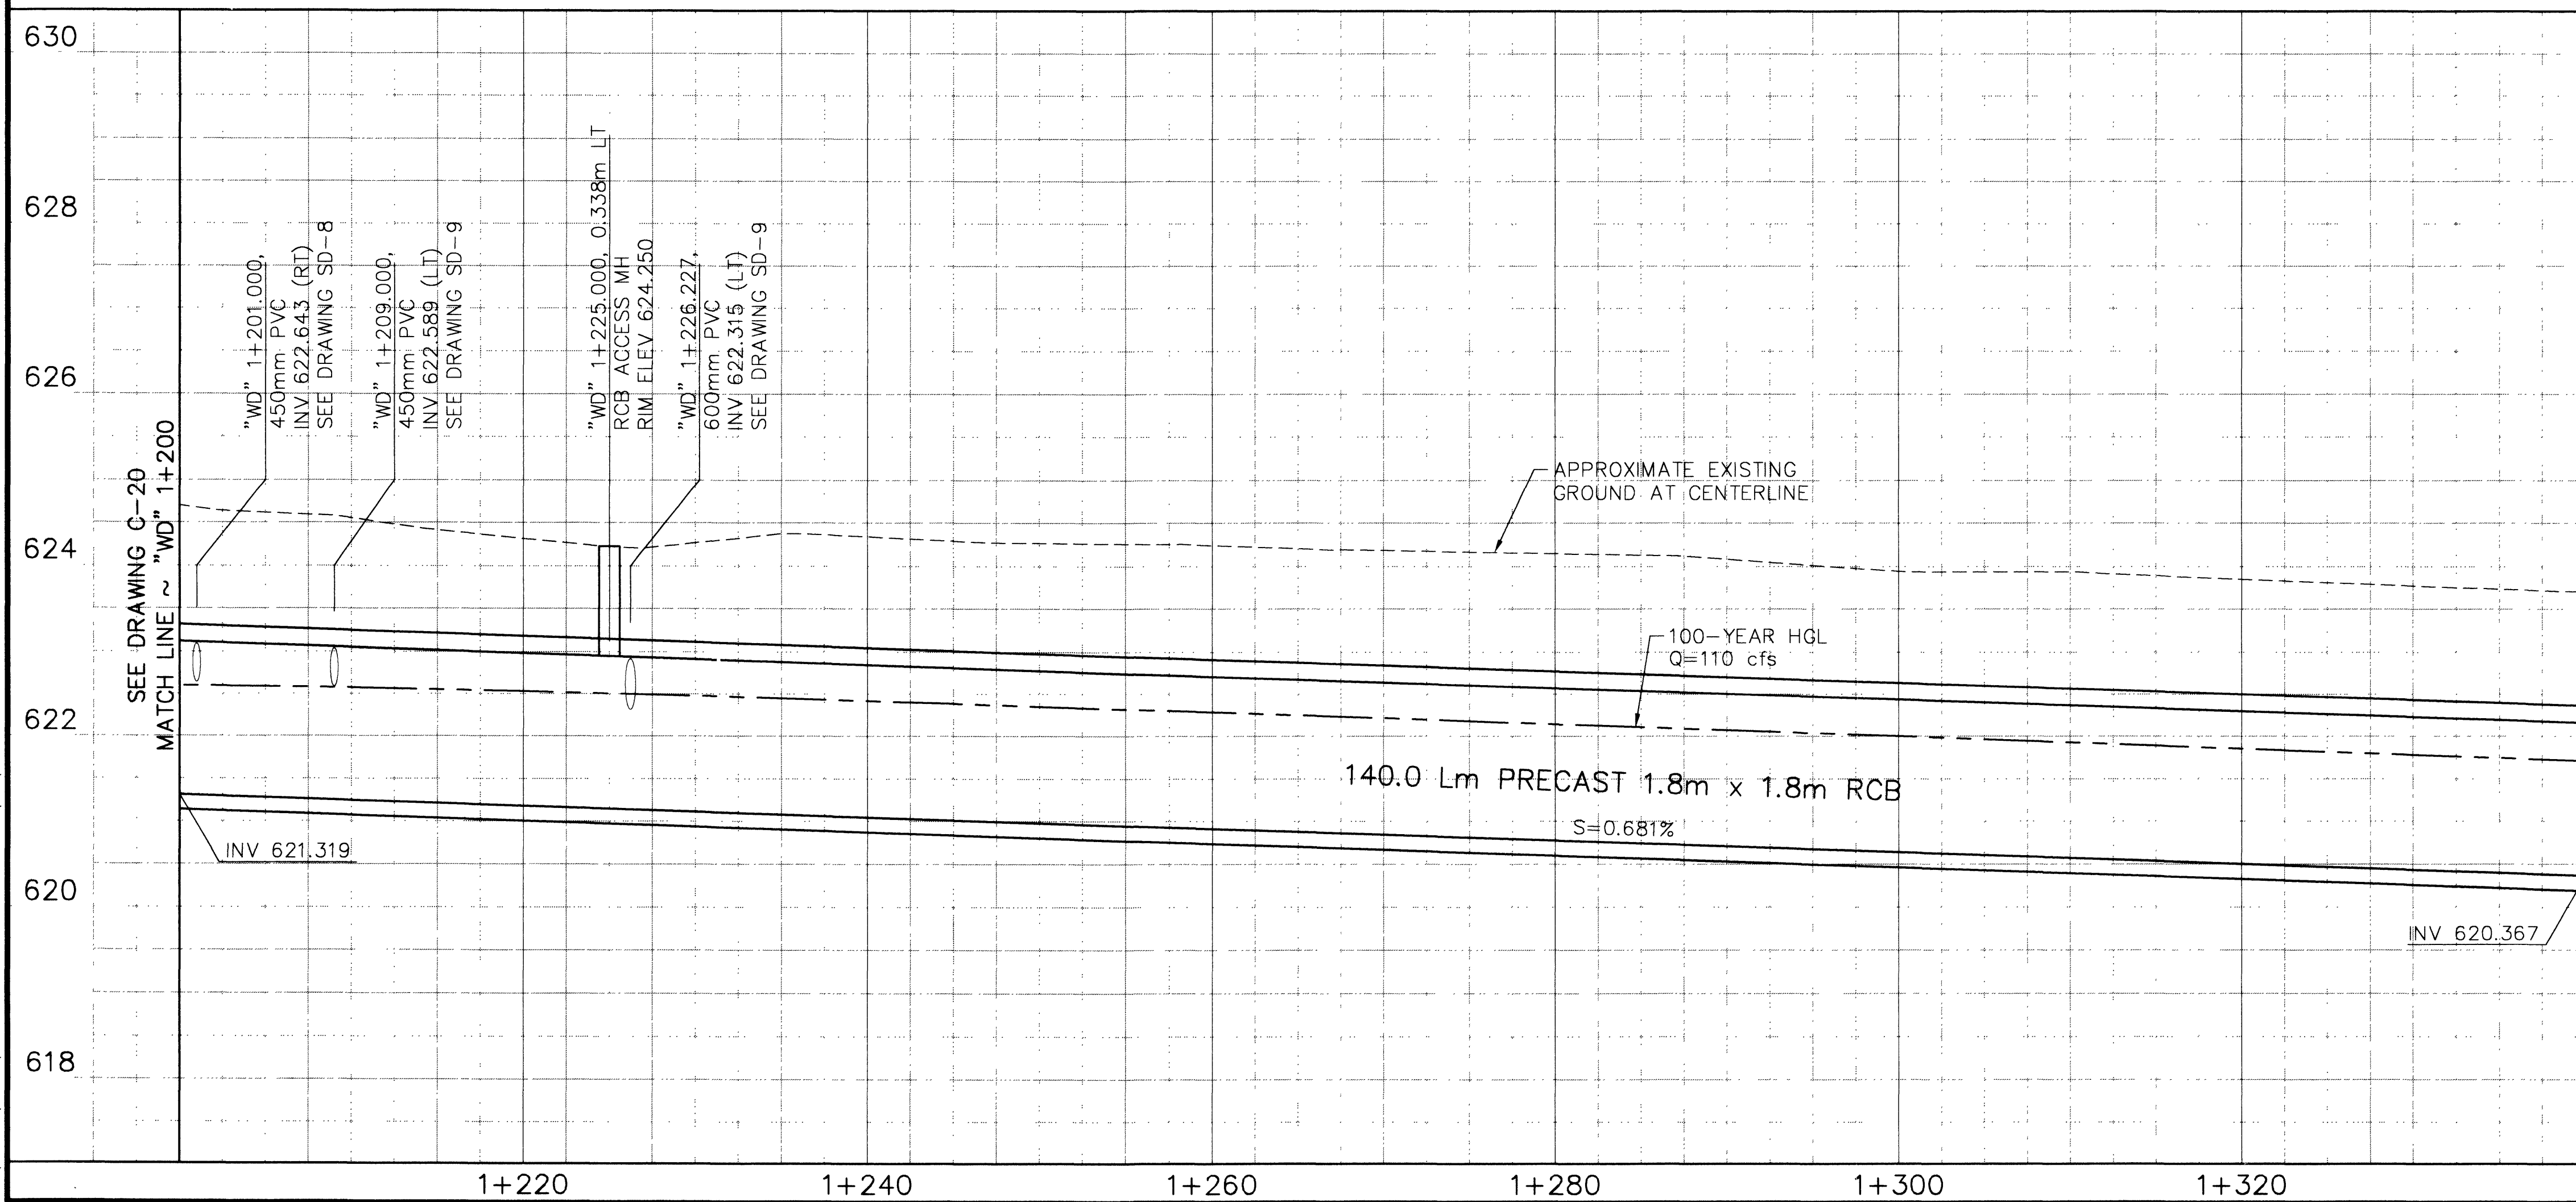


L:\31604\SHITS\C-21.DWG KOECHLEY 12/22/99 15:34

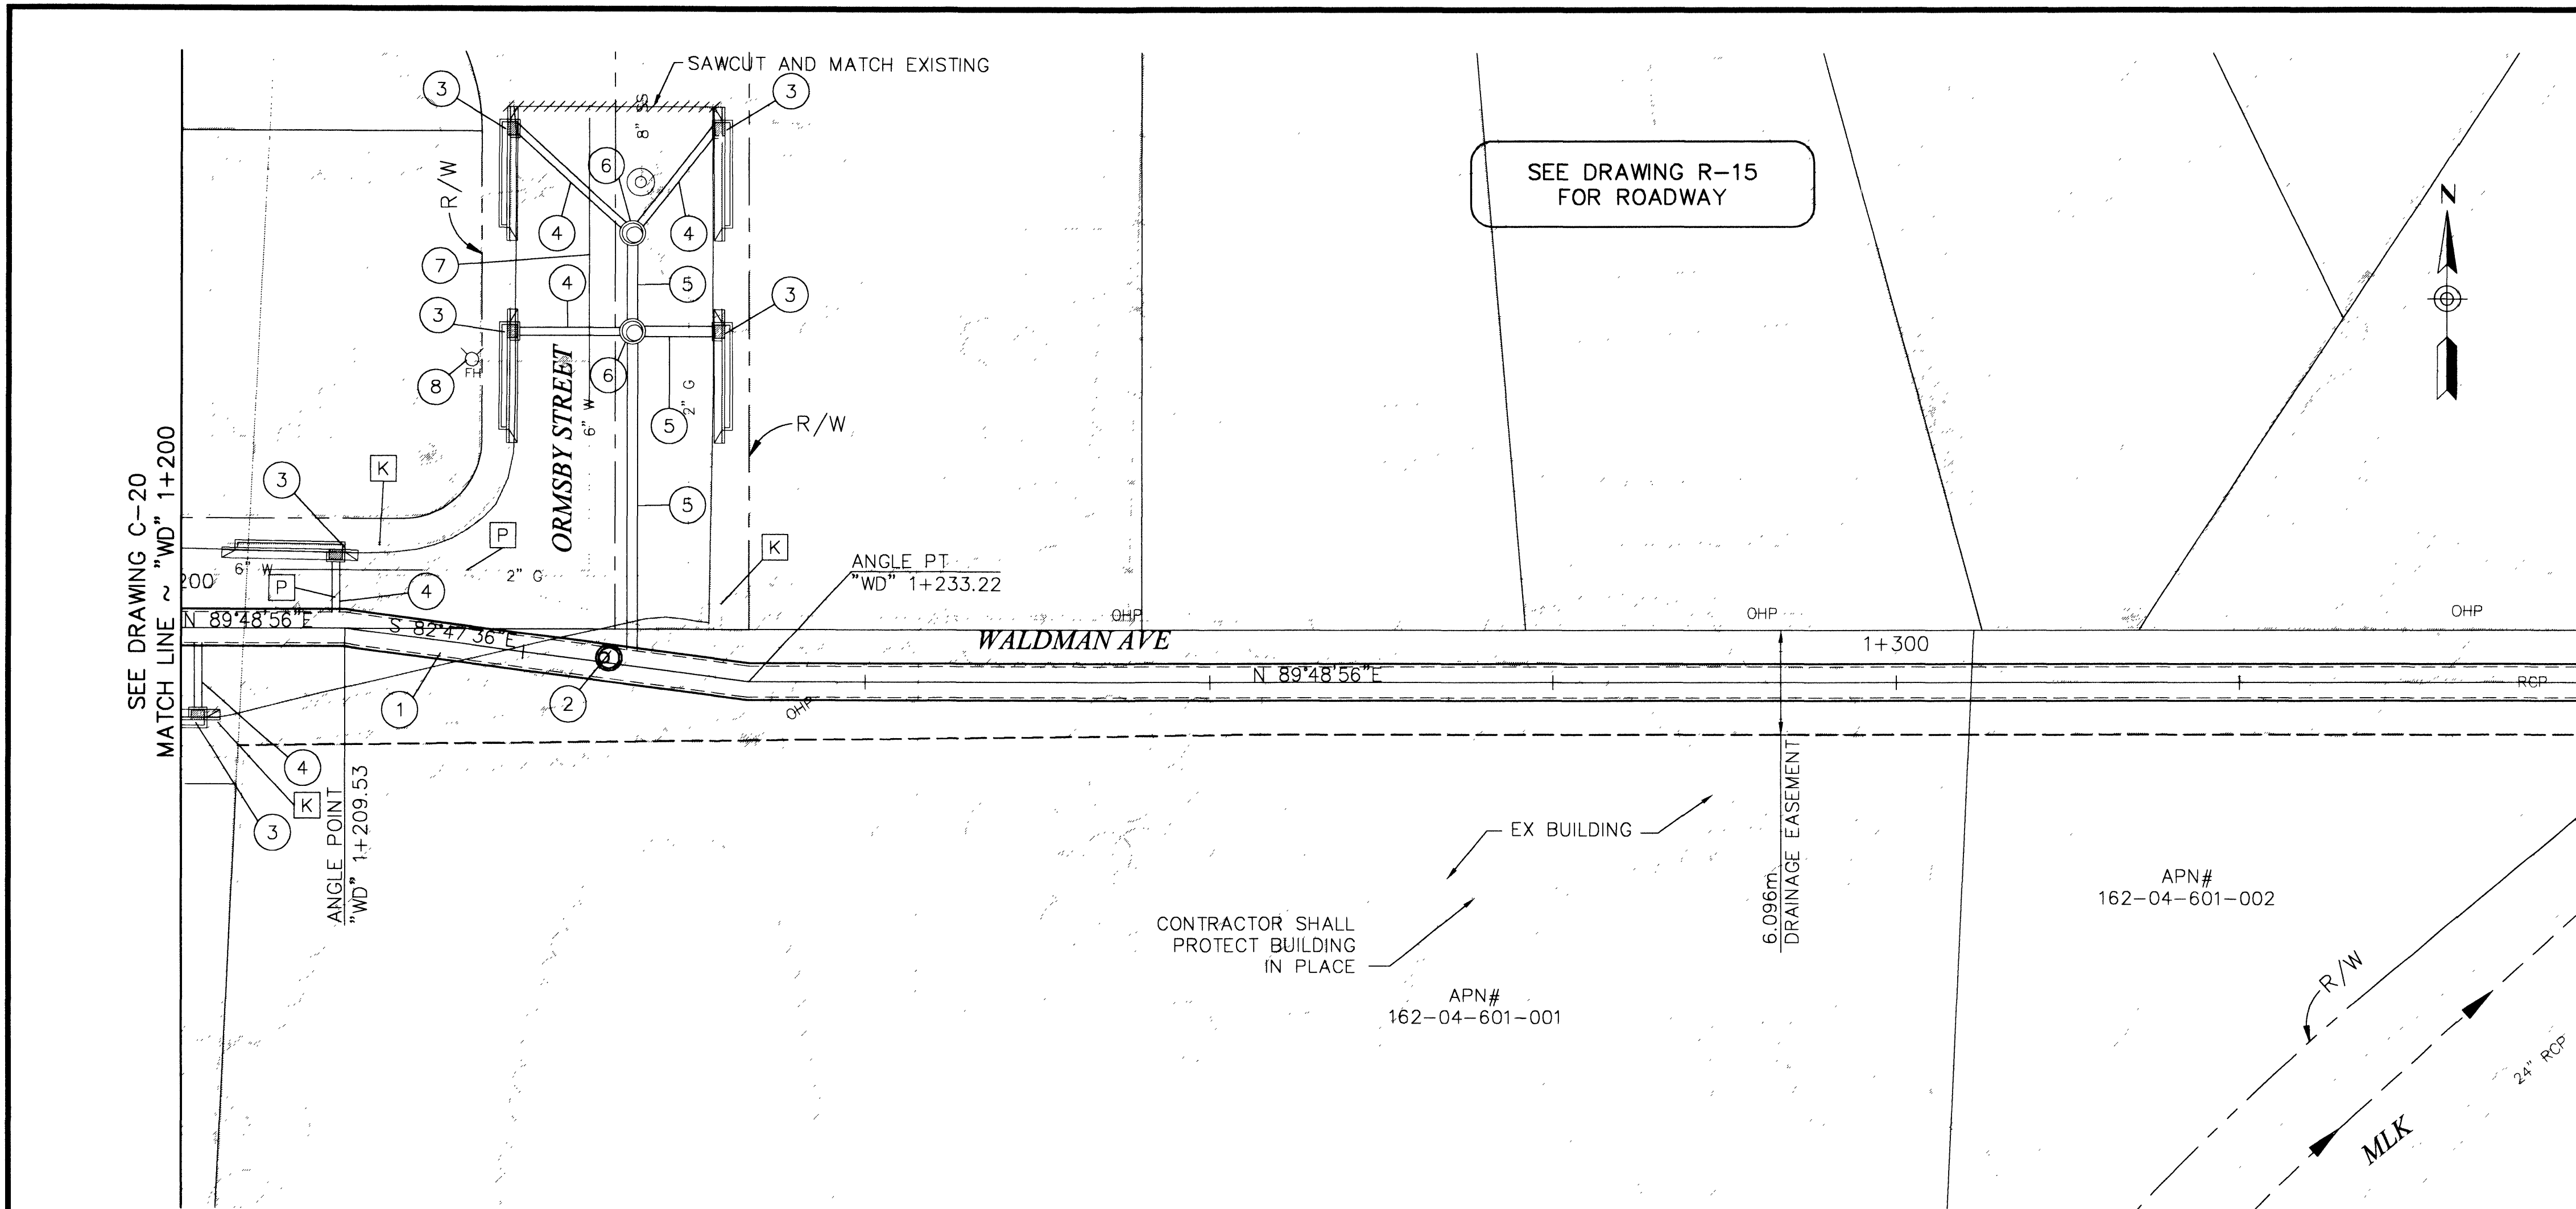


- REMOVAL ITEMS**
- [K] REMOVE DI
 - [P] REMOVE STORM DRAIN PIPE
- CONSTRUCTION ITEMS**
- "WD" 1+200.000 TO "WD" 1+340.000 CONSTRUCT 1.8m x 1.8m PRECAST RCB
 - "WD" 1+225.000, 0.520m LT CONSTRUCT RCB ACCESS MH SEE DRAWING S-19
 - "WD" 1+201.000, 5.226m RT "WD" 1+209.000, 4.381m LT "WD" 1+216.791, 18.550m LT "WD" 1+215.248, 30.460m LT "WD" 1+227.482, 32.040m LT "WD" 1+229.030, 20.140m LT CONSTRUCT 6.0m DI TYPE D MODIFIED SEE DRAWING S-7
 - "WD" 1+201.000, 5.226m RT TO "WD" 1+201.000, 0.900m RT "WD" 1+209.000, 3.381m LT TO "WD" 1+209.000, 0.900m LT "WD" 1+216.791, 18.550m LT TO "WD" 1+223.869, 19.500m LT "WD" 1+229.030, 20.140m LT TO "WD" 1+223.869, 19.500m LT "WD" 1+215.248, 30.460m LT TO "WD" 1+223.121, 25.230m LT CONSTRUCT 450mm PVC
 - "WD" 1+227.482, 32.040m LT TO "WD" 1+223.121, 25.230m LT "WD" 1+223.121, 25.230m LT TO "WD" 1+223.869, 19.500m LT "WD" 1+223.869, 19.500m LT TO "WD" 1+226.227, 0.900m LT CONSTRUCT 600mm PVC
 - "WD" 1+223.869, 19.500m LT "WD" 1+223.121, 25.230m LT CONSTRUCT TYPE I MH WITH 750mm FRAME AND COVER
 - "WD" 1+200.000, 3.350m LT "WD" 1+213.500, 3.350m LT RELOCATE 150mm WATER LINE SEE DRAWING U-40
 - "WD" 1+214.860, 16.460m LT RECONNECT EX FIRE HYDRANT PER LVWWD UDS PLATE NO. 7

APPROVED FOR CONSTRUCTION

LAS VEGAS VALLEY WATER DISTRICT DATE

Call before you Dig. 1-800-277-2800 UNDERGROUND SERVICE (USA)

Call before you Overhead 563-6111 OVERHEAD SERVICE (USA)

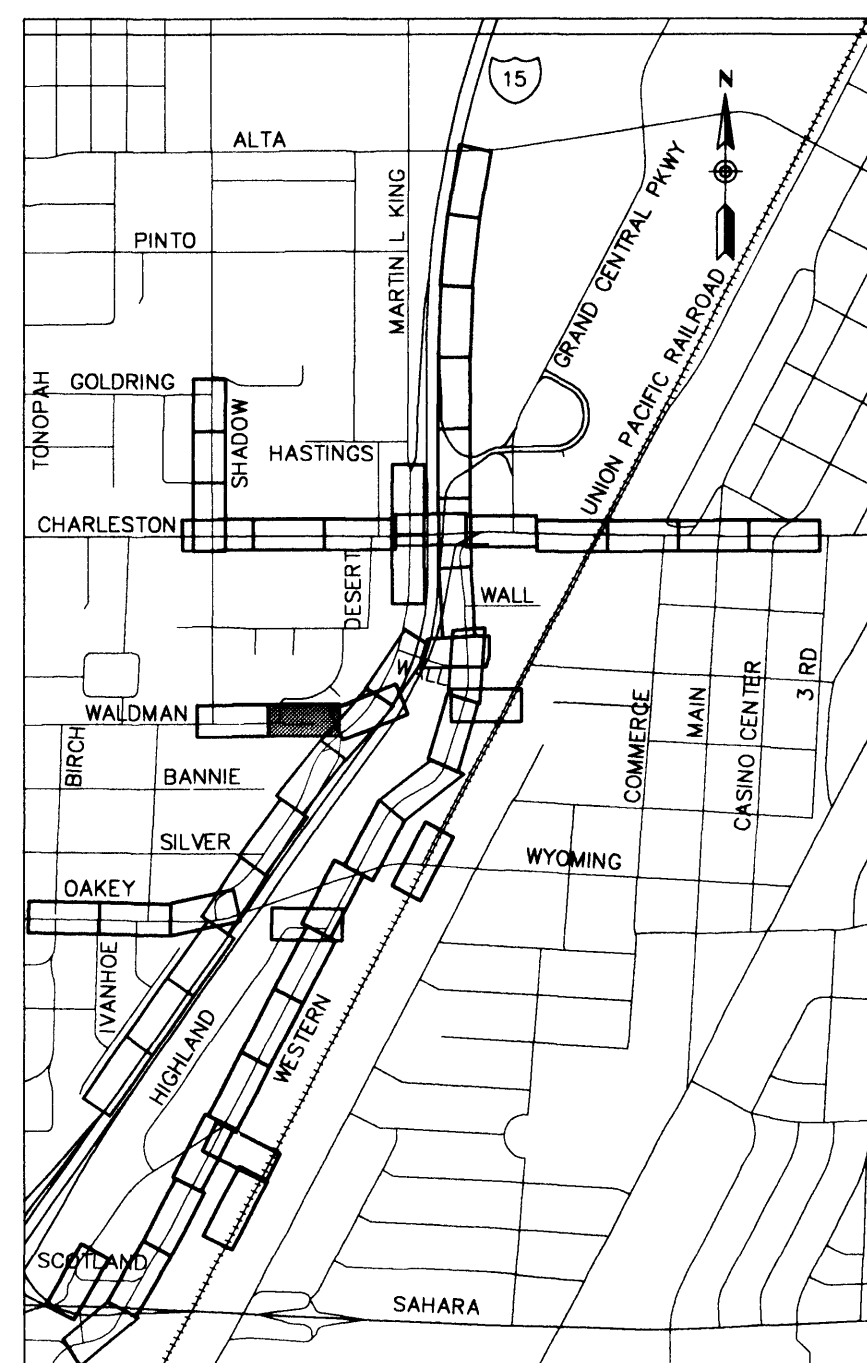

REVISIONS		PROJECT #	SCALE (V)	SCALE (H)	F.D. BK. #	DATE	DESIGN BY	DATE
		31604	1:50	1:250	N/A	DECEMBER 17, 1999	BPP	

PARSONS BRINCKERHOFF
Las Vegas, Nevada

DEPARTMENT OF PUBLIC WORKS
I-15 FREEWAY CHANNEL
CONSTRUCTION PLAN AND PROFILE
"WD" 1+200 TO "WD" 1+340

DRAWING No. **C-21**
44
241

327-V254