


L:\31604\SHITS\R-25.DWG KOECHLEY 12/22/99 16:56

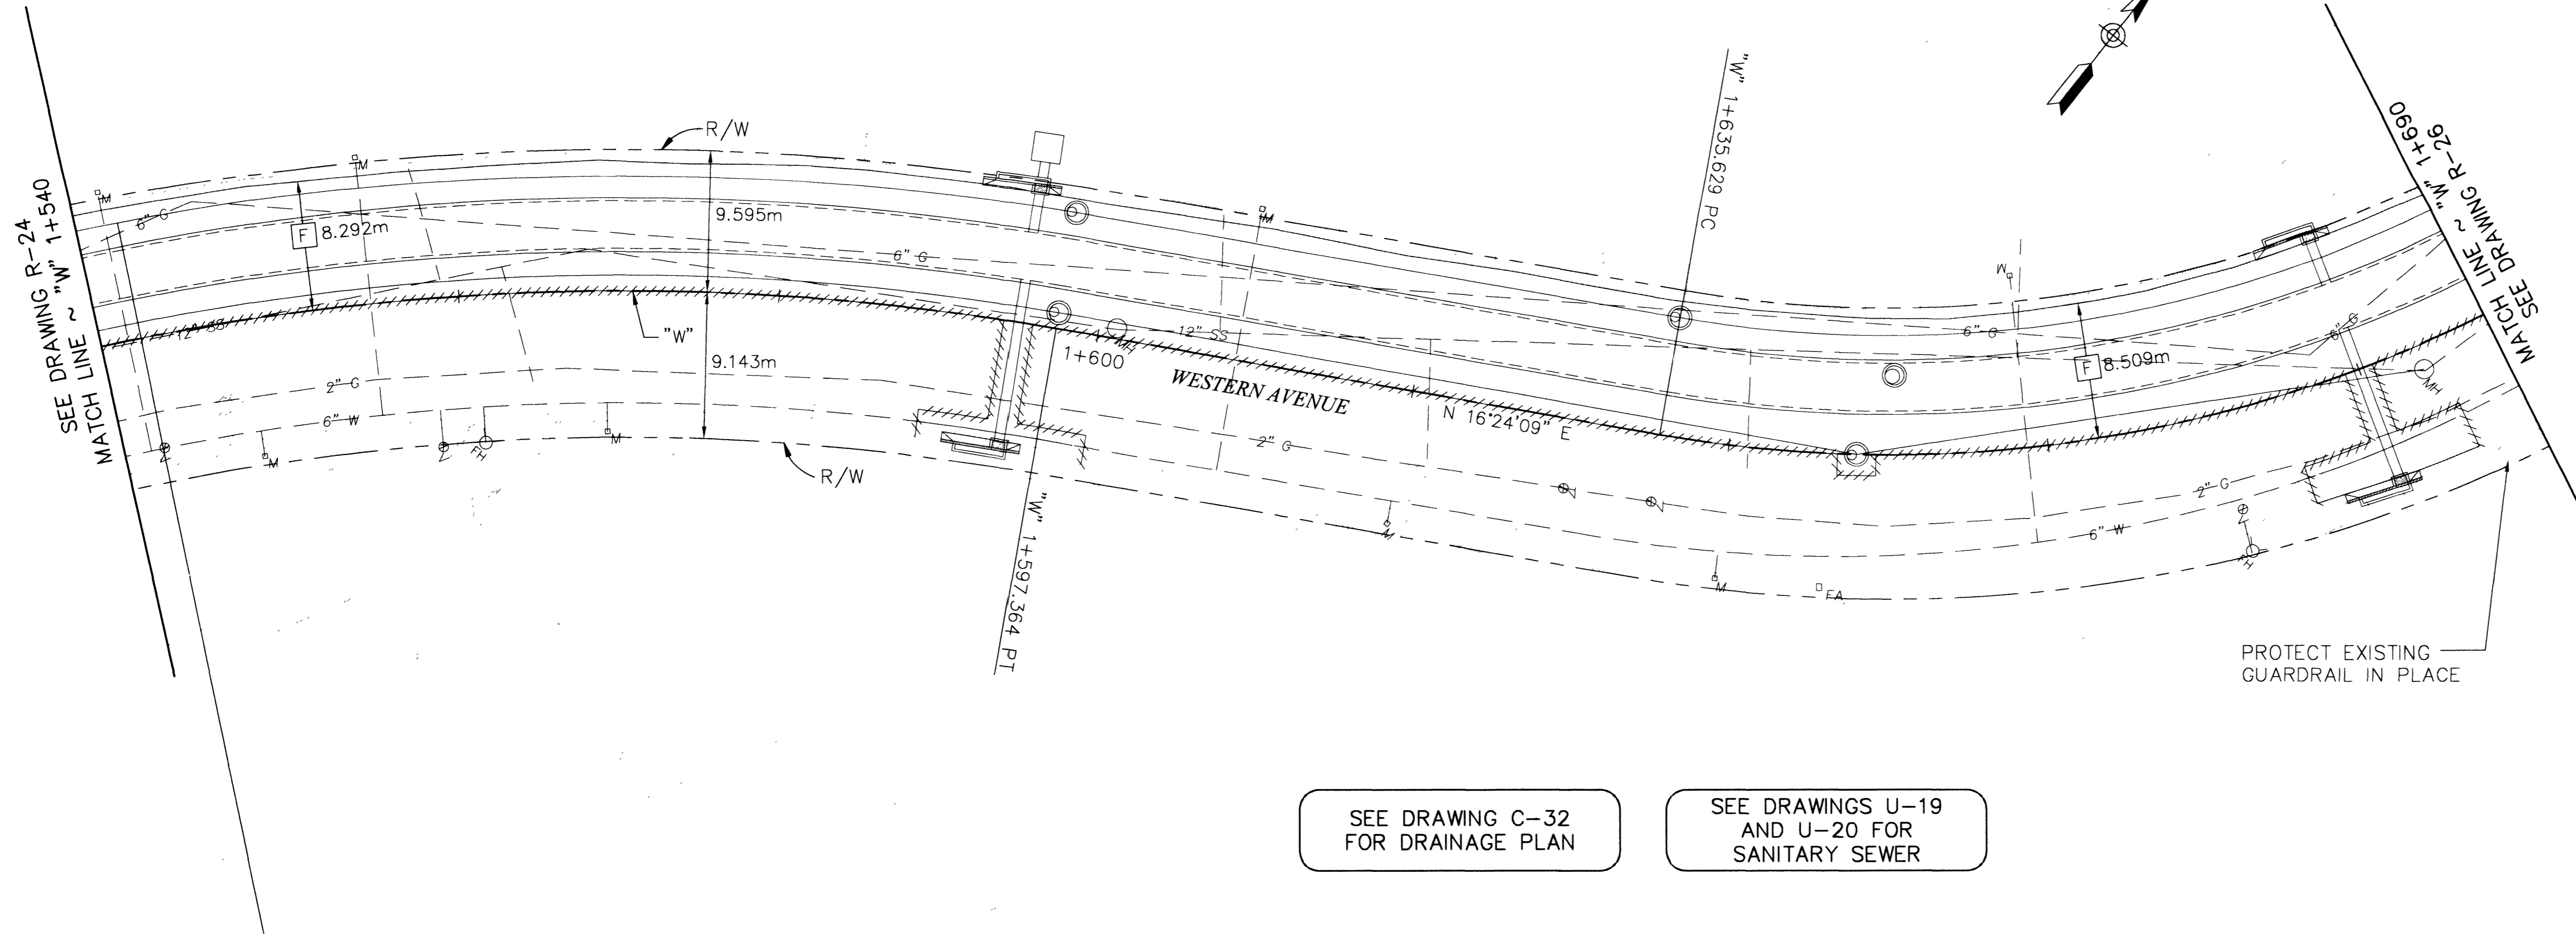


SEE DRAWING C-32 FOR DRAINAGE PLAN

SEE DRAWINGS U-19 AND U-20 FOR SANITARY SEWER

REMOVAL ITEMS
[F] REMOVE AC PAVEMENT

PROTECT EXISTING GUARDRAIL IN PLACE


<p>Call before you Dig. 1-800-277-2800 <small>UNDERGROUND SERVICE (USA)</small></p>	<p>Call before you Overhead 563-6111 <small>OVERHEAD SERVICE (USA)</small></p>
--	---

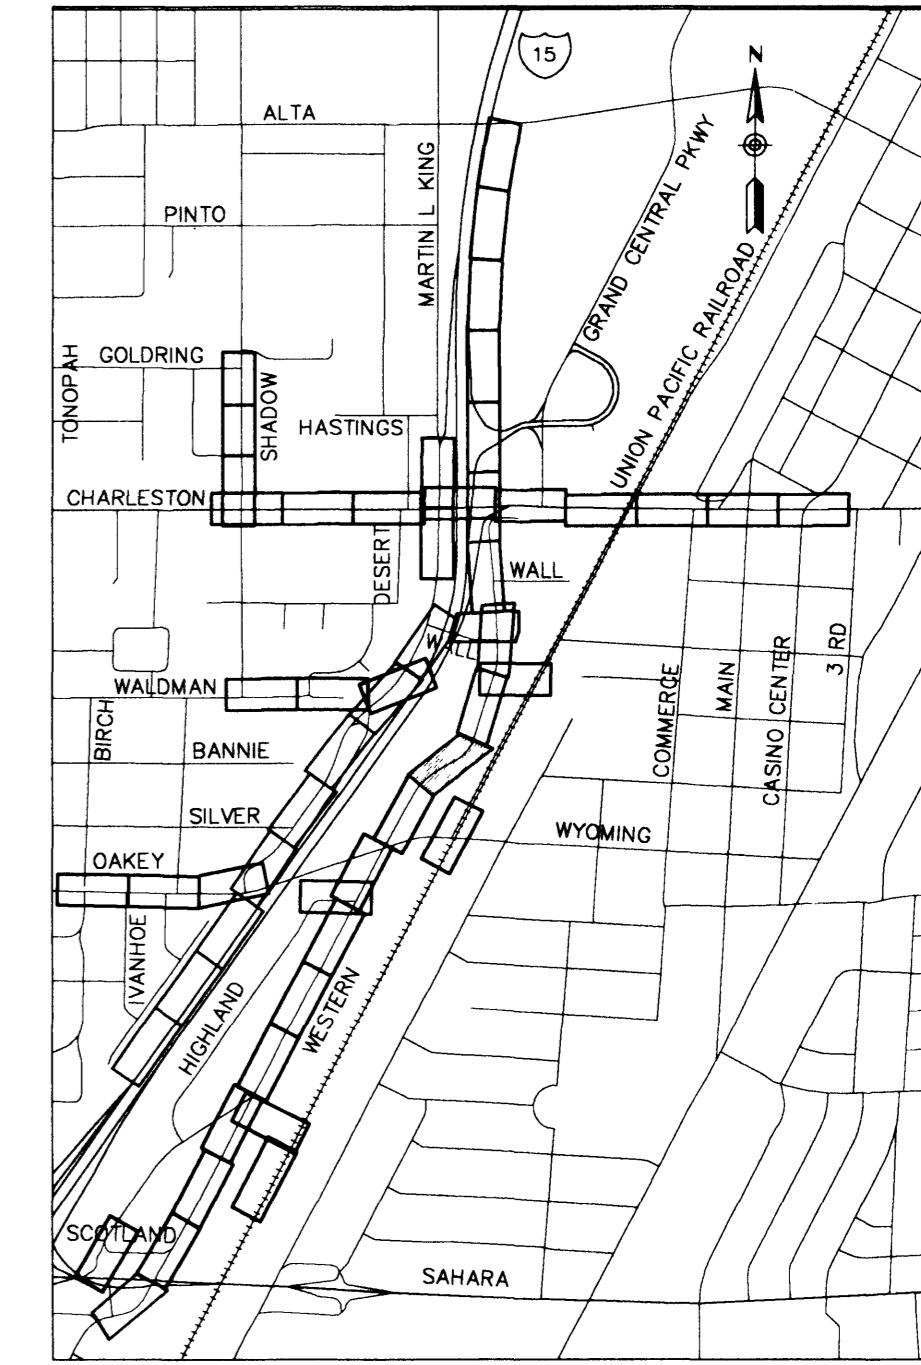

DATE	REVISIONS

PROJECT # 31604
SCALE (V) 1:50
DATE DECEMBER 17, 1999
DESIGN BY BPP


PARSONS BRINCKERHOFF
Las Vegas, Nevada

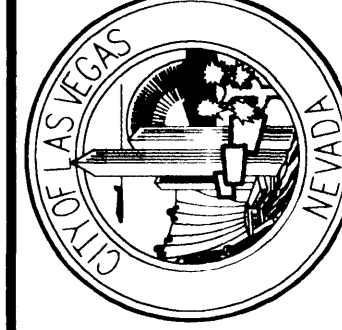

DEPARTMENT OF PUBLIC WORKS

I-15 FREEWAY CHANNEL CONSTRUCTION PLAN

"W" 1+540 TO "W" 1+690

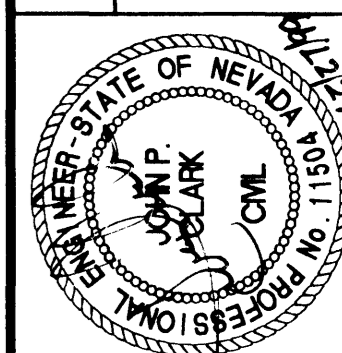

DRAWING No. 121
R-25
241

METRIC