


K:\31604\ADDEN2\SHITS\NR-27.DWG GHANEMM 05\01\01 09.43

5/16/87

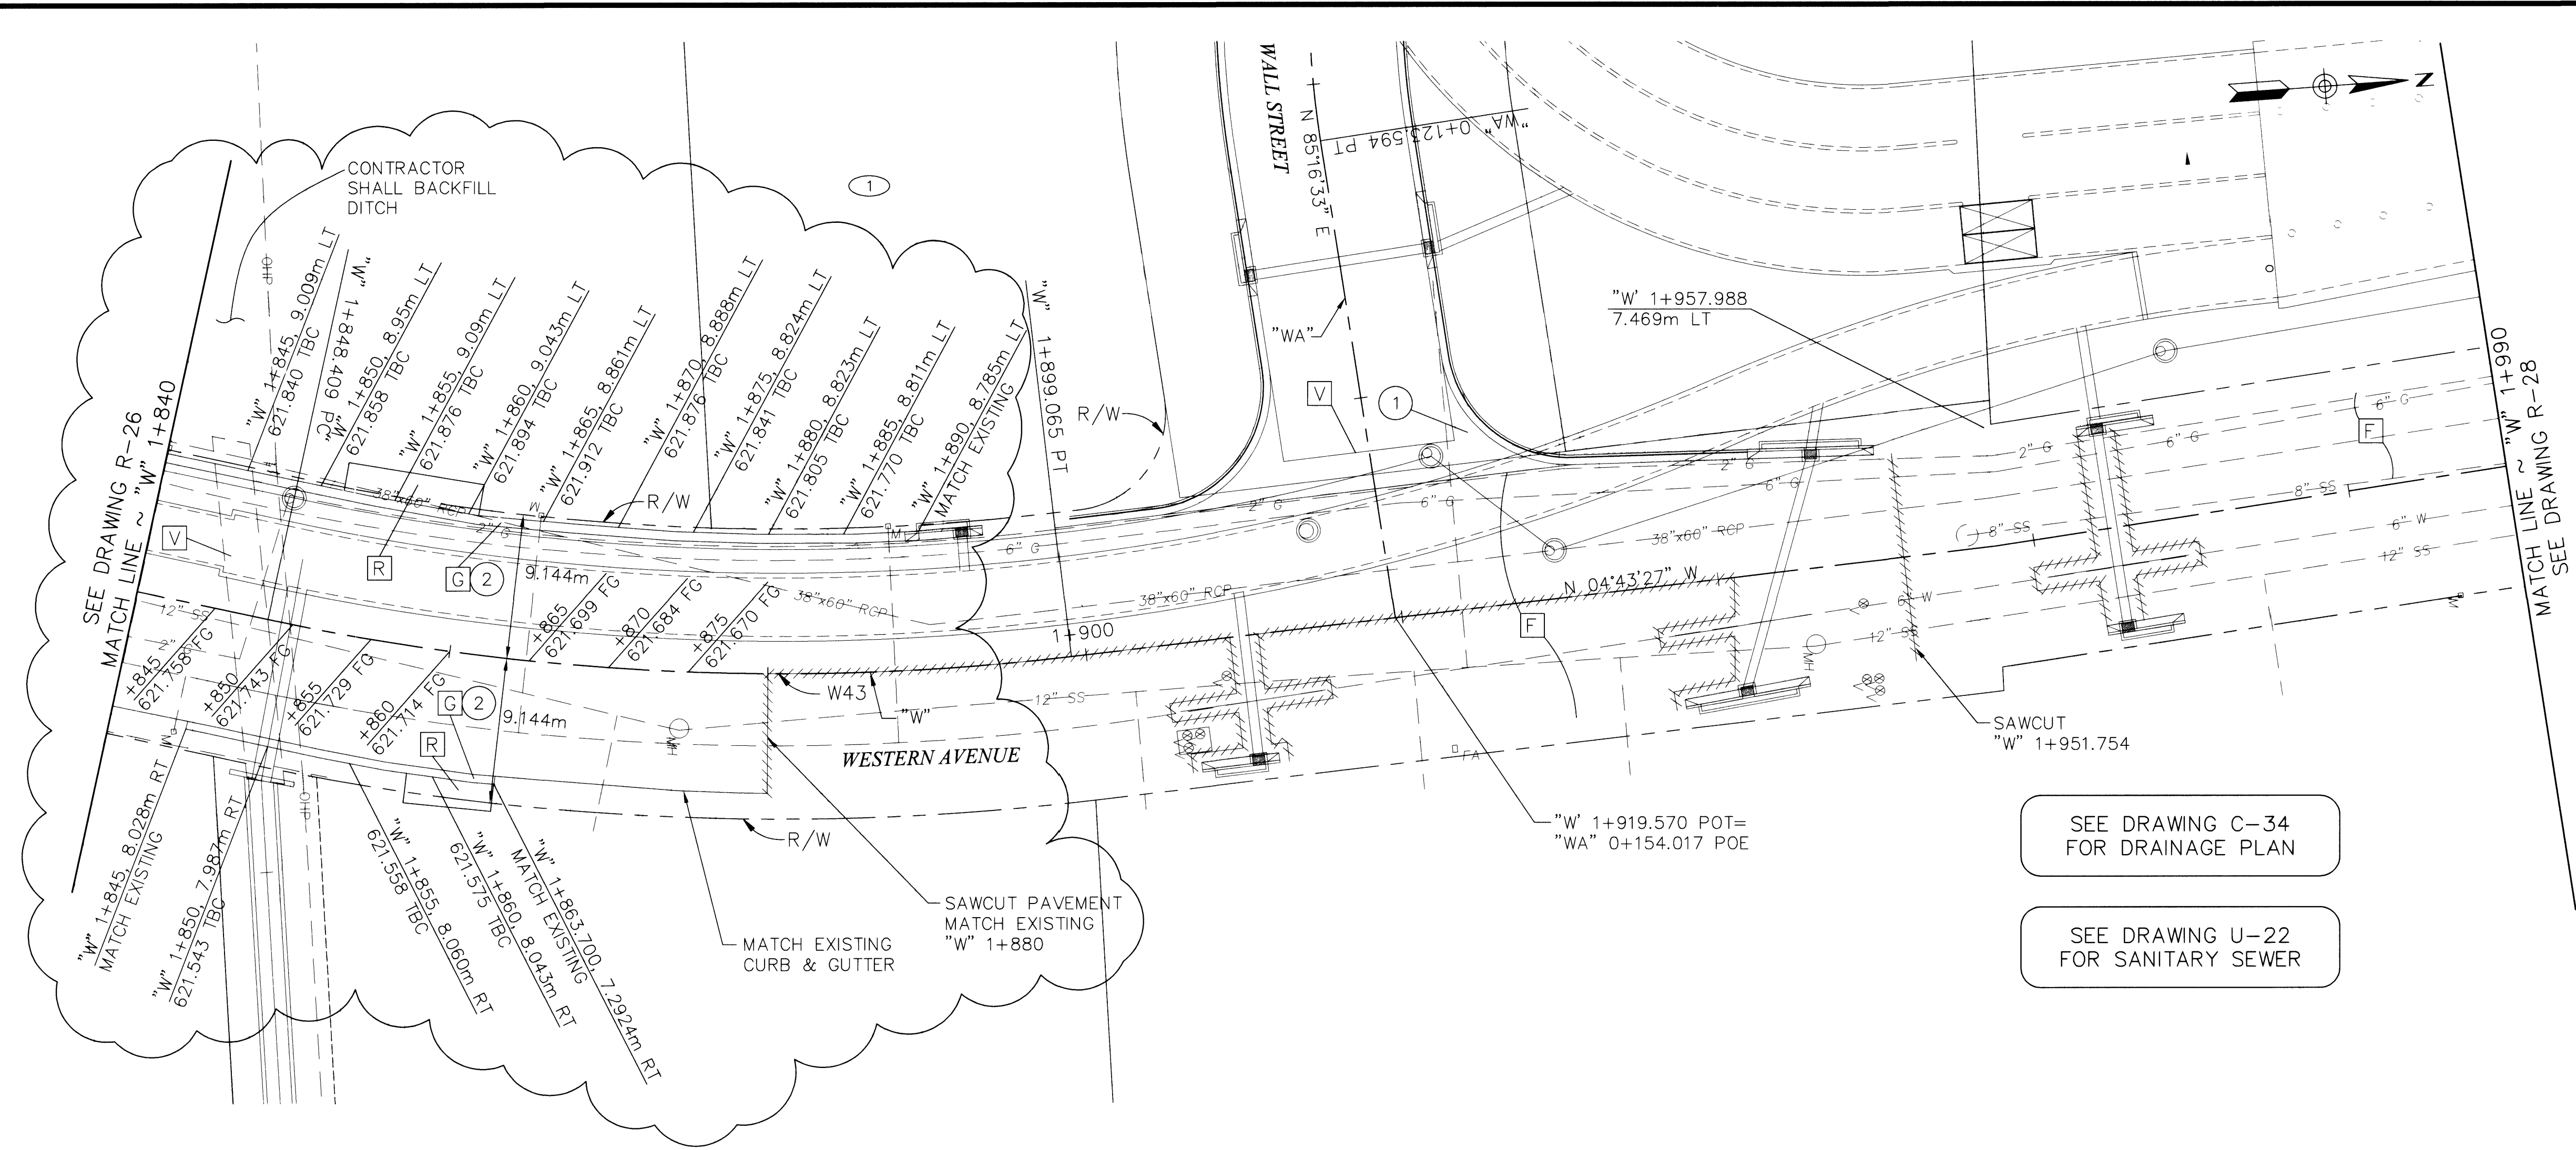

SEE DRAWING C-34
FOR DRAINAGE PLAN

SEE DRAWING U-22
FOR SANITARY SEWER

- REMOVAL ITEMS
- F REMOVE AC PAVEMENT

V REMOVE CROSS DRAIN

G REMOVE CURB AND GUTTER

R REMOVE AND RECONSTRUCT DRIVEWAY
- CONSTRUCTION ITEMS
- 1 "W" 1+905.470, 8.650m LT TO "W" 1+931.810, 8.710m LT CONSTRUCT CONCRETE CROSS DRAIN VALLEY GUTTER

2 "W" 1+845.000, 8.028m RT TO "W" 1+863.700, 7.924m RT CONSTRUCT TYPE "L" CURB AND GUTTER

"W" 1+840.000, 8.969m LT TO "W" 1+890.000, 8.785m LT

"W" CURVE DATA				
No.	Δ	R	L	T
W43	19°02'41"	152.400m	50.656m	25.564m

Call before you Dig.


1-800-277-2600

UNDERGROUND SERVICE (USA)

Call before you Overhead

563-6111

OVERHEAD SERVICE (USA)

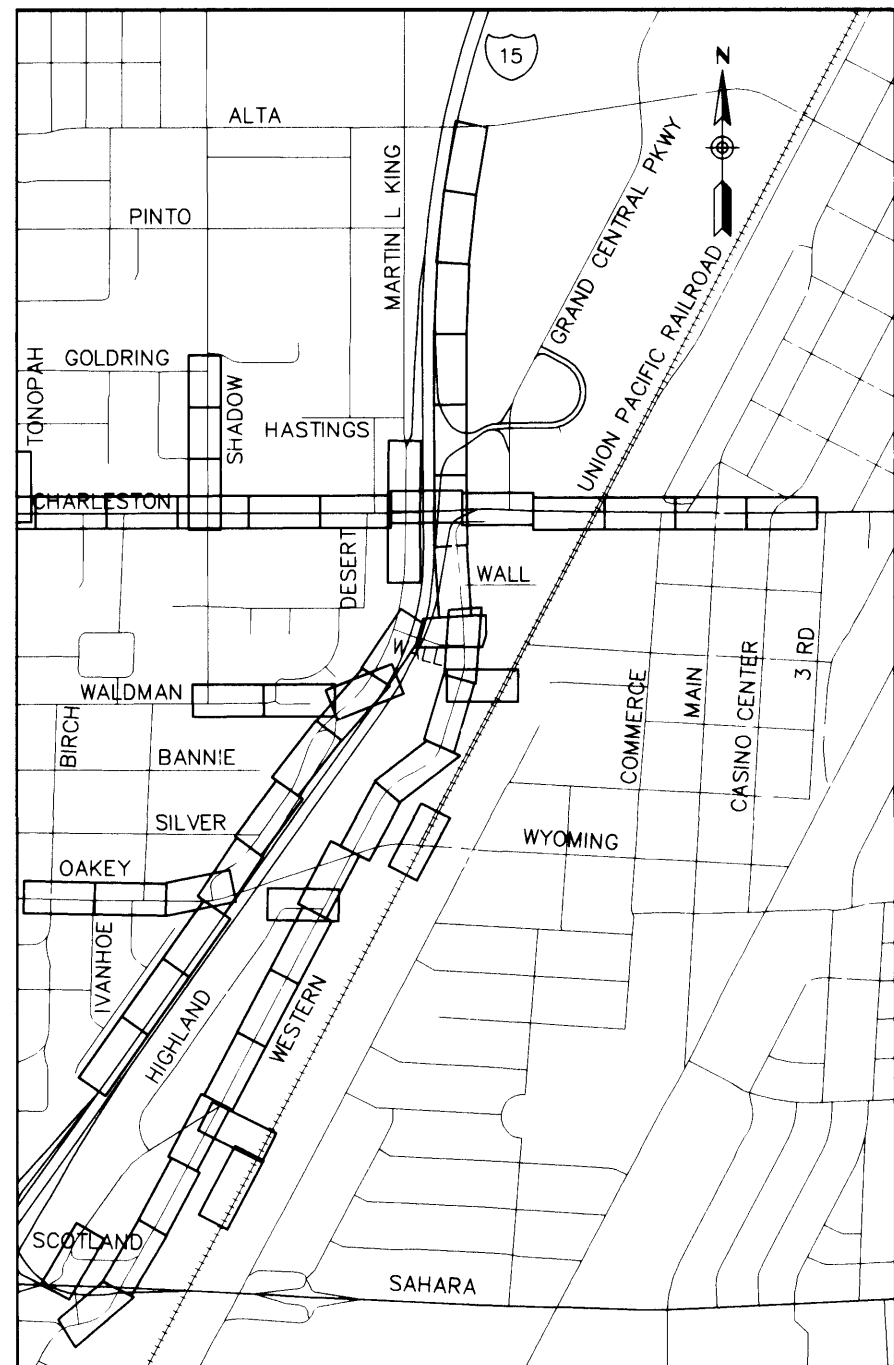

REVISIONS

DATE	REVISIONS	PROJECT #	SCALE (V)	DATE	DESIGN BY
4/27/01	REVISED WESTERN AVENUE	31604	1:50	DECEMBER 17, 1998	BPP

PARSONS BRINCKERHOFF

L2S Vegas, Nevada

CITY OF LAS VEGAS

NEVADA

DEPARTMENT OF PUBLIC WORKS

I-15 FREEWAY CHANNEL
CONSTRUCTION PLAN
"W" 1+840 TO "W" 1+990

ENGINEER STATE OF NEVADA

JOHN CLARK

CIVIL

PROFESSIONAL

DRAWING No. 123
R-27 241