


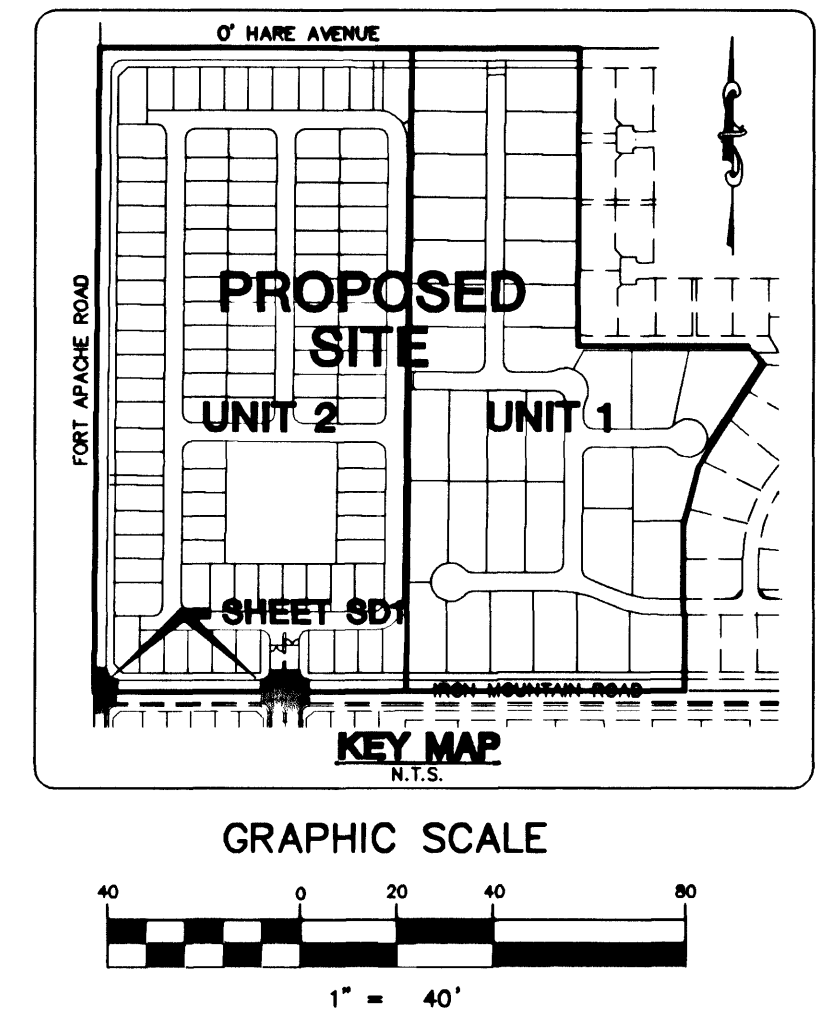

THE BASIS OF BEARINGS FOR THIS PROJECT IS GRID NORTH AS DEFINED BY THE NEVADA COORDINATE SYSTEM OF 1983 (NCS83), EAST ZONE, (2701), DETERMINED BY CLARK COUNTY GIS CONTROL POINTS 802,803, 804, & 805, AS SHOWN ON A RECORD OF SURVEY ON FILE IN THE CLARK COUNTY, NEVADA, RECORDER'S OFFICE, IN BOOK 88 OF SURVEYS, AT PAGE 57.

PROJECT DATUM: NORTH AMERICAN VERTICAL DATUM
OF 1988 (NAVD88)
CLARK COUNTY BENCHMARK USC&GS V-169
NAVD88 ELEVATION: 791.316 METERS (2596.17 FEET)
USC&GS BRASS CAP 400 FT. SOUTH OF LOG CABIN WAY
AND 100 FT. EAST OF EL CAPITAN WAY JUST EAST OF
OF A BARBED WIRE FENCE.


CONTRACTOR SHALL VERIFY HORIZONTAL AND VERTICAL LOCATION OF EXISTING UTILITIES AND NOTIFY THE DESIGN ENGINEER IMMEDIATELY OF ANY DISCREPANCIES PRIOR TO CONSTRUCTION.



LAS VEGAS VALLEY WATER DISTRICT

Avoid overhead power
line contact. It's costly.

Call
before you
Overhead
1-702-593-6111

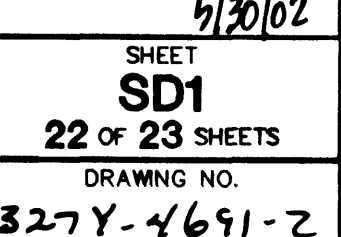

**STORM DRAIN
PLAN AND PROFILE
FORT APACHE ROAD**

DRAWN BY: dtb/jmd	SEPT. 2001
	DESIGNED BY: BR/dtb
	SEPT. 2001
CHECKED BY: CRG/dp	SEPT. 2001
PROJECT NO: 5463-4	SCALE: 1"=40' HORIZ. 1"=4' VERT.

H:\5463\UNIT4\5463SD02.dwg (BR-SD1)