



NOTES


- ① CONNECT TO CATV SYSTEM.
- ② TO/FROM VIDEO SCALAR/DSP PROCESSOR.
- ③ FROM CATV ACCESS POINT.
- ④ TO TV WALL PLATE (SEE FLOOR PLANS) DRAWINGS TA2.11 AND TA2.16.

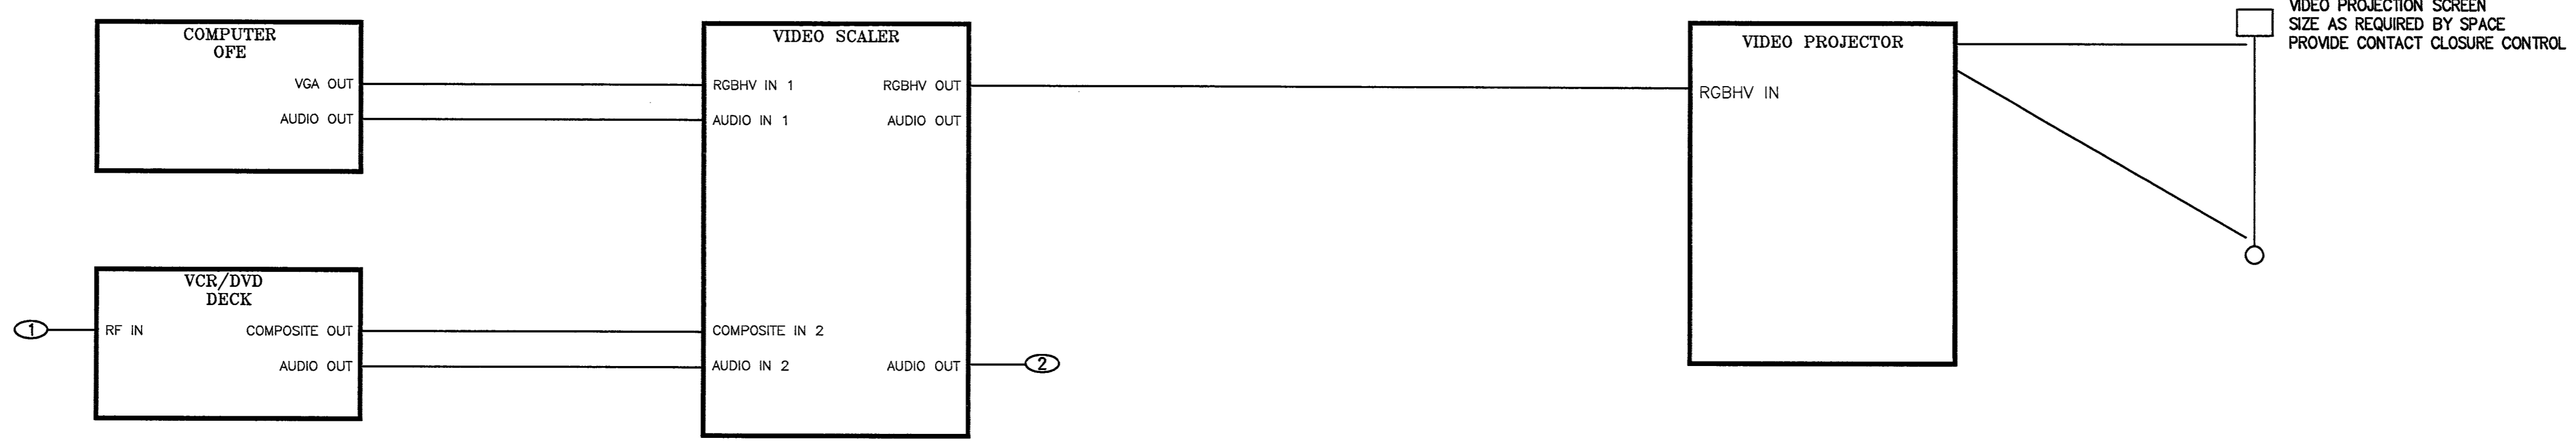


CONFERENCE ROOM TYPICAL VIDEO A
SCALE: NO SCALE TA0.03

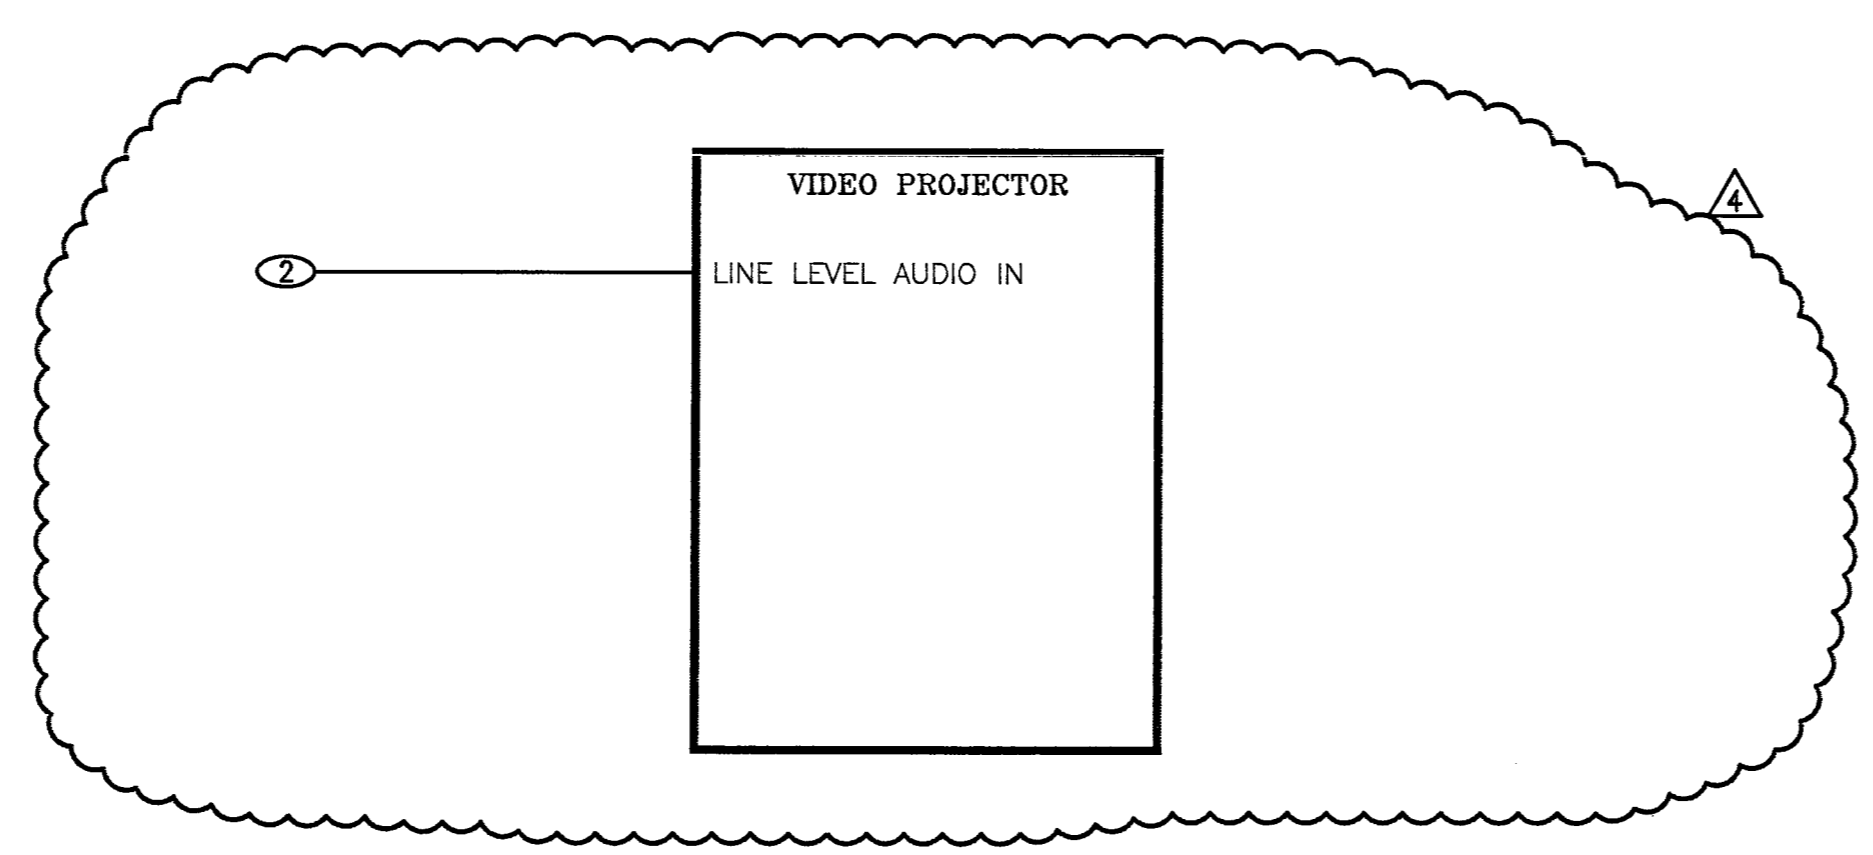

CONFERENCE ROOM TYPICAL AUDIO B
SCALE: NO SCALE TA0.03

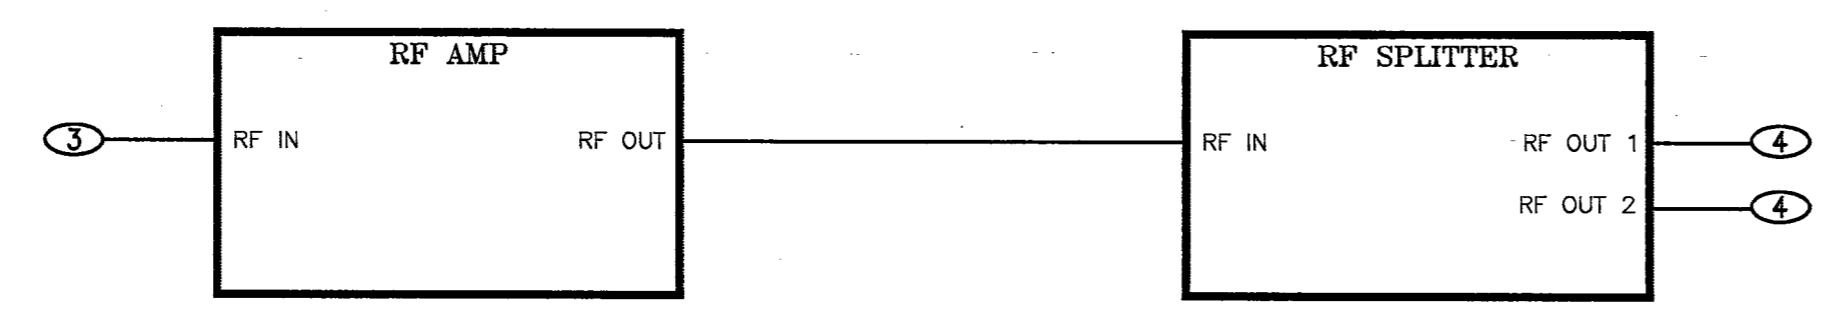

AUDITORIUM & CONFERENCE ROOM CATV C
SCALE: NO SCALE TA0.03

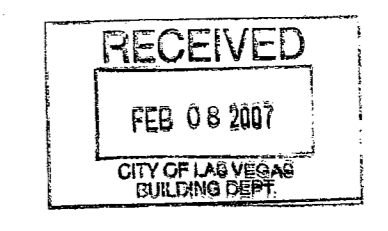

KGA
ARCHITECTURE
INTERNATIONAL
AN ASSOCIATION
4400 SOUTH FLORISS AVENUE
LAS VEGAS, NEVADA 89101
PHONE: 702-253-8500
TELEPHONE: 702-362-6800
FACSIMILE: 702-362-2940

HERITAGE ARCHITECTURE & PLANNING
PHONE: 88-229-2888

CIVIL -
VTM
NEVADA
PHONE: 702-873-7300

STRUCTURAL -
BARKER DROTAR ASSOCIATES
STRUCTURAL ENGINEERS
PHONE: 702-253-8500

MECHANICAL - PLUMBING - ELECTRICAL -
USE SAFETY - ACCIDENTAL - GENERAL LIGHTING
JBA CONSULTING ENGINEERS
PHONE: 702-261-9200

STAGE LIGHTING & DESIGN -
CD-M LIGHTING DESIGN GROUP
PHONE: 88-229-2222


LANDSCAPE -
JWZUNINO & ASSOCIATES
PHONE: 702-253-0900

COST ESTIMATING -
ROGER HUNT
LEVETT & BAILEY
702-257-4888

ADA ACCESSIBILITY
ENGELSMAN AND ASSOCIATES
PHONE: 252-324-6442



**FIFTH STREET SCHOOL
REHABILITATION
BUILDING DEPARTMENT SUBMITTAL**

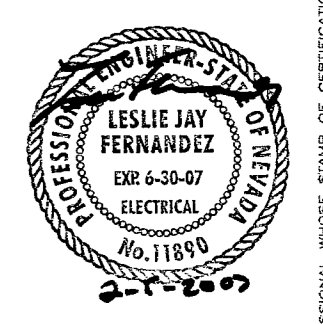

OWNER: CITY OF LAS VEGAS
DEPARTMENT OF PUBLIC WORKS
ARCHITECTURAL SERVICES
4400 EAST STEWART AVENUE
LAS VEGAS, NEVADA 89101
PHONE: (702) 253-8500
FAX: (702) 384-4846
TDD: (702) 386-9108

FILE NO:
AV SINGLE LINE DIAGRAM
DATE:
12/12/2006
SCALE:
N.T.S.
SHEET NO:
513-65E

SHEET NO:
TA0.03

113412