


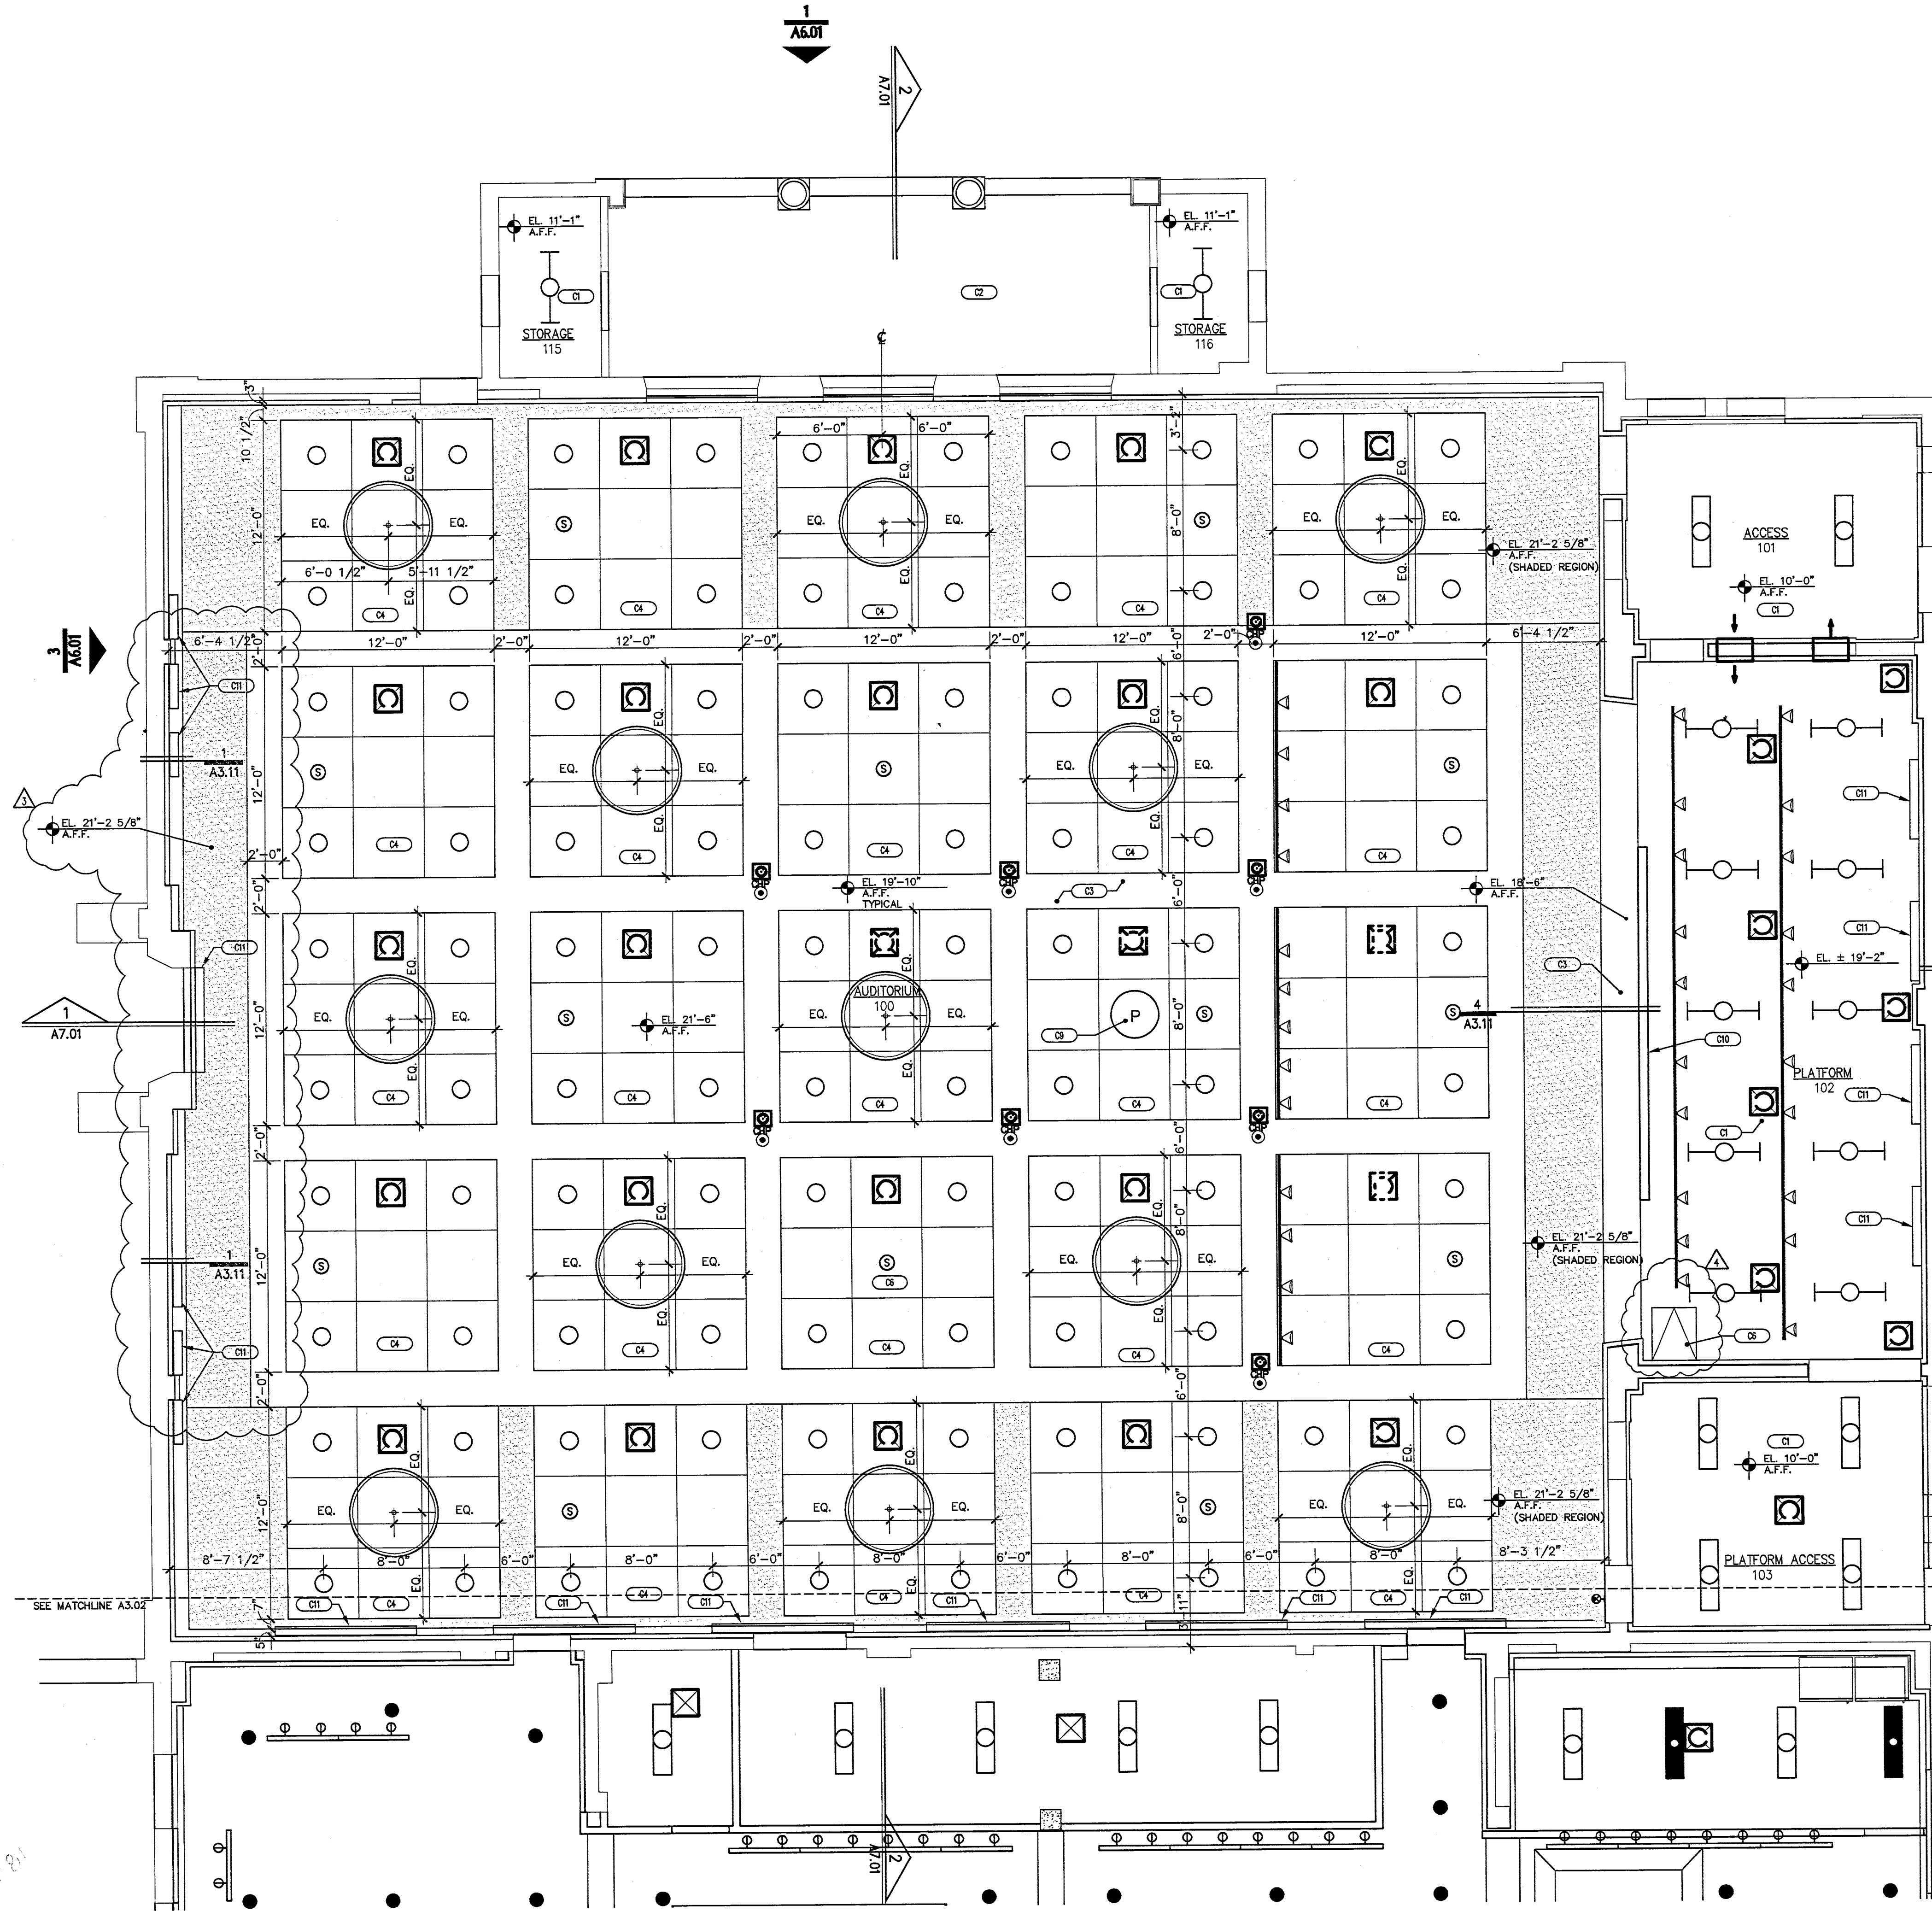

ENLARGED AUDITORIUM REFLECTED CEILING PLAN

SCALE: 1/4" = 1'-0"

723-FUR.dwg

CEILING NOTES

KEY	DESCRIPTION
C1.	GYPSON BOARD CEILING
C2.	EXPOSED TO STRUCTURE ABOVE
C3.	GYPSON BOARD SOFFIT
C4.	4'-0" X 4'-0" ACOUSTICAL PANEL SYSTEM
C5.	EXISTING SKYLIGHTS TO BE RESTORED
C6.	SEE DETAIL 5/A3.11
C7.	AREA FOR NEW ACCESS HATCH. SEE DETAIL 10/A3.01
C8.	COORDINATE WITH STRUCTURAL DRAWINGS
C9.	PENDANT LIGHTS - REFER TO ELECTRICAL DRAWINGS
C10.	MOUNTED WALL LIGHT, PROJECTOR
C11.	SOFFIT-MOUNTED VIEWING SCREEN, MECHO-SHADE
C12.	NOT USED
C13.	NEW LIGHT FIXTURE IN ATTIC - COORDINATE WITH ELECTRICAL DRAWINGS
C14.	TRACK LIGHTING - N.I.C.

CEILING LEGEND

- COMPACT FLUORESCENT LIGHT FIXTURE
- FLUORESCENT LIGHT FIXTURE
- ▭ FLUORESCENT LIGHT FIXTURE SURFACE
- EMERGENCY LIGHT FIXTURE
- TRACK LIGHTING SYSTEM
- ⊕ FLUORESCENT LIGHT FIXTURE
- ⊙ EXIT SIGN
- ⊙ PENDANT LIGHT
- ⊙ SUPPLY AIR REGISTER
- ⊙ RETURN AIR GRILLE
- ⊙ EXHAUST FAN
- ⊙ SPEAKER
- ⊙ FIRE ALARM CHIME
- ⊙ SMOKE DETECTOR
- ⊙ PROTECTOR

GENERAL NOTES

- ALL LIGHTING FIXTURES AND CEILINGS THROUGHOUT NEW GYPSON BOARD CEILING SHALL BE ATTACHED TO UNDERSIDE OF WOOD JOISTS. VERIFY CEILING HEIGHTS IN FIELD.
- REFER TO MECHANICAL AND ELECTRICAL DRAWINGS FOR TYPE OF FIXTURE OR DIFFUSER.
- INSTALL PROJECTOR PER MANUFACTURER RECOMMENDATIONS.

BUILDING MAP

RECEIVED
FEB 08 2007
CITY OF LAS VEGAS
BUILDING DEPT.

PLANS APPROVED
ARCHITECTURAL
Building & Survey Dept.
City of Las Vegas, Nevada
JCF FEB 09 2007

Does Not Include Electrical, Plumbing, Mechanical, Structural or Civil Site Improvements. Make No Change Without Approval. Plan is Not a Permit to Violate Any Ordinance.

OWNER: CITY OF LAS VEGAS
DEPARTMENT OF PUBLIC WORKS
ARCHITECTURAL SERVICES

400 EAST STEWART AVENUE
LAS VEGAS, NEVADA 89101
PHONE: (702) 228-6535
FAX: (702) 384-8846
TDD: (702) 384-9408

PROJECT: AUDITORIUM RCP
DATE: 12/12/2006
SCALE: 1/4" = 1'-0"
CLV DWS NO: 513-65E
SHEET NO: A3.01

REVISIONS:

NO.	DESCRIPTION
1	CLV COMMENTS
2	OWNER COMMENTS

REVISED 02/03