


- NOTES**
- 1 EXIST. TOILET ROOM SHALL REMAIN.
  - 2 2" W. DN., 1/2" V. UP, 1/2" H. & C.W. DN. TEE 1/2" C.W. TO REF.
  - 3 PROVIDE P.O.C. FOR NEW PLUMBING WITH EXIST. IN EXIST. PLUMBING CHASE.
  - 4 REMOVE EXIST. C.W. STUB-OUT & CAP IN WALL. PATCH WALL TO MATCH SURROUNDING.
  - 5 P.O.C. NEW 2" W. WITH EXIST. 2" STUB-OUT.
  - 6 REMOVE EXIST. WASTE, VENT & C.W. SERVING REMOVED WATER COOLER. PATCH WALL TO MATCH SURROUNDING.

**ENLARGED FLOOR PLAN-CULTURAL AFFAIRS**  
 SCALE : 1/4" = 1'-0"

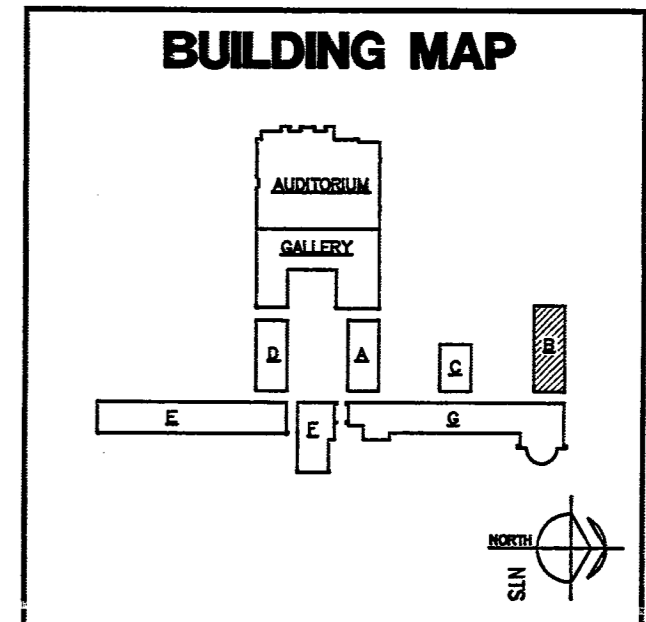

CLV COMMENTS  
 JANUARY 4, 2007

**KGA**  
 CONSULTANTS

488 SOUTH POLARIS AVENUE  
 LAS VEGAS, NEVADA 89103  
 WWW.KGACONSULTANTS.COM  
 TELEPHONE 702.392.4990  
 FACSIMILE 702.392.2940

HISTORICAL  
**HERITAGE ARCHITECTURE & PLANNING**  
 488 SOUTH POLARIS AVENUE  
 LAS VEGAS, NEVADA 89103  
 PHONE: 702-392-7888

CIVIL -  
**VTM**  
 NEVADA  
 PHONE: 702-473-7200

STRUCTURAL -  
**BARKER DROTTER ASSOCIATES**  
 STRUCTURAL ENGINEERS  
 PHONE: 702-392-8800


MECHANICAL - PLUMBING - ELECTRICAL -  
 LIFE SAFETY - ACoustICAL - GENERAL LIGHTING  
**SEA CONSULTING ENGINEERS**  
 PHONE: 702-392-6000

STAGE LIGHTING & DESIGN -  
**COM LIGHTING DESIGN GROUP**  
 PHONE: 88-29-2323

LANDSCAPE -  
**JWZUNINO & ASSOCIATES**  
 PHONE: 702-262-2900

GRAPHIC DESIGNING -  
**RODER HUNT**  
**LEVETT & BAILEY**  
 702-277-6888

ADA ACCESSIBILITY  
**ENGELSMAN AND ASSOCIATES**  
 PHONE: 366-544-6442

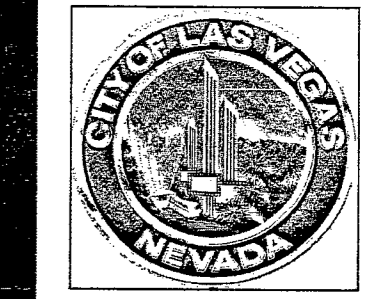


**FIFTH STREET SCHOOL  
 REHABILITATION  
 BUILDING DEPARTMENT SUBMITTAL**

REVISED  
 2-27-07



PLANS APPROVED  
 PLUMBING/MECHANICAL  
 REVISIONS & DESIGN DEPT.  
 City of Las Vegas Nevada

RECEIVED  
 JAN 05 2007  
 City of Las Vegas

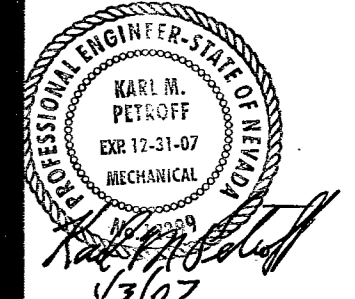

OWNER: CITY OF LAS VEGAS  
 DEPARTMENT OF PUBLIC WORKS  
 ARCHITECTURAL SERVICES

400 EAST STEWART AVENUE  
 LAS VEGAS, NEVADA 89103  
 PHONE: (702) 229-6535  
 FAX: (702) 386-6646  
 TDD: (702) 386-9108

FILE  
**ENLARGED FLOOR PLAN**  
 DATE  
 12/12/2006  
 SCALE  
 1/4" = 1'-0"

CU/DWG NO  
**513-65E**

DATE  
**P1.19**

REVISED 02/03

113361

