


ENLARGED FLOOR PLAN-AIA LAS VEGAS CHAPTER

SCALE: 1/4" = 1'-0"

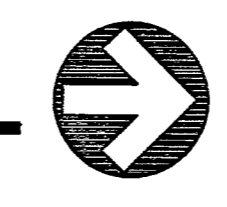

- NOTES**
- 1 REFER TO P1.00 FOR CONTINUATION.
 - 2 2" W. DN., 1 1/2" V. UP TO EXIST. V., 1/2" C.W. DOWN TO S-1 & W.H.-4, W/ 1/2" C.W. TEE TO REFRIGERATOR.
 - 3 PROVIDE NEW C.W. OF EQUAL SIZE AS EXIST. BETWEEN THIS P.O.C. & P.O.C. SHOWN ON P1.18.
 - 4 EXIST. C.W. ABV. CEILING. SEE NOTICE ON SHEET P1.13.
 - 5 REMOVE EXIST. CAST IRON PIPING ABOVE CEILING.
 - 6 P.O.C. NEW 1/2" COPPER C.W. WITH EXIST. REMOVE ALL GALV. C.W. PIPING DOWNSTREAM.
 - 7 REMOVE GALV. C.W. PIPING IN ITS ENTIRETY TO EXIST. TOILET ROOM.
 - 8 EXIST. C.W. SHALL BE REMOVED.
 - 9 EXIST. H.B. SHALL BE REMOVED. PATCH OPENING IN WALL TO MATCH SURROUNDING.
 - 10 P.O.C. NEW 2" W. WITH EXIST. 2" W. IN WALL.
 - 11 REMOVE EXIST. C.O. & INSTALL NEW C.O. ON OPPOSITE SIDE OF WALL.
 - 12 REMOVE EXISTING GALV. C.W. PIPING IN WALL.
 - 13 REMOVE EXIST. PIPING THRU WALL.
 - 14 P.O.C. NEW 1 1/2" V. WITH EXIST. VENT.

CLV COMMENTS
JANUARY 4, 2007

HERITAGE ARCHITECTURE & PLANNING
445 SOUTH POLARIS AVENUE
LAS VEGAS, NEVADA 89103
WWW.HERITAGEARCHITECTURE.COM
TEL: 702-337-1900
FAX: 702-337-2040

HERITAGE ARCHITECTURE & PLANNING
P.O. BOX 700
LAS VEGAS, NEVADA 89103
TEL: 702-337-1900

STRUCTURAL -
BARKER DROTAR ASSOCIATES
STRUCTURAL ENGINEERS
PHONE: 702-337-0000

MECHANICAL - PLUMBING - ELECTRICAL -
LIFE SAFETY - ACoustICAL - GENERAL LIGHTING
JBA CONSULTING ENGINEERS
PHONE: 702-337-0000

STAGE LIGHTING & DESIGN -
CD-M LIGHTING DESIGN GROUP
PHONE: 888-228-2323

LANDSCAPE -
LAWSON & ASSOCIATES
PHONE: 702-337-9396

CURTAINING -
ROSEBUD BLIND
LEVETT & BAILEY
702-337-6668

ADA ACCESSIBILITY
ENDELMAN AND ASSOCIATES
PHONE: 352-334-4442



**FIFTH STREET SCHOOL
REHABILITATION
BUILDING DEPARTMENT SUBMITTAL**

REVISED
12/2/07




PLANS APPROVED
PLUMBING/MECHANICAL
Building & Safety Dept.
City of Las Vegas, Nevada

JAN 26 2007

Stamp: PROFESSIONAL ENGINEER STATE OF NEVADA
KARL N. FEITKE
EXE 13-31-07
MECHANICAL
JAN 05 2007
City of Las Vegas

OWNER: CITY OF LAS VEGAS
DEPARTMENT OF PUBLIC WORKS
ARCHITECTURAL SERVICES

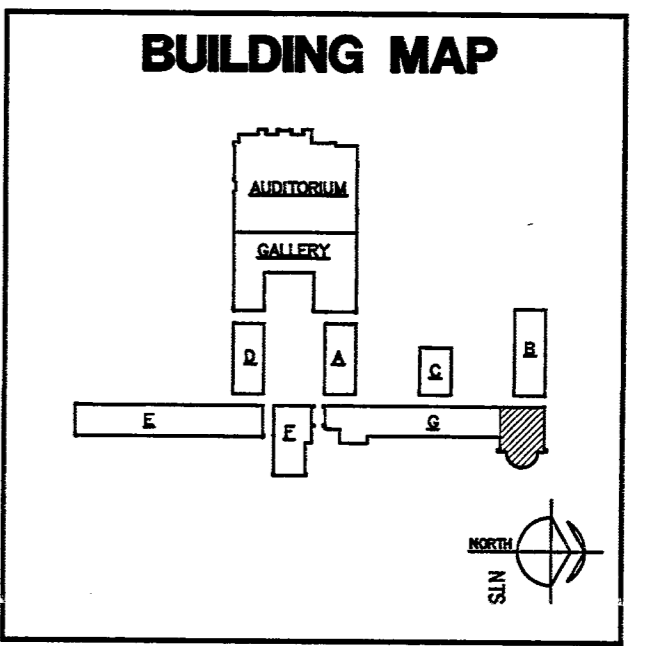

400 EAST STEWART AVENUE
LAS VEGAS, NEVADA 89103
PHONE: (702) 229-6532
FAX: (702) 386-4846
TDD: (702) 386-9108

OWNER: CITY OF LAS VEGAS
DEPARTMENT OF PUBLIC WORKS
ARCHITECTURAL SERVICES

FILE
ENLARGED FLOOR PLAN
DATE
12/12/2006
SCALE
1/4" = 1'-0"
REV NO

CLV DWS NO
513-65E

SHEET NO
P1.20

113362