




REVISIONS

3	6/24/02 REVISIONS
2	12/14/01 REVISIONS

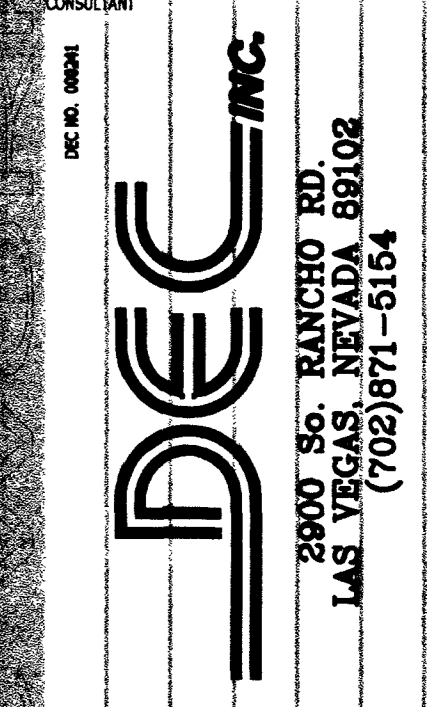

CITY OF LAS VEGAS, NEVADA
FIRE STATION #44
ROOF HVAC PLAN


DEPARTMENT OF PUBLIC WORKS
ARCHITECTURAL SERVICES
400 EAST STEWART AVENUE
LAS VEGAS, NEVADA 89101
PHONE: (702) 229-8333
FAX: (702) 392-8232
TDD: (702) 399-9108

DEKIN ENGINEERING CONSULTANT

DATE	7/15/01
SCALE	AS SHOWN
PROJECT	630.97
SHEET NO.	77 OF 106
	M-03

SHEET NOTES: (THIS SHEET ONLY)

- 1 6" FLUE FROM WATER HEATER WH-1.
- 2 4" FLUE FROM UNIT HEATER UH-1A THRU 1E.
- 3 NOT USED.
- 4 ROOF CAP (EXHAUST) GREENHECK MODEL GRS-12.
- 5 COMBUSTION AIR LOUVER, QTY 2, 12" x 8" WITH BIRD AND INSECT SCREEN. SEE M-02 FOR CONTINUATION. CONTRACTOR SHALL PROVIDE OPENING THROUGH PARAPET WALL.

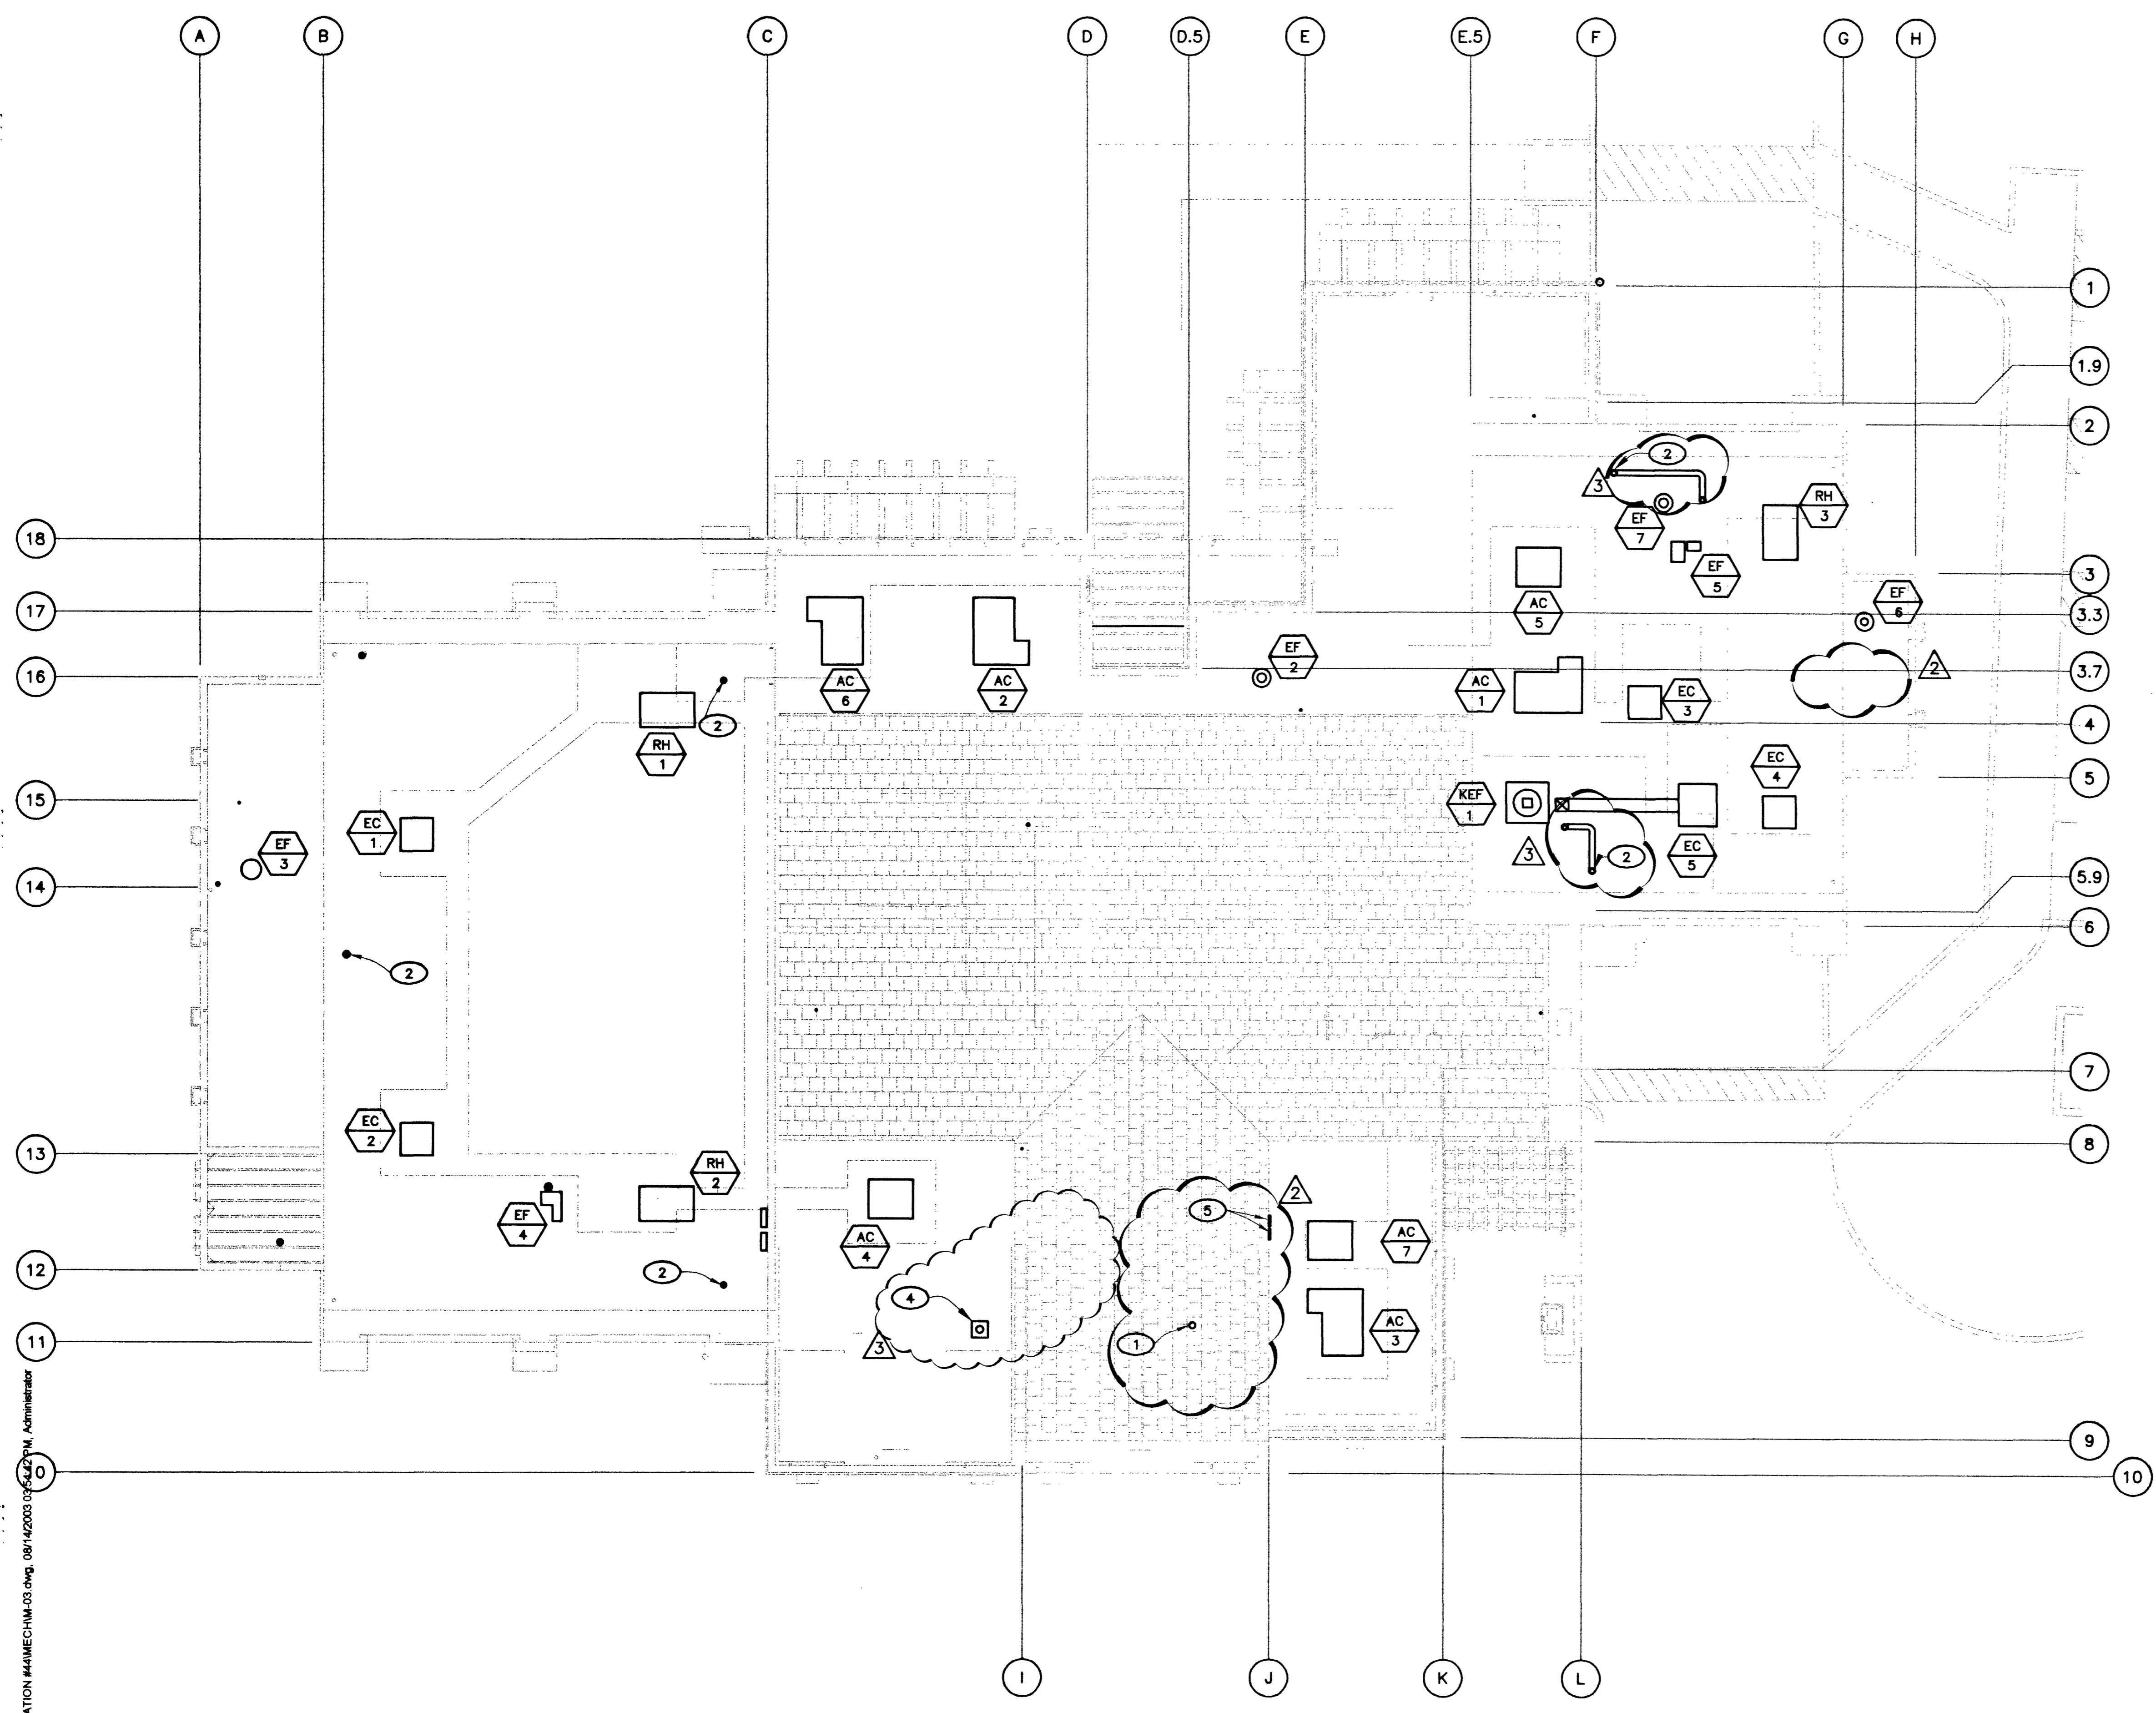

1 ROOF HVAC PLAN
M-03 1/8" = 1'-0"

57299

Q:\Projects\0000000241 FIRE STATION #44\MECH\1-M-03.dwg, 08/14/2003 09:54:21 AM, Administrator

REVISIONS AND NOTES: ALL REVISIONS AND NOTES SHALL BE MADE TO THE ORIGINAL DRAWING. THE CONSULTANT SHALL BE RESPONSIBLE FOR THE ACCURACY OF THE INFORMATION PROVIDED. THE CONSULTANT SHALL BE RESPONSIBLE FOR THE ACCURACY OF THE INFORMATION PROVIDED. THE CONSULTANT SHALL BE RESPONSIBLE FOR THE ACCURACY OF THE INFORMATION PROVIDED.