


SHEET GENERAL NOTES

- 1 CONTRACTOR TO PROVIDE ALL CONDUITS AND LOW VOLTAGE WIRING FOR ALL T-STAT, T-STAT PROVIDED BY MECHANICAL CONTRACTOR, INSTALLED BY ELECTRICAL CONTRACTOR. COORDINATE LOCATION OF T-STAT WITH MECHANICAL DRAWINGS (SHEET M-04)
- 2 CONTRACTOR TO PROVIDE ALL INTERLOCK CONTROL WIRING AND CONDUIT FOR EVAP COOLERS, HVAC & EF AS REQUIRED BY MECHANICAL DWGS SHEET M-03.
- 3 VERIFY LOCATION OF HVAC UNITS.
- 4 CONCEAL CONDUITS UNDER ROOF. DO NOT RUN CONDUIT ON ROOF.
- 5 COORDINATE WITH MECHANICAL DWG WHICH AC UNIT IS PROVIDED WITH DUCT DETECTOR. CONNECT DUCT DETECTOR TO FACP. IN THE EVENT OF ACTIVATION, FACP SHALL DISABLE RESPECTIVE AC UNIT.

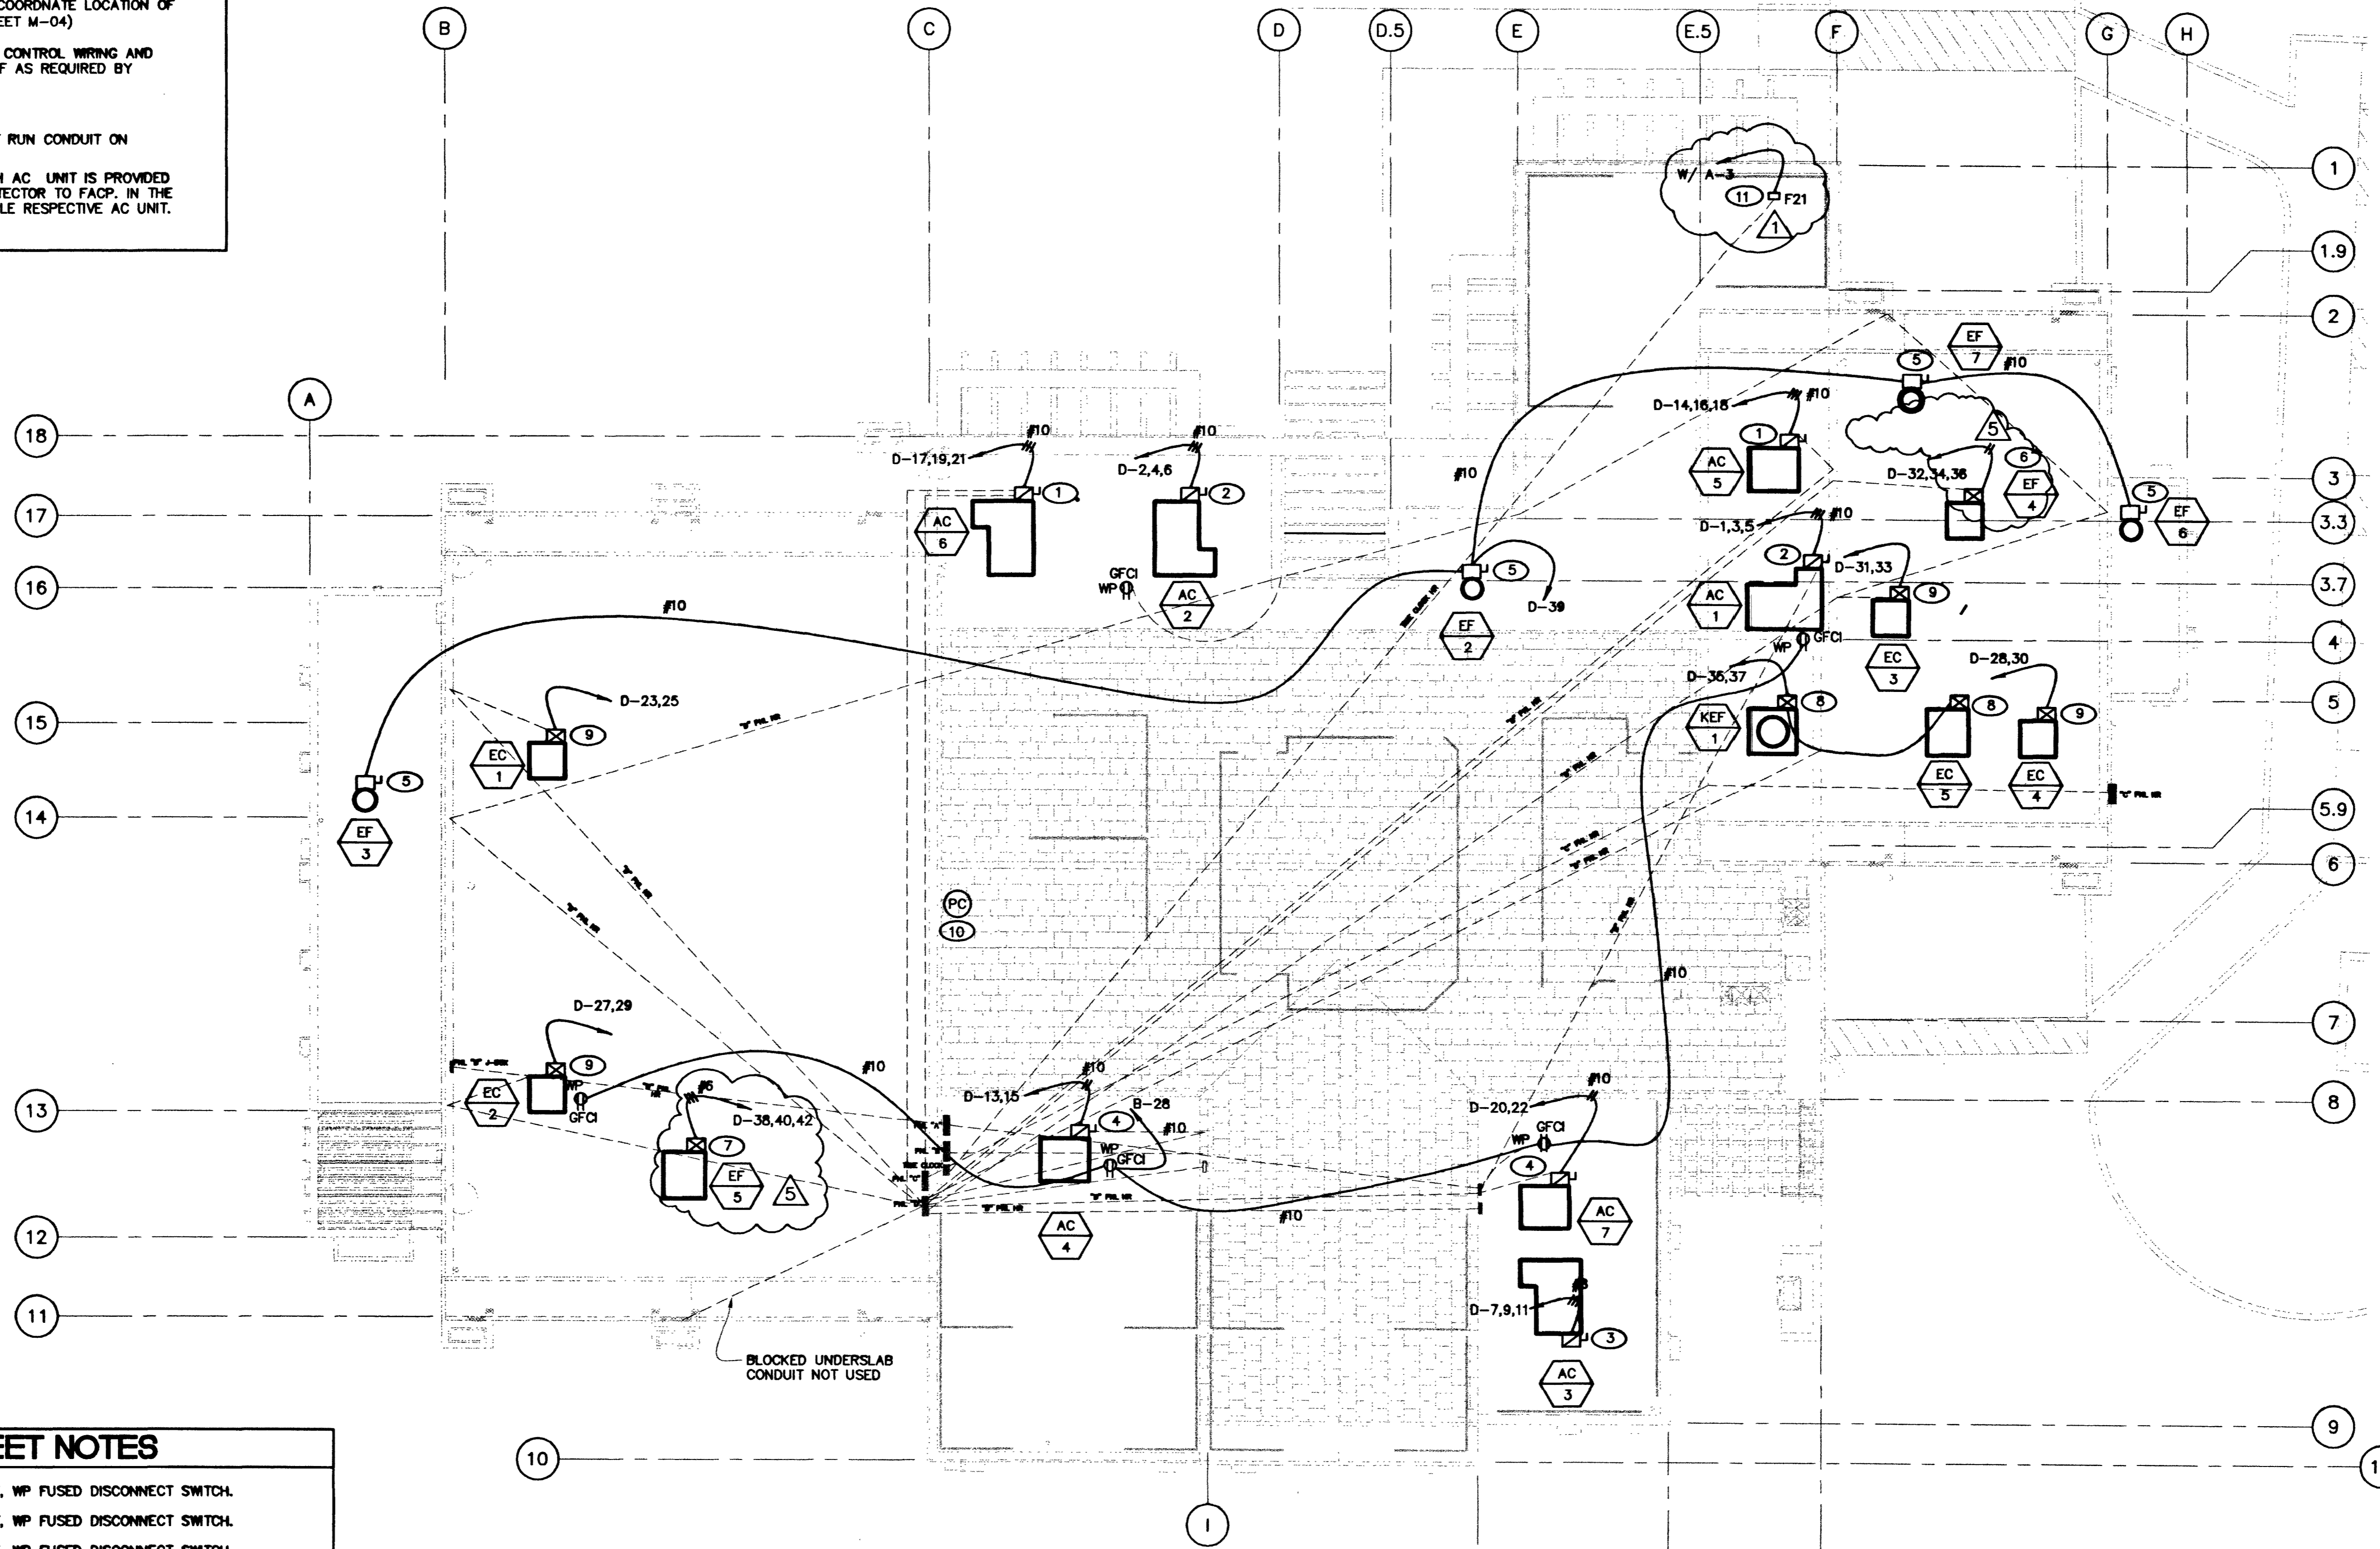

ELECTRICAL HVAC PLAN

SCALE: 1/8"=1'-0"

SHEET NOTES

- 1 250V, 3P, 30AS, 25AF, WP FUSED DISCONNECT SWITCH.
- 2 250V, 3P, 30AS, 30AF, WP FUSED DISCONNECT SWITCH.
- 3 250V, 3P, 60AS, 35AF, WP FUSED DISCONNECT SWITCH.
- 4 250V, 2P, 30AS, 30AF, WP FUSED DISCONNECT SWITCH.
- 5 250V, 1P, 20AS, WP DISCONNECT SWITCH.
- 6 WP COMBINATION STARTER FOR EXHAUST FAN 4. SIZE AS REQUIRED.
- 7 WP COMBINATION STARTER FOR EXHAUST FAN 5. SIZE AS REQUIRED.
- 8 SEE SCHEMATIC ON EB.3 FOR CONNECTION.
- 9 VERIFY IF EVAP COOLER MOTOR OR EXHAUST FAN IS PROVIDED WITH INTEGRAL OVERLOAD PROTECTION. IF NONE PROVIDE A COMBINATION MOTOR STARTER. SIZE AS REQUIRED. IF MOTOR IS PROTECTED, PROVIDE A 250V, 2P, 30AS DISCONNECT SWITCH.
- 10 LOCATION OF PHOTO CELL.
- 11 LIGHT FIXTURE MOUNTED ON ROOF TO ILLUMINATE ADDRESS OF BLDG. ADJUST LOCATION WHERE APPROPRIATE.

57319



REVISIONS
5 7/24/02 MISLABEL

CONSULTANT
DEC INC.
2900 S. RANCHO RD.
LAS VEGAS, NEVADA 89108
(702) 871-6164

CITY OF LAS VEGAS, NEVADA
FIRE STATION #44
ELECTRICAL HVAC PLAN

DEPARTMENT OF PUBLIC WORKS
ARCHITECTURAL SERVICES
400 EAST STEWART AVENUE
LAS VEGAS, NEVADA 89101
PHONE: (702) 228-8338
FAX: (702) 892-5232
TDD: (702) 896-1108

DRAWN: AOA
FILE:
DATE: 07/15/01
SCALE: 1/8"=1'-0"
PROJECT: 08079
SHEET NO: 970F 06
E3.1

CONTRACTOR TO VERIFY ALL INFORMATION ON THIS DRAWING AND TO BE RESPONSIBLE FOR THE ACCURACY OF THE INFORMATION PROVIDED. THE CONTRACTOR SHALL BE RESPONSIBLE FOR THE ACCURACY OF THE INFORMATION PROVIDED. THE CONTRACTOR SHALL BE RESPONSIBLE FOR THE ACCURACY OF THE INFORMATION PROVIDED.