


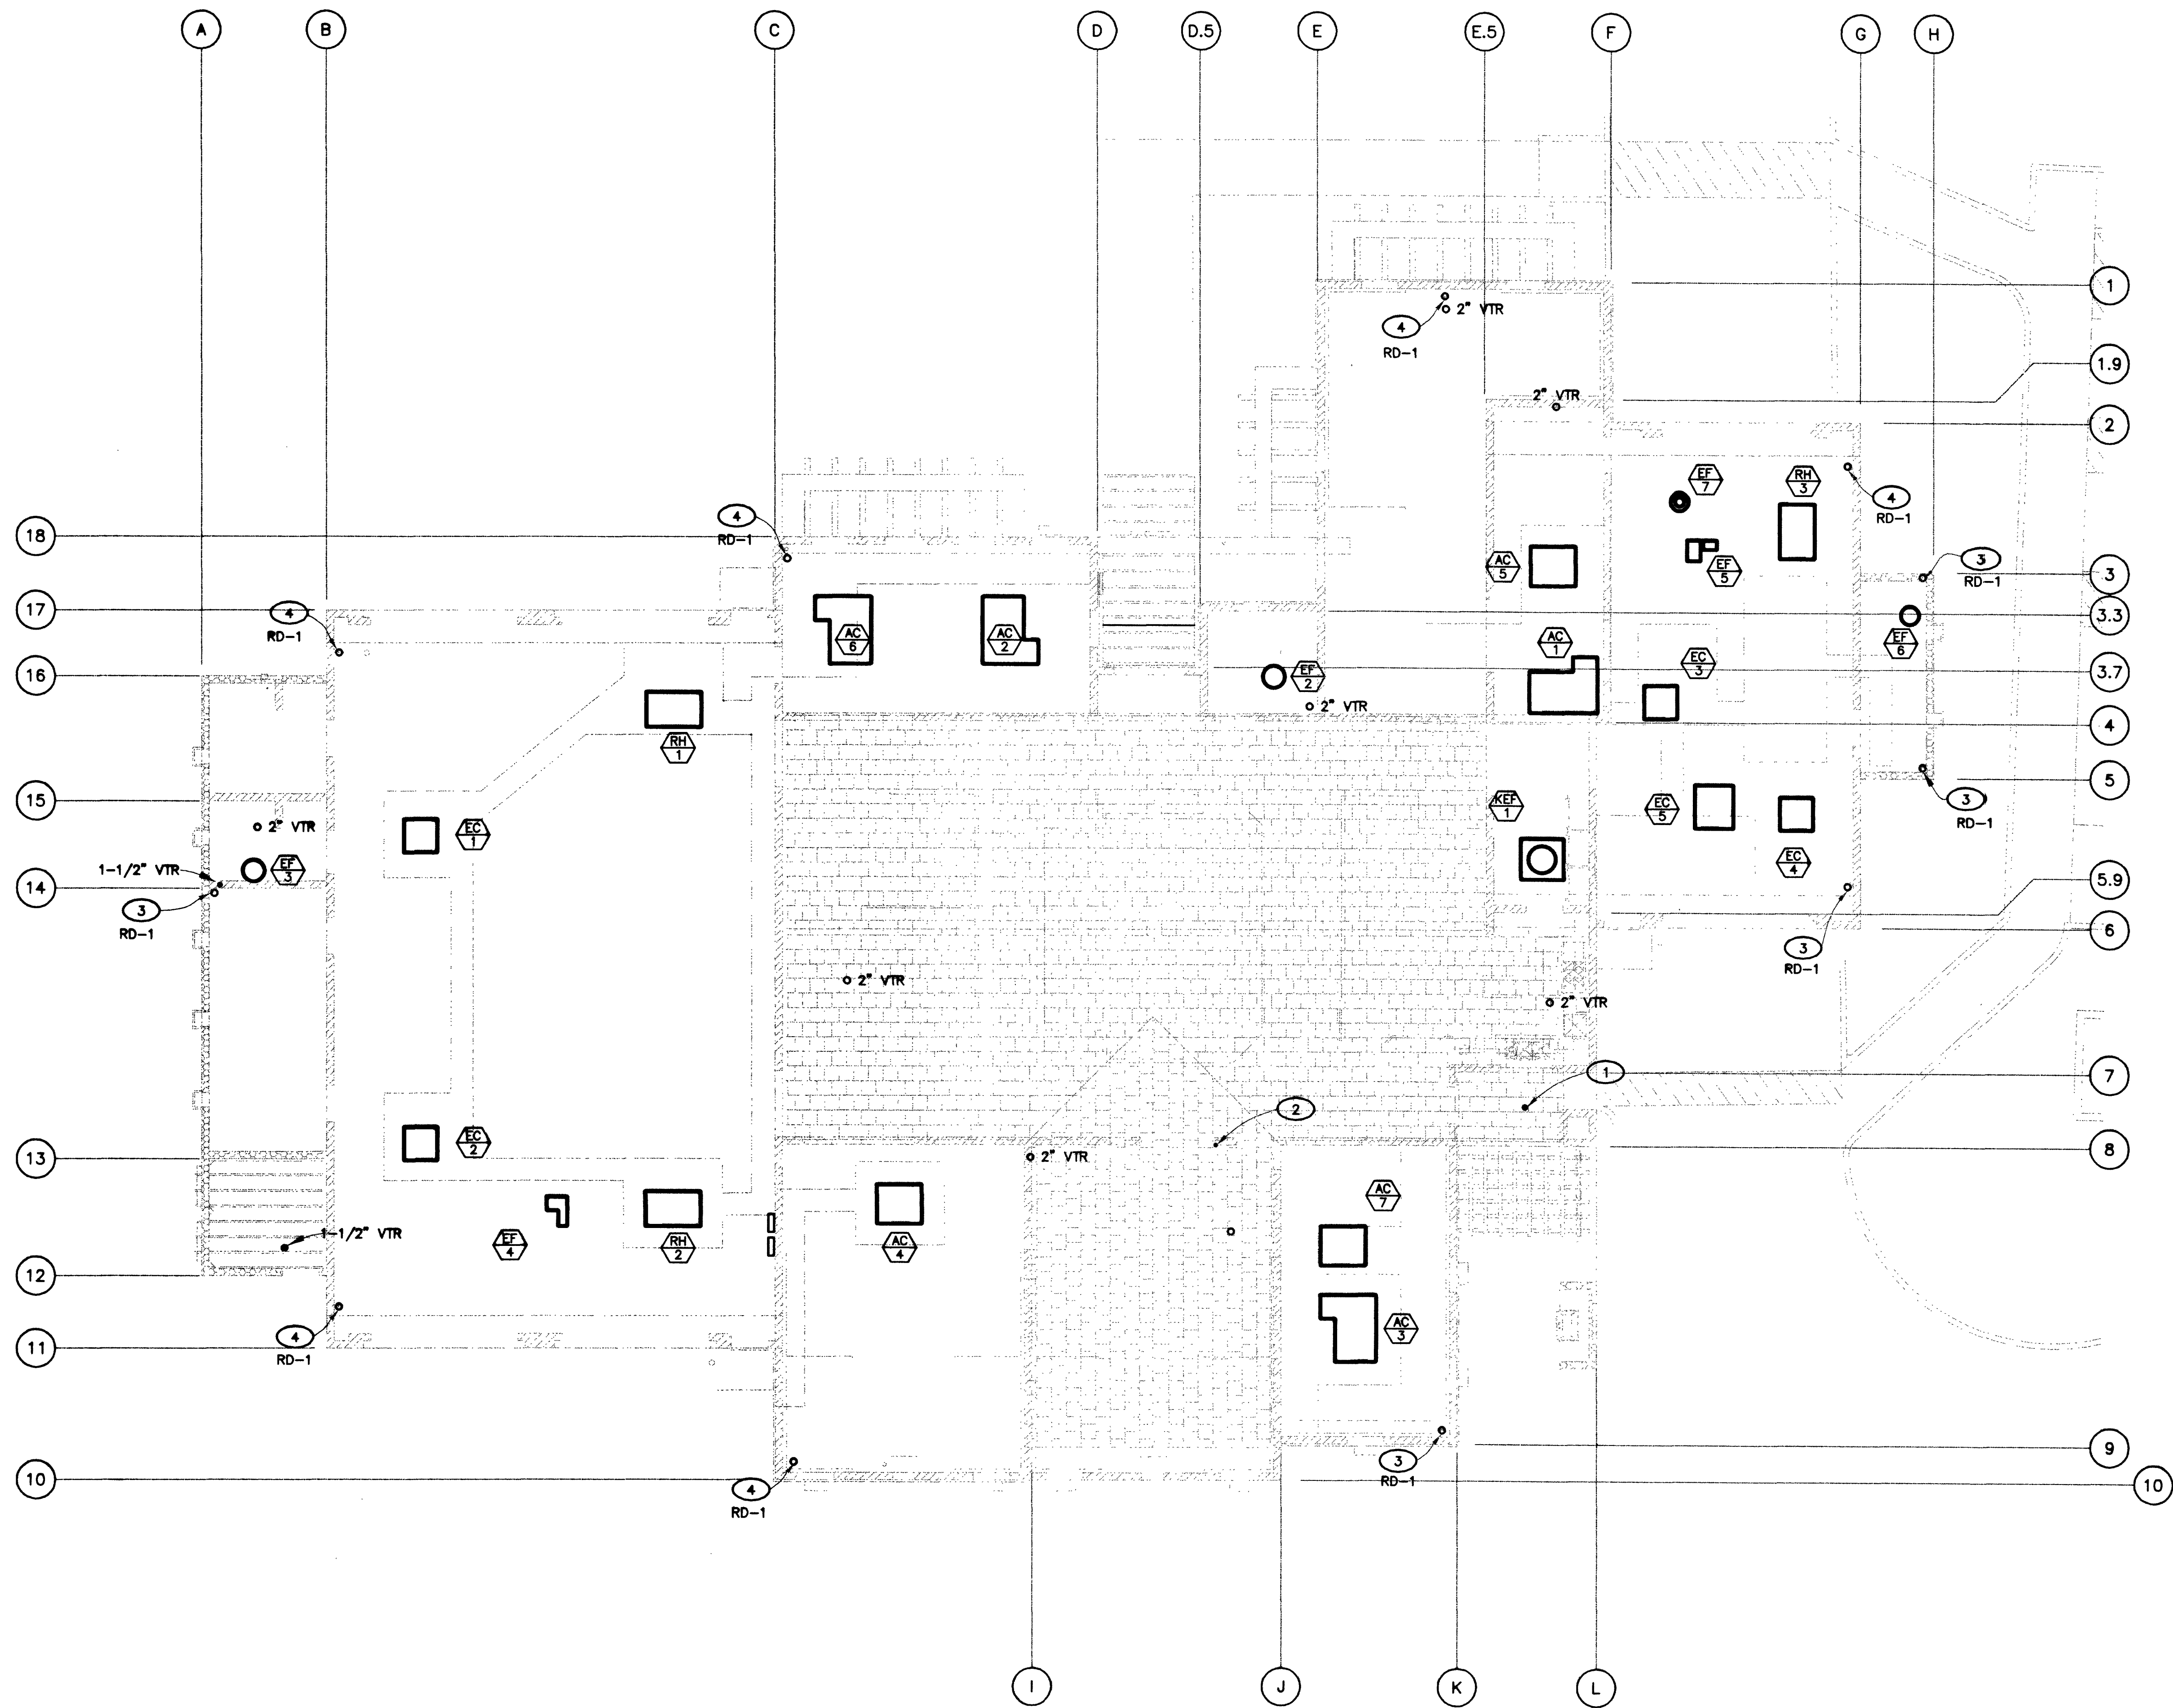

SHEET NOTES: (THIS SHEET ONLY)

- 1 2" KITCHEN VENT RETURN SEE 1/P-04
- 2 VENT RETURN FROM JANITORS CLOSET
- 3 5" ROOF DRAIN 3/P-04
- 4 5" ROOF DRAINS



REVISIONS
CONSULTANT

DEC
2800 SO. RANCHO RD.
LAS VEGAS, NEVADA 89102
(702) 871-5164

CITY OF LAS VEGAS, NEVADA
FIRE STATION #44
ROOF PLUMBING PLAN

DEPARTMENT OF PUBLIC WORKS
ARCHITECTURAL SERVICES
400 EAST STEWART AVENUE
LAS VEGAS, NEVADA 89201
PHONE: (702) 225-5555
FAX: (702) 882-5232
TDD: (702) 886-6108

DESIGN ENGINEER'S CONSULTANT

NAME: K. B. L.

FILE

DATE: 7/15/01

SCALE: AS SHOWN

PROJECT: 600.07

SHEET NO: 84 OF 06

P-02

1 ROOF PLUMBING PLAN
P-02 1/8" = 1'-0"

57306

