


This document, including the ideas and designs it contains, is an instrument of professional services rendered by the Architect / Engineer. This document may not be used or copied in whole, or in part, for any purpose other than this specific project without the expressed written consent of Westar Architectural Group, Inc.

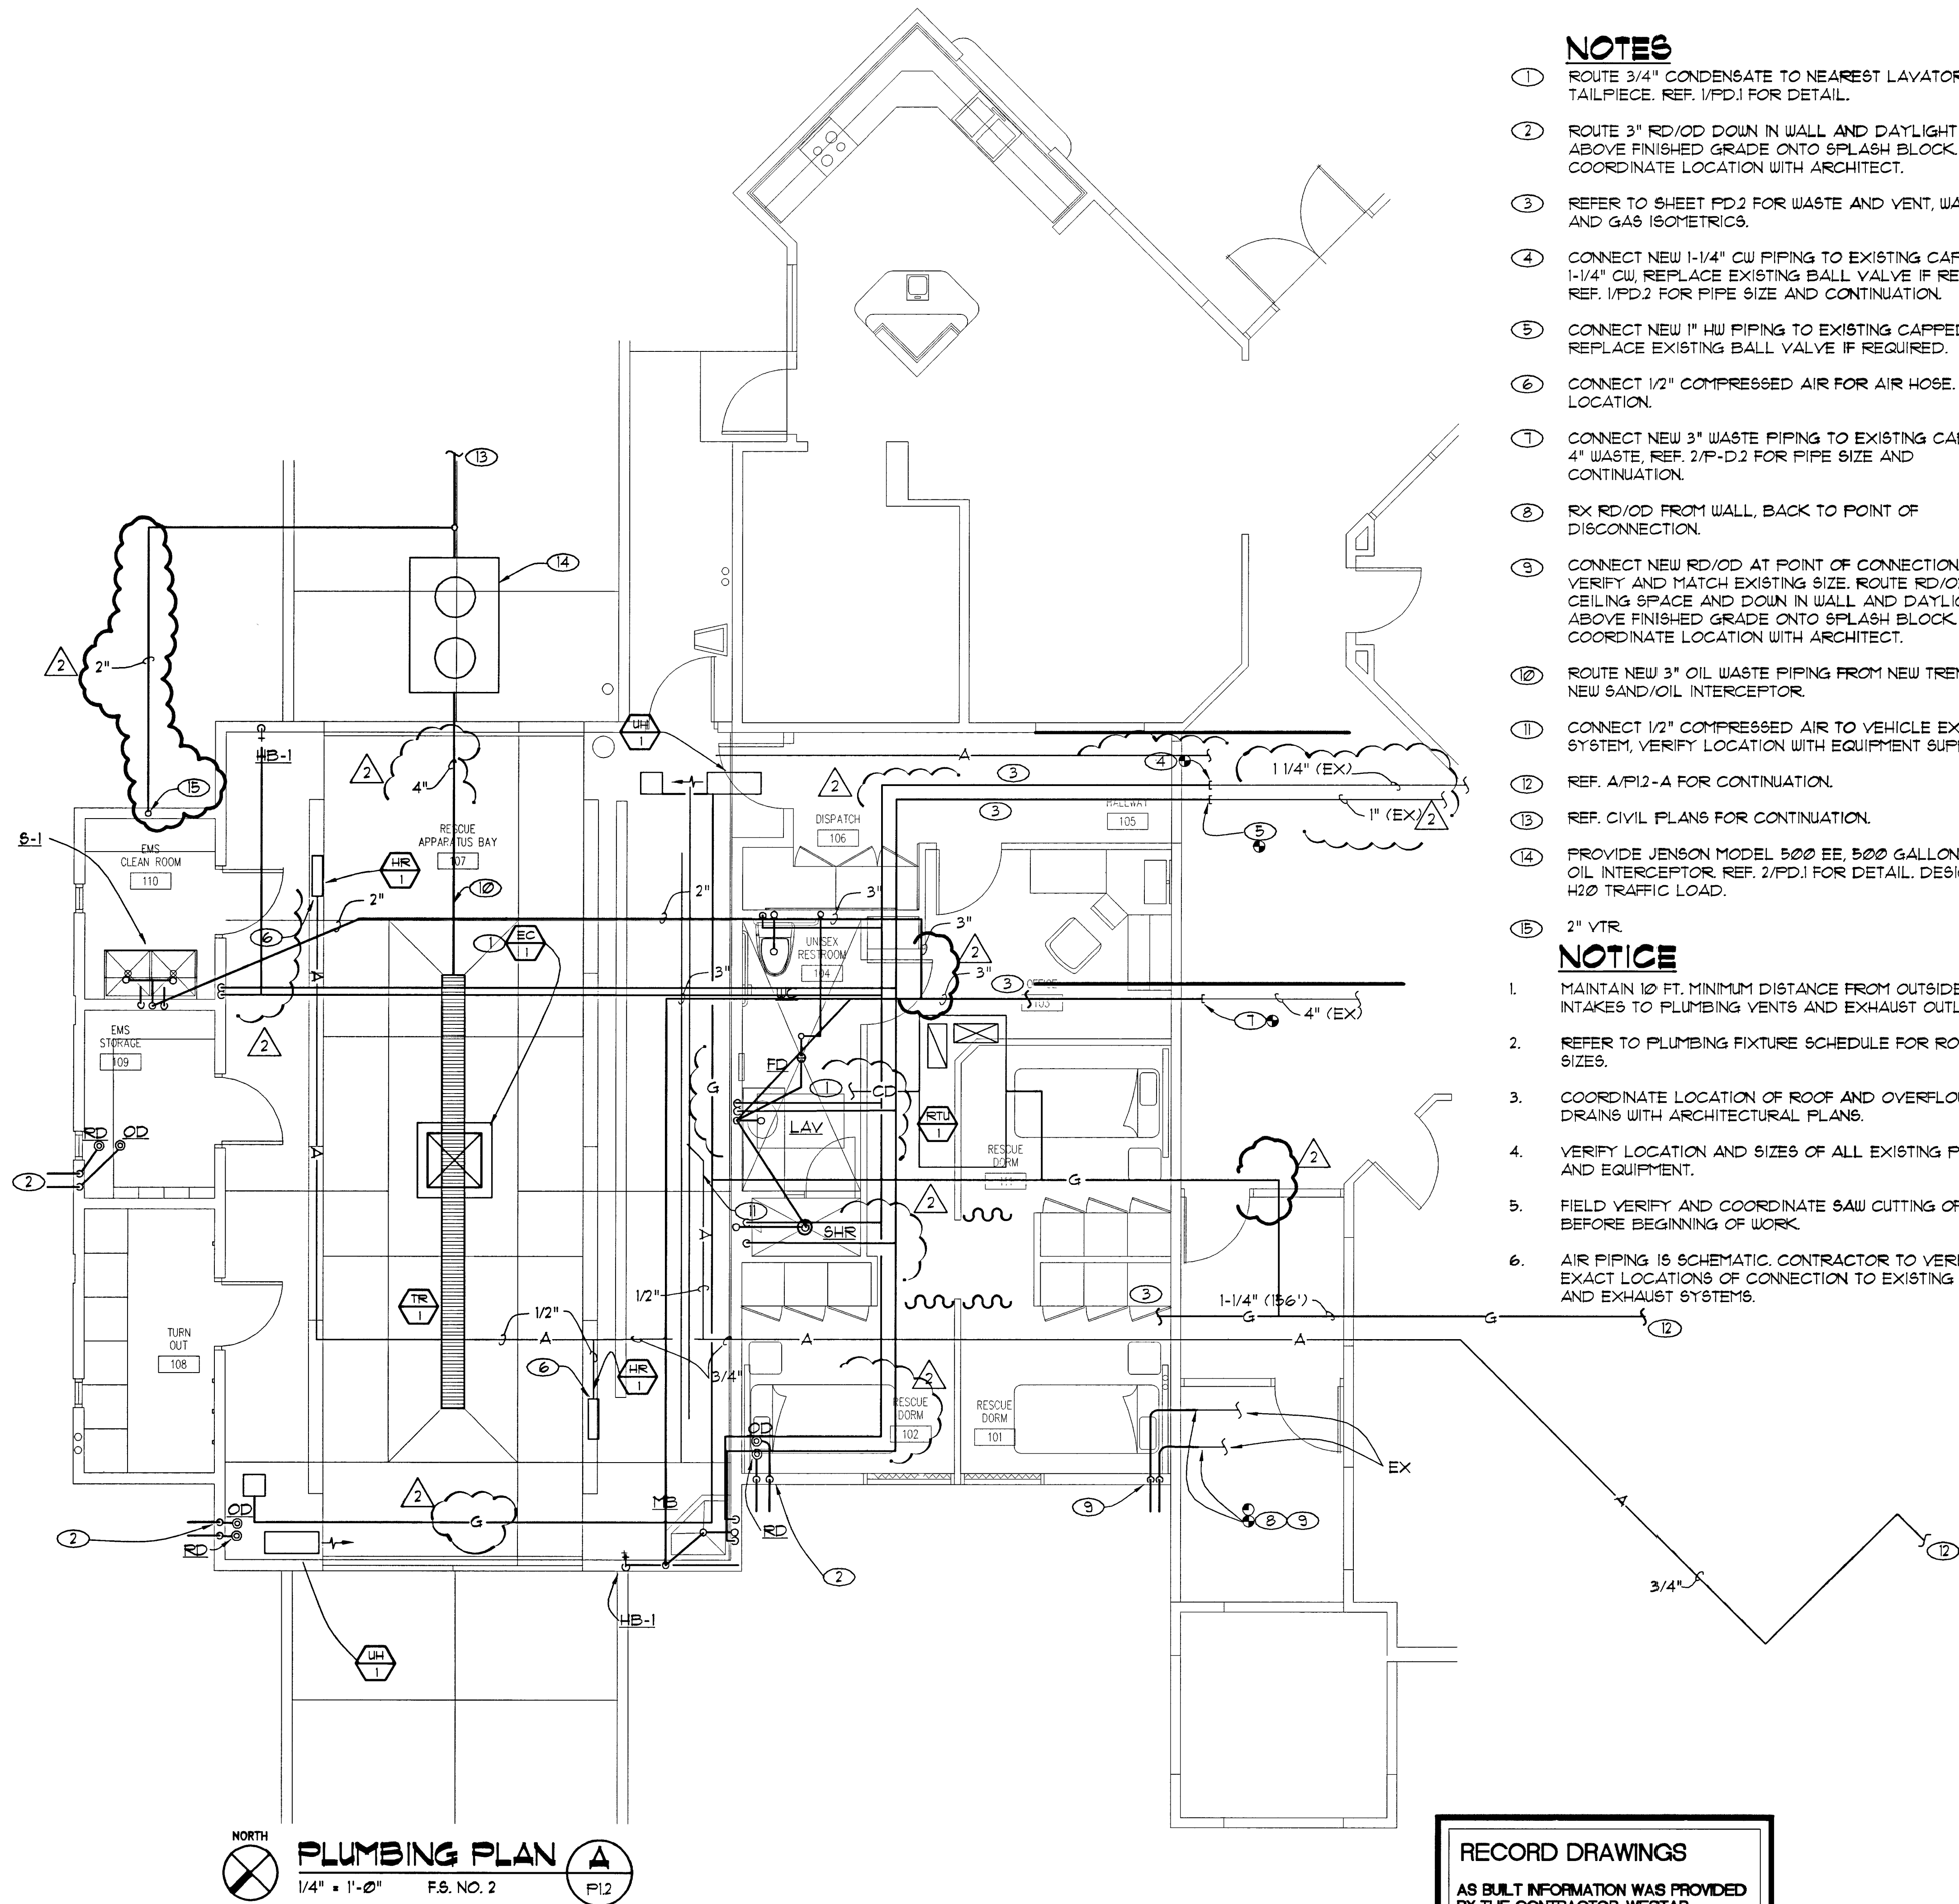

NOTES

- 1 ROUTE 3/4" CONDENSATE TO NEAREST LAVATORY TAILPIECE. REF. 1/PD.1 FOR DETAIL.
- 2 ROUTE 3" RD/OD DOWN IN WALL AND DAYLIGHT 6" ABOVE FINISHED GRADE ONTO SPLASH BLOCK. COORDINATE LOCATION WITH ARCHITECT.
- 3 REFER TO SHEET PD.2 FOR WASTE AND VENT, WATER, AND GAS ISOMETRICS.
- 4 CONNECT NEW 1-1/4" CW PIPING TO EXISTING CAPPED 1-1/4" CW, REPLACE EXISTING BALL VALVE IF REQUIRED. REF. 1/PD.2 FOR PIPE SIZE AND CONTINUATION.
- 5 CONNECT NEW 1" HW PIPING TO EXISTING CAPPED 1" HW. REPLACE EXISTING BALL VALVE IF REQUIRED.
- 6 CONNECT 1/2" COMPRESSED AIR FOR AIR HOSE. VERIFY LOCATION.
- 7 CONNECT NEW 3" WASTE PIPING TO EXISTING CAPPED 4" WASTE, REF. 2/P-D.2 FOR PIPE SIZE AND CONTINUATION.
- 8 RX RD/OD FROM WALL, BACK TO POINT OF DISCONNECTION.
- 9 CONNECT NEW RD/OD AT POINT OF CONNECTION. VERIFY AND MATCH EXISTING SIZE. ROUTE RD/OD IN CEILING SPACE AND DOWN IN WALL AND DAYLIGHT 6" ABOVE FINISHED GRADE ONTO SPLASH BLOCK. COORDINATE LOCATION WITH ARCHITECT.
- 10 ROUTE NEW 3" OIL WASTE PIPING FROM NEW TRENCH TO NEW SAND/OIL INTERCEPTOR.
- 11 CONNECT 1/2" COMPRESSED AIR TO VEHICLE EXHAUST SYSTEM, VERIFY LOCATION WITH EQUIPMENT SUPPLIER.
- 12 REF. A/P12-A FOR CONTINUATION.
- 13 REF. CIVIL PLANS FOR CONTINUATION.
- 14 PROVIDE JENSON MODEL 500 EE, 500 GALLON SAND/OIL INTERCEPTOR. REF. 2/PD.1 FOR DETAIL. DESIGN FOR H2O TRAFFIC LOAD.
- 15 2" VTR.

NOTICE

1. MAINTAIN 10 FT. MINIMUM DISTANCE FROM OUTSIDE AIR INTAKES TO PLUMBING VENTS AND EXHAUST OUTLETS.
2. REFER TO PLUMBING FIXTURE SCHEDULE FOR ROUGH-IN SIZES.
3. COORDINATE LOCATION OF ROOF AND OVERFLOW DRAINS WITH ARCHITECTURAL PLANS.
4. VERIFY LOCATION AND SIZES OF ALL EXISTING PIPING, AND EQUIPMENT.
5. FIELD VERIFY AND COORDINATE SAW CUTTING OF SLAB, BEFORE BEGINNING OF WORK.
6. AIR PIPING IS SCHEMATIC. CONTRACTOR TO VERIFY EXACT LOCATIONS OF CONNECTION TO EXISTING PIPING AND EXHAUST SYSTEMS.

ABF CONSULTING ENGINEERS
Las Vegas, Nevada 89103
Tel: (702) 248-0338
Sparks, Nevada 89431
Tel: (775) 674-2222
Phoenix, Arizona 85014
Tel: (602) 274-1801
WE ENGINEER, ARCHITECT, PLANNING, AND INTERIOR DESIGN. WE PROVIDE A FULL RANGE OF SERVICES. WE ARE A FULL SERVICE FIRM. WE ARE A FULL SERVICE FIRM.

WESTAR
ARCHITECTURAL GROUP, INC. / NEVADA INC.
LAS VEGAS, NEVADA
ARCHITECTURE * PLANNING * PROJECT MANAGEMENT
3900 MEADOWS LANE, SUITE 220 LAS VEGAS, NEVADA 89107
TELEPHONE: (702) 878-0000 FAX: (702) 878-8430

A FACILITY IMPROVEMENT FOR:
FIRE STATION 2, 7, & 9
LAS VEGAS, NEVADA

PROJECT NUMBER	DATE	REVISION DESCRIPTION	NUMBER	DATE
01003	2/14/03	RECORD DRAWING CONNECTIONS	1	
DRAWN BY S.F.	DESIGNED BY KSD			
ISSUE DATE 08-13-01				
SCALE 1/4" = 1'-0"				
SHEET NUMBER 630.99				
P1.2				

RECORD DRAWINGS

AS BUILT INFORMATION WAS PROVIDED BY THE CONTRACTOR. WESTAR ARCHITECTURAL ASSUMES NO LIABILITY FOR ACCURACY OF ITS CONTENTS.

08/07/03