



This document, including the ideas and designs it contains, is an instrument of professional services rendered by the Architect / Engineer. The document may not be used or copied in whole, or in part, for any purpose other than this specific project without the expressed written consent of Westar Architectural Group, Inc.

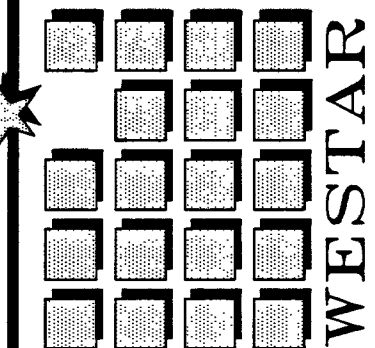

PROJECT NUMBER	0803	DESIGNED BY	KSD	ISSUE DATE	09-18-01	SCALE	1/4" = 1'-0"
DRAWN BY	9JF	DATE	09-18-01	DATE			
REVISION DESCRIPTION	RECORD DRAWING CONNECTION	DATE	09-18-01	DATE			
NUMBER	1	NUMBER		NUMBER		NUMBER	
SHEET NUMBER	630.99						
	P1.79(9)						

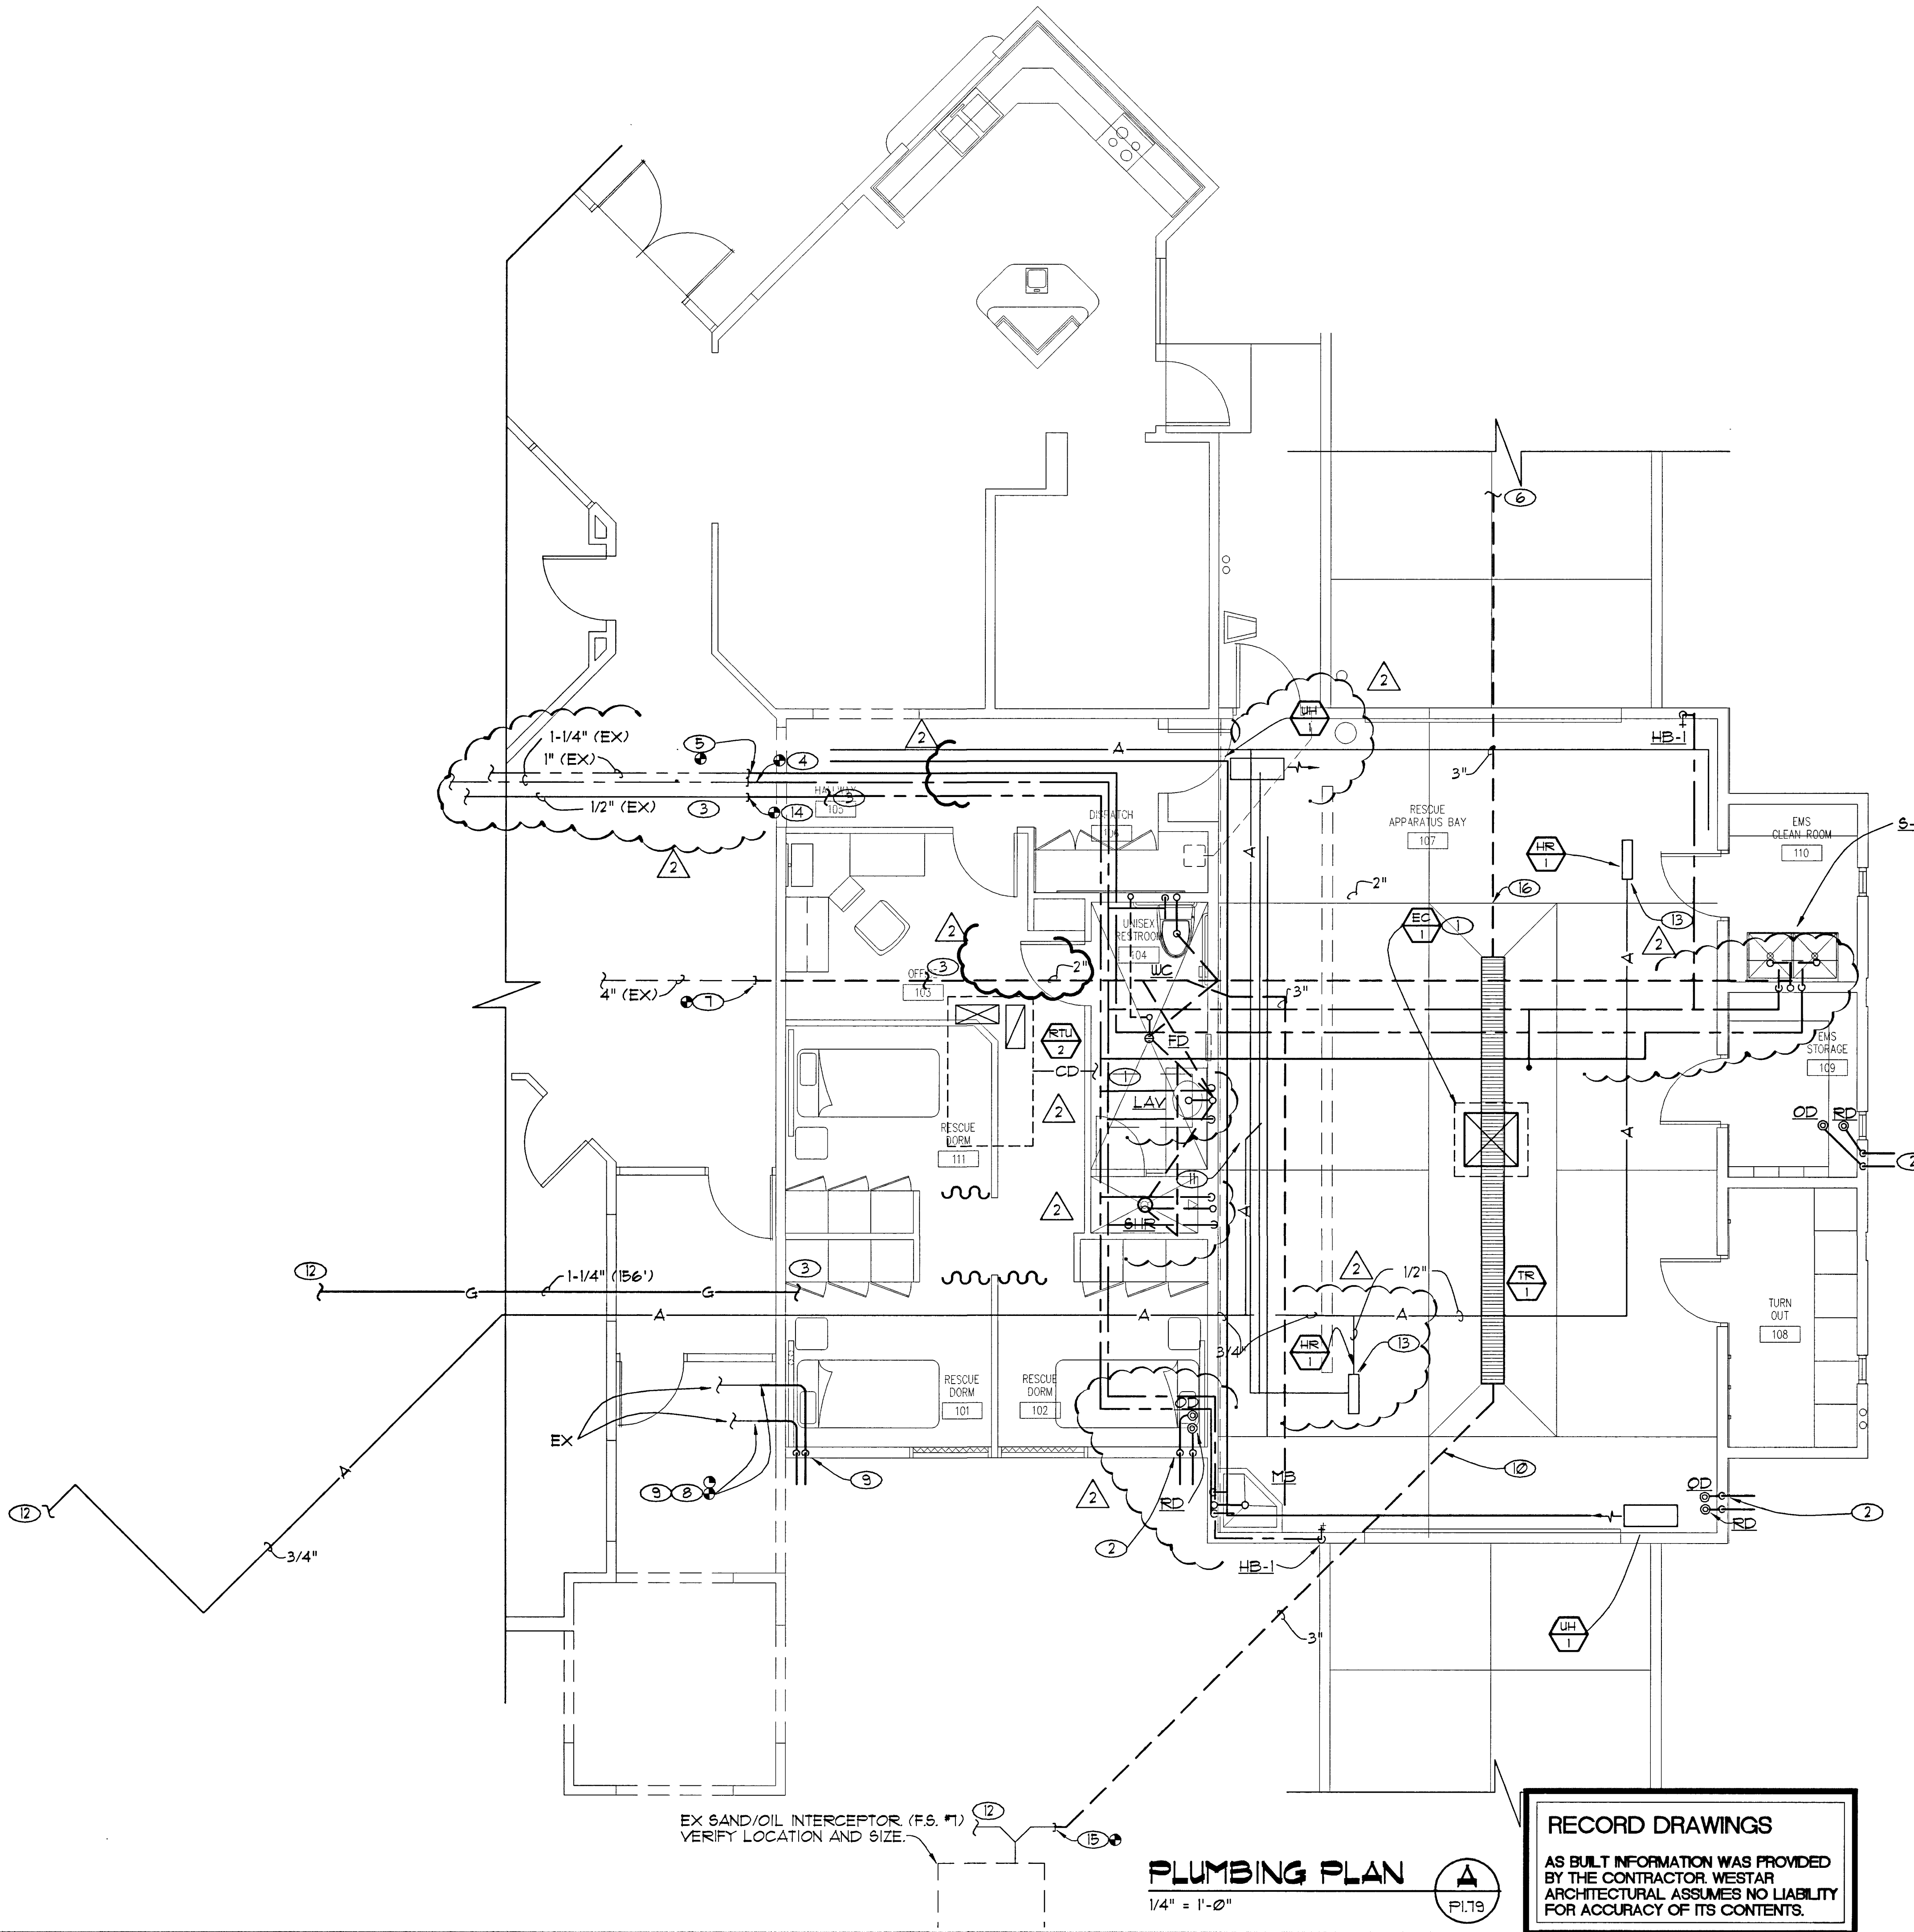

- ### NOTES
- ROUTE 3/4" CONDENSATE TO NEAREST LAVATORY TAILPIECE. REF. 1/FP.1 FOR DETAIL.
 - ROUTE 3" RD/OD DOWN IN WALL AND DAYLIGHT 6" ABOVE FINISHED GRADE ONTO SPLASH BLOCK. COORDINATE LOCATION WITH ARCHITECT.
 - REFER TO SHEET P-D.2 FOR WASTE AND VENT, WATER, AND GAS ISOMETRICS.
 - CONNECT NEW 1-1/4" CW PIPING TO EXISTING CAPPED 1-1/4" CW. REF. 1/FP-D.2 FOR PIPE SIZE AND CONTINUATION. REPLACE EXISTING BALL VALVE IF REQUIRED.
 - CONNECT NEW 1" HW PIPING TO EXISTING CAPPED 1" HW. REPLACE EXISTING BALL VALVE IF REQUIRED.
 - SEE CIVIL PLANS FOR CONTINUATION.
 - CONNECT NEW 3" WASTE PIPING TO EXISTING CAPPED 4" WASTE. REF. 2/P-D.2 FOR PIPE SIZE AND CONTINUATION.
 - RX RD/OD FROM WALL, BACK TO POINT OF DISCONNECTION.
 - CONNECT NEW RD/OD AT POINT OF CONNECTION. VERIFY AND MATCH EXISTING SIZE. ROUTE RD/OD IN CEILING SPACE AND DOWN IN WALL AND DAYLIGHT 6" ABOVE FINISHED GRADE ONTO SPLASH BLOCK. COORDINATE LOCATION WITH ARCHITECT.
 - ROUTE NEW 3" OIL WASTE PIPING FROM NEW TRENCH TO EXISTING SAND/OIL INTERCEPTOR (F.S. * 1 ONLY).
 - CONNECT 1/2" COMPRESSED AIR TO VEHICLE EXHAUST SYSTEM. VERIFY LOCATION WITH EQUIPMENT SUPPLIER.
 - REF. A/PL19-A FOR CONTINUATION.
 - CONNECT 1/2" COMPRESSED AIR FOR AIR HOSE. VERIFY LOCATION.
 - CONNECT NEW 1/2" HW PIPING TO EXISTING CAPPED 1/2" HW. REF. 1/FP.2 FOR PIPE SIZE AND CONTINUATION. REPLACE EXISTING BALL VALVE IF REQUIRED.
 - CONNECT NEW 3" SAND/OIL WASTE PIPING TO EXISTING CAPPED 4" WASTE. FIRE STATION * 1 ONLY. FIELD VERIFY LOCATION.
 - ROUTE NEW 3" SAND/OIL WASTE PIPING FROM NEW TRENCH TO EXISTING SAND/OIL INTERCEPTOR (F.S. * 1 ONLY).

- ### NOTICE
- MAINTAIN 10 FT. MINIMUM DISTANCE FROM OUTSIDE AIR INTAKES TO PLUMBING VENTS AND EXHAUST OUTLETS.
 - REFER TO PLUMBING FIXTURE SCHEDULE FOR ROUGH-IN SIZES.
 - COORDINATE LOCATION OF ROOF AND OVERFLOW DRAINS WITH ARCHITECTURAL PLANS.
 - VERIFY LOCATION AND SIZES OF ALL EXISTING PIPING, AND EQUIPMENT.
 - FIELD VERIFY AND COORDINATE SAW CUTTING OF SLAB, BEFORE BEGINNING OF WORK.
 - AIR PIPING IS SCHEMATIC. CONTRACTOR TO VERIFY EXACT LOCATIONS OF CONNECTION TO EXISTING PIPING AND EXHAUST SYSTEMS.

RECORD DRAWINGS
AS BUILT INFORMATION WAS PROVIDED BY THE CONTRACTOR. WESTAR ARCHITECTURAL ASSUMES NO LIABILITY FOR ACCURACY OF ITS CONTENTS.

PLUMBING PLAN
1/4" = 1'-0"
P1.79

EX SAND/OIL INTERCEPTOR (F.S. * 1)
VERIFY LOCATION AND SIZE.