


This document, including the ideas and designs it contains, is an instrument of professional services rendered by the Architect / Engineer. This document may not be used or copied in whole, or in part, for any purpose other than this specific project without the expressed written consent of Westar Architectural Group, Inc.

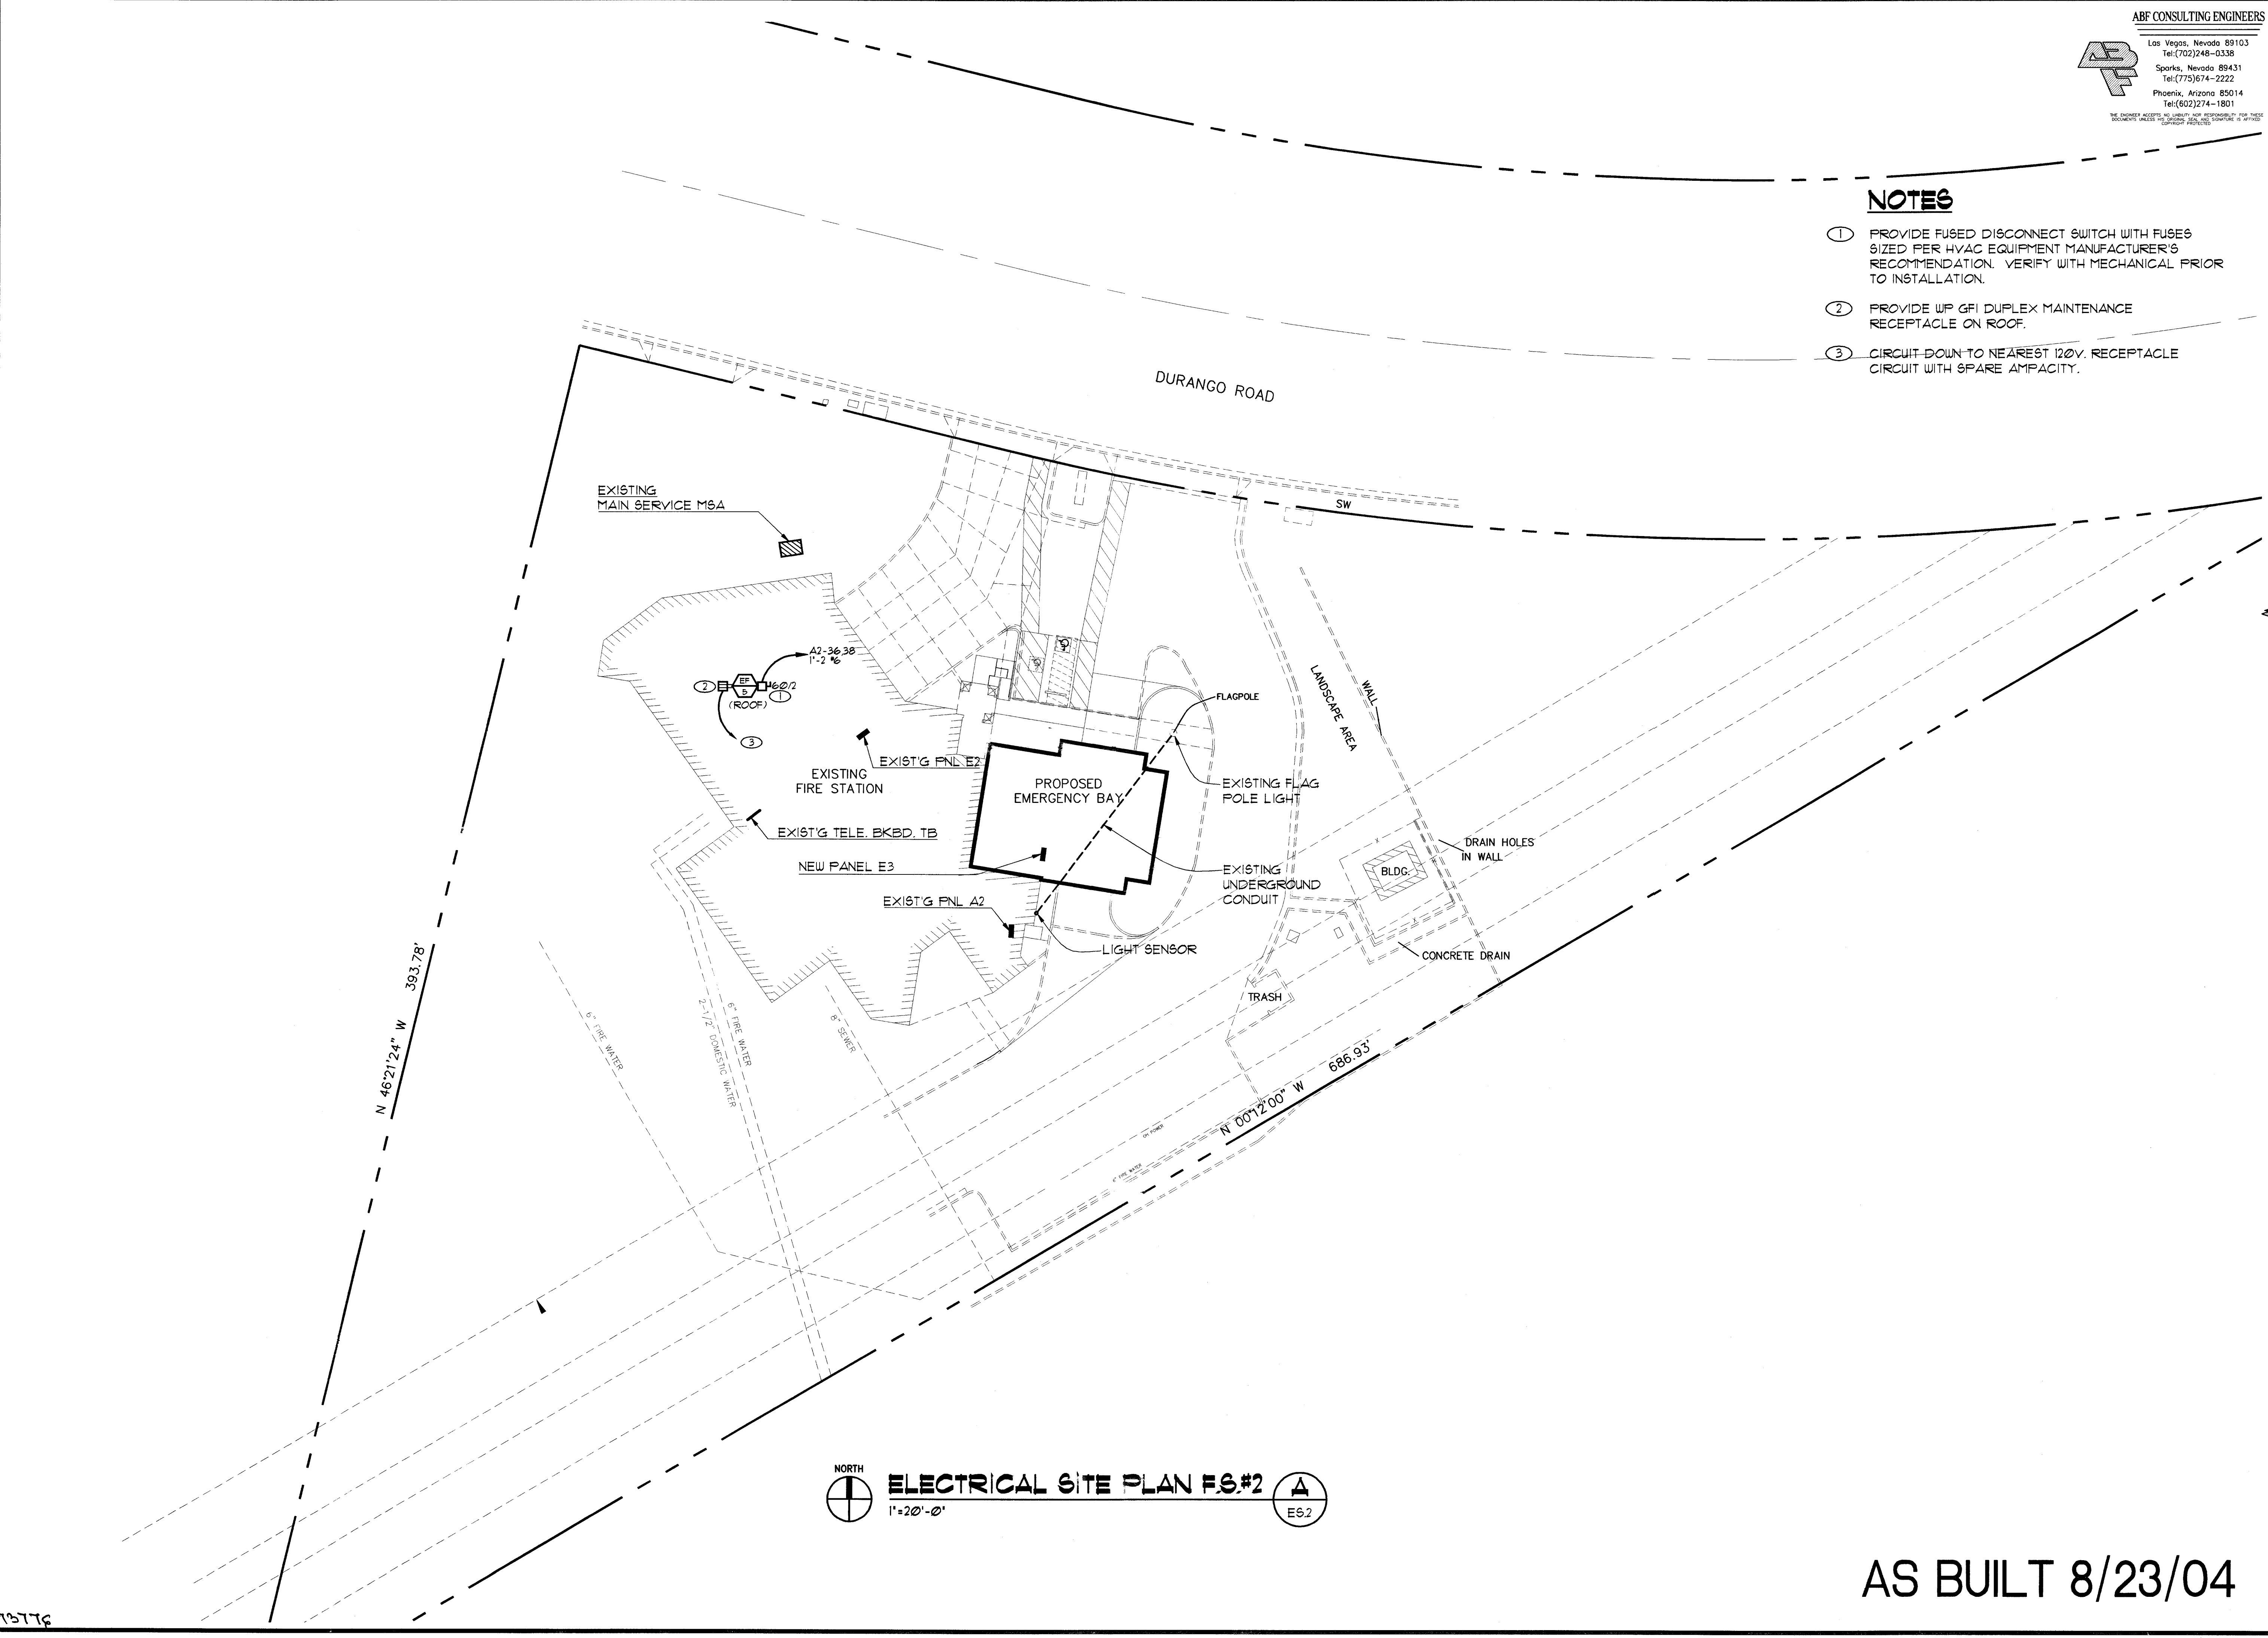

- NOTES**
- 1. PROVIDE FUSED DISCONNECT SWITCH WITH FUSES SIZED PER HVAC EQUIPMENT MANUFACTURER'S RECOMMENDATION. VERIFY WITH MECHANICAL PRIOR TO INSTALLATION.
 - 2. PROVIDE WP GFI DUPLEX MAINTENANCE RECEPTACLE ON ROOF.
 - 3. CIRCUIT DOWN TO NEAREST 120V. RECEPTACLE CIRCUIT WITH SPARE AMPACITY.

NORTH
ELECTRICAL SITE PLAN FS.#2
1"=20'-0"
ES.2

AS BUILT 8/23/04

ABF CONSULTING ENGINEERS
Las Vegas, Nevada 89103
Tel: (702) 248-0338
Sparks, Nevada 89431
Tel: (775) 674-2222
Phoenix, Arizona 85014
Tel: (602) 274-1801
THE ENGINEER ASSURES NO OTHERS ARE RESPONSIBLE FOR THESE DOCUMENTS UNLESS THE SIGNING SEAL AND SIGNATURE IS AFFIXED TO THE DOCUMENT.

WESTAR
ARCHITECTURAL GROUP, / NEVADA INC.
LAS VEGAS * PHOENIX
ARCHITECTURE * PLANNING * PROJECT MANAGEMENT
3900 MEADOWS LANE SUITE 220 LAS VEGAS, NEVADA 89107
TELEPHONE: (702) 878-0000 FAX: (702) 878-0430

ES.2

PROJECT NUMBER	DATE	REVISION DESCRIPTION	NUMBER
01883			
N.B.	09-13-01		

SCALE 1"=20'-0"

ES.2

SEAL
FINAL
STATE OF NEVADA
ROBERT E. ASH
ELECTRICAL
Exp. Dec. 31, 2004
No. 4371