

This document, including the ideas and designs it contains, is an instrument of professional services rendered by the Architect / Engineer. This document may not be used or copied in whole, or in part, for any purpose other than this specific project without the express written consent of Westar Architectural Group.

DATE	REVISION DESCRIPTION	NUMBER


PROJECT NUMBER	0633	DESIGNED BY	KSD	ISSUE DATE	09-18-01	SCALE	NONE
SHEET NUMBER							

PLUMBING FIXTURE SCHEDULE

MARK	FIXTURE	MANUFACTURER/ MODEL	ROUGH-IN SIZES				REMARKS
			CW	HW	SAN	VENT	
WC	WATER CLOSET (HANDICAPPED)	AMERICAN STANDARD MODEL NO. 2216.143	1/2'	---	3'	2'	VITREOUS CHINA WITH 18" HIGH ELONGATED BOWL, OLSONITE NO. 95 SOLID PLASTIC OPEN FRONT SEAT. TRIP HANDLE ON ACCESS SIDE 1.6 G.P.F.
LAV	LAVATORY (HANDICAPPED)	AMERICAN STANDARD MODEL NO. 0491.019	1/2'	1/2'	2'	1-1/2'	SELF-RIMMING, VITREOUS CHINA WITH MOEN NO. 8425 FAUCET WITH GRID STRAINER AND SYMONS #4-10 MECHANICAL MIXING VALVE. C.P. ANGLE STOP VALVES.
SHR	SHOWER (HANDICAPPED)	MOEN MODEL NO. 8345	3/4'	3/4'	---	---	PRESSURE BALANCED VALVE COMPLETE WITH HAND HELD SHOWERHEAD VACUUM BREAKER, HOSE CONNECTION, HOSE AND 24" SLIDE BAR, SHOWER DRAIN 60"x11" 220NC (2.5 GPM) FIAT MODEL 60MFTR (60"x32") PRECAST TERRAZZO FLOOR ENCLOSURE
RD	ROOF DRAIN	J.R. SMITH MODEL NO. 1010	---	---	---	---	CAST IRON BODY WITH FLASHING COLLAR GRAVEL STOP, CAST IRON DOME AND UNDERDECK CLAMP.
OD	OVERFLOW ROOF DRAIN	J.R. SMITH MODEL NO. 1010	---	---	---	---	CAST IRON BODY WITH FLASHING COLLAR GRAVEL STOP, CAST IRON DOME AND UNDERDECK CLAMP.
FD	FLOOR DRAIN	J.R. SMITH MODEL NO. 2005-A	---	---	2"	1-1/2'	CAST IRON BODY WITH FLASHING COLLAR NICKEL BRONZE ADJUSTABLE STRAINER HEAD.
HB-1	HOSE BIBB	WOODFORD MODEL NO. 24F	1/2'	---	---	---	NON-FREEZING WITH INTEGRAL VACUUM BREAKER, BACKFLOW PREVENTER, AND LOOSE TEE KEY. MOUNT AT 18" AFF.
TR-1	TRENCH DRAIN	ZURN MODEL NO. Z-812-G-E4	---	---	3'	---	12" WIDE FLOW-THRU PRE-SLOPED TRENCH DRAINAGE SYSTEM. BOTTOM OF TRENCH SHALL HAVE 1/8" PER FOOT SLOPE. PROVIDE W/ HEAVY DUTY DURA-COATED STEEL FRAME AT SURFACE. COMBINATION ANCHOR TABS/LEVELING DEVICES APPROPRIATE LOCATIONS AND EXTRA HEAVY-DUTY CAST IRON GRATE. INSTALL PER MFG'S INSTRUCTIONS AND COORDINATE W/ G.C.
S-1	SINK	ELKAY MODEL NO. SS-8248	1/2'	1/2'	2'	1-1/2'	TWO COMPARTMENT SINK WITH FISHER MODEL # 10014 SUPPLY LINE, FISHER MODEL # VIT30-1 ANGLE STOPS, FISHER MODEL # 2310-3 TEMPERATURE CONTROL VALVE WITH # 2200-000 NIPPLE/ LOCKNUT AND SLIP JOINT, FISHER #3010 SINGLE FOOT VALVE, FISHER MODEL #0158 ROTARY WASTE VALVE FOR EACH BASIN, FISHER MODEL # 2160 UTILITY SPRAY WITH WALL CONTROL VALVE AND SWIVEL HOSE ADAPTER WALL HOOD, SUPPLY LINES AND INTEGRAL VACUUM BREAKER AS REQUIRED.
MB	MOP BASIN	FIAT TSBC-1610	3/4'	3/4'	3'	2'	24"x24"x12" WITH DROP FRONT KOHLER MODEL K-8928 FAUCET WITH VACUUM BREAKER AND INTEGRAL STOPS.

PLUMBING LEGEND


ABBR.	SYMBOL	DESCRIPTION
S	—	SANITARY BELOW GRADE / FLOOR
S	—	SANITARY ABOVE GRADE / FLOOR
V	—	VENT
CW	—	COLD WATER
HW	—	HOT WATER
(E) CW	—	EXISTING COLD WATER
(E) HW	—	EXISTING HOT WATER
(E) S	—	EXISTING SANITARY PIPING
VTR	○	VENT THRU ROOF
WCO	—	WALL CLEANOUT
GCOFCO	⊖	GRADE / FLOOR CLEAN OUT
EWL, LWT	—	ENTERING, LEAVING WATER TEMPERATURE
	—	CAP ON END OF PIPE
POC	●	POINT OF CONNECTION, NEW TO EXISTING
DISC	○	DISCONNECT TO POINT INDICATED
EX		EXISTING TO REMAIN
RX		REMOVE EXISTING
RXS		REMOVE EXISTING AND SALVAGE FOR REUSE THIS CONT.
RS		REINSTALL SALVAGED EQUIPMENT
DN		DOWN
FM		FROM
CLG		CEILING
TYP		TYPICAL
MTD		MOUNTED
ACLG		ABOVE CEILING
GPM		GALLONS PER MINUTE
CU		COPPER
HP		HORSEPOWER
AD		ACCESS DOOR
W/		WITH
W/O		WITHOUT
REF		REFERENCE TO INFO. FOUND ON OTHER DRAWINGS
FTB		FINISH FLOOR TO BOTTOM
UG, UF		UNDERGROUND, UNDER FLOOR
AFF, BFF		ABOVE, BELOW FINISHED FLOOR
AFG, BFG		ABOVE, BELOW FINISHED GRADE
NIC		NOT IN CONTRACT

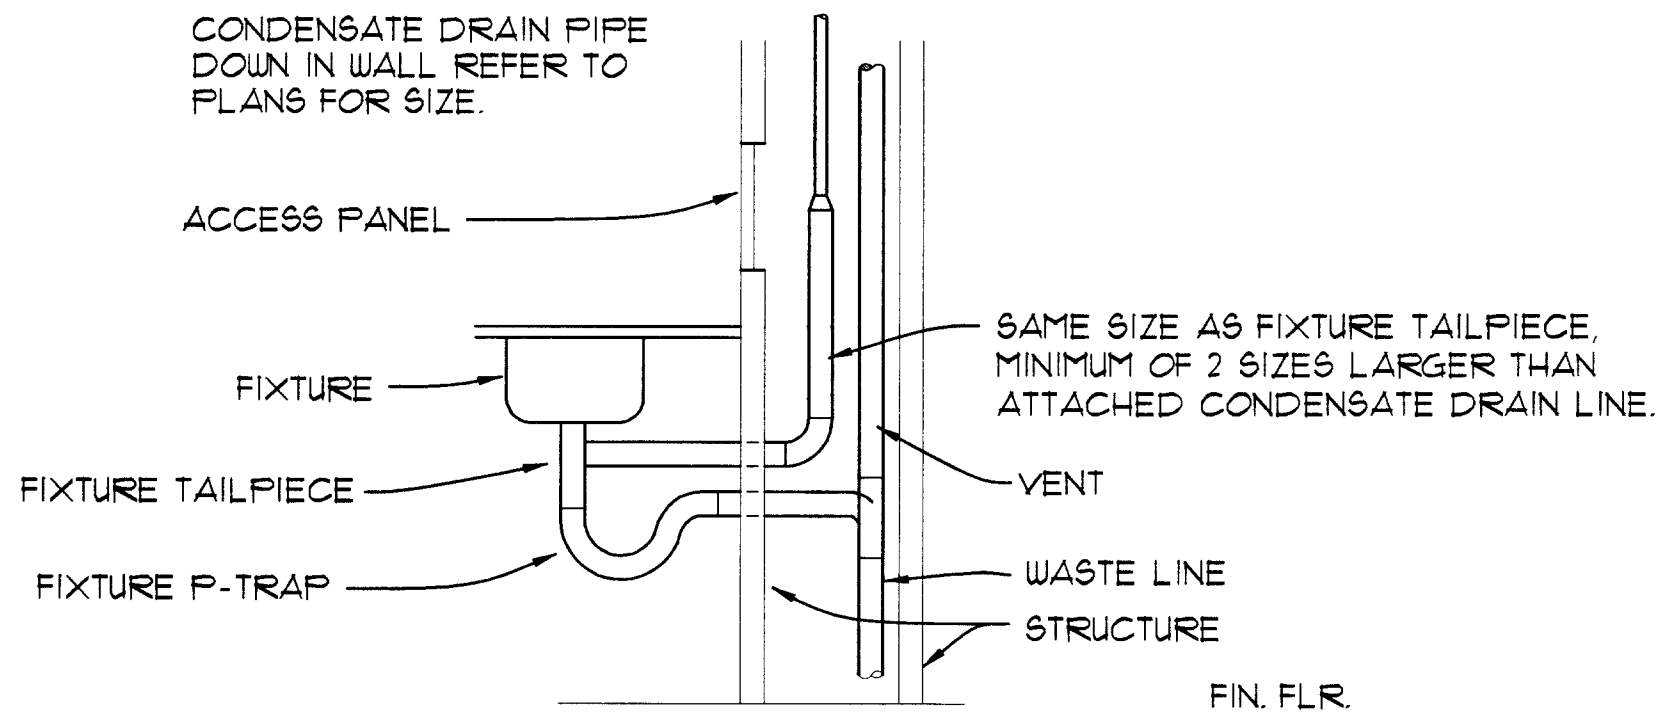

CONDENSATE DRAIN TAILPIECE CONNECTION DETAIL

NO SCALE

1
PD.1

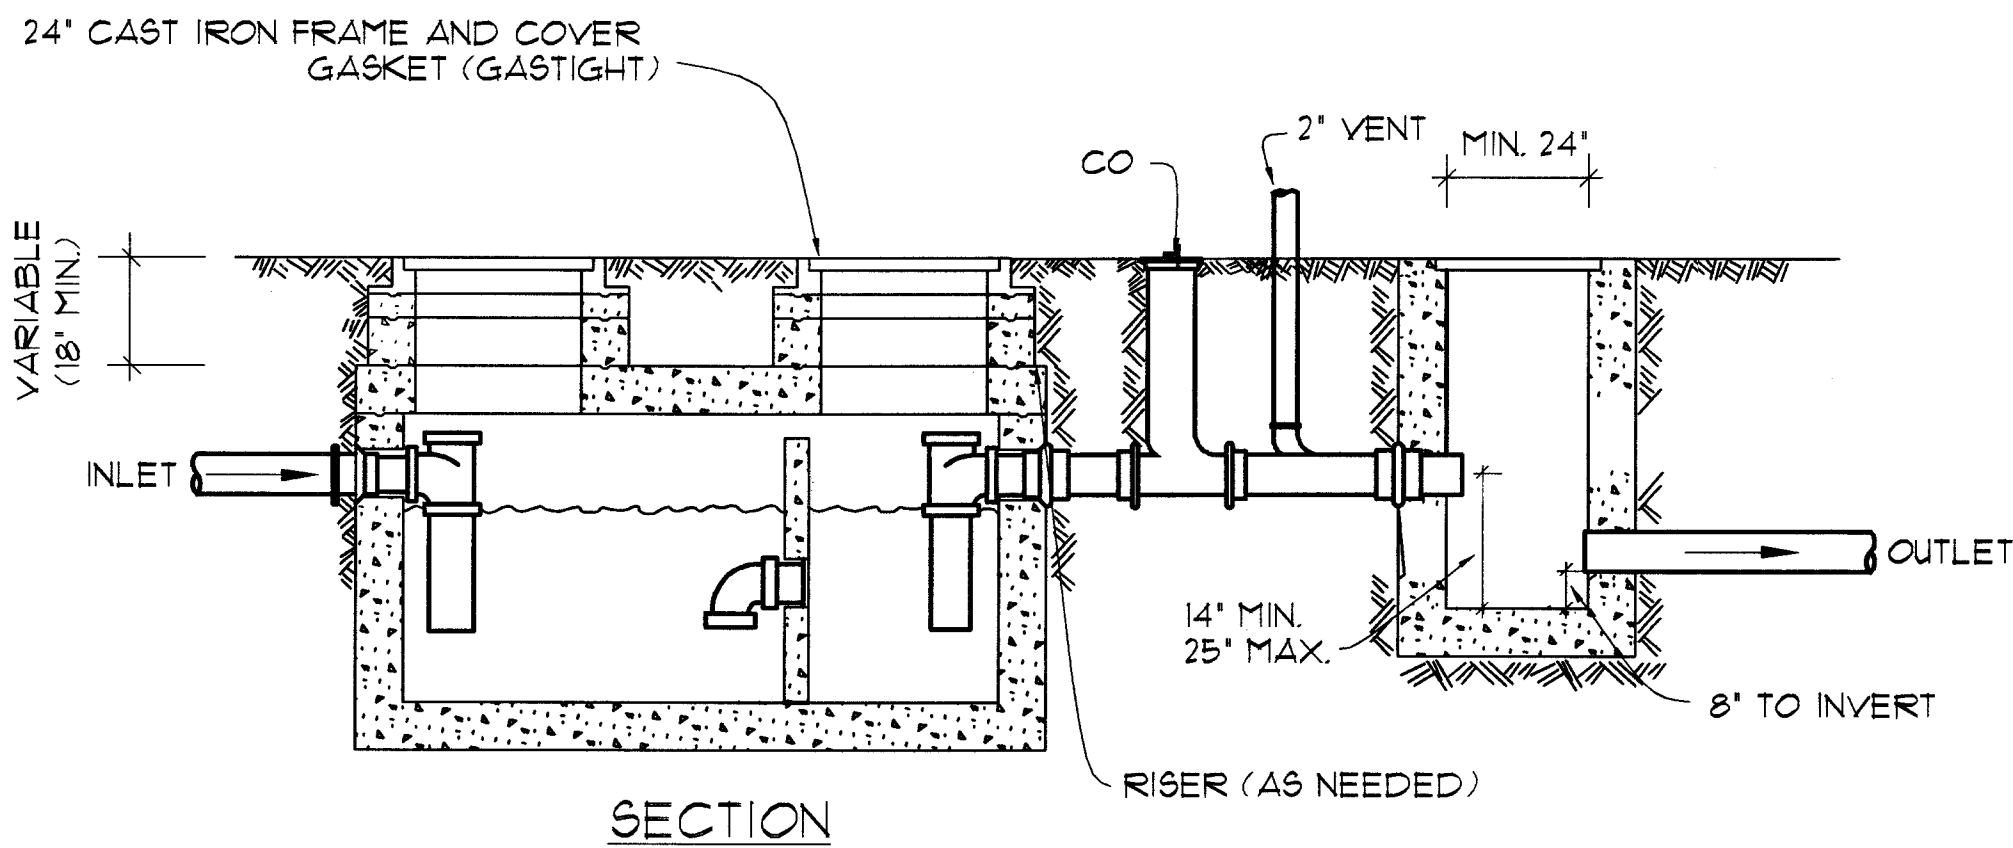

SAND/OIL INTERCEPTOR DETAIL

NO SCALE

2
PD.1

LIST OF DRAWINGS

PD.1	LEGEND SCHEDULES & DETAILS
PD.2	ISOMETRICS
PD.3	SPECIFICATION HIGHLIGHTS
PI.2	PLUMBING PLAN STATION 2
PI.2-A	OVERALL PLUMBING PLAN STATION 2
PI.7.9	PLUMBING PLAN STATION 7.9
PI.7.9-A	OVERALL PLUMBING PLAN STATION 7.9

AS BUILT 8/23/04